

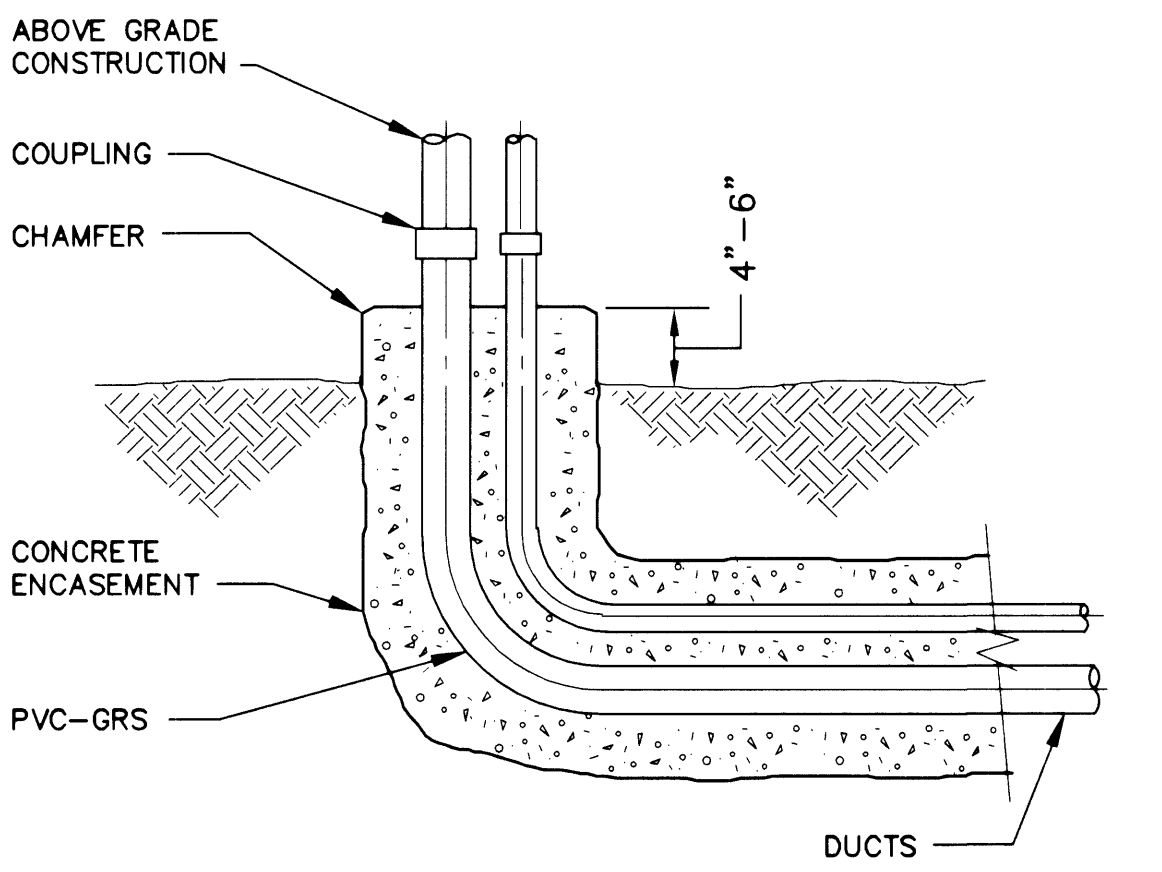


R:\01\20\Contract 19 - Demolition and Flood Control\C19-e200.dwg
12/04/98
392.90

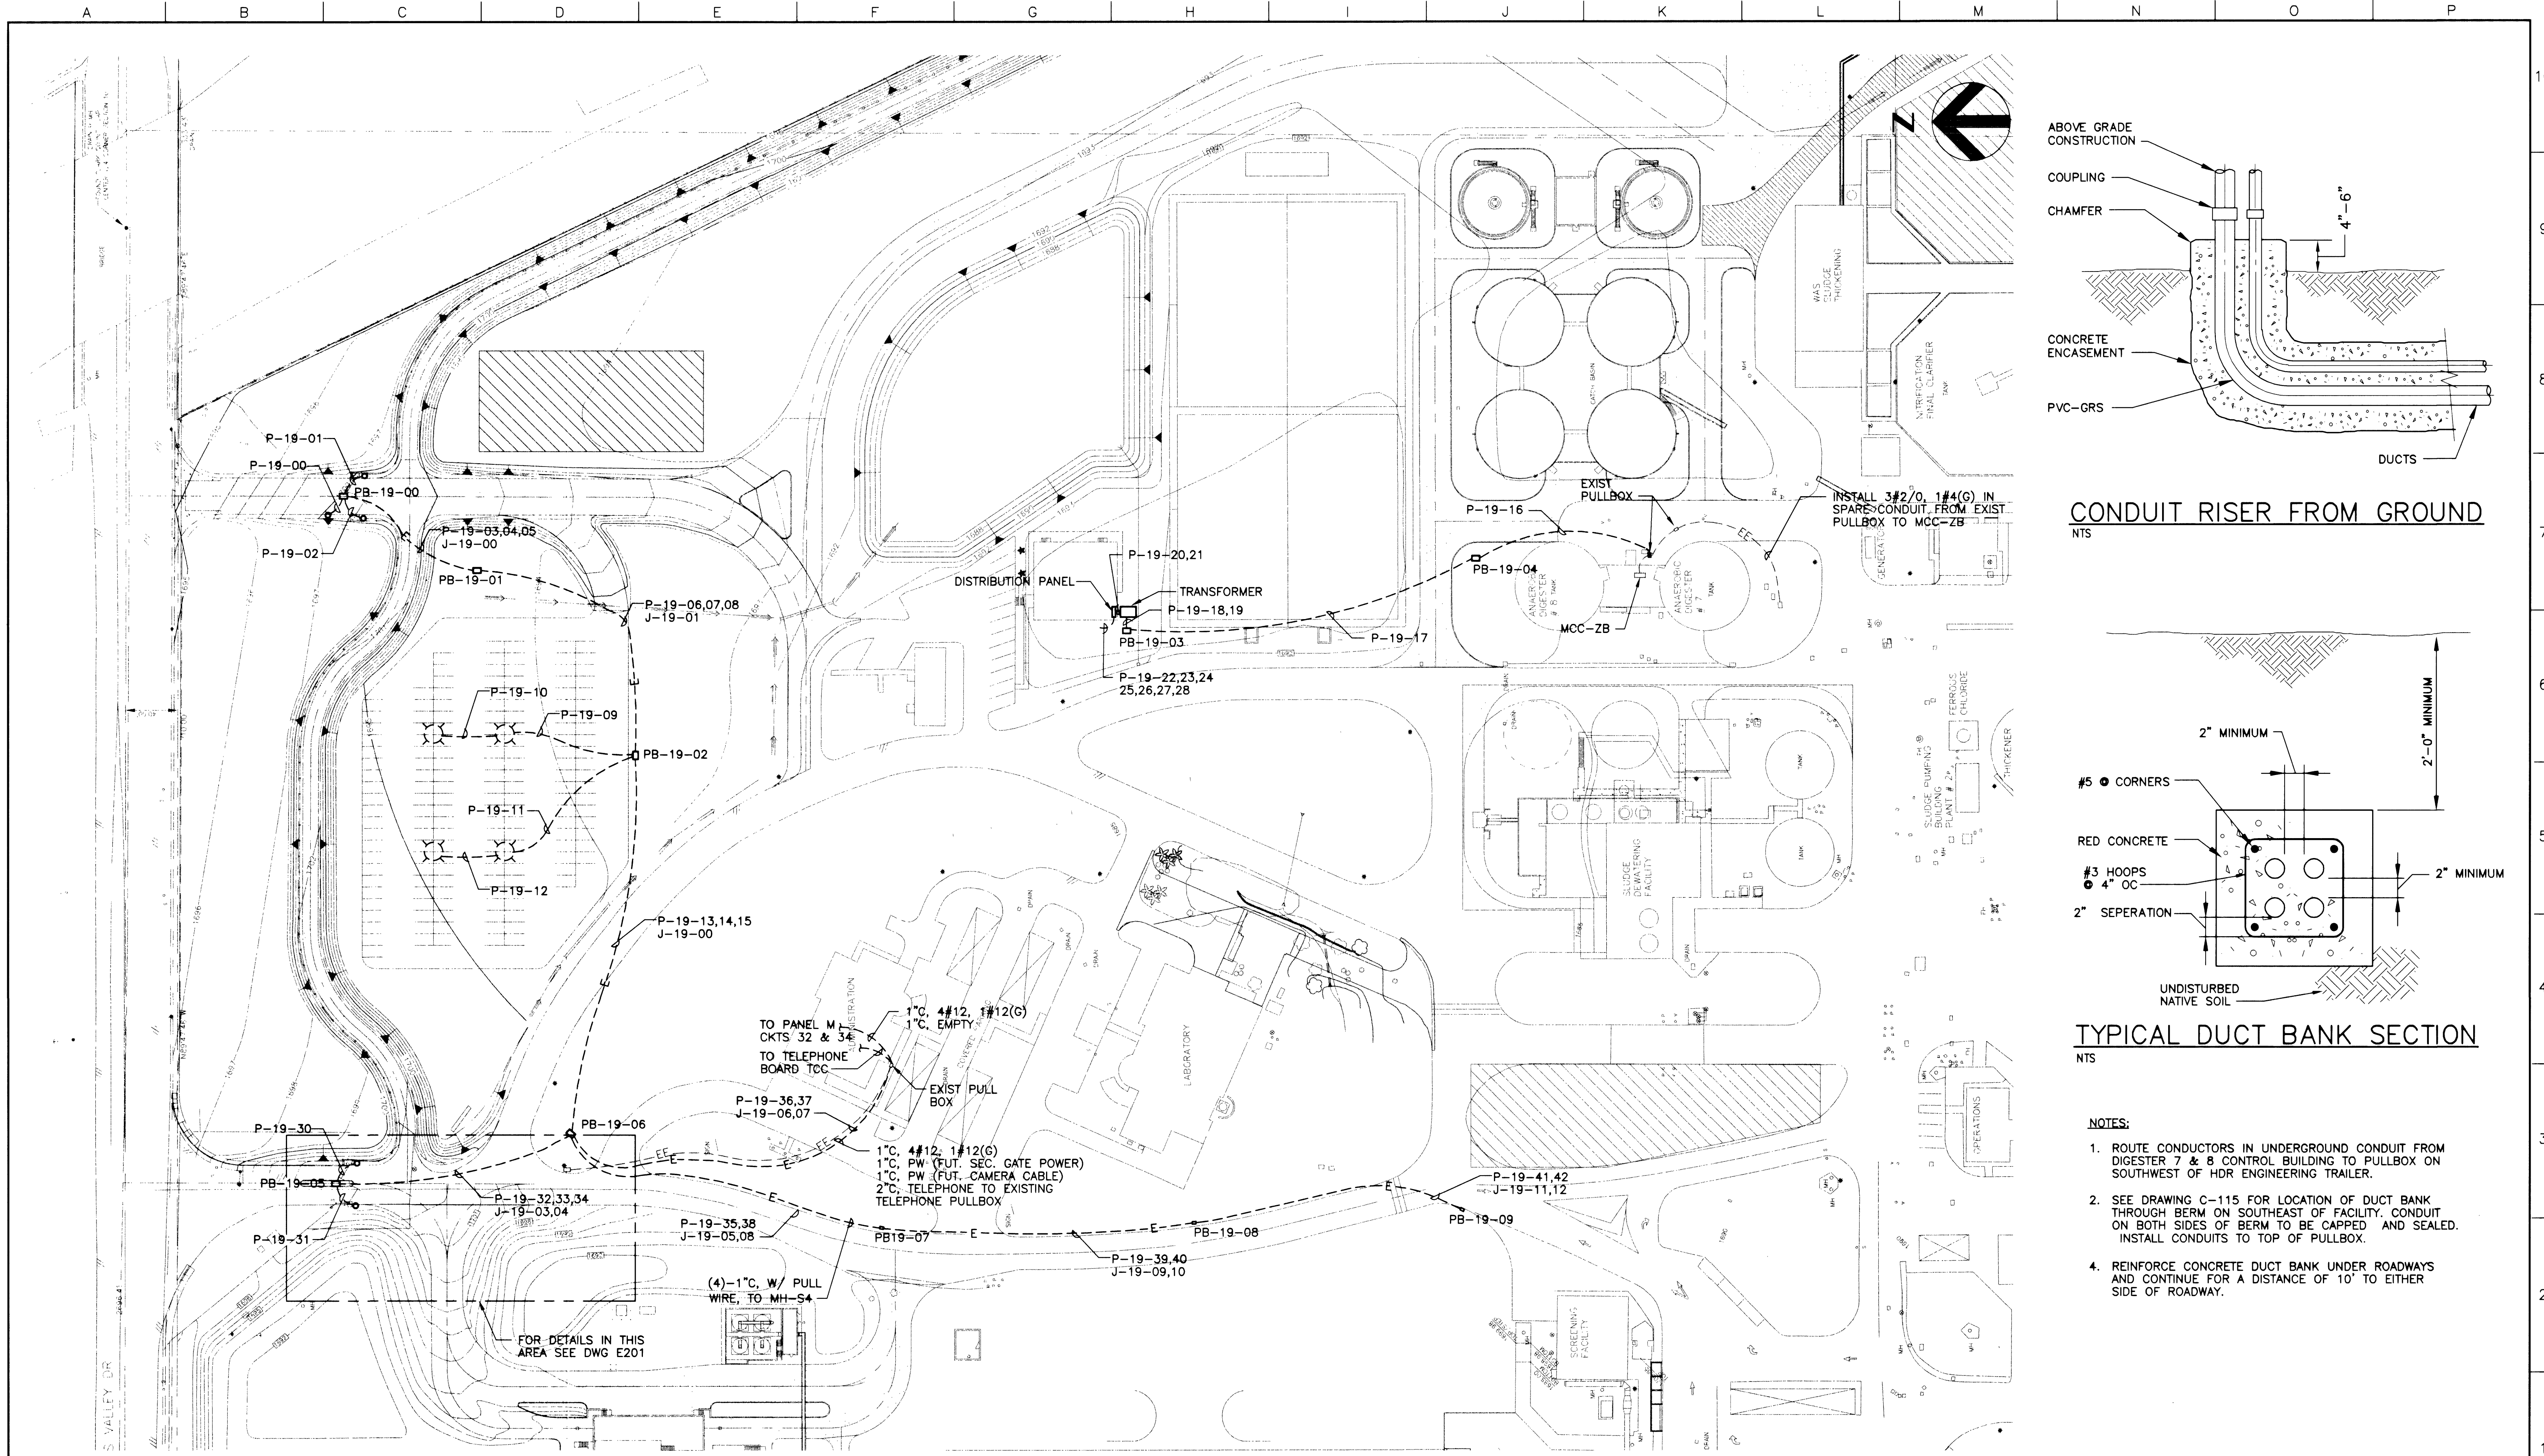

CONDUIT RISER FROM GROUND

NTS

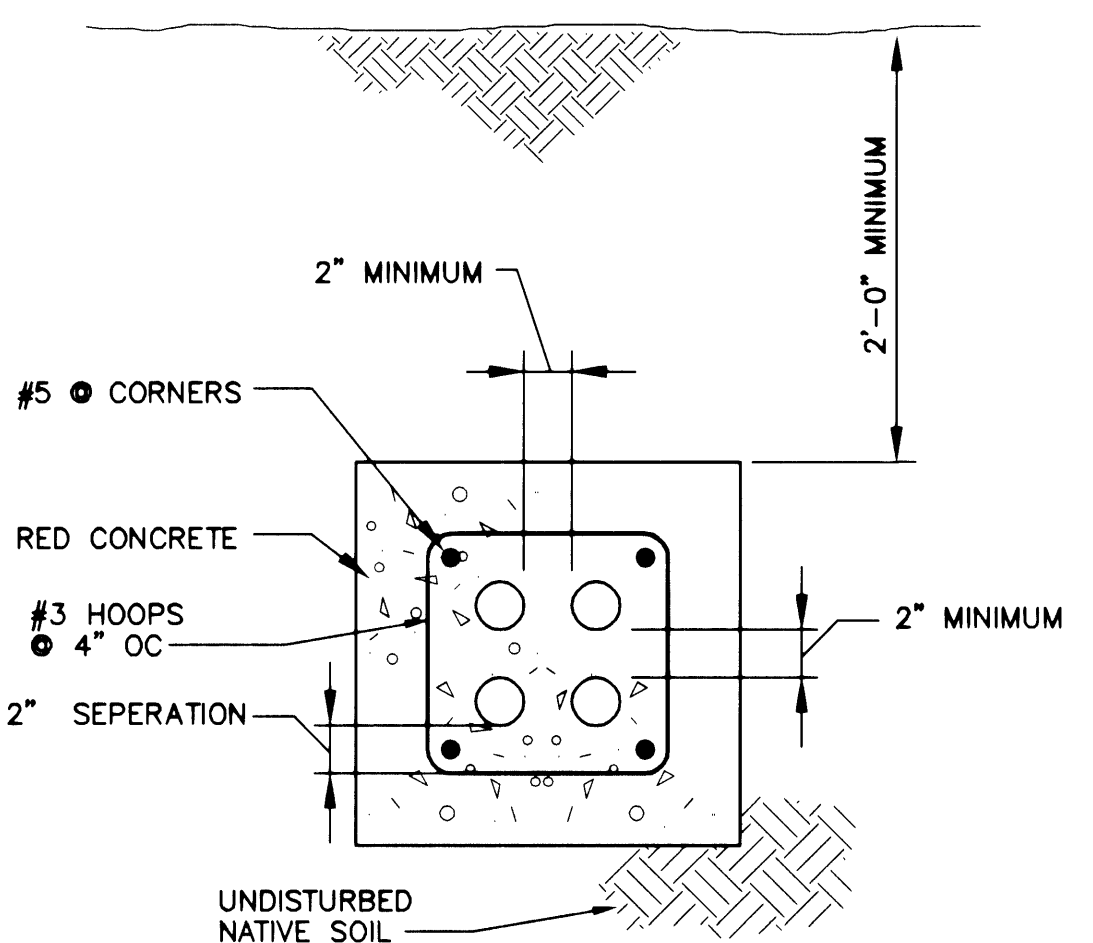

TYPICAL DUCT BANK SECTION

NTS

NOTES:

- ROUTE CONDUCTORS IN UNDERGROUND CONDUIT FROM DIGESTER 7 & 8 CONTROL BUILDING TO PULLBOX ON SOUTHWEST OF HDR ENGINEERING TRAILER.
- SEE DRAWING C-115 FOR LOCATION OF DUCT BANK THROUGH BERM ON SOUTHEAST OF FACILITY. CONDUIT ON BOTH SIDES OF BERM TO BE CAPPED AND SEALED. INSTALL CONDUITS TO TOP OF PULLBOX.
- REINFORCE CONCRETE DUCT BANK UNDER ROADWAYS AND CONTINUE FOR A DISTANCE OF 10' TO EITHER SIDE OF ROADWAY.

RECORD DRAWINGS		07/14/00	RJG	THK	DAP	JMC
ISSUED FOR BIDS		12/04/98	MCD	THK	DAP	JMC
Issue No.	Description	Date	Drawn	Chkd.	Prep. Engr.	Proj. Mgr.
392.90						

HDR
HDR Engineering, Inc.
770 E. Warm Springs Road
Suite 360
Las Vegas, NV 89119
702-938-6000

Project Manager	D. GRABER
Designed	T. REARICK
Designed	
Checked	
Drawn	M. DAVIS

City of Las Vegas
**Water Pollution Control Facility
Plant Expansion**
Contract 19 - Demolition\Flood Control

ELECTRICAL POWER PLAN				311.49	
Date	DECEMBER, 1998	Project No.	00120-154-141	Scale	1" = 60'
Drawing No.	E200	Sheet No.	42 of 45		