
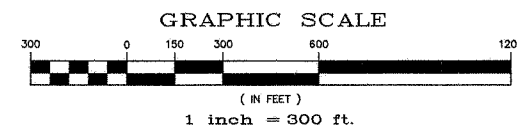
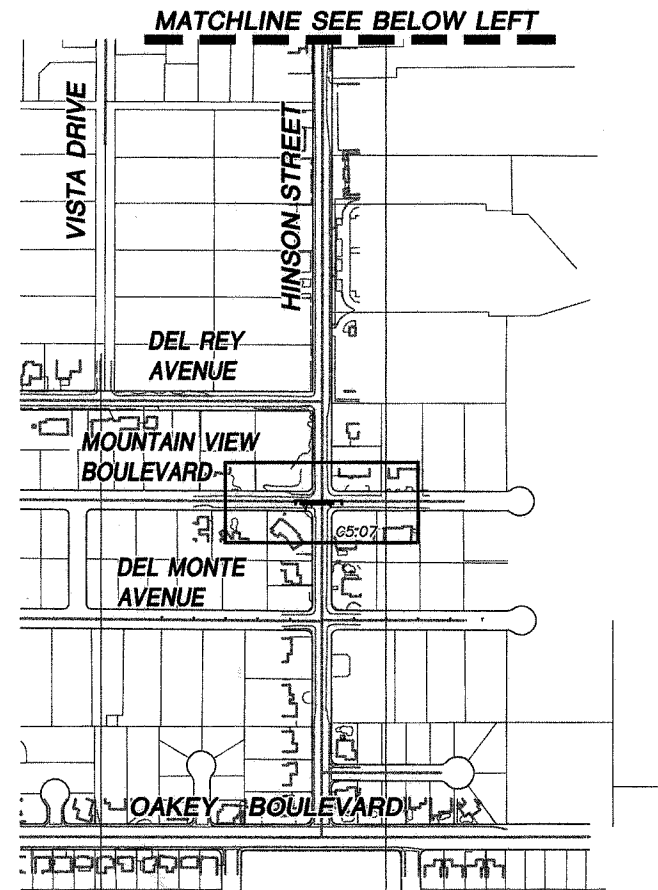


117828


X:\Transportation Design Nevada\Projects\511566\PHASE 1 Sheets\566-PH1 C5.00 *5-05-09 11:25am

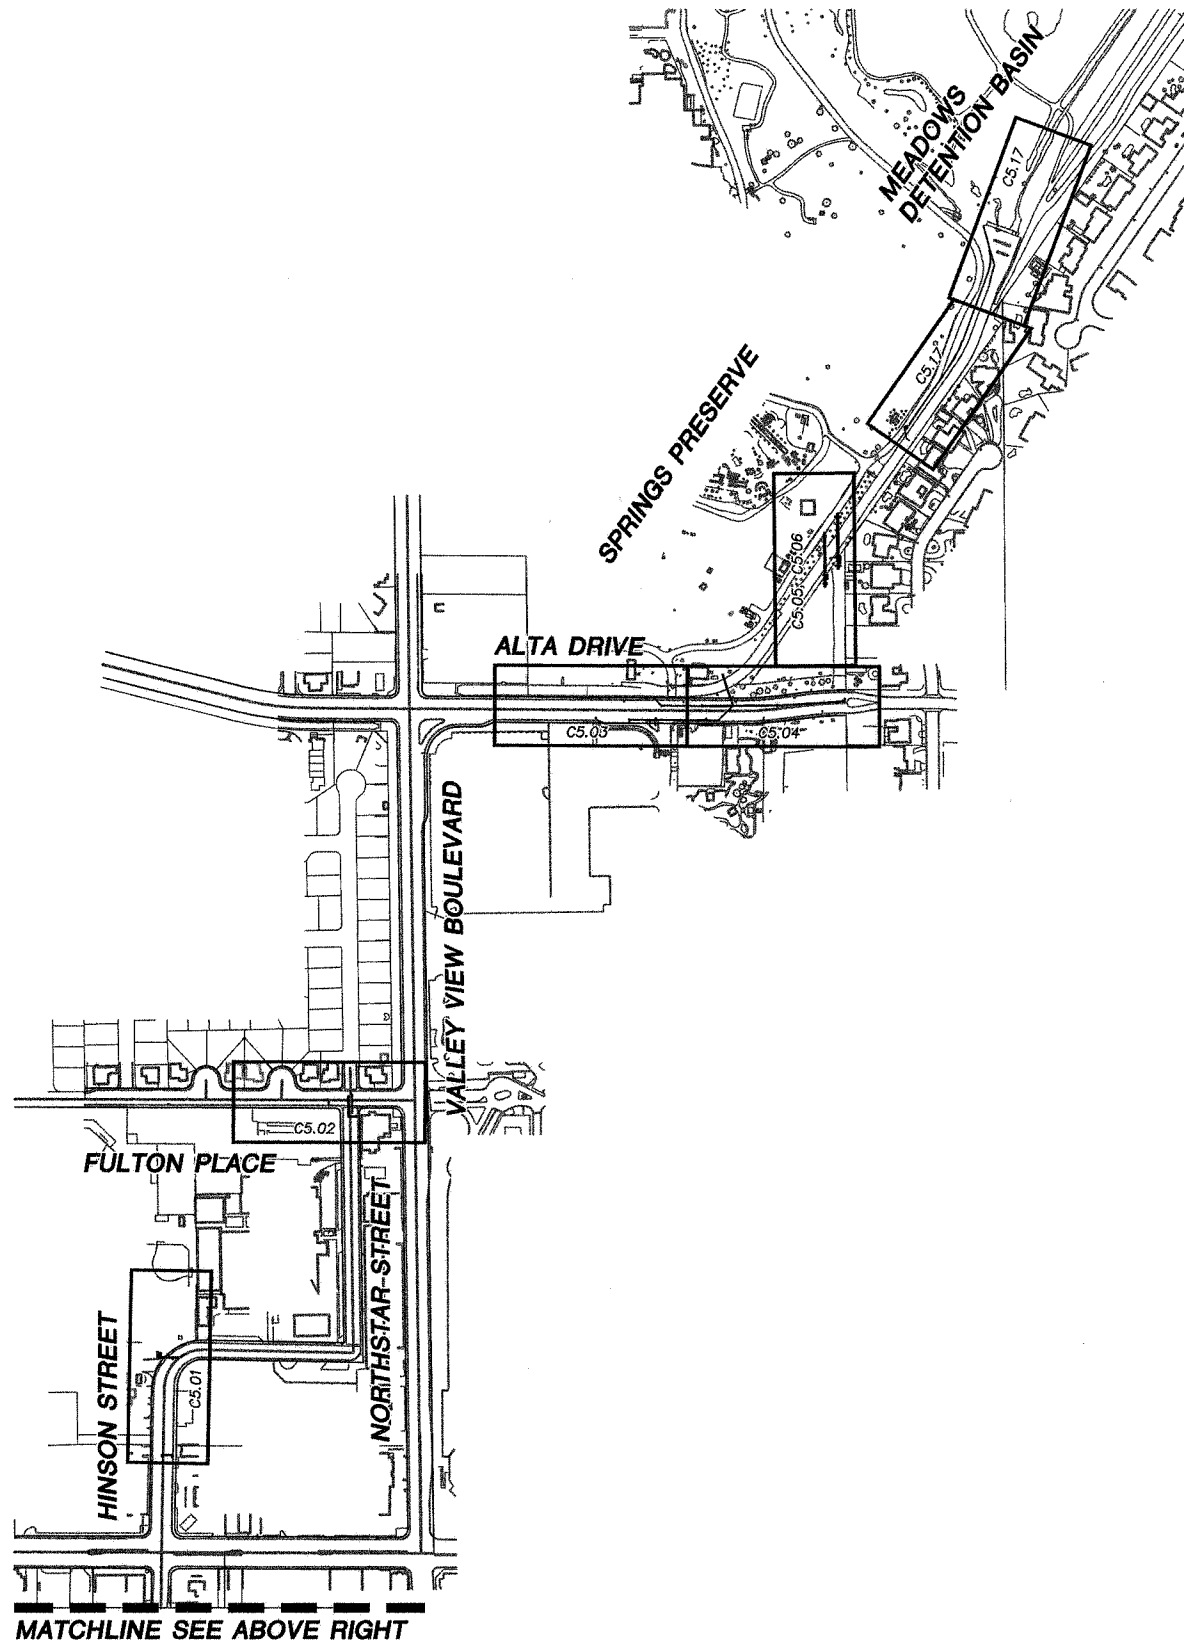

Call before you Dig
or
Call 811
1-800-227-2800
OR
CLARK COUNTY PUBLIC UTILITIES
1-702-455-7544

AVOID OVERHEAD POWER LINE
CONTACT. IT'S COSTLY.
Call before you
Overhead
1-702-227-2829
NORTH POWER DISTRIBUTION AND
SAFETY SERVICES DEPARTMENT

PBSJ
2270 Corporate Circle Drive
Suite 100
Henderson, Nevada 89074
Telephone: 702/263-7275
Fax: 702/263-7200
ENGINEERING • PLANNING • SURVEYING • CONSTRUCTION SERVICES

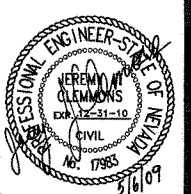

SHEET:

C5.00
105 of 139

DRAWING#
327V284

TITLE: OAKLEY/MEADOWS STORM DRAIN
PHASE 1
CHARLESTON BOULEVARD TO ALTA DRIVE

OVERALL UTILITY PLAN

DEPARTMENT OF PUBLIC WORKS
ENGINEERING DESIGN SECTION

CITY ENGINEER: CHERI EDELMAN, P.E.
CITY PROJECT ENGINEER: MICHAEL STURDIVANT, P.E.
PROJECT MANAGER: ANGELO SPATA, P.E.
DESIGN BY: SMG
CHECK BY: AAS
DRAWN BY: RPW
DATE: MAY 2009