


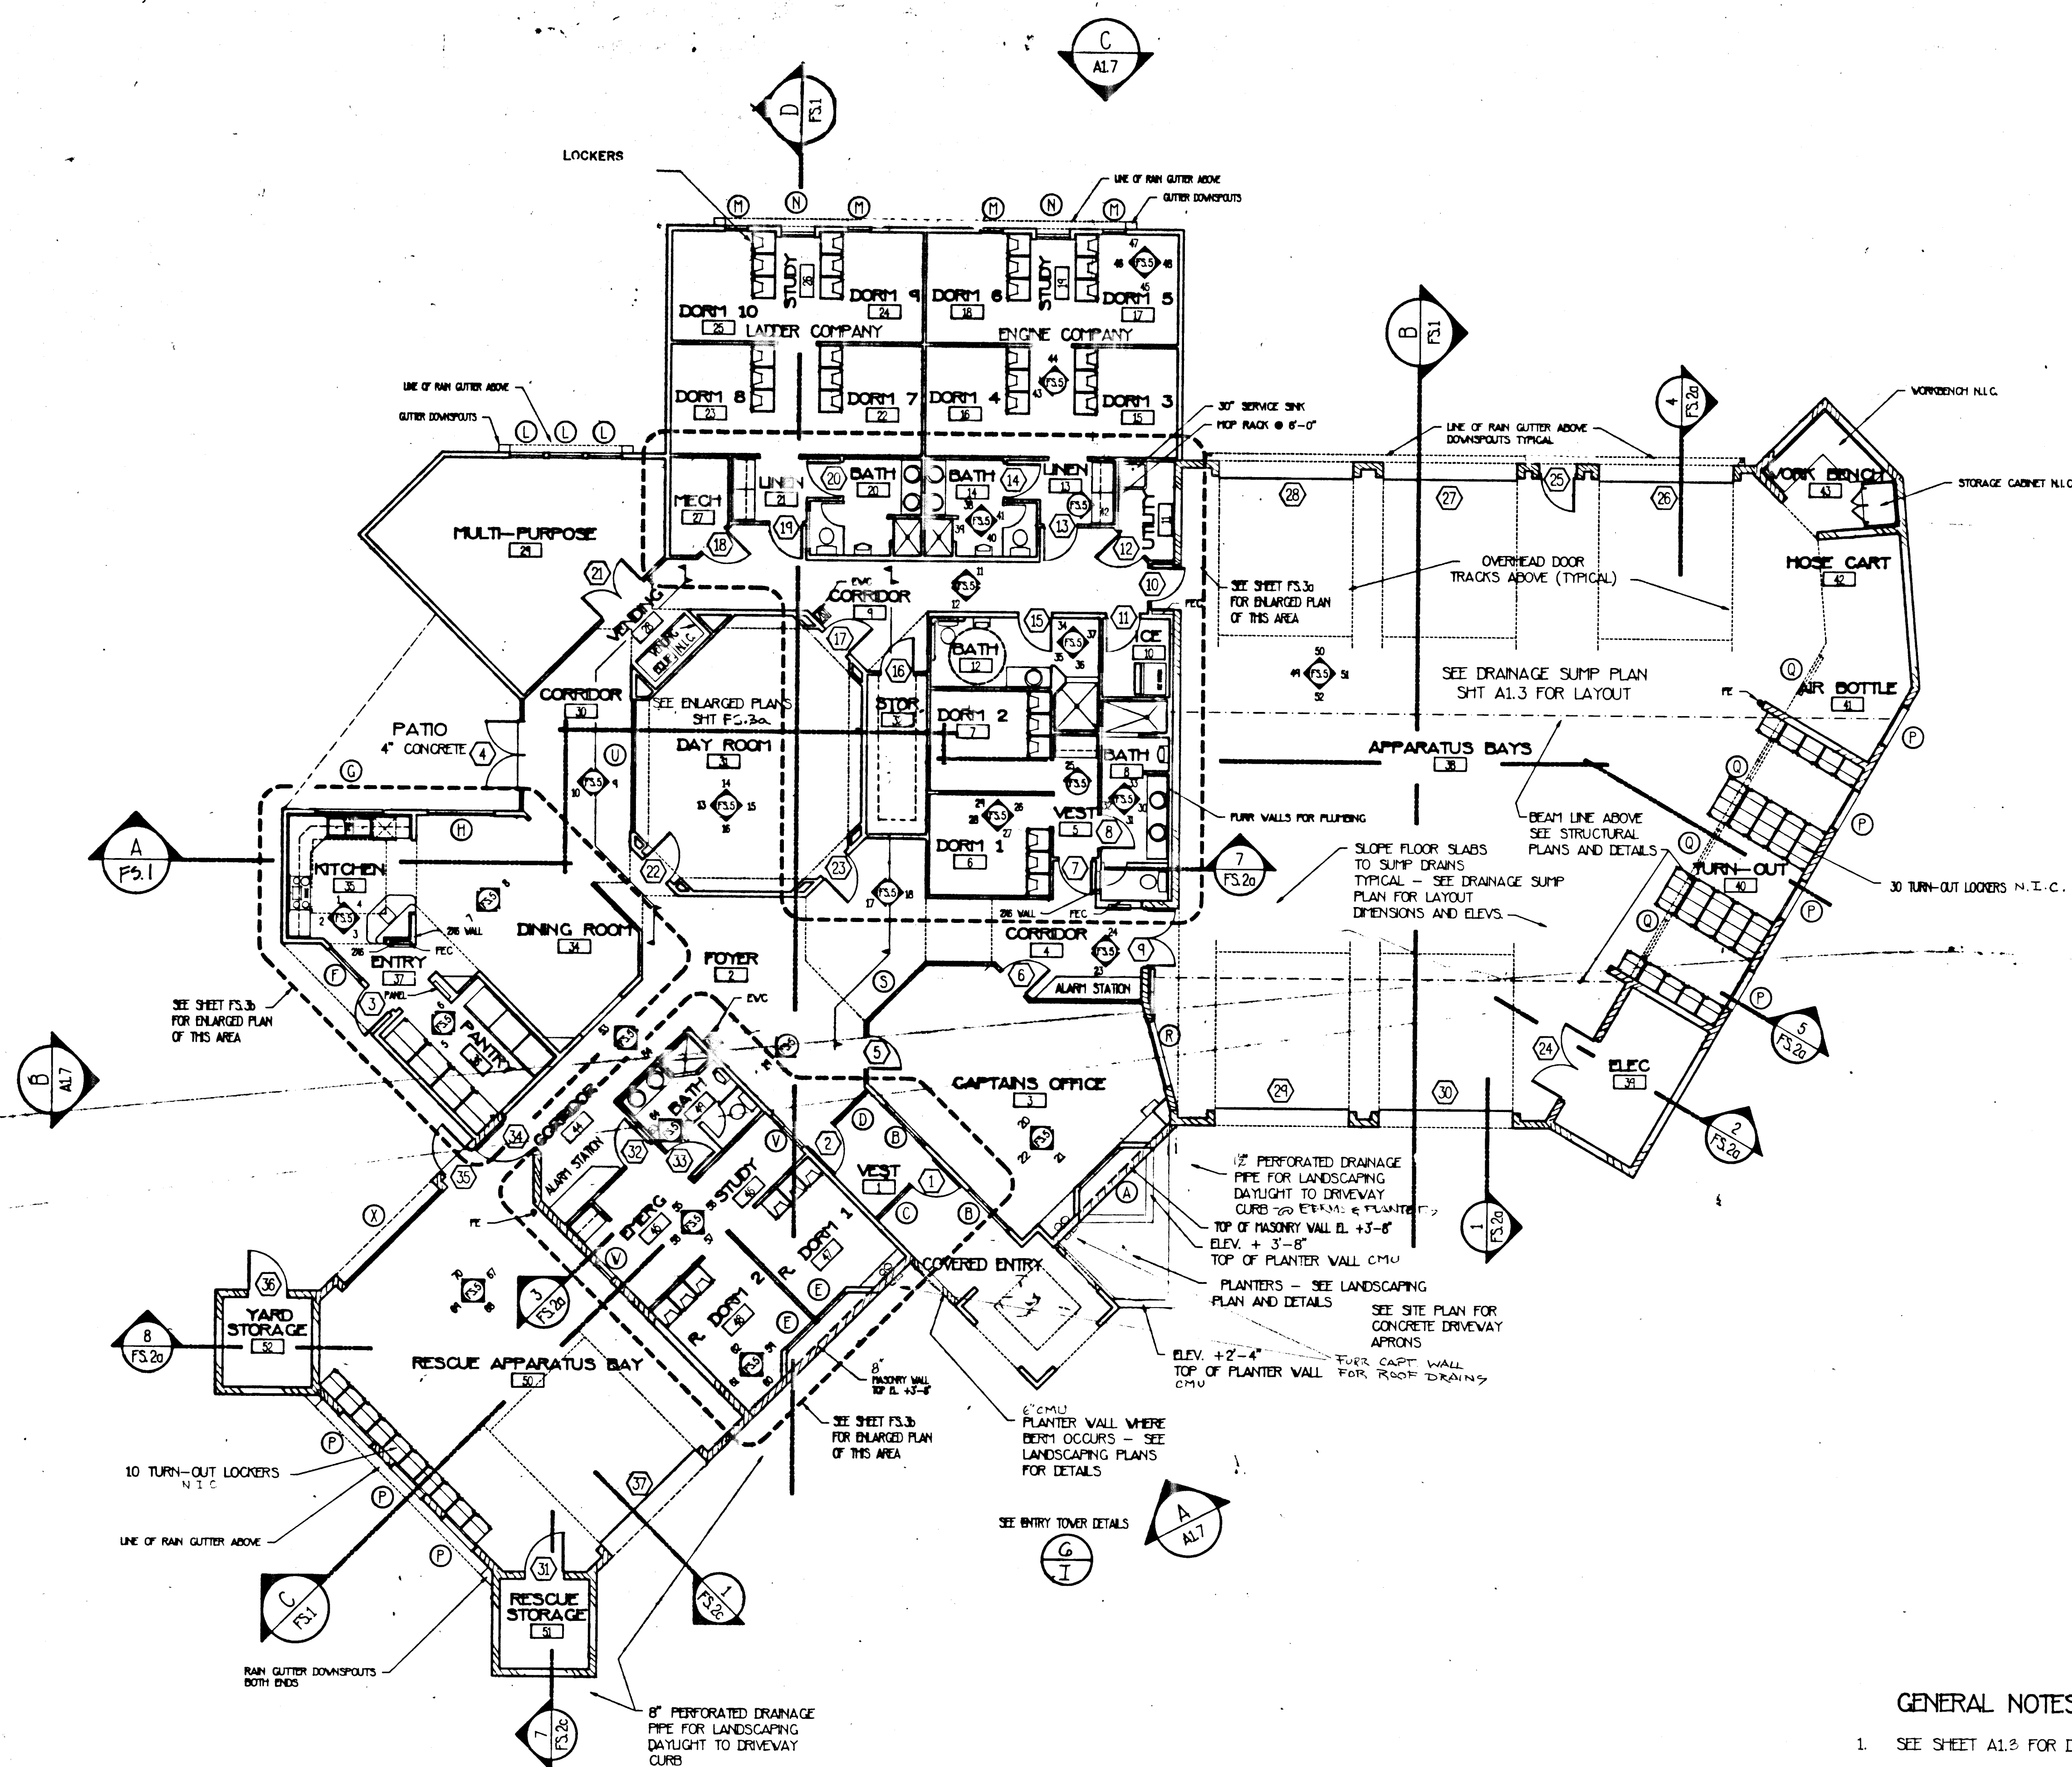

- GENERAL NOTES:
1. SEE SHEET A1.2 FOR DIMENSION PLAN
 2. CONTRACTOR TO REVIEW ALL DOCUMENTS, THE PROJECT SITE, AND CONDITIONS PRIOR TO BIDDING THE PROJECT. CONTRACTOR TO NOTIFY ARCHITECT OF ANY DISCREPANCIES
 3. DO NOT SCALE DRAWINGS. WRITTEN DIMENSIONS TAKE PRECEDENCE OVER SCALED DIMENSIONS.
 4. ALL INTERIOR STUD WALLS TO BE SOUND INSULATED.
 5. ALL EXTERIOR STUD WALLS TO BE 2 X 6 STUDS EXCEPT WHERE MASONRY WHERE SHOWN ON STRUCTURAL PLAN
 6. RAISE FLASH FLOOR & ALL DOWNSPUTS
 7. RAISED PLANTERS TO HAVE WATERPROOFING INDICATION & FLATTED DRAIN
 - 8.

A FLOOR PLAN - 3 BAY FIRE STATION
SCALE: 1/8" = 1'-0"

AS BUILT 12-15-89
RICHARDSON CONST. INC.

RECOMMENDED	DATE	REVISION	DATE
JOB 412-215			
DATE 12-15-89			
DRAWN BY			
CHECK			
LAS VEGAS FIRE DEPARTMENT CITY OF LAS VEGAS, NEVADA			
FLOOR PLAN - 3 BAY STATION			
SHEET 29			
A1.2			
OF 112 SHEETS			

AAAC WALLACE, INC.
Engineering/Architecture
1055 SOUTH HANSEN BLVD. LAS VEGAS, NEVADA 89101