

0:45:00/00:00:00 ST-PLANS Tue May 7 11:24:53 1996 DAN




DISK # DISK

58330

PLOTTED: PLOT DATE

STA 141+50
MATCH LINE

MATCH LINE
STA 153+00

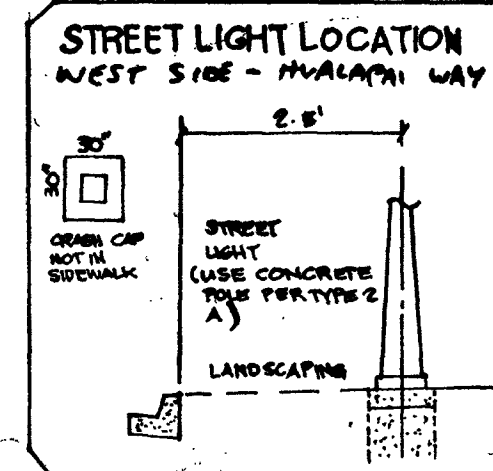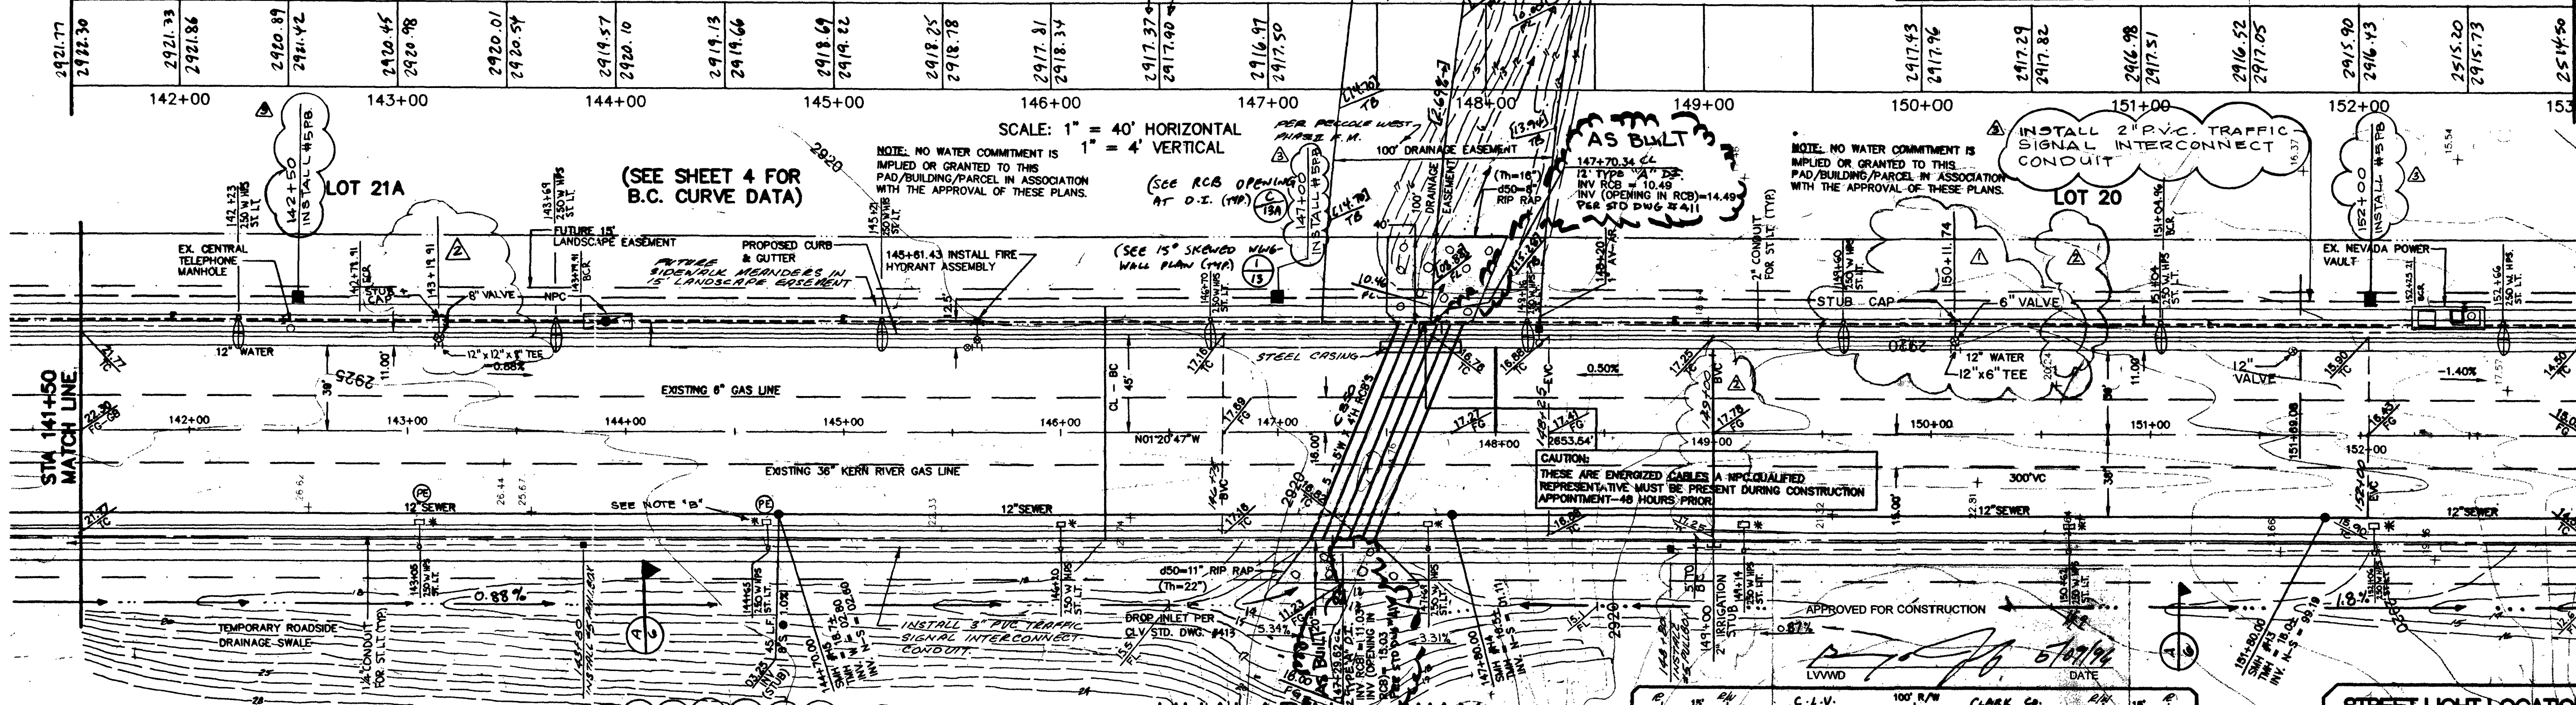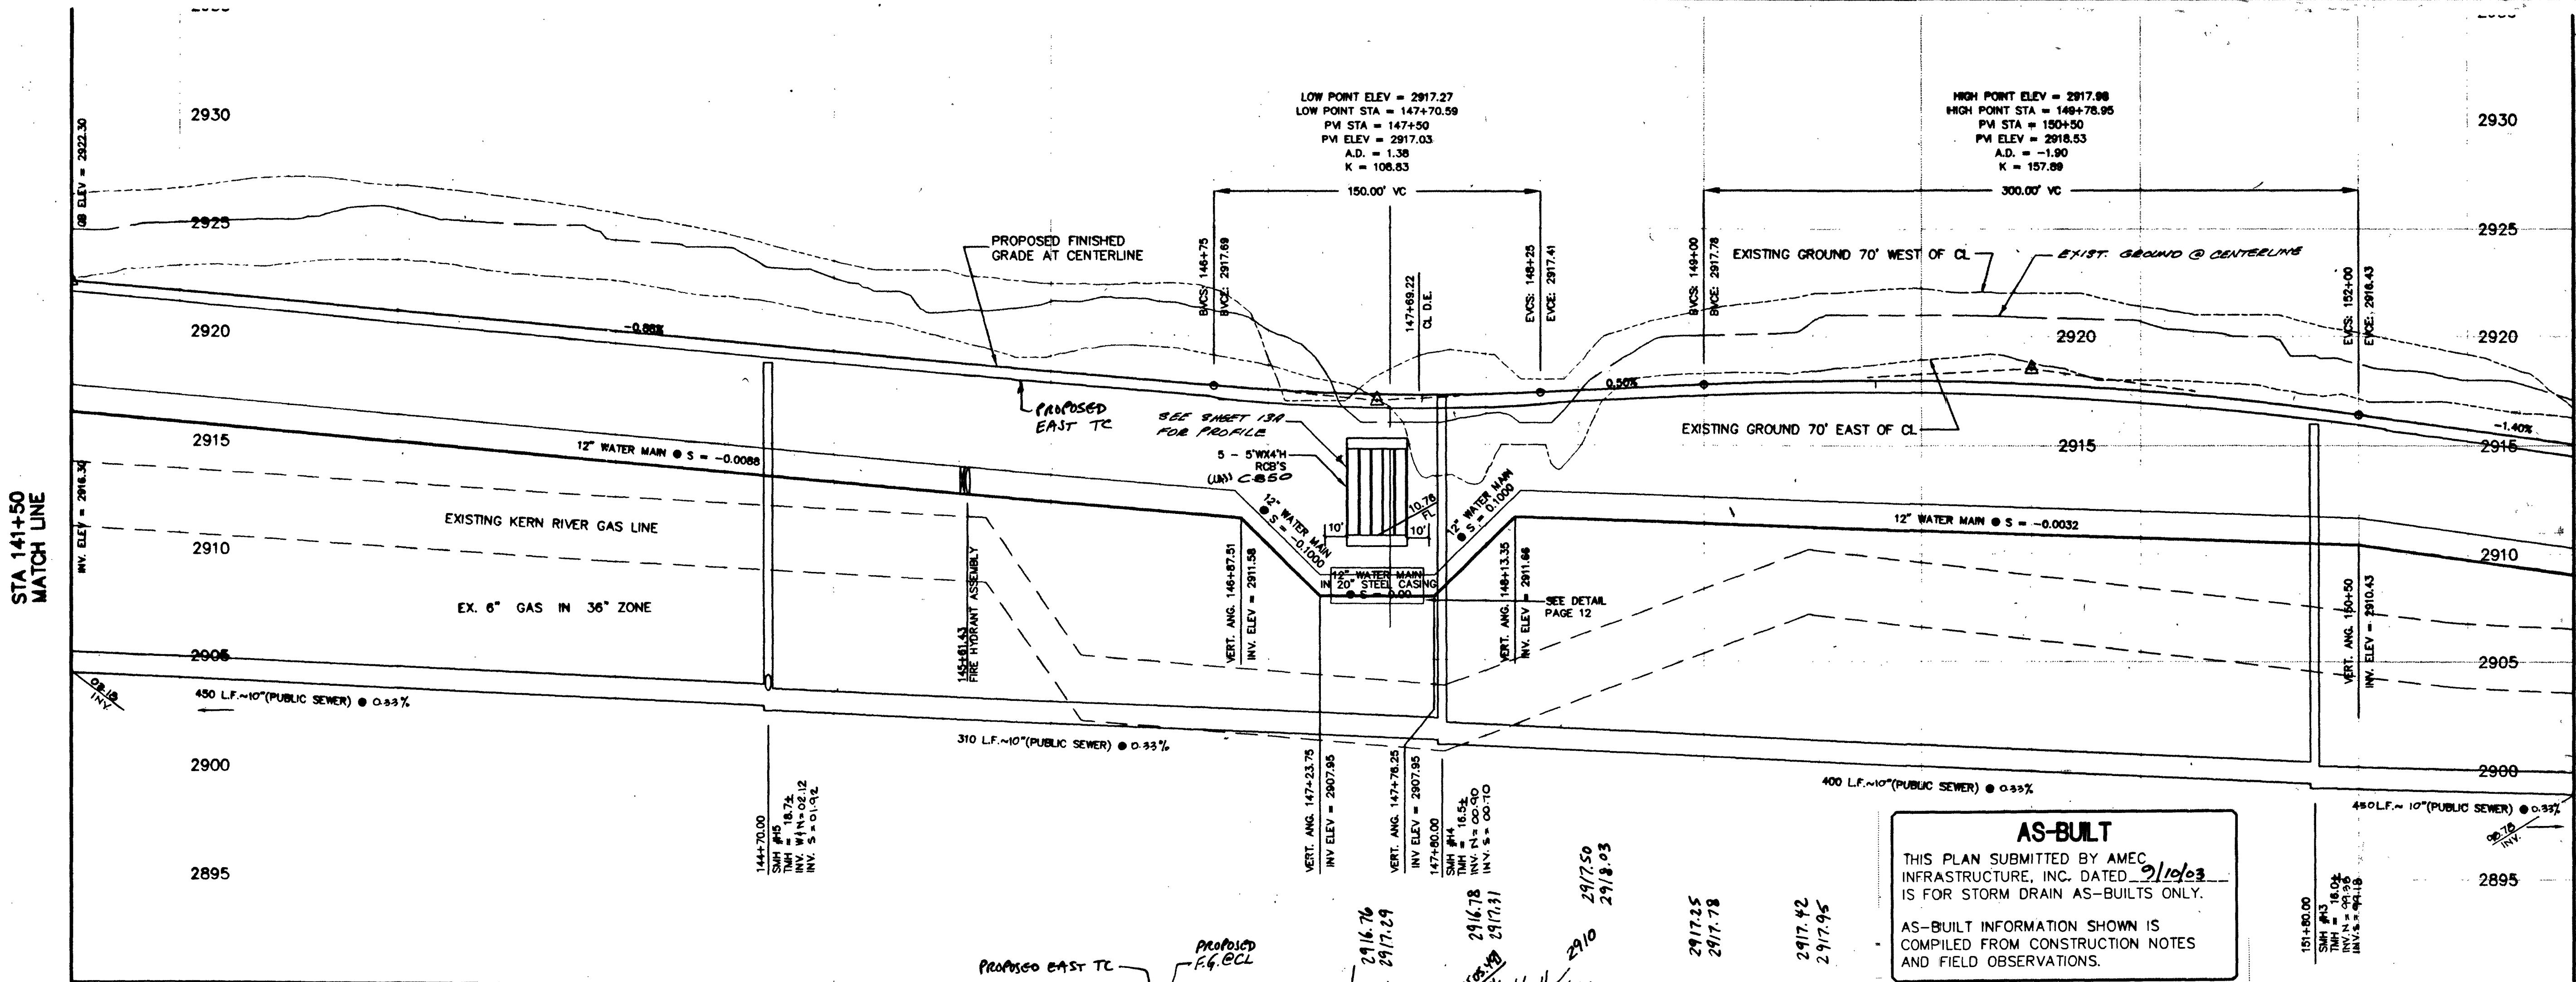

LEGEND



- 200 W HPS
- 250 W HPS
- 125 A OR 200 A PAD MOUNTS SERVICE
- PHOTO EYE
- 2" ST. LT. CONDUIT
- 3/4" PULLBOX

NOTE: ADD COVER DURING ROAD CONSTRUCTION BETWEEN STA. 156+00 AND STA. 157+00 IN ADDITION TO THE 3 FEET OF COVER PER KERN RIVER GAS CO. CONCERNS.

HUALAPAI WAY (PUBLIC)

I CERTIFY THAT THIS GRADING PLAN IS IN CONFORMANCE WITH THE APPROVED DRAINAGE STUDY AT THE CITY OF LAS VEGAS FOR THIS PROJECT.

Daniel L. Rubio, Jr. 5/9/96
DATE

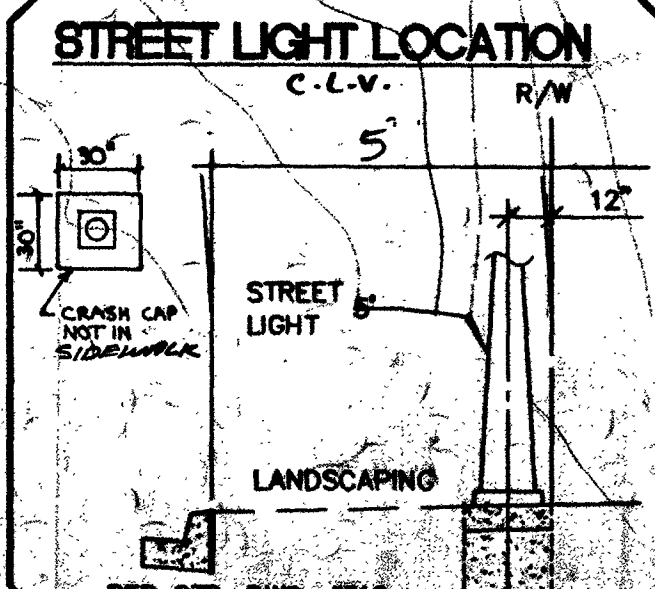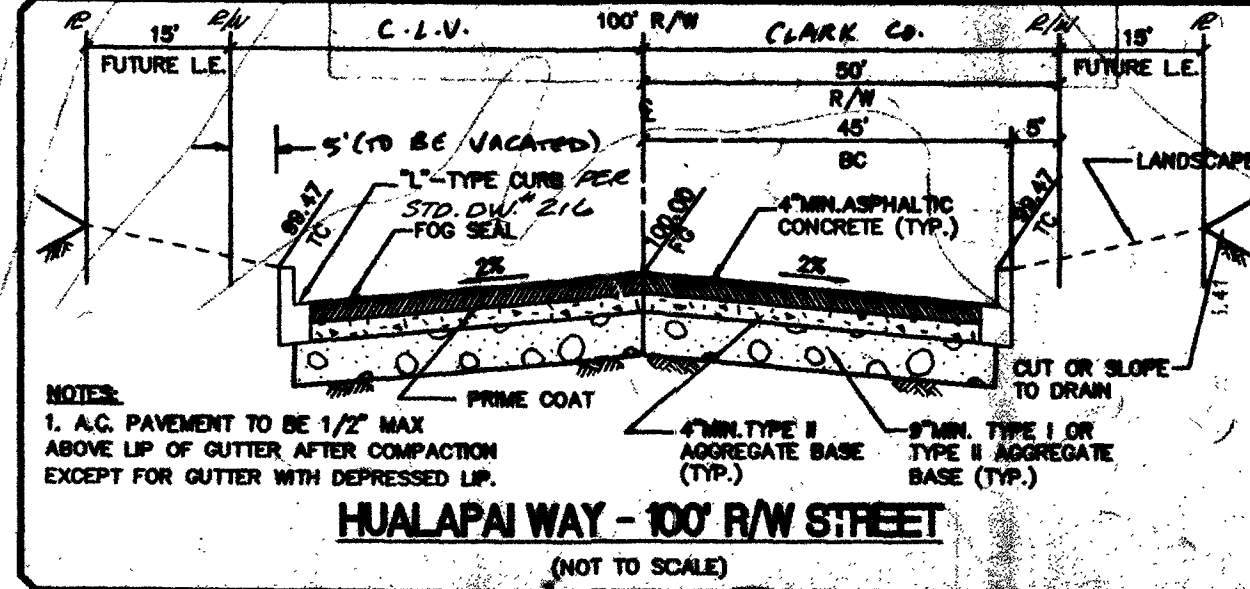

AS-BUILT
THIS PLAN SUBMITTED BY AMEC INFRASTRUCTURE, INC. DATED 3/10/03 IS FOR STORM DRAIN AS-BUILTS ONLY.
AS-BUILT INFORMATION SHOWN IS COMPILED FROM CONSTRUCTION NOTES AND FIELD OBSERVATIONS.

REVISION	DATE	DESCRIPTION
1	5/9/96	ISSUED FOR PERMITS
2	5/9/96	REVISED FOR PERMITS
3	5/9/96	REVISED FOR PERMITS
4	5/9/96	REVISED FOR PERMITS
5	5/9/96	REVISED FOR PERMITS
6	5/9/96	REVISED FOR PERMITS
7	5/9/96	REVISED FOR PERMITS
8	5/9/96	REVISED FOR PERMITS
9	5/9/96	REVISED FOR PERMITS
10	5/9/96	REVISED FOR PERMITS

DATE: 03/19/98
DRAWN BY: [Signature]
DESIGNED BY: [Signature]
CHECKED BY: [Signature]
JOB NO.: 0445.0025
SCALE: AS SHOWN

PENTACORE
CIVIL ENGINEERING - LAND SURVEYING - PLANNING
CONSTRUCTION MANAGEMENT - ADA CONSULTING
7833 WEST CHARLESTON BOULEVARD
LAS VEGAS, NEVADA 89102 (702)256-0115

PECCOLE NEVADA CORP.
PECCOLE WEST PHASE II
PLAN AND PROFILE HUALAPAI WAY
STA. 141+50 TO STA. 153+00

SHEET
7
OF 15