


CALL BEFORE YOU DIG
1-800-227-2600

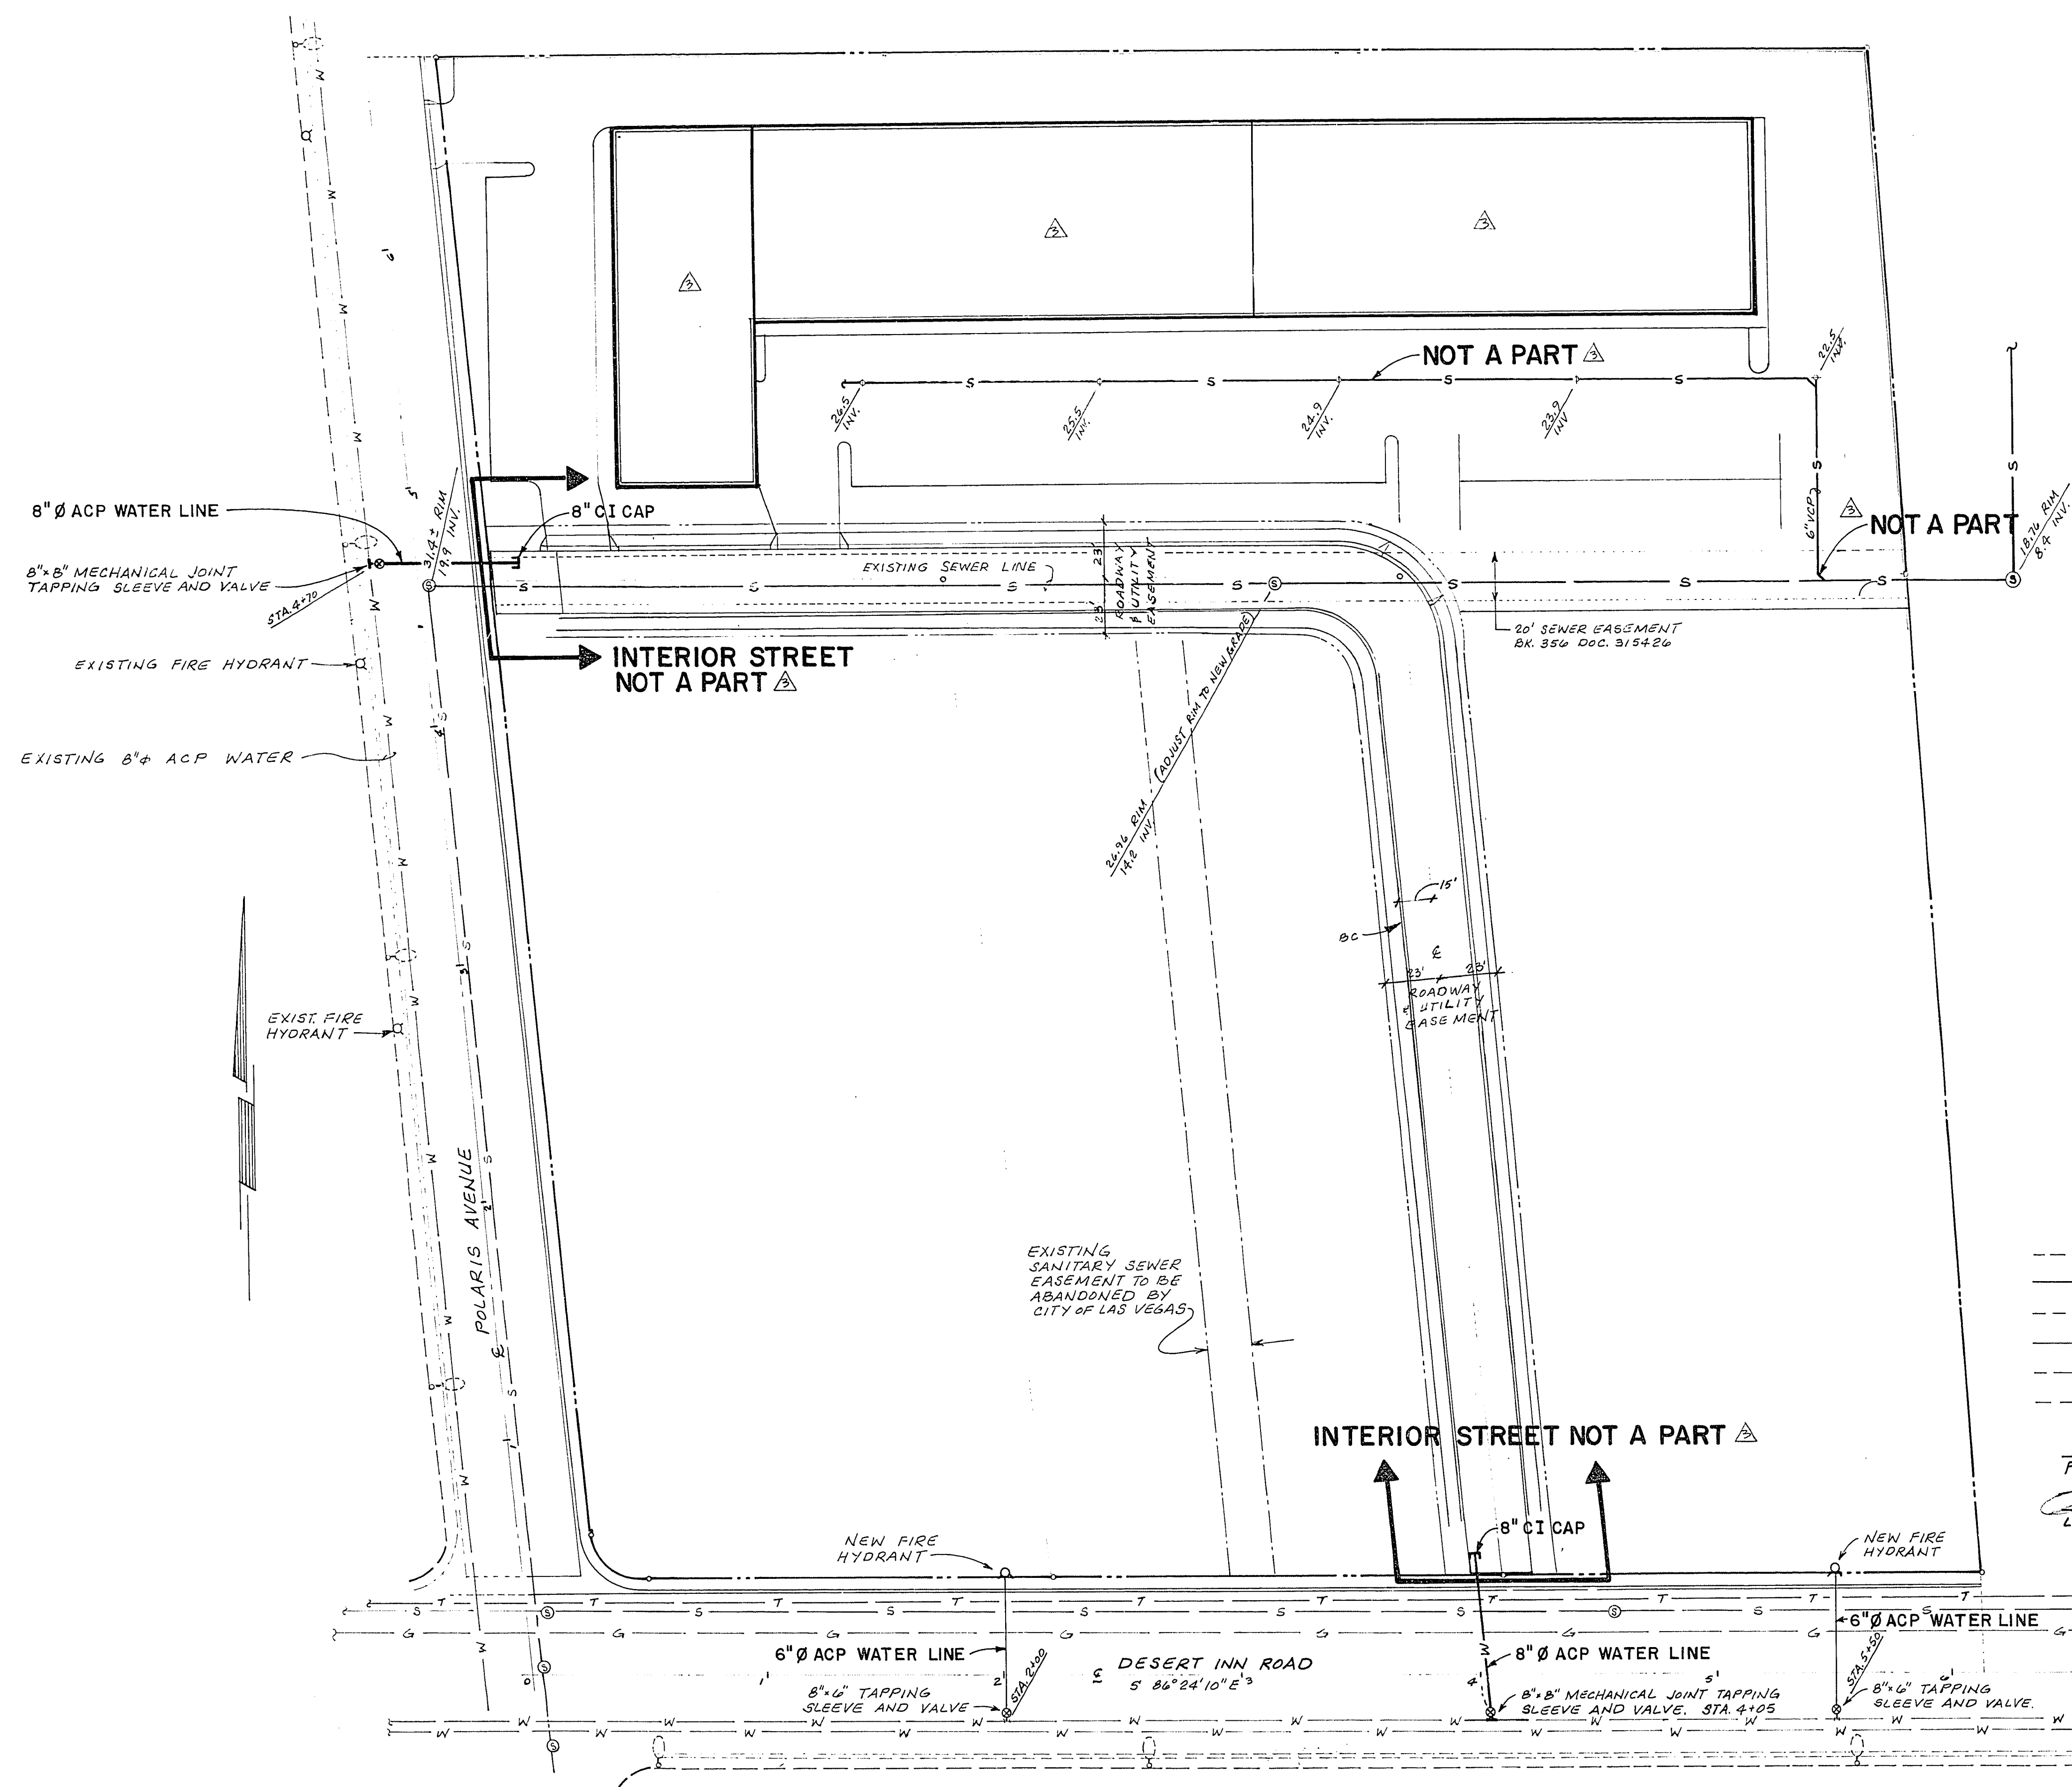

ESTIMATE OF QUANTITIES


6" C.I. CAP	2 EA.
8" ACP WATER MAIN	135 L.F.
8" 6" TAPPING SLEEVE AND VALVE	2 EA.
FIRE HYDRANTS	2 EA.
6" GATE VALVES	2 EA.
6" ACP WATER MAIN	140 L.F.
8" 6" TAPPING SLEEVE & VALVE	2 EA.

LEGEND

INV.	INVERT
⊗	GATE VALVE
⊙	SEWER MANHOLE
⊕	FIRE HYDRANT
⊘	CLEANOUT
---	EXISTING WATER MAIN
---	NEW WATER MAIN
---	EXISTING SEWER MAIN
---	NEW SEWER MAIN
---	EXISTING GAS MAIN
---	TELEPHONE LINES (EXISTING)

FIRE MARSHALL
LAND DEVELOPMENT
DATE 5-19-87

 APPROVED FOR CONSTRUCTION:
J. P. Walsh
L.V.V.W.D.
DATE 3/10/87



OWNER'S NAME DELETE ONSITE IMPROVEMENTS REV. PER ARCH. REV. DATED 26 MAY '87. REVISED PER CLV COMMENTS.		B.D.H. 11/1/86 B.D.H. 11/1/86 B.P. WALSH 11/1/87 B.P. WALSH 4/10/87		Reference Information and Notes:		Designed B.P. WALSH Drawn B.P. WALSH Checked B.P. WALSH Date FEBRUARY 1987		LEWEX, INC. Kennedy/Jenks/Chilton Las Vegas, Nevada		POLARIS BUSINESS CENTER MASTER UTILITY PLAN CITY OF LAS VEGAS NEVADA 107-V1474		Scale 1" = 40' Job No. B79007.00-C-00 Sheet 87003 of 3 of 5	
Revised Description Submit Date													

4-3-40