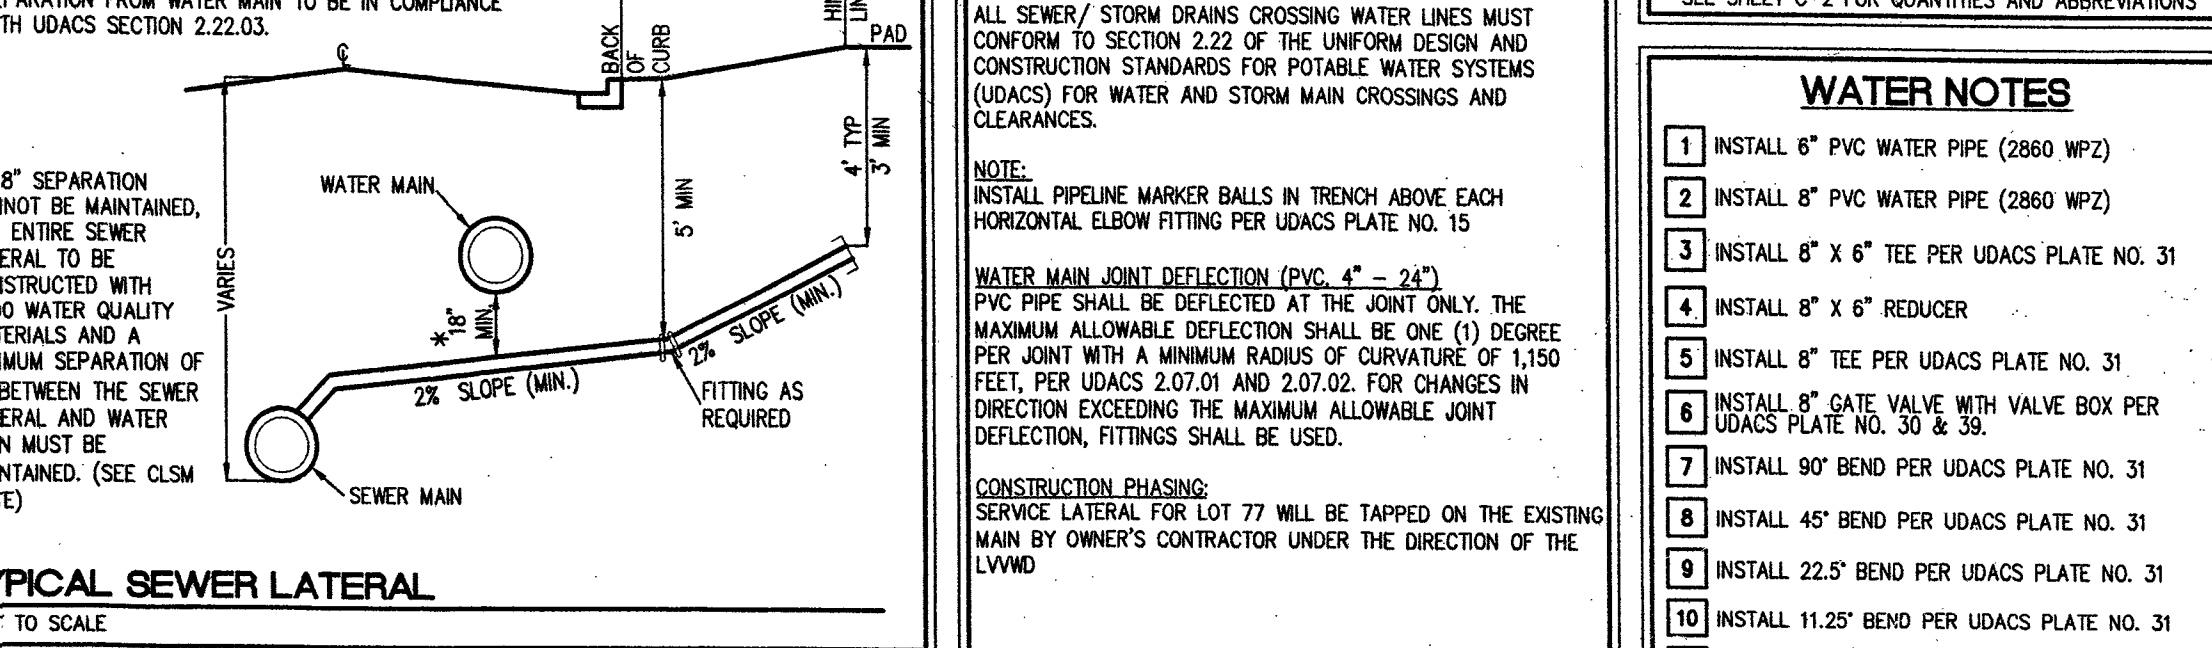
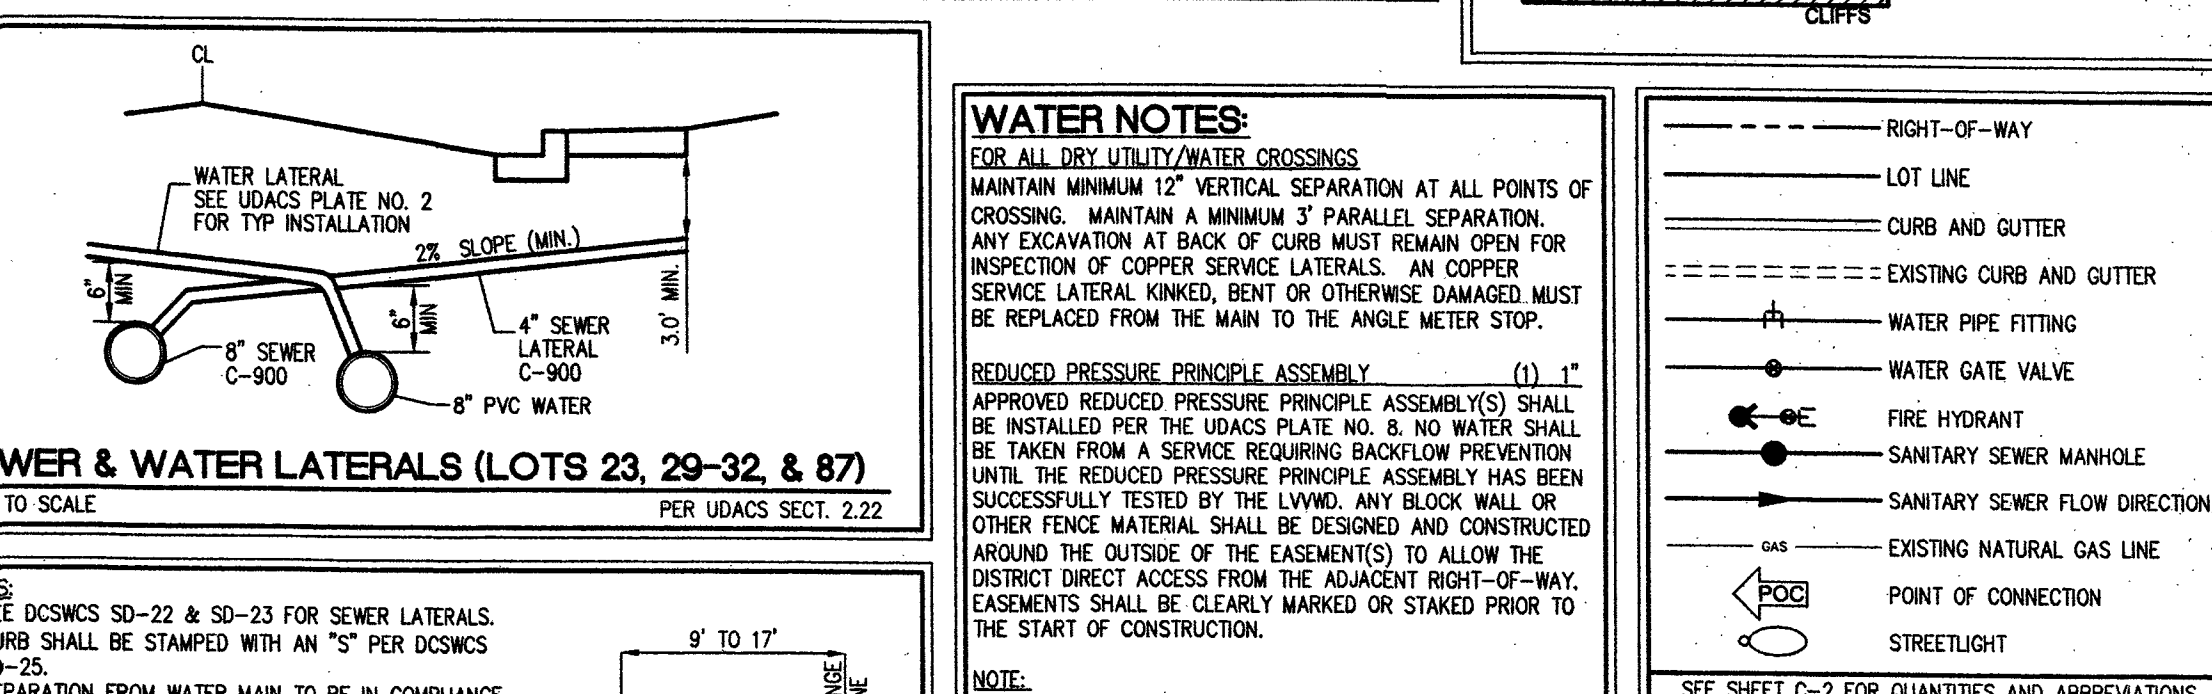
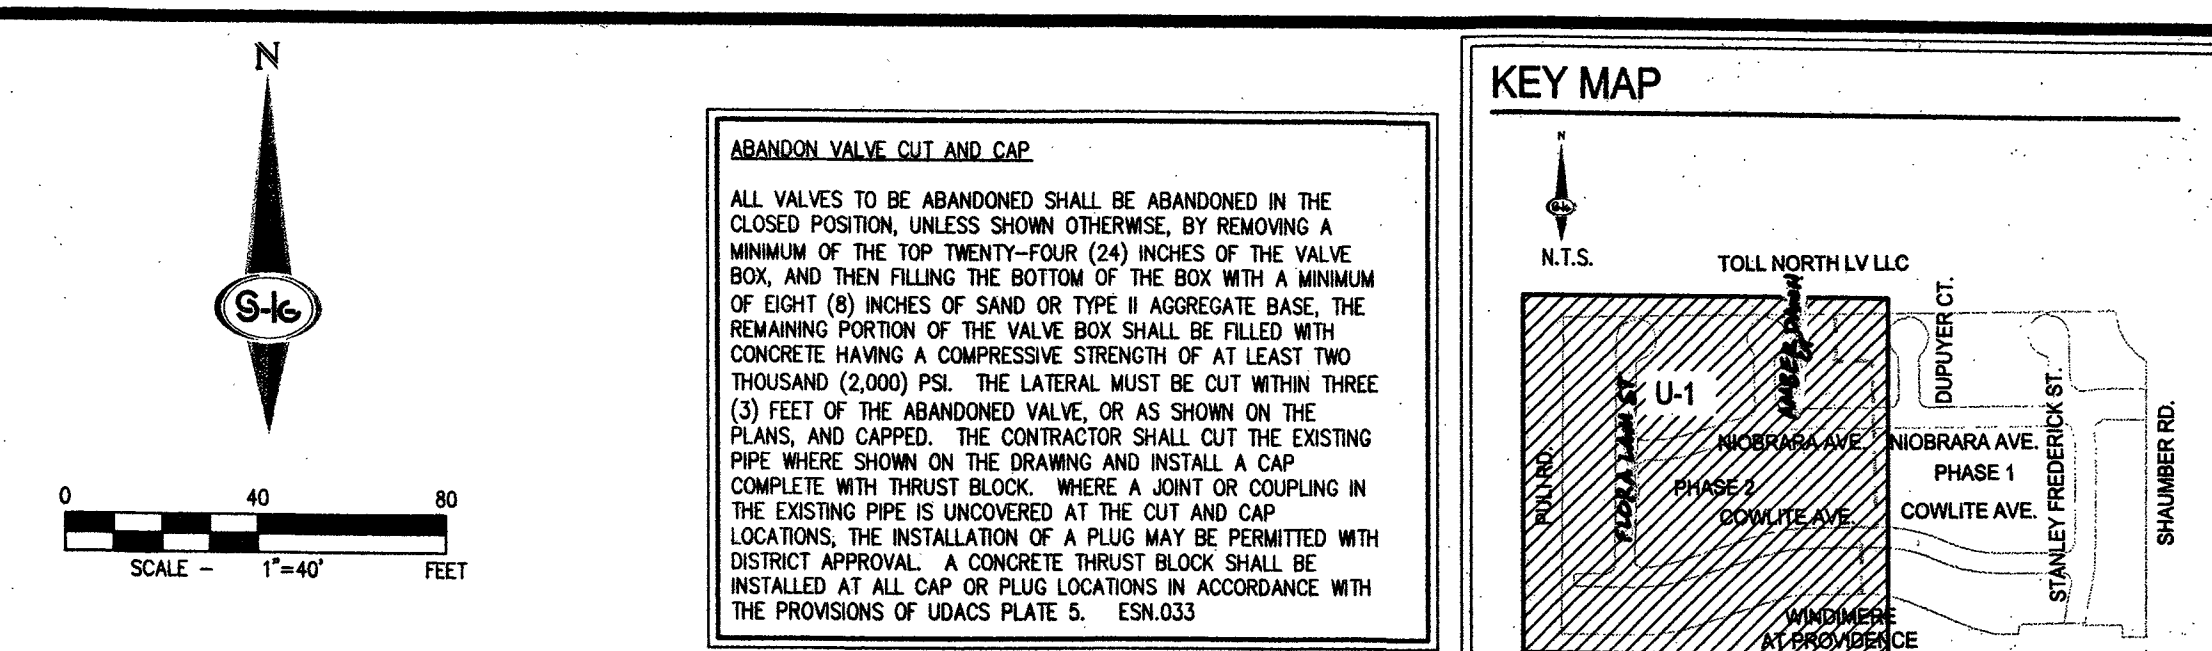
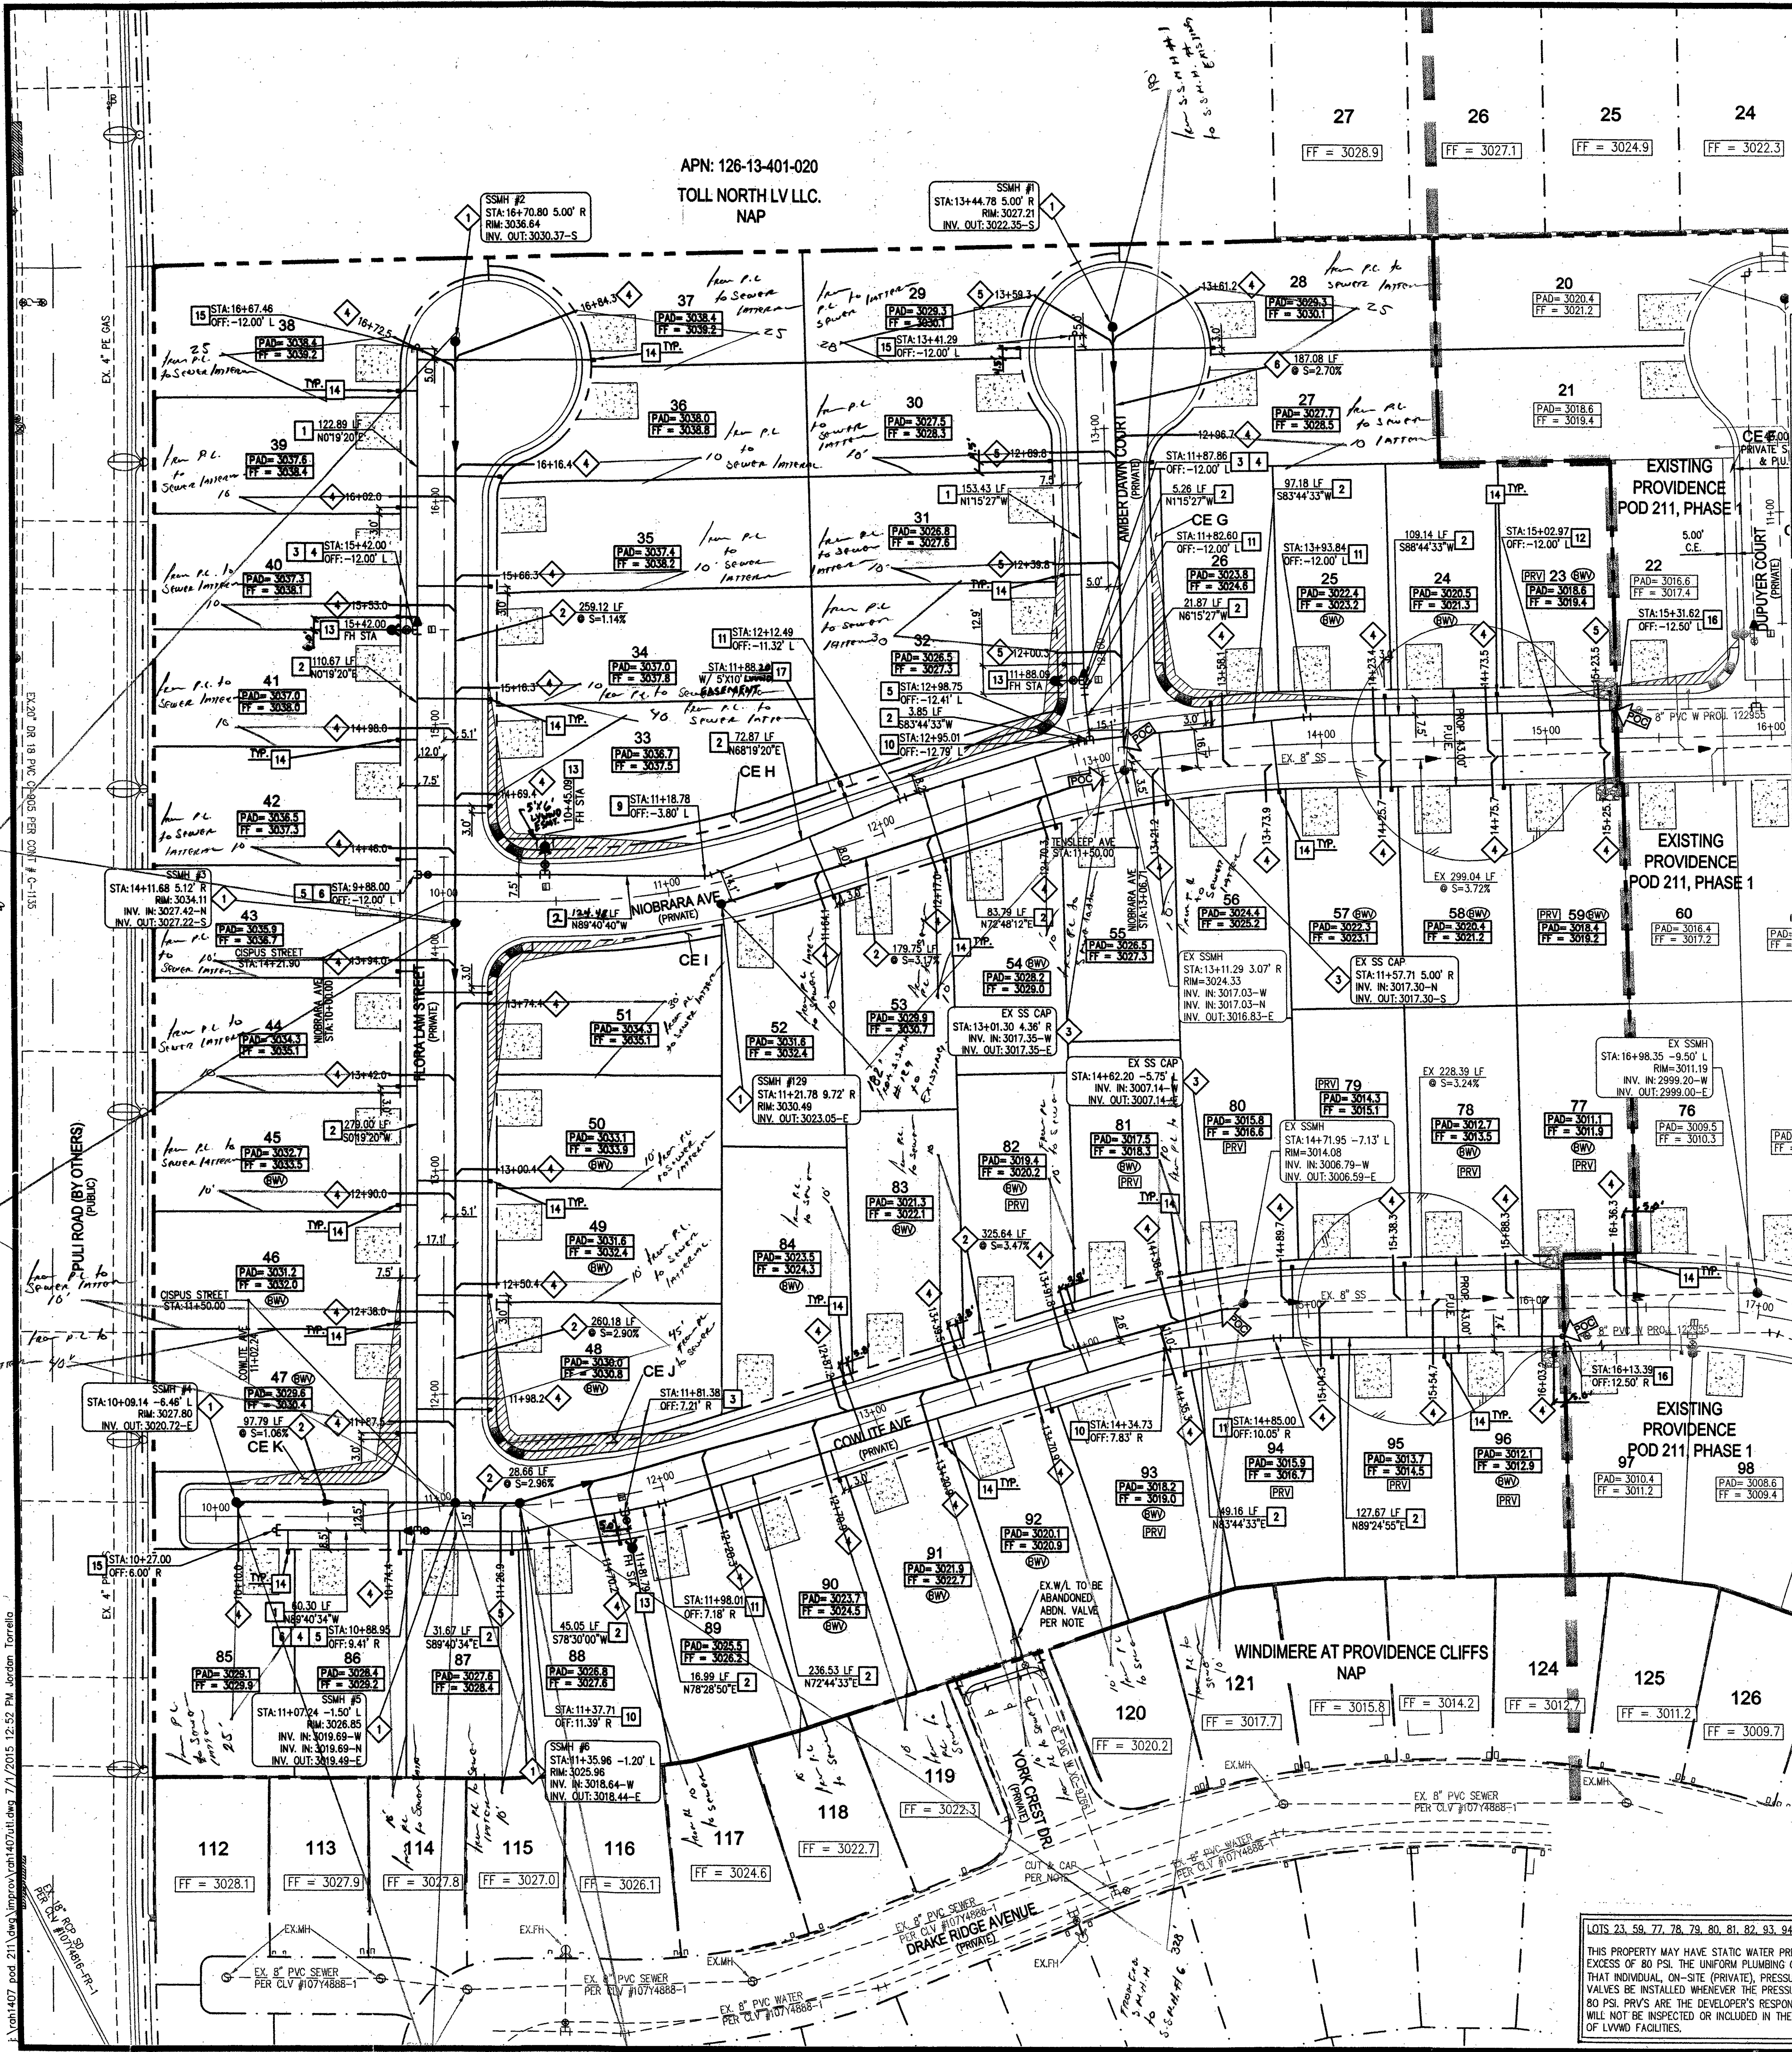


SLATER HANIFAN GROUP

CONSULTING ENGINEERS & PLANNERS

5740 S. ARVILLE STREET #216, LAS VEGAS, NV 89118

PHONE (702) 284-5300

CITY OF LAS VEGAS, NV

PROVIDENCE POD 211 PHASE 2

UTILITY PLAN

DATE: 6/16/15

DRAWN: JMT

CHECKED: TJS

PROJECT NO. RAH1407

U-1

SHEET 9 OF 10