


18-81

SYMBOL	MAKE & MODEL	SERIAL NO.
⊙	Automatic Timer	Aqua Dial 511P Controller
⊙	Vacuum Breaker	Frigo Model
⊙	Pump	Weinman Model 1.5 G Serial 200000
⊙	Motor	Reliance 3 HP 115 230V 32-16 amps
⊙	Sprinkler Full Circle	Aqua Dial No. 13 with 7/32 nozzle
⊙	Sprinkler Half Circle	Aqua Dial No. 14 with 7/32 nozzle
⊙	Sprinkler Full Circle	Champion Full Heads
⊙	Sprinkler Half Circle	Champion Half Heads
⊙	Valve (Electric)	Rainbird
⊙	Quick Disconnect	Rainbird No. 44 Quick Coupler
⊙	Valve Manual	Manual Control Valve

Note: Work drawing to show location by triangulation all electric valves. Show dimensions and access to pump and timer cage. Identify source of electric service.

--- 3" - 4" Sch 40 Main Line (Specify Size)
--- Lateral Line (Specify Size)

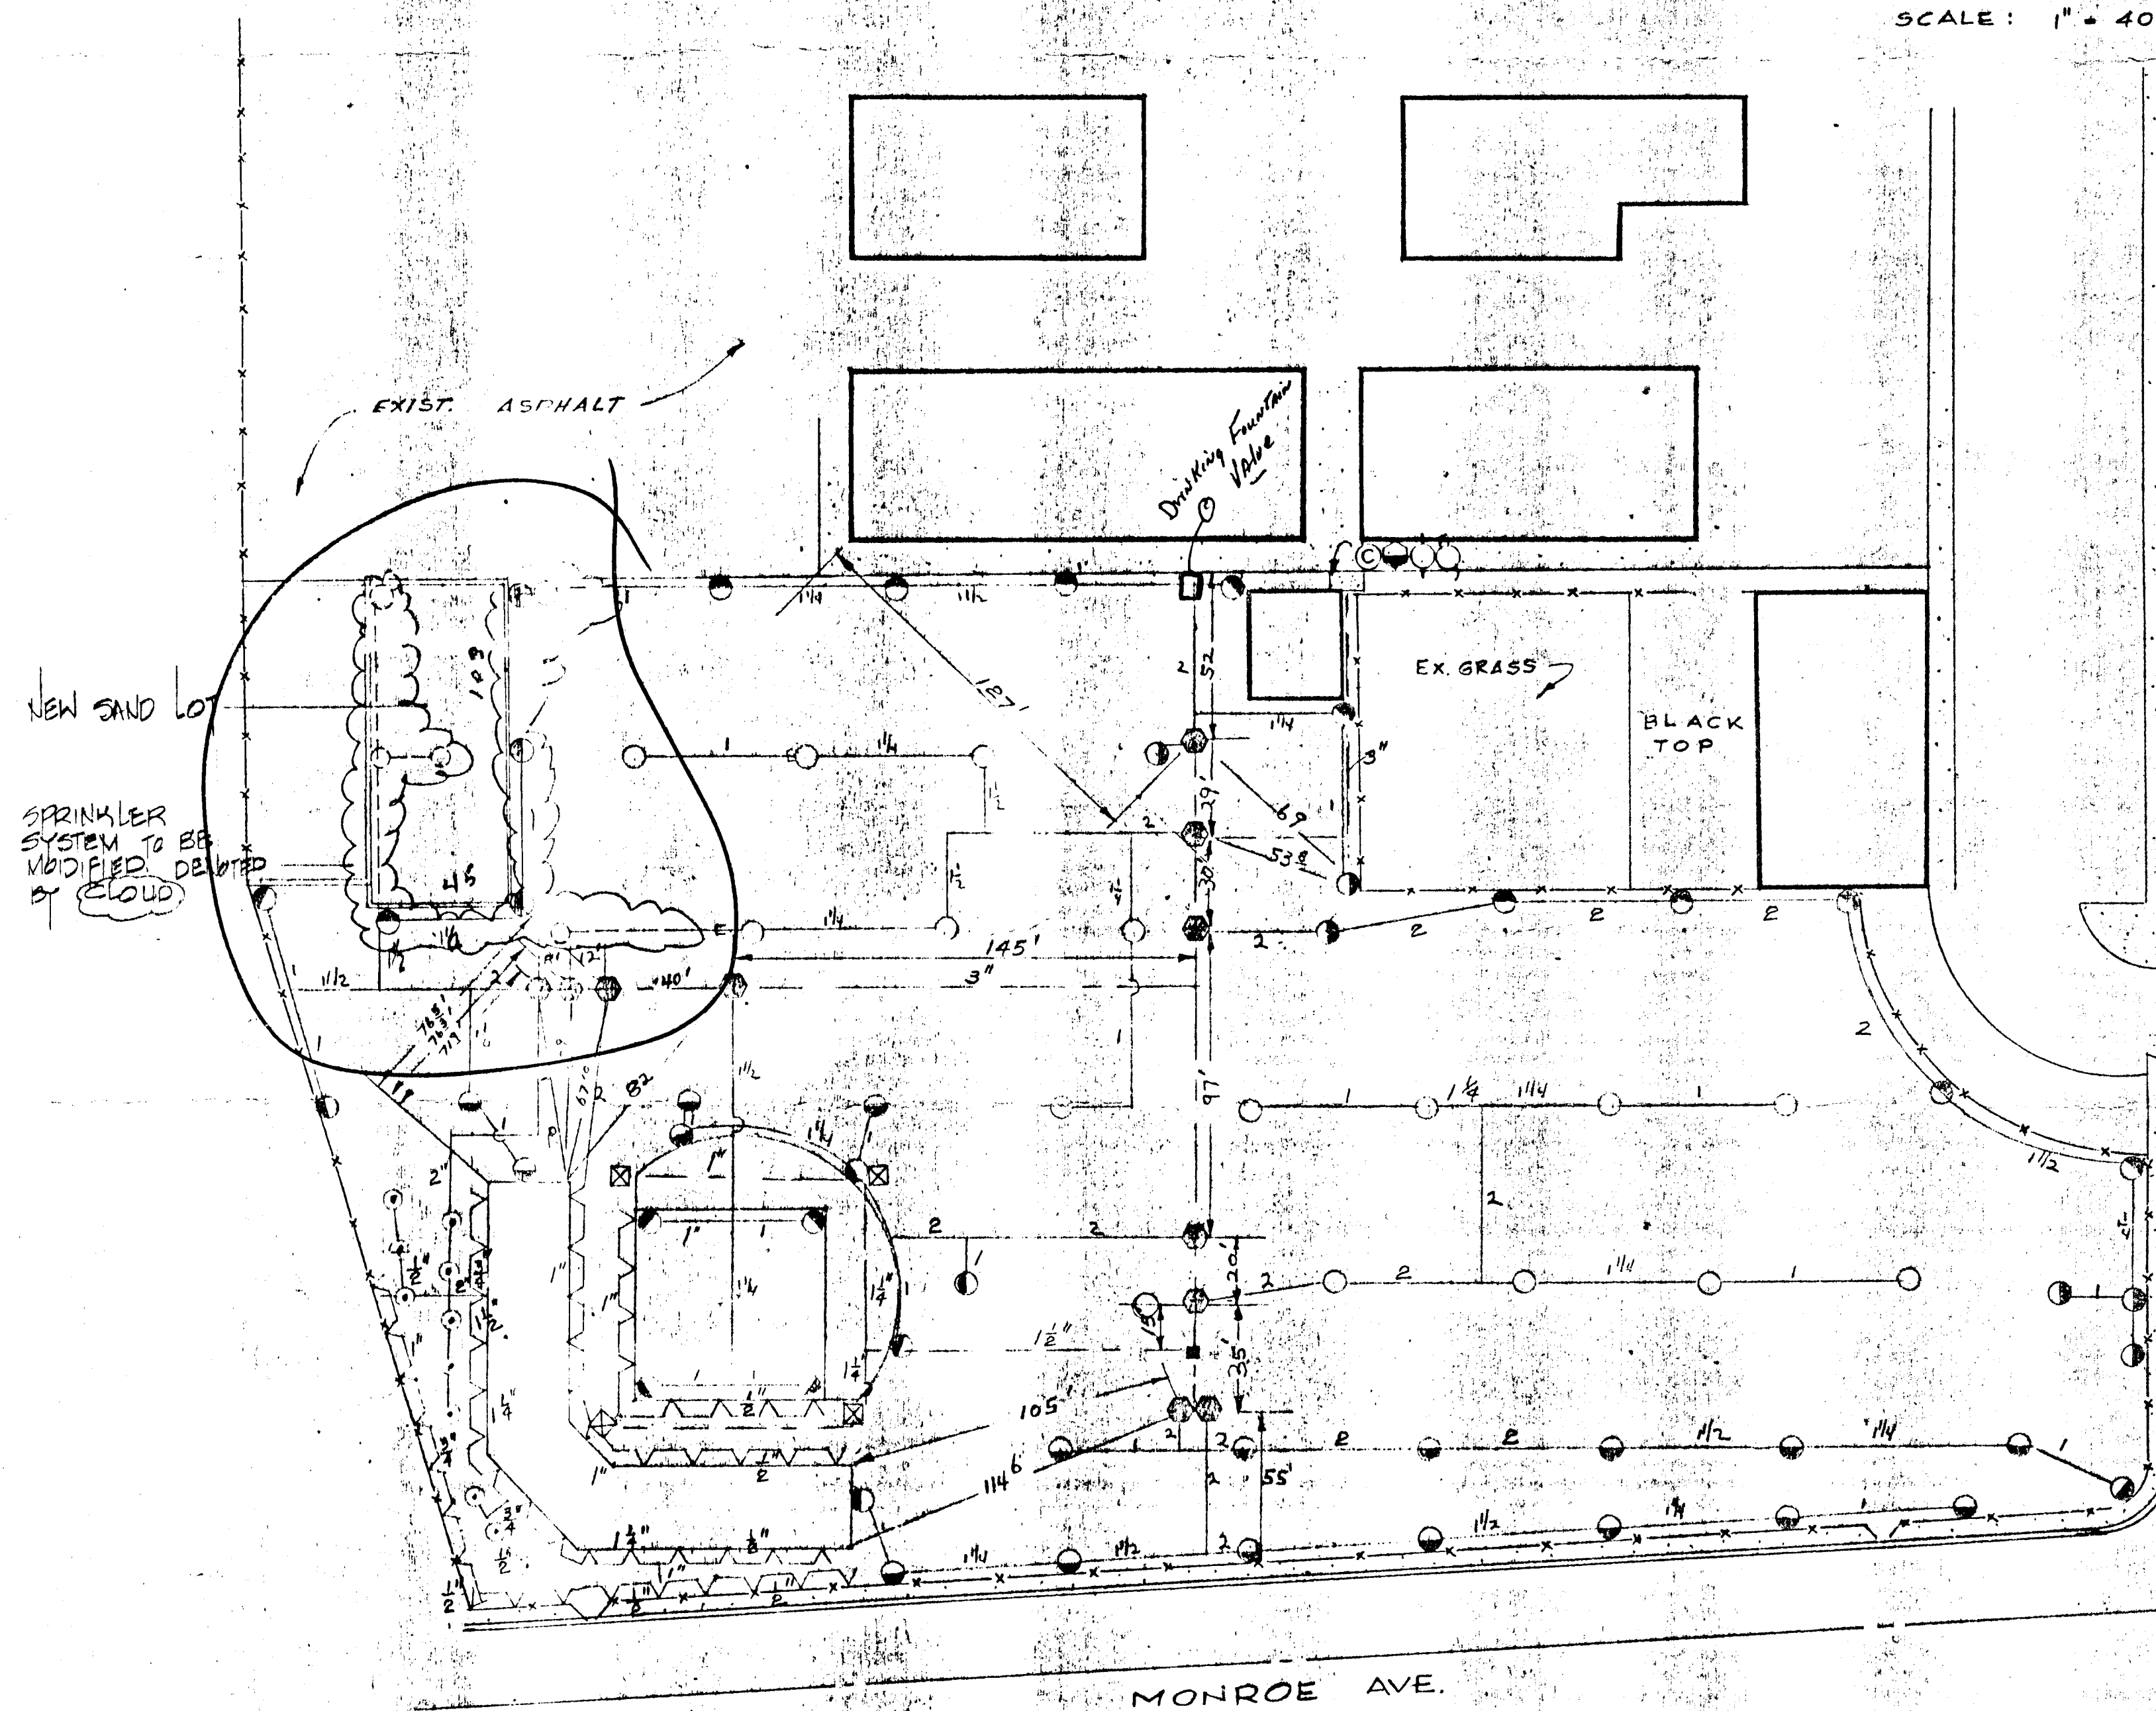

LAWN SPRINKLER PLAN (AS BUILT)
IRA J. EARL ELEMENTARY

222

3648

county
C.C.S.D.
school facilities
architectural
department
section

LAWN SPRINKLER SYSTEM
IRA J. EARL ELEMENTARY

drawn by
checked by
revision
sheet

736-5256
new 3/81

175-53