


CURVE TABLE				
CURVE	LENGTH	RADIUS	TANGENT	DELTA
C1	25.25'	46.00'	12.95'	31°28'58"
C3	210.95'	191.97'	117.55'	62°57'37"
C4	23.02'	20.50'	12.98'	65°57'22"
C10	16.03'	22.50'	36.66'	101°55'17"
C11	36.26'	22.50'	25.11'	92°29'11"

 DENOTES 6" REINFORCED CONCRETE PAVING OVER 8" TYPE II 2
 DENOTES TEXTURED CONCRETE PAVING 10
 3 DENOTES 4' DIA TREE WELL WITH LOCATION NUMBER
 • DENOTES 1' LIGHT WELL 3
 C8.03

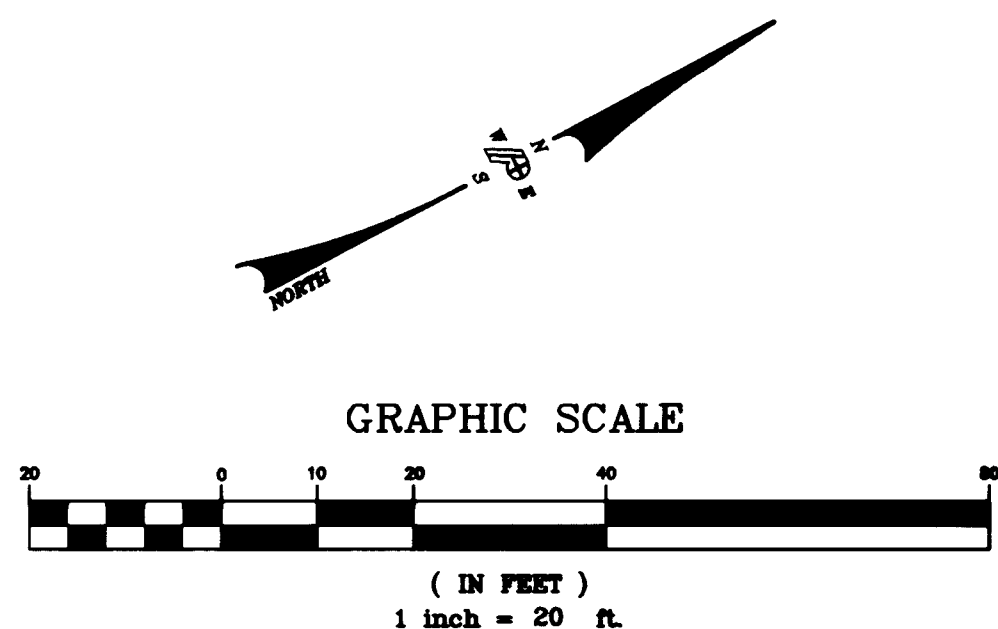

TREE WELL NO.	STATION	OFFSET FROM CENTERLINE	TREE WELL NO.	STATION	OFFSET FROM CENTERLINE	TREE WELL NO.	STATION	OFFSET FROM CENTERLINE
①	12+04.75	20.00' L	⑬	14+06.50	25.60' L	②⑤	13+06.50	12.50' R
②	12+18.50	25.60' L	⑭	14+21.50	25.60' L	②⑥	13+21.50	30.00' R
③	12+43.76	33.17' L	⑮	14+37.48	20.00' L	②⑦	13+39.50	12.50' R
④	12+51.50	33.17' L	⑯	12+07.50	25.00' R	②⑧	13+50.50	15.33' R
⑤	12+74.17	32.69' L	⑰	12+29.50	25.00' R	②⑨	13+61.50	17.74' R
⑥	12+90.67	32.69' L	⑱	12+37.70	18.03' R	③⑩	13+72.75	30.00' R
⑦	13+07.17	32.69' L	⑲	12+51.50	25.00' R	③⑪	13+84.00	25.00' R
⑧	13+23.67	32.69' L	⑳	12+57.92	14.61' R	③⑫	13+95.25	30.00' R
⑨	13+40.17	32.69' L	㉑	12+73.50	25.00' R			
⑩	13+61.50	30.00' L	㉒	12+67.98	9.86' R			
⑪	13+76.59	33.00' L	㉓	12+79.16	8.15' R			
⑫	13+89.09	20.51 L	㉔	12+95.50	25.00' R			

- 1 CONSTRUCT "L" TYPE CURB & GUTTER
IN ACCORDANCE WITH USD NO. 216
- 2 CONSTRUCT 6" STEEL REINFORCED CONCRETE OVER 8"
TYPE II AGGREGATE BASE IN ACCORDANCE WITH DETAIL
- 3 CONSTRUCT 8' CROSS GUTTER PER
CLARK COUNTY AREA STD. DWG. NO. 228
- 4 INSTALL AUTOMATIC GATE, STANLEY MODEL 460
REFER TO ELECTRICAL PLANS
- 5 INSTALL SPECIAL BOLLARD IN
ACCORDANCE WITH 1
C8.03 3
- 6 REMOVE EXISTING PARKING METER & FOUNDATION
- 9 CONSTRUCT FREMONT STREET EXPERIENCE
GUTTER IN ACCORDANCE WITH DETAIL 5
C8.01
- 10 CONSTRUCT TEXTURED CONCRETE PAVING
REFER TO LANDSCAPE PLANS FOR TEXTURE & PATTERN
- 11 CONSTRUCT SIDEWALK RAMP CASE II PER
CLARK COUNTY AREA STD. DWG. NO. 235
- 12 CONSTRUCT BOLLARD RECEIVER PER DETAIL
RELOCATE EXISTING BOLLARD INTO RECEIVER 6
C8.01
- 13 CONSTRUCT FSE FLAG POLE SEE LANDSCAPE

NOTE:
FOR PLANTER NO. 1, 2 & 3 LAYOUT
SEE SHEET C8.03

AVOID HITTING OVERHEAD
POWER LINES. IT'S ONLY
CALL BEFORE
YOU DO
OVERHEAD




1-702-583-6111
NEVADA POWER EXPERIMENT

Avoid cutting underground utility lines. It's costly.

**Call
before you
Dig**

1-800-227-2800

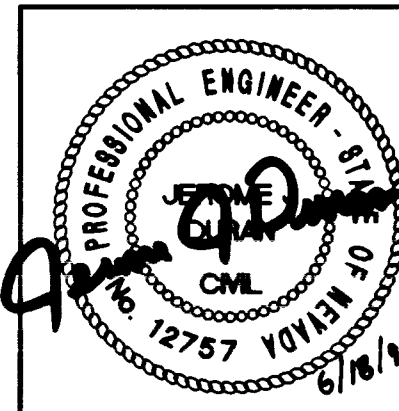

ENGINEERS PLANNERS SURVEYORS
LANDSCAPE ARCHITECTS
POGGEMEYER
DESIGN GROUP INC.
2601 NORTH TENAYA WAY
LAS VEGAS, NEVADA 89128 (702) 255-8100

	ISSUED FOR CONSTRUCTION	00/00/00
REV No:	NOTE	DATE
	REQUIRED FOR UTILITY/CITY APPROVAL	05/08/98
	REMOVE GATE ADD BOLLARDS	05/21/98
	CLARIFICATION REQUIRED BY CITY ENGINEER 7/7/98	06/09/98 ^{PH}

FREMONT STREET EXPERIENCE

THIS DOCUMENT DOES NOT DESCRIBE AN INSTALLABLE SYSTEM UNTIL IT HAS BEEN REVIEWED FOR CODE COMPLIANCE AND COMPLIANCE WITH CONSTRUCTION STANDARDS BY A CERTIFIED ENGINEER. ALTHOUGH EVERY EFFORT HAS BEEN MADE TO PRODUCE A COMPLETE AND ACCURATE CODE-COMPLIANT DESIGN, PRESTRESS SYSTEM EXPERIENCE, LLC, SPECIFICALLY DISCLAIMS ANY RESPONSIBILITY FOR CODE COMPLIANCE. THESE DRAWINGS AND THE CONCEPTS THEY REPRESENT ARE THE PROPERTY OF PRESTRESS SYSTEM EXPERIENCE, LLC. ANY REUSE, REPRODUCTION, REPRODUCTION, COPIED OR USED IN ANY PART PRIOR TO WRITTEN PREMISSION OF PRESTRESS SYSTEM EXPERIENCE, LLC.

425 FREMONT STREET, LAS VEGAS, NV. 89101
TEL: (702) 678-5600 FAX: (702) 678-5611

JOB No:	98046C
DESIGNED BY:	JJD
DRAWN BY:	DRF
DATE:	6.18.98
FILE NAME:	C401-SITE

PROJECT TITLE:
FREMONT STREET EXPERIENCE
3rd STREET MALL EXPANSION

SITE PLAN

SHEET TITLE:

SCALE: AS NOTED
SHEET 4 OF 24
DRAWING No:
C4.01

107-V2922

