
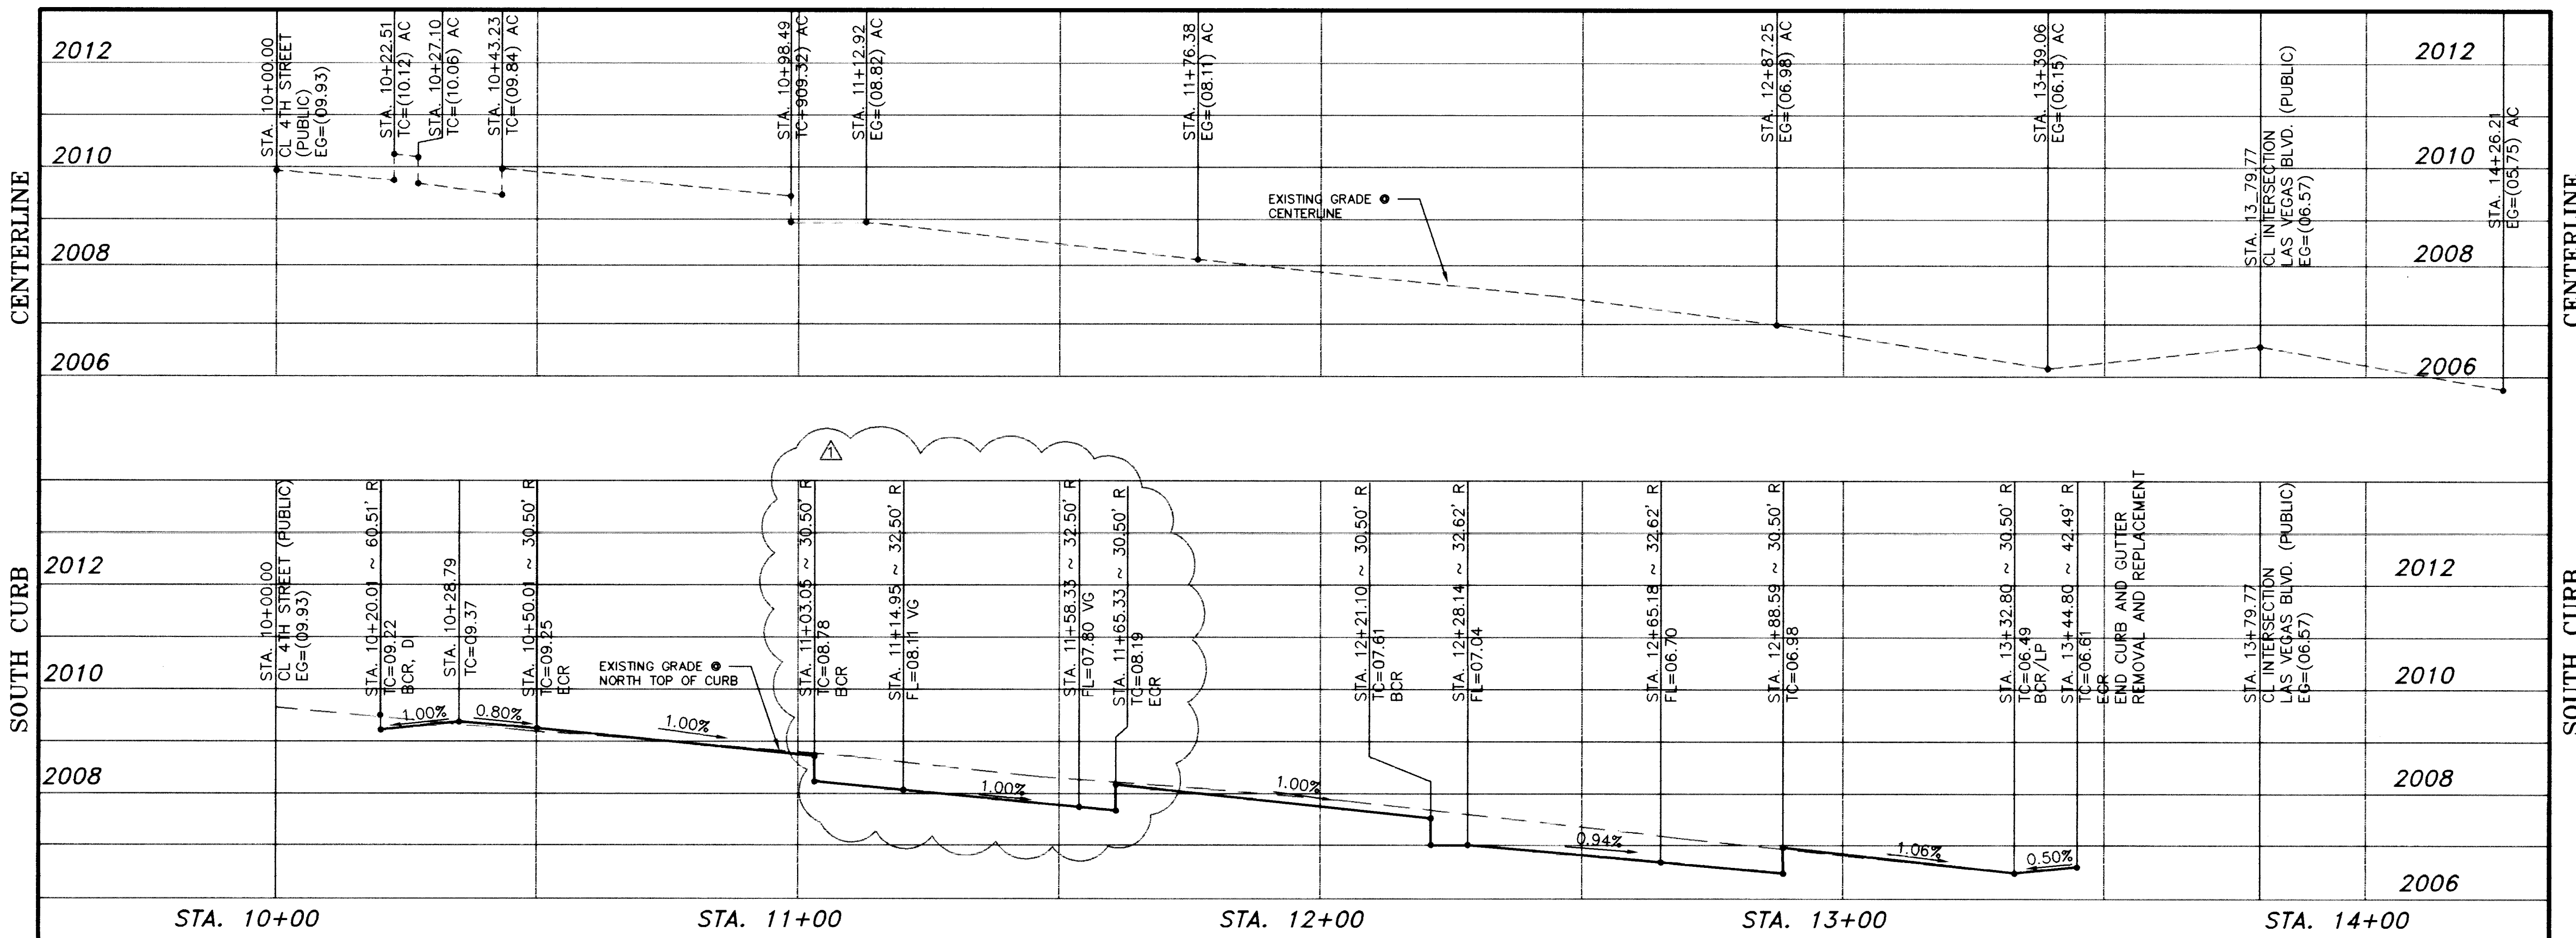


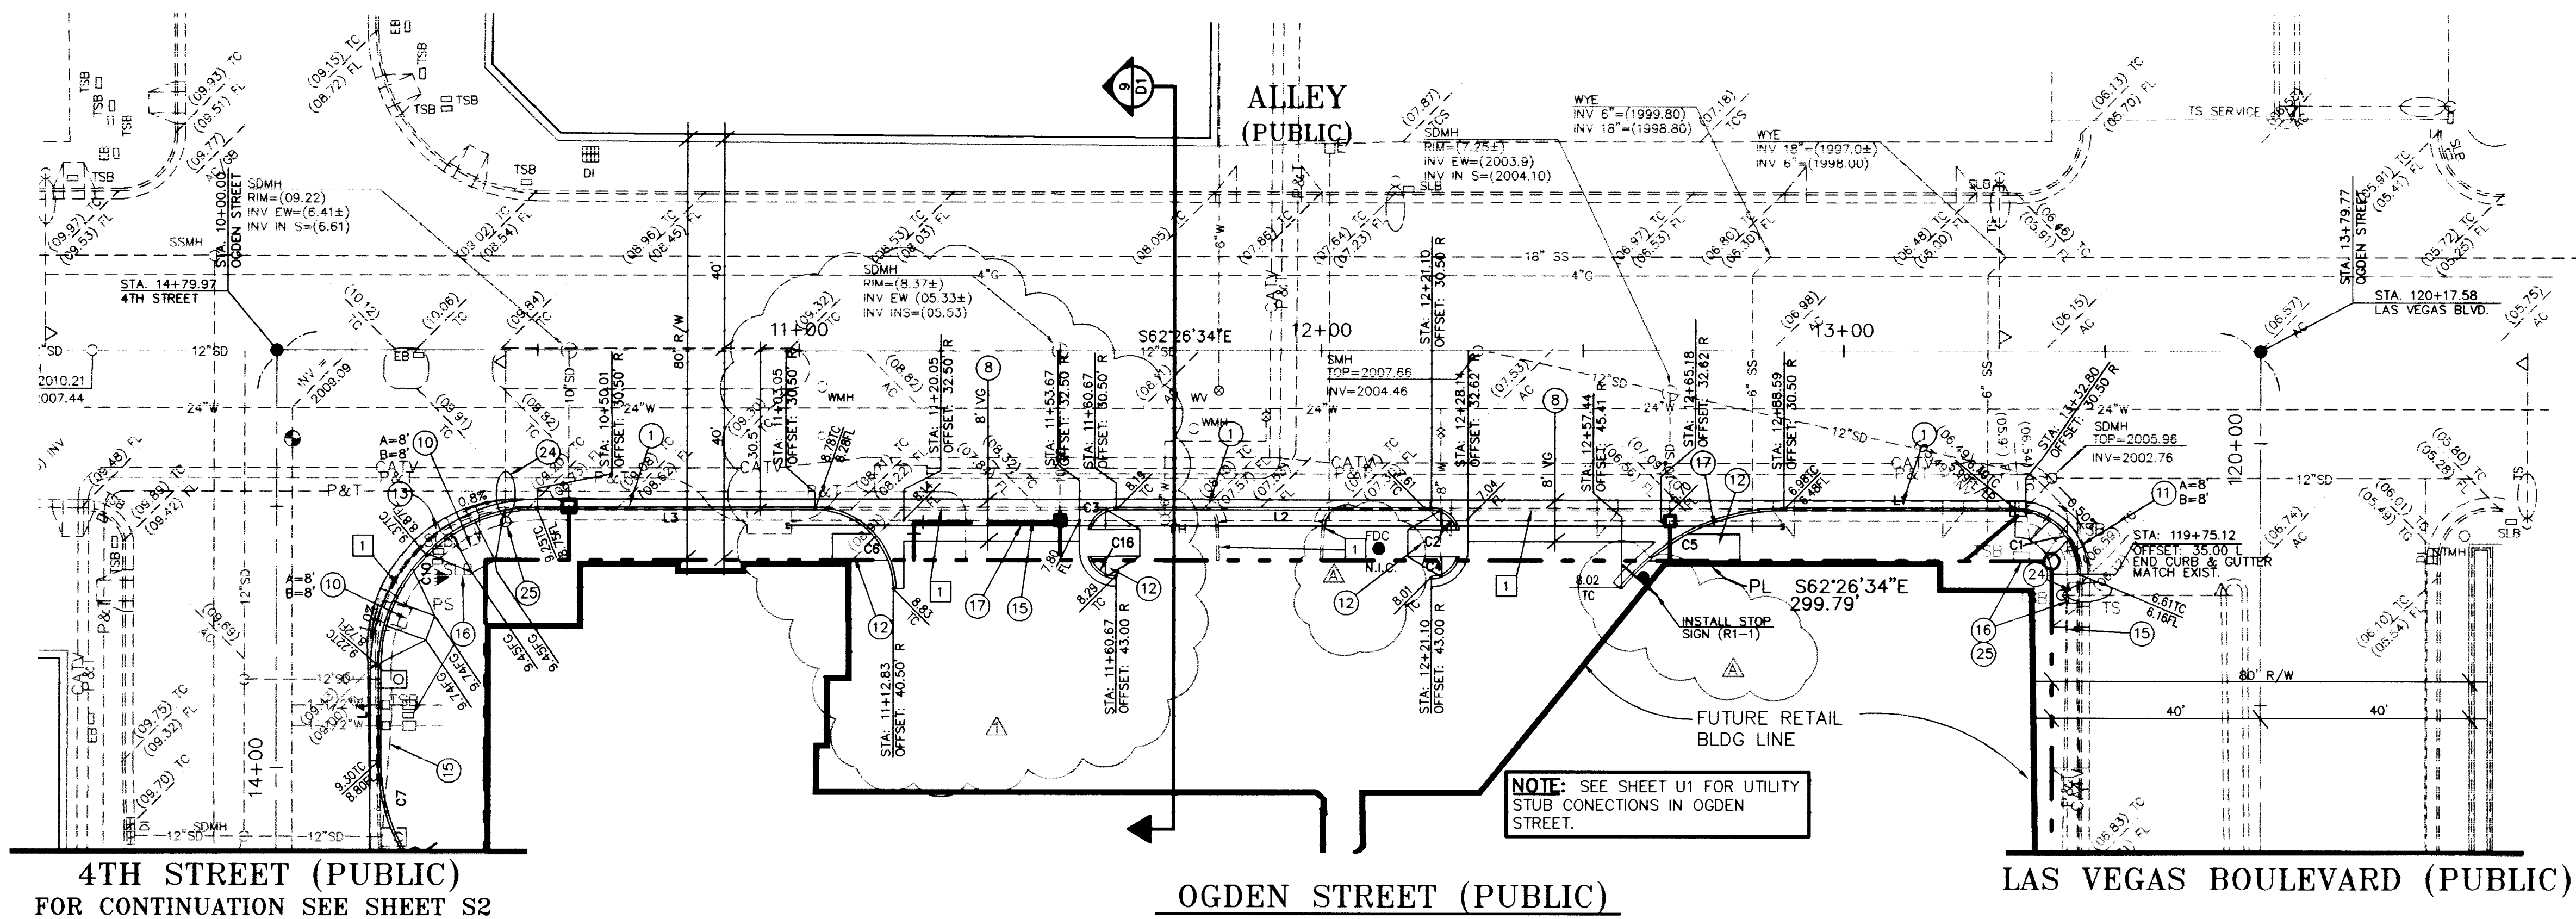


AVOID CUTTING UNDERGROUND
UTILITY LINES. IT'S COSTLY.

Call before you Dig-
1-800-227-2600
UNDERGROUND SERVICE ALERT (U.S.A.)

AVOID OVERHEAD POWER
LINE CONTACT

Call before you OVERHEAD
1-702-593-6111
NEVADA POWER ENVIRONMENT AND
SAFETY SERVICES DEPARTMENT

MARTIN & MARTIN ASSUMES NO RESPONSIBILITY FOR EXISTING UTILITY LOCATIONS
AND ELEVATIONS. THE UTILITIES SHOWN ON THIS DRAWING HAVE BEEN PLOTTED
FROM THE BEST AVAILABLE INFORMATION. IT IS, HOWEVER, THE CONTRACTOR'S
RESPONSIBILITY TO FIELD VERIFY THE LOCATION AND ELEVATION OF ALL UTILITIES
PRIOR TO THE COMMENCEMENT OF ANY CONSTRUCTION. CONTRACTOR TO FIELD
VERIFY ALL EXISTING SITE CONDITIONS PRIOR TO CONSTRUCTION. IF A CONFLICT
EXISTS BETWEEN WHAT IS SHOWN ON THESE DRAWINGS AND WHAT EXISTS IN THE
FIELD, THE CONTRACTOR IS TO NOTIFY THE ARCHITECT OR ENGINEER IMMEDIATELY.

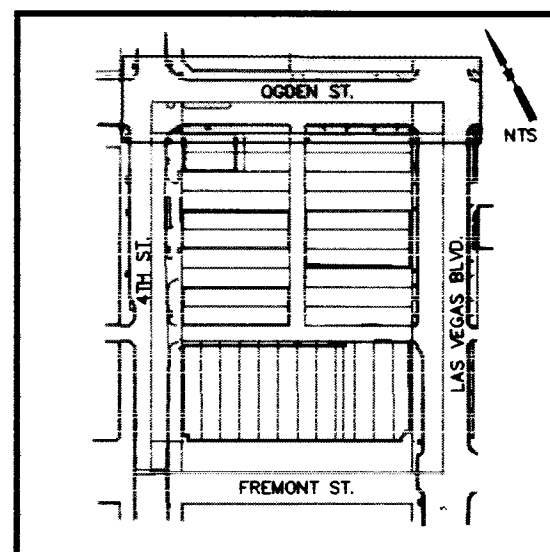

ISSUED FOR BIDDING 12-30-98

1-28-99

sheet

S3

SHEET 8 OF 9

drawing number

107-V3037

PLAN CHECK REVISIONS 12-28-98

no	description of revisions	date	name
1	REVISE DRIVEWAY. ADD STORM DRAIN	1-18-99	JB / JAB

WORLD ENTERTAINMENT CENTERS
LAS VEGAS, INC.
233 SOUTH FOURTH STREET, SUITE 201
LAS VEGAS, NEVADA 89101
PHONE (702) 477-0470

MARTIN & MARTIN
CIVIL ENGINEERS
2101 SOUTH JONES BLVD., SUITE A
LAS VEGAS, NEVADA 89146
PHONE (702) 248-8000

PLAN AND PROFILE
OGDEN STREET (PUBLIC)

GARAGE PLANS FOR
NEONOPOLIS

@ FREMONT STREET EXPERIENCE

date 12-30-98

job number 1671.00

design by J. BETTENCOURT

drawn by V. WINFORD

checked by D. MALPASS, P.E.

