


ART L. JACOBSON-ARCHITECT
RIVERSIDE, CALIFORNIA

HEERS ASSOC.
LAS VEGAS, NEVADA

PERMITS 45-413	DATE 27.03.54	SHEET 2 B
JOB NO. Z-55		OF SHEETS

UTILITY PLAN
SCALE 1" = 30'
SEE NOTE ON SHEET #1

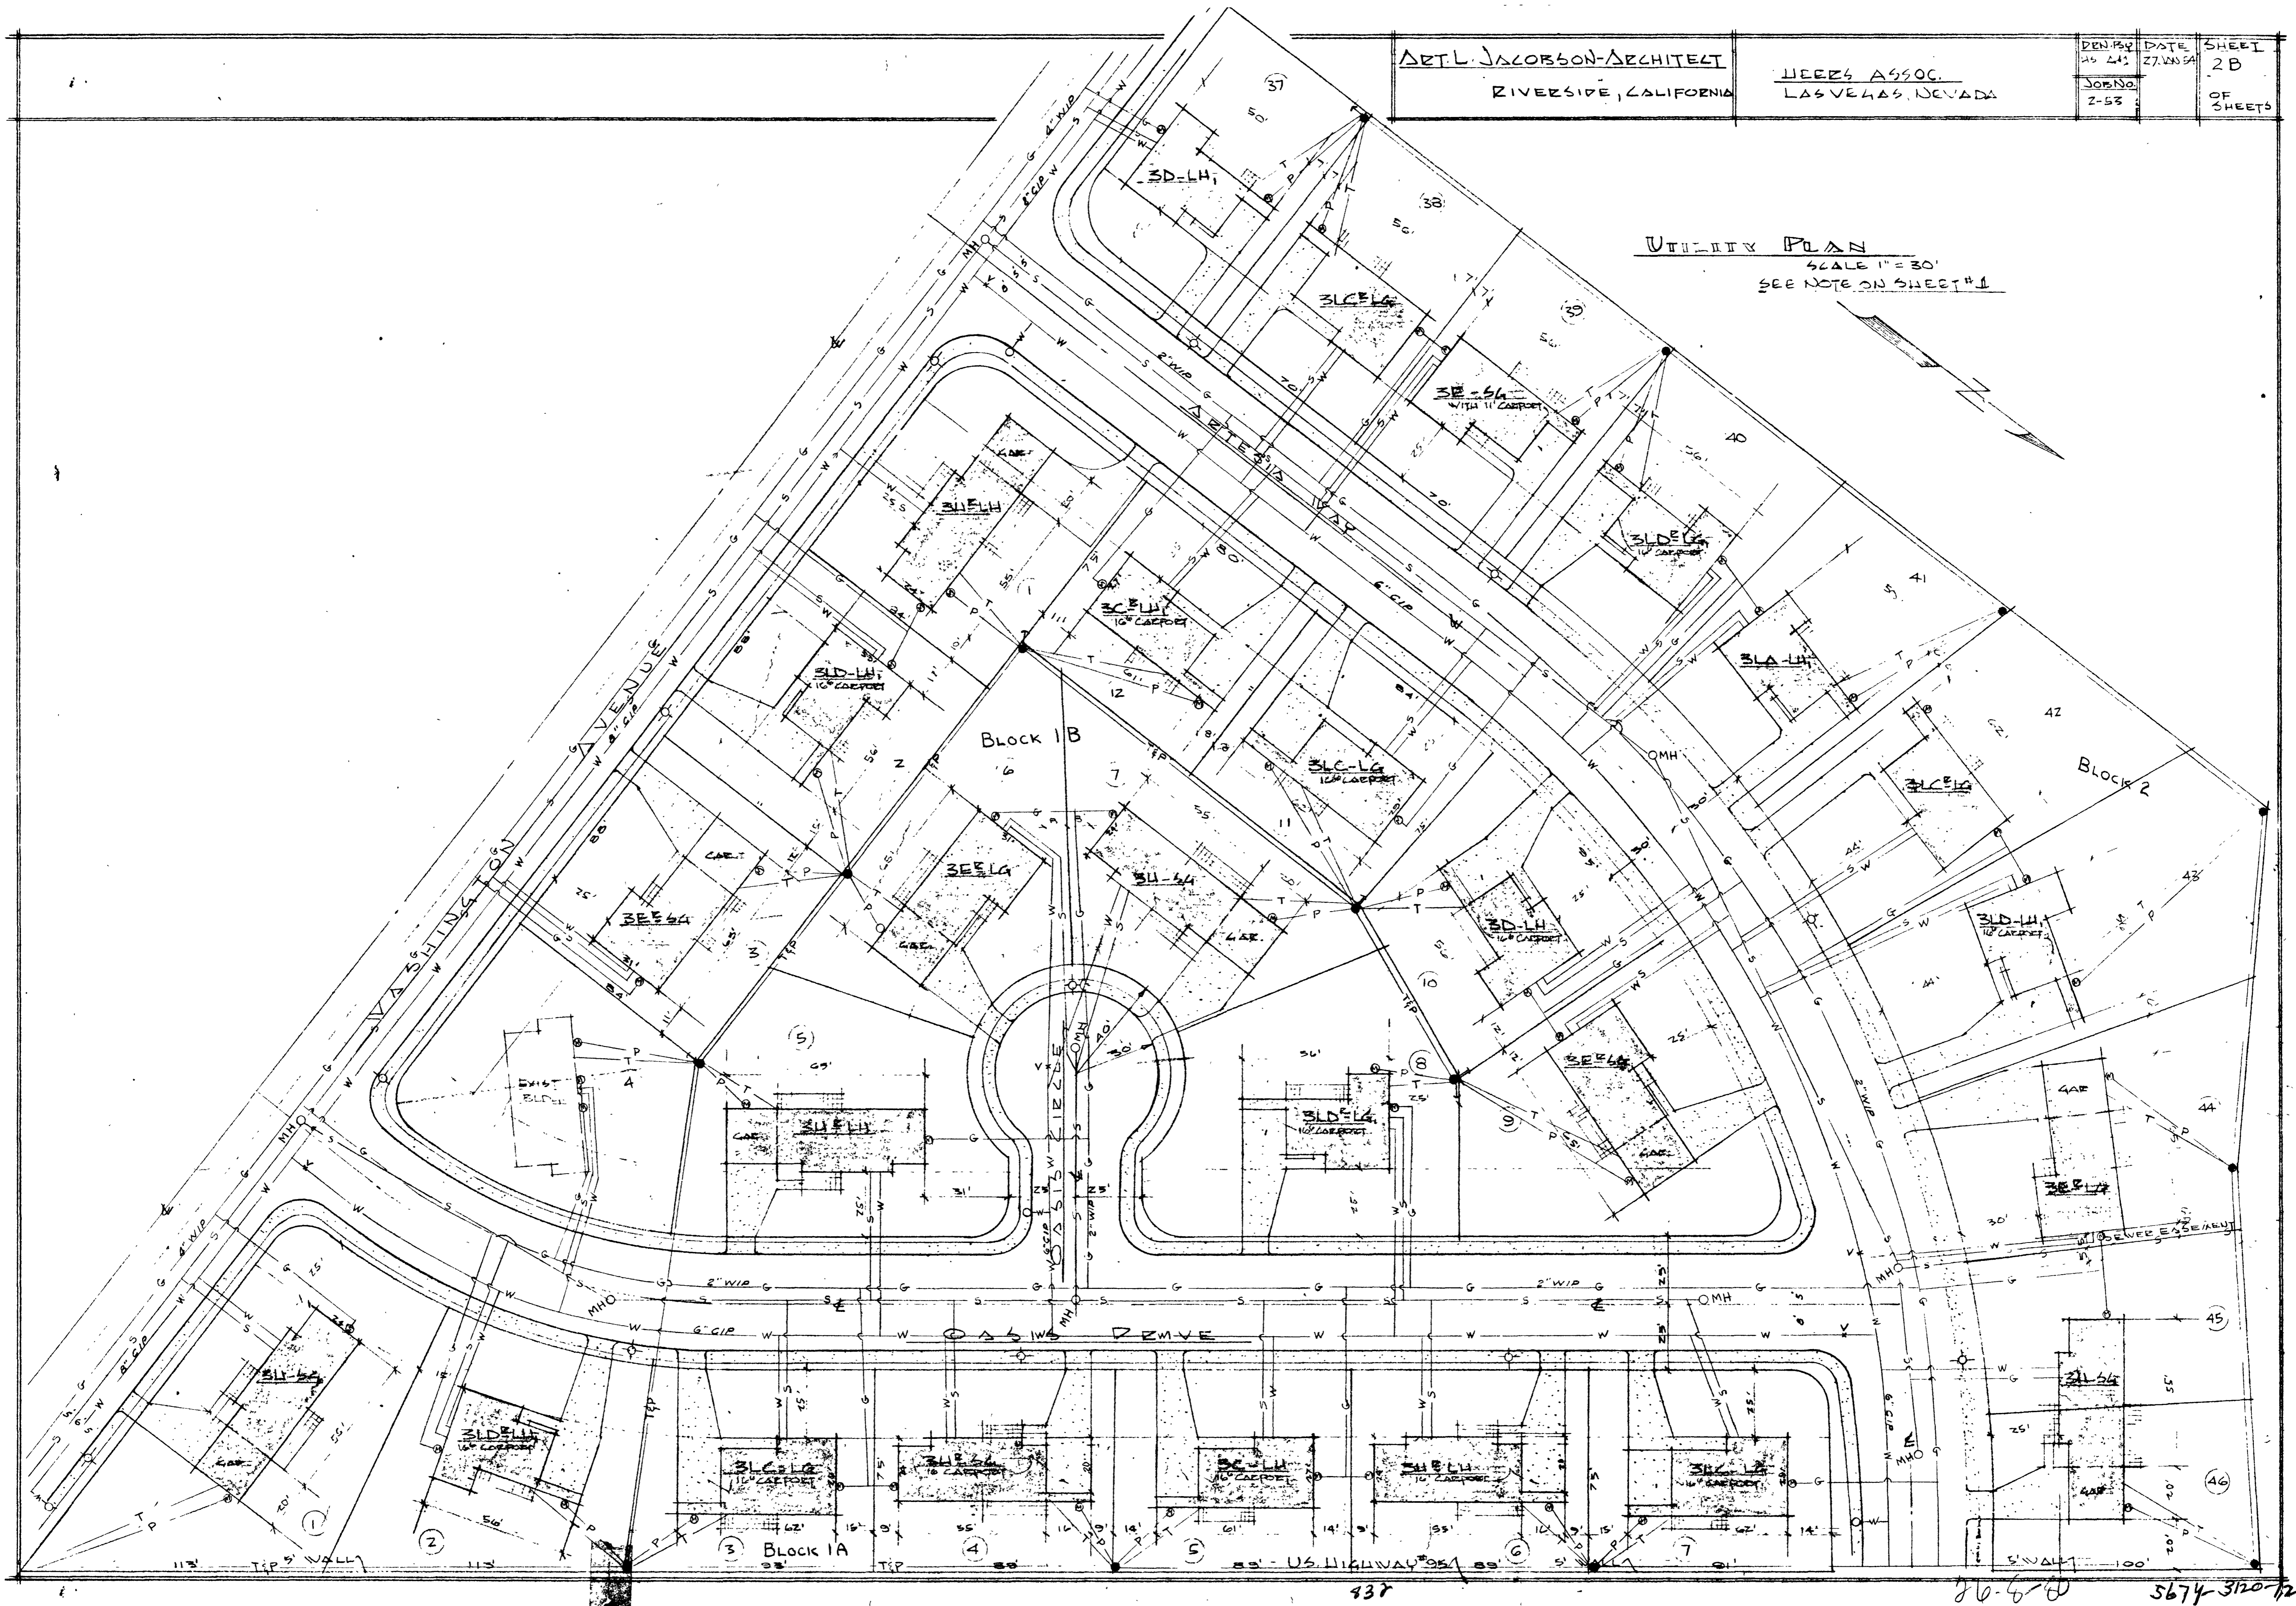

Architects
Beverly Hills, California

Client
Los Angeles, California

DATE	NOV 20 1954
SCALE	AS SHOWN
BY	W. H. H. / J. H. H.
CHECKED	W. H. H. / J. H. H.

MECHANICAL PLAN
FIRST FLOOR
SECTION OF BUILDING

