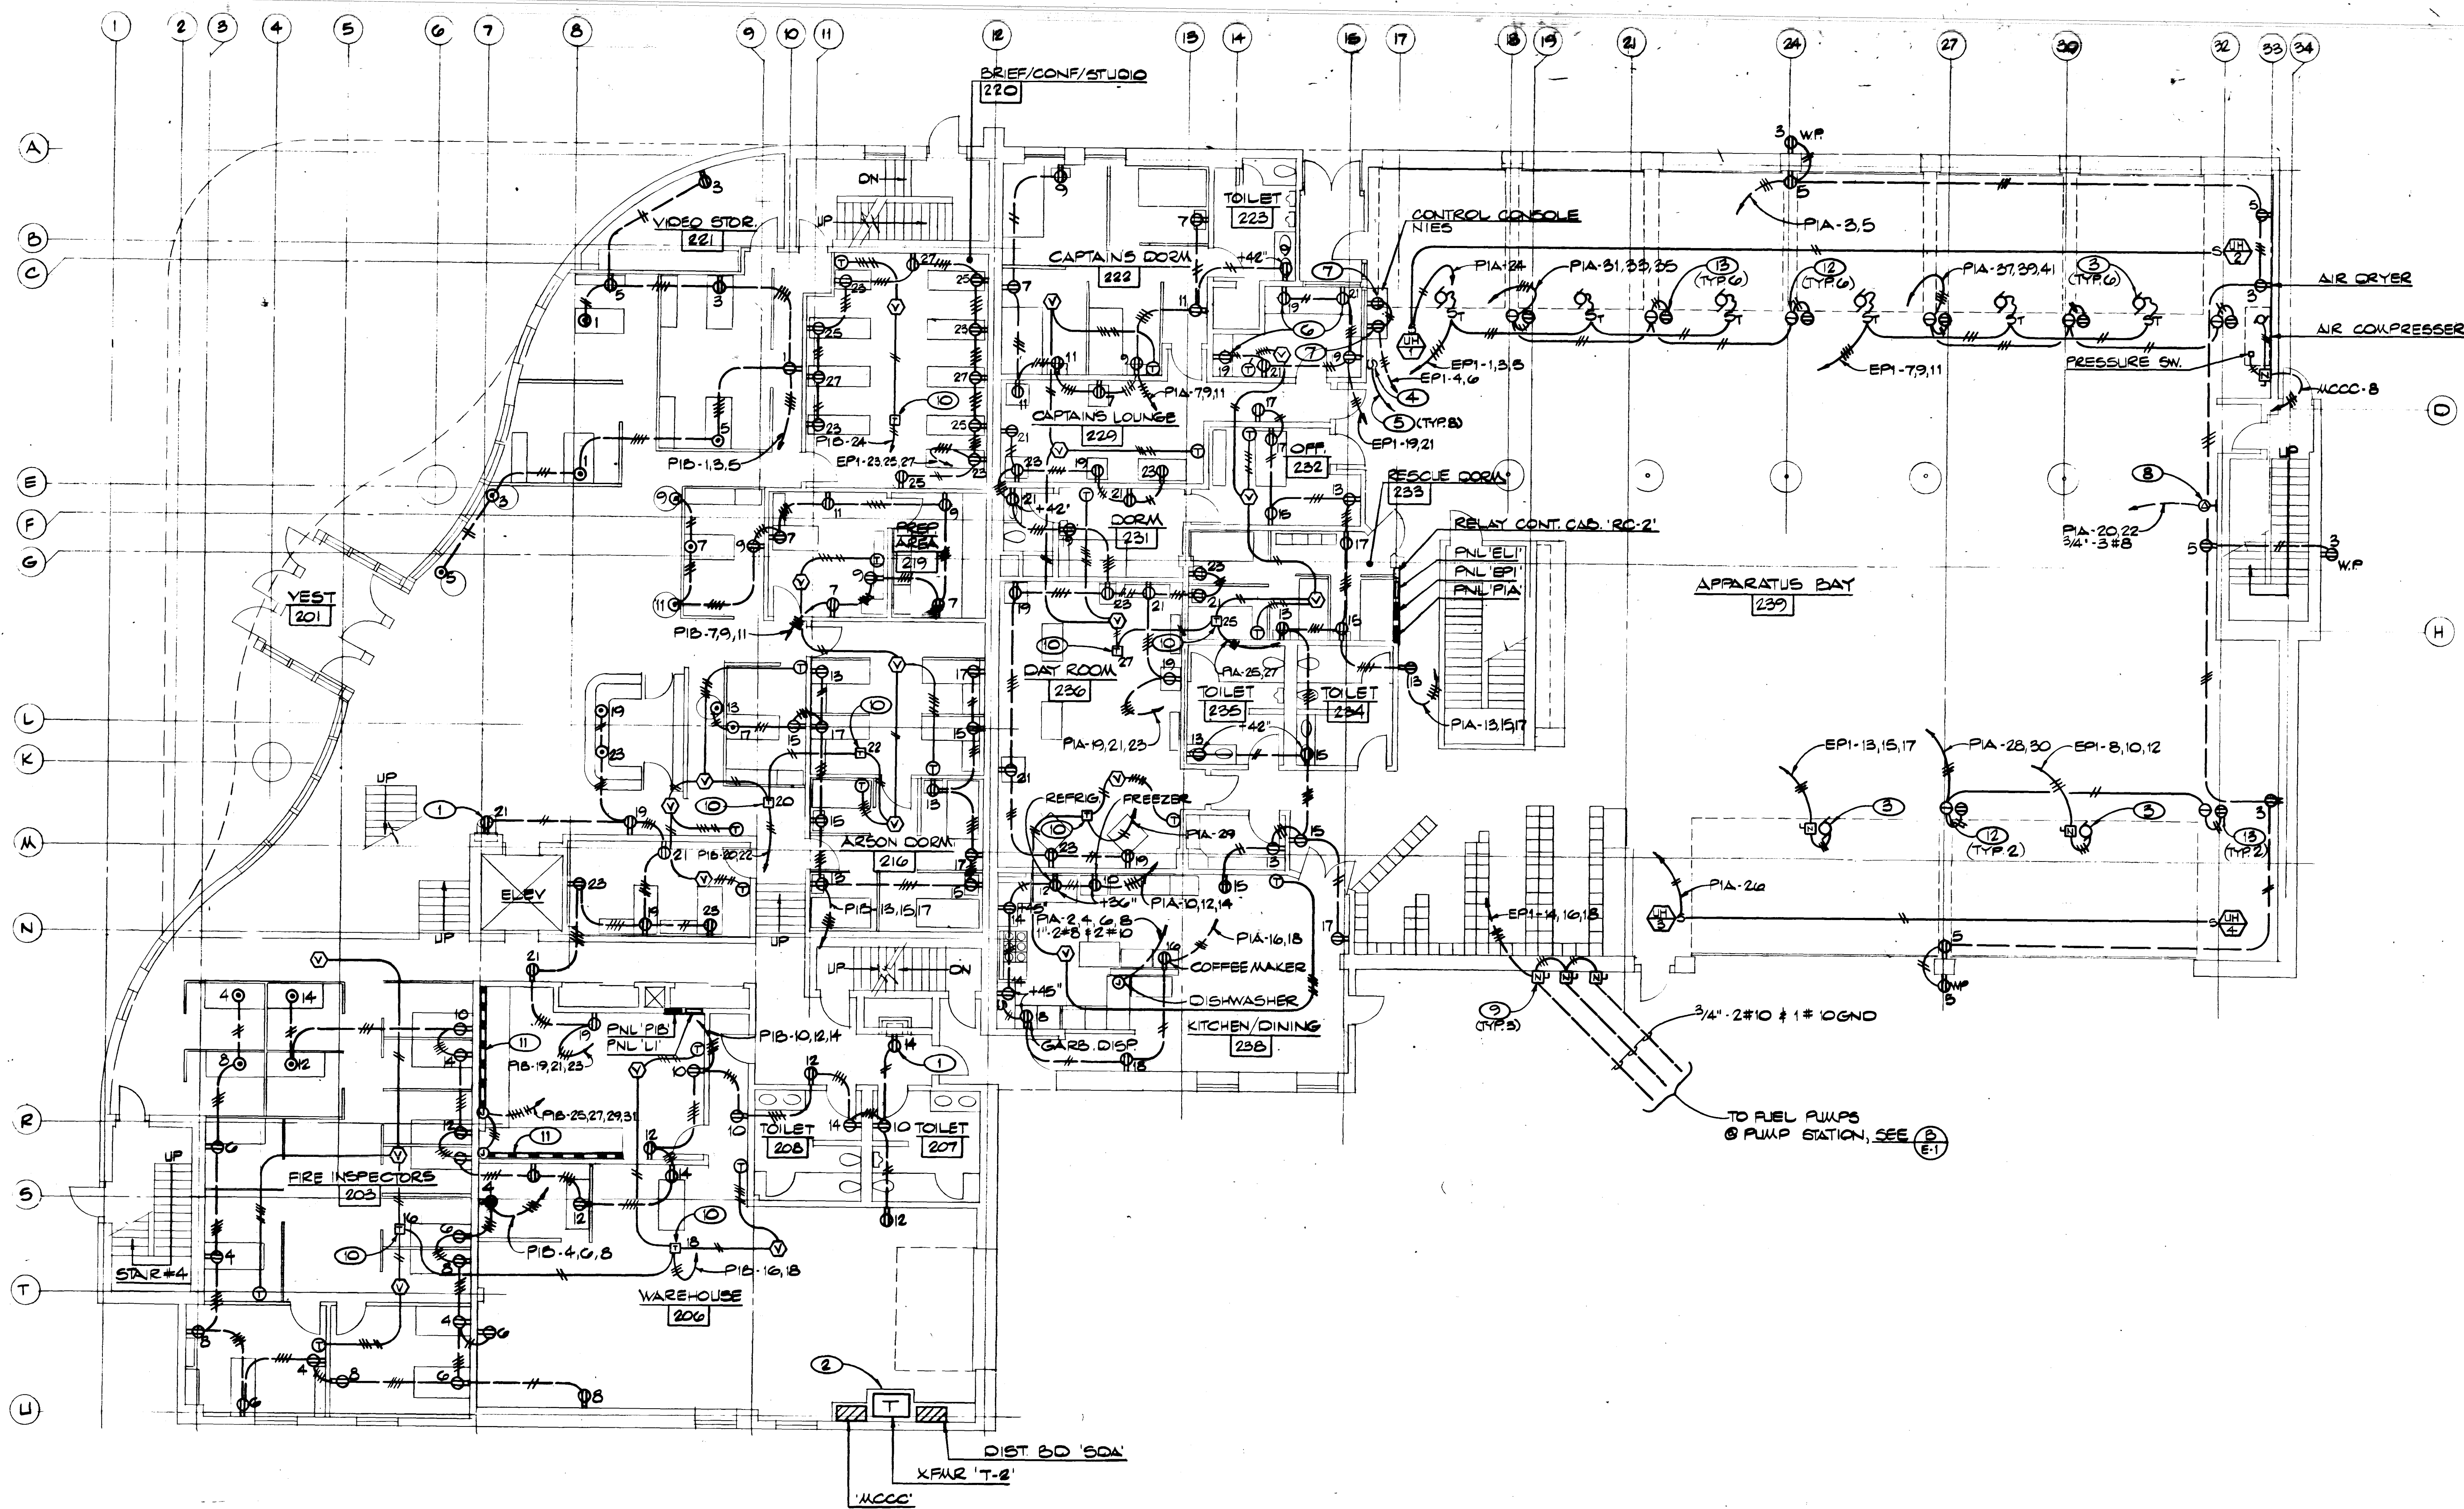


PLAZA LEVEL POWER PLAN

1/8" = 1'-0"

E-7

NOTES (THIS SHEET ONLY)

- 1 CONCEAL IN OR BEHIND E.W.C.
- 2 PROVIDE 4" CONCRETE EQUIP PAD.
- 3 CONNECT TO MOTORIZED DOOR AS REQ'D. VERIFY EXACT REQUIREMENTS W/EQUIP SUPPLIER PRIOR TO ROUGH-IN.
- 4 INSTALL & CONNECT EIGHT MOTORIZED DOOR CONTROLLER SWITCHES AS REQ'D. VERIFY EXACT REQUIREMENTS W/EQUIP SUPPLIER PRIOR TO ROUGH-IN.
- 5 1/2" S#12 TO EACH MOTORIZED DOOR.
- 6 VERIFY EXACT MOUNTING HEIGHT W/ARCH.
- 7 AMPLIFIER RECEIPTS VERIFY MTG. PRIOR TO ROUGH-IN.
- 8 FLUSH OUTLET, 208V, 10, 3W, 50A, NEMA 6-50R
- 9 30A 2P WP DSC SWITCH SURF MTD. 6" x 6" O" ABOVE GRADE W/ENGRAVED NAMEPLATE ON EACH SWITCH TO READ "FUEL PUMP SHUTDOWN". ALL EXPOSED CONDUIT SHALL BE RIGID STEEL W/REQ'D SEAL-OFF FITTINGS, UNIONS, ETC.
- 10 PROVIDE 120V TO 24V, 100VA TRANSFORMER. MOUNT IN ACCESSIBLE CEILING SPACE
- 11 PROVIDE WIRING OLD CO. FLUSHOLD SIMILAR TO 220GA SERIES (TWO CIRCUIT W/GROUNDING CONDUCTOR) W/DUPLEX RECEIPTS 15' O.C. & ALL NECESSARY FITTINGS
- 12 PROVIDE FLUSH MTD. CEILING TWISTLOCK RECEPT. NEMA L5-20 AND SILVER SEALTY MODEL #B210 115V TRICKLE CHARGER W/ CORD CAP TO MATCH RECEPT. FURNISH COMPLETE W/CEILING MTD. BRACKET HARDWARE. CORD REEL W/4IN. 75 FT. CORD & CORD CAP TO MATCH OUTLET ON FIRE EQUIPMENT AS REQ'D. BY LV FIRE DEPT. MOUNT CHARGER AS RECOMMENDED BY EQUIP SUPPLIER.
- 13 PROVIDE FLUSH MTD. CEILING TWISTLOCK RECEPT. NEMA L5-20 AND DANIEL WOODHEAD HEAVY DUTY CORD REEL #964 W/CORD CAP TO MATCH RECEPT. 35 FT. 16/3 SJO CORD & SWIVEL BASE. SECURELY MOUNT TO CEILING AS DIRECTED BY ARCH.

NEED COLE AIA
PATRICK KLEIN AIA
THOMAS SILVA AIA
LEWIS BACON

HARRIS P. SHARP AIA
GERALD R. STEPHENSON AIA
DAVID A. DALEIDA AIA

h&s HARRIS SHARP & ASSOCIATES, INCORPORATED
2915 W. CHARLESTON BLVD. LAS VEGAS, NEVADA 89102 (702) 877-0125
ARCHITECTURE, PLANNING AND INTERIORS

Sheet Title PLAZA LEVEL POWER PLAN
Job Title
Job 482-1
Date 8 NOV 82
Drawn By SMG
Checked WMA
Sheet No. E-7
Of 18
75 of 119

