


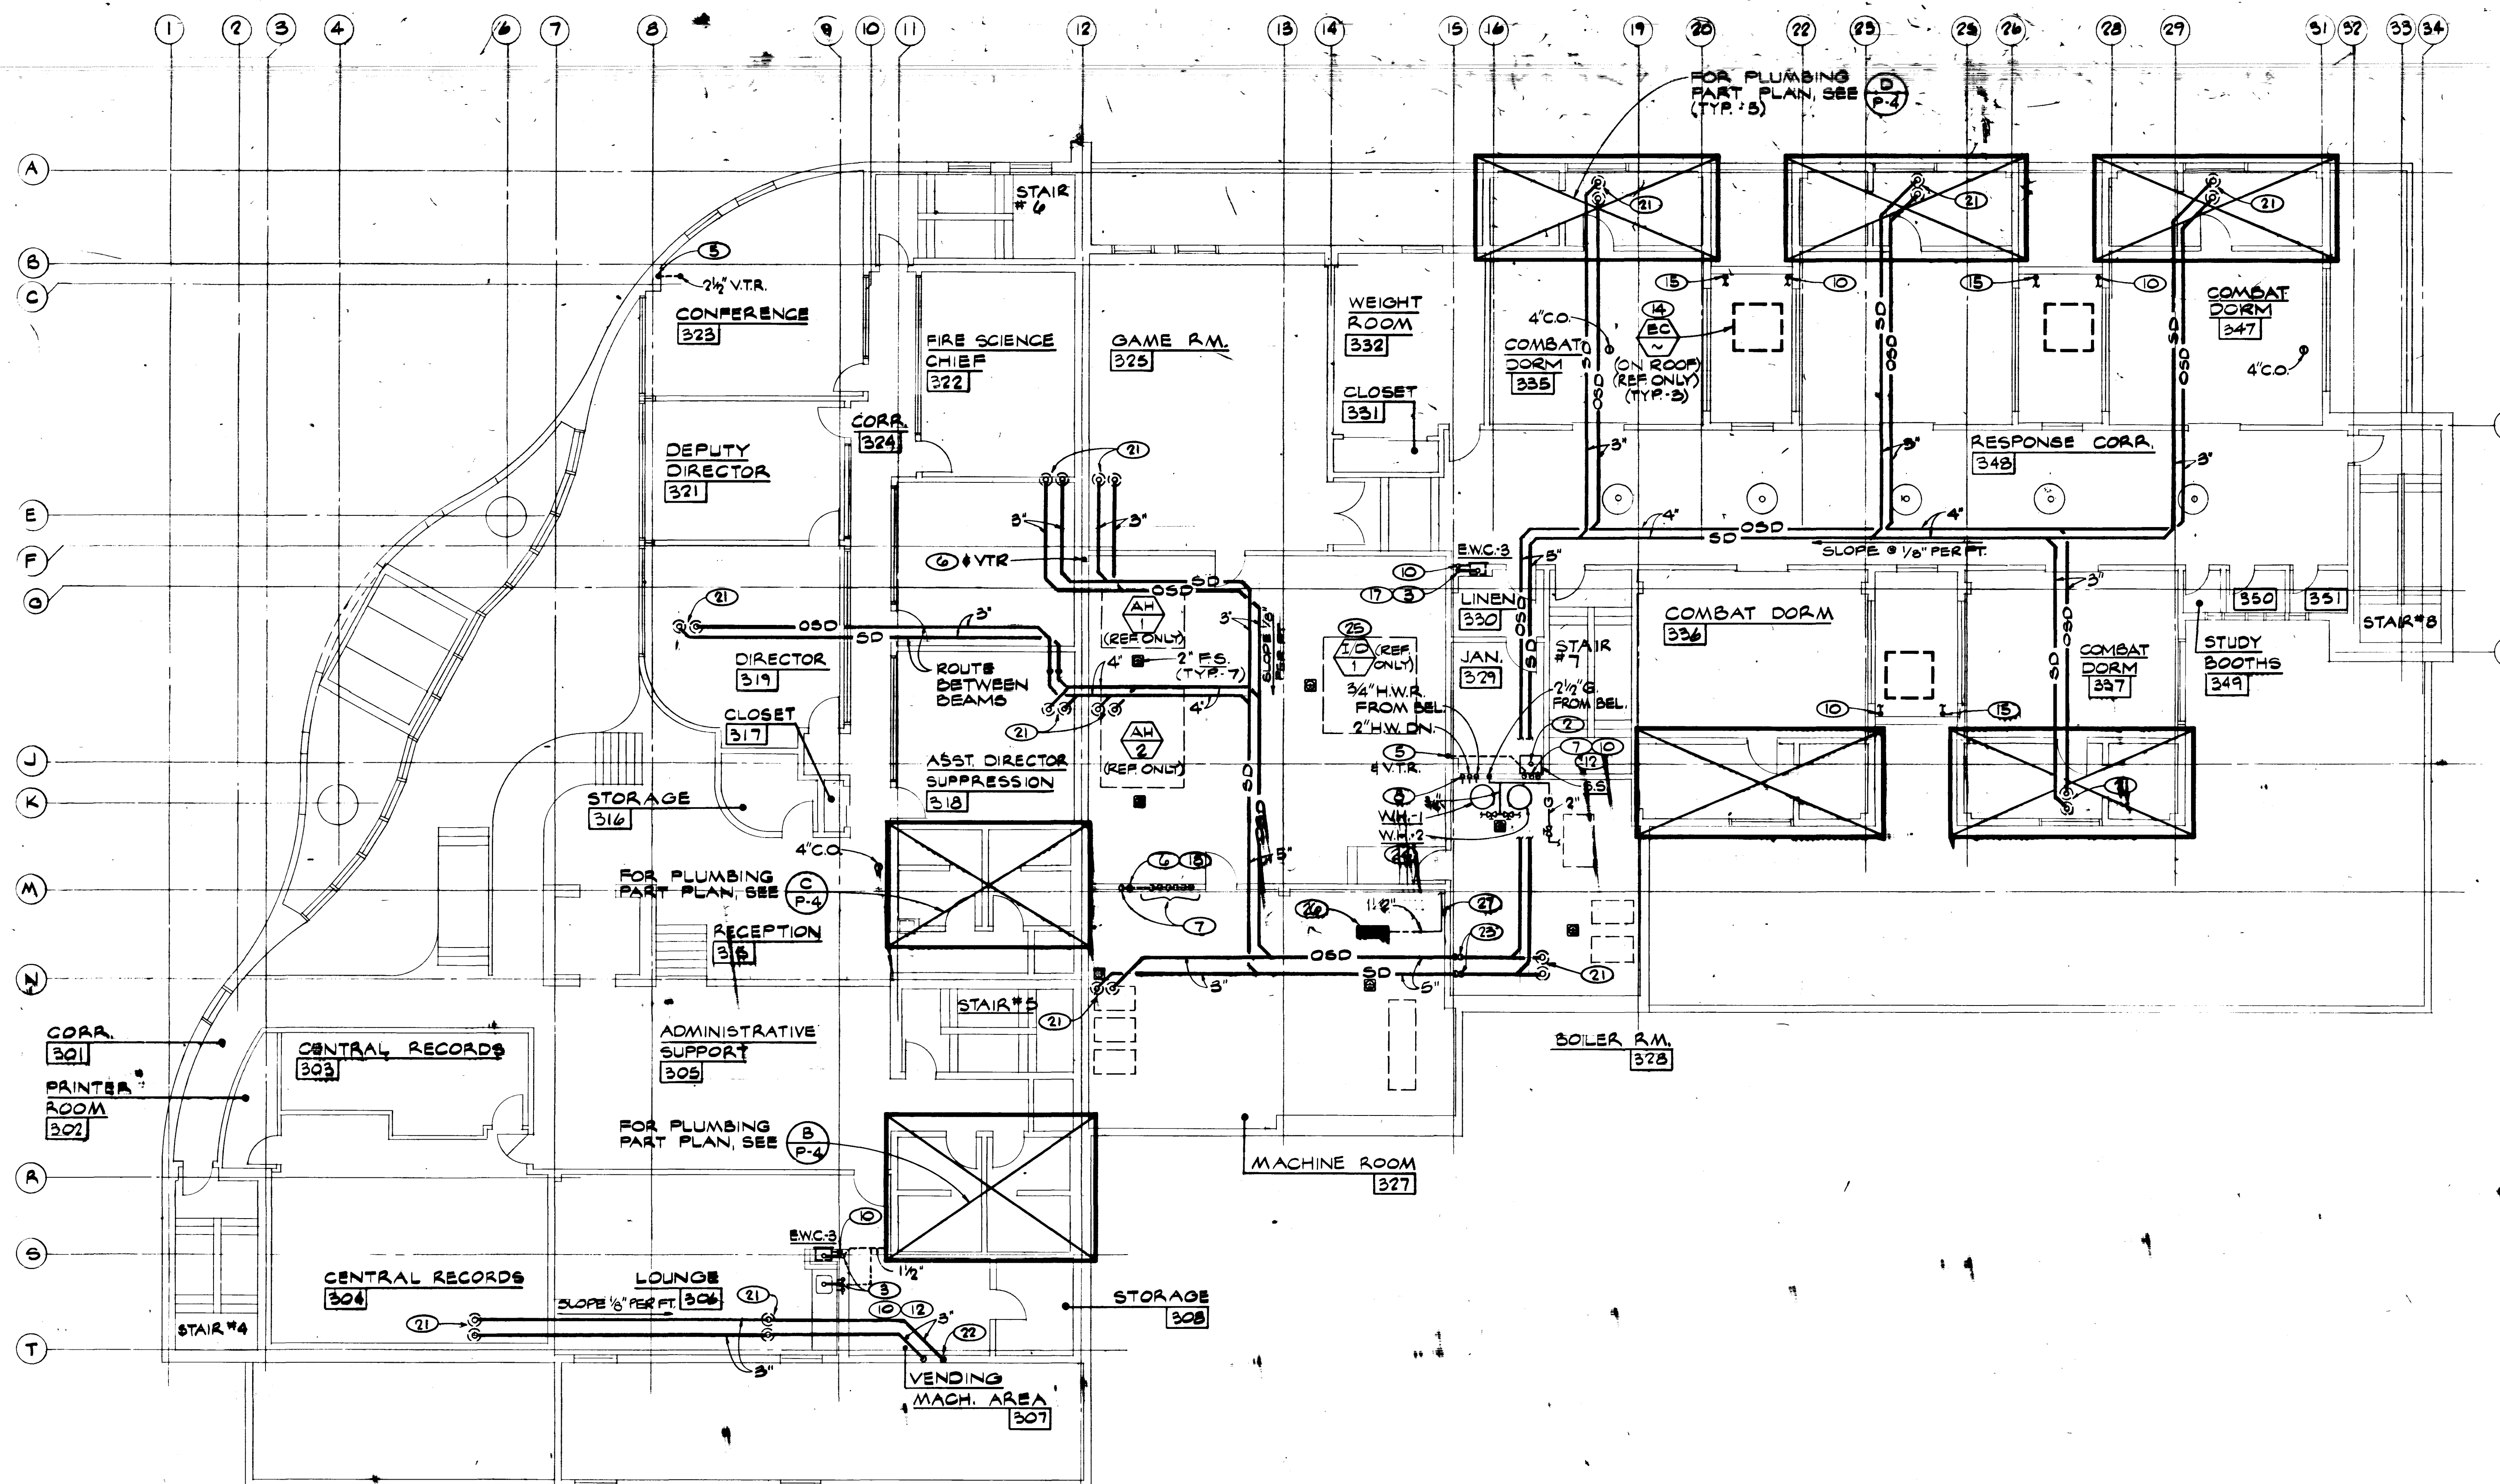


NOTES

- 1 4" S. DN.
- 2 2" W. DN.
- 3 1 1/2" W. DN.
- 4 3" V.T.R.
- 5 2 1/2" V. FROM BEL.
- 6 2" V.
- 7 1 1/2" V.
- 8 2" C.W.
- 9 1 1/2" C.W.
- 10 1/2" C.W.
- 11 3/4" H.W.
- 12 1/2" H.W.
- 13 PROVIDE SOV. ON RISER(S) W/12"x12" A.D.
- 14 FOR C.W. & DRAIN PIPING SEE P-5.
- 15 1" D. DN.
- 16 1 1/2" V. FROM BEL., OCCURS @ TLT. RM. 337 ONLY.
- 17 1 1/2" V.T.R.
- 18 2" V.T.R.
- 19 4" C.P. OCCURS @ TLT. RM. 339 ONLY.
- 20 W.C-1 OCCURS @ TLT. RM. 337 ONLY.
- 21 3" Q + OSD DN. FROM RD + Q.E.D. ADV.
- 22 5" Q + OSD DN. IN WALL.
- 23 5" S.D. + OSD DN.
- 24 SEE DETAIL P-5.
- 25 ROUTE 1" DRAIN & 1" OVERFLOW DRAIN (W/5.O.V. ON DRAIN LINE) FOR BOTH INDIRECT & DIRECT EVAP. COOL SECTION TO OVER F.S. VERIFY EXACT CONN. REQMENTS W/ 1/8" M.F.R.S. APPROVED SHOP DWGS.
- 26 REDUCED PRESSURE BACKFLOW PREVENTER.
- 27 1/2" C.W. FROM BELOW.


SECOND LEVEL FLOOR PLAN

1/8" = 1'-0"

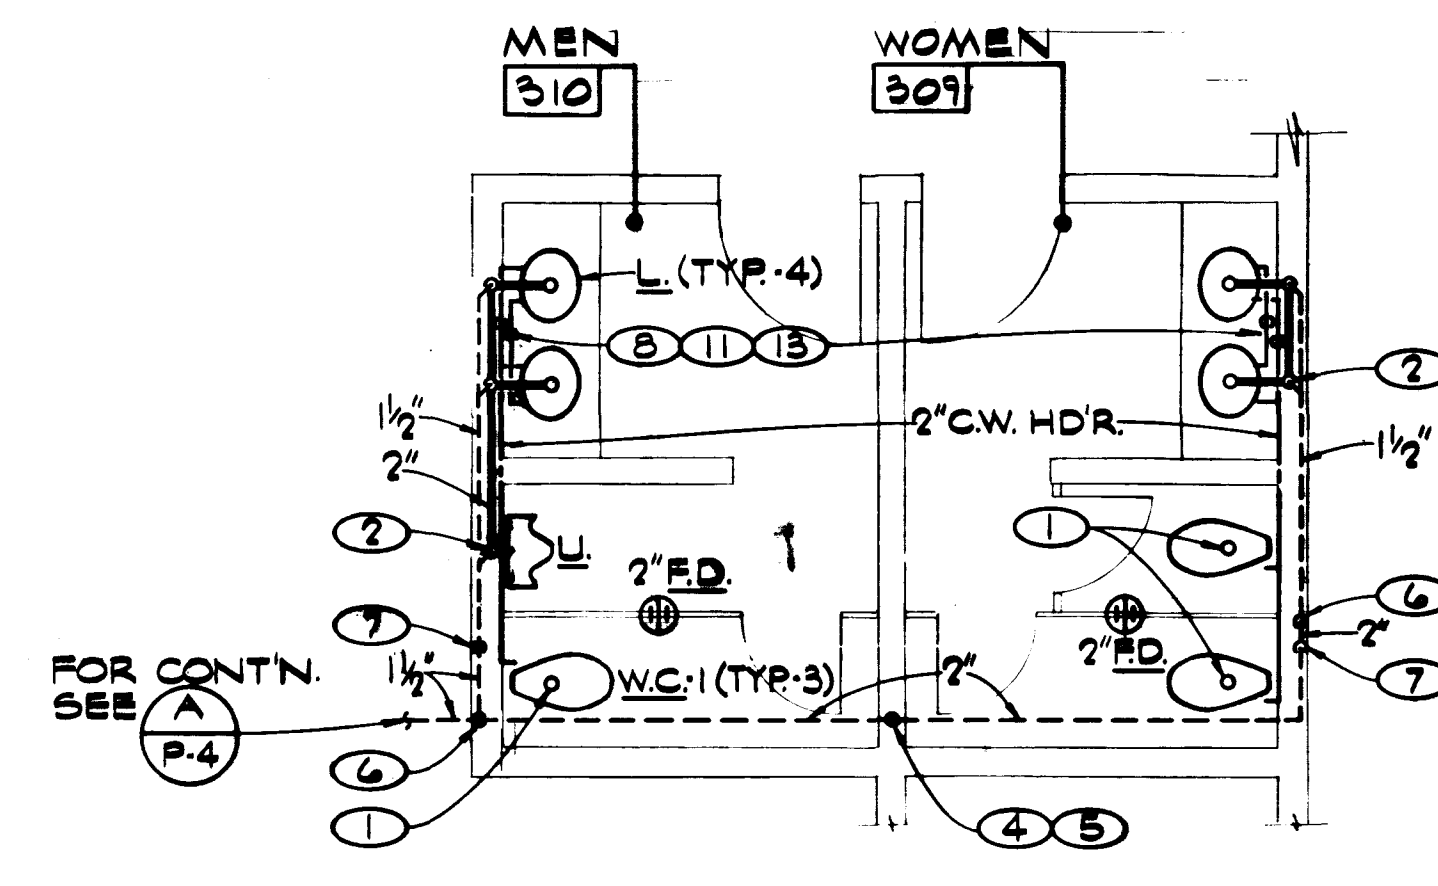


PART PLAN

1/4" = 1'-0"

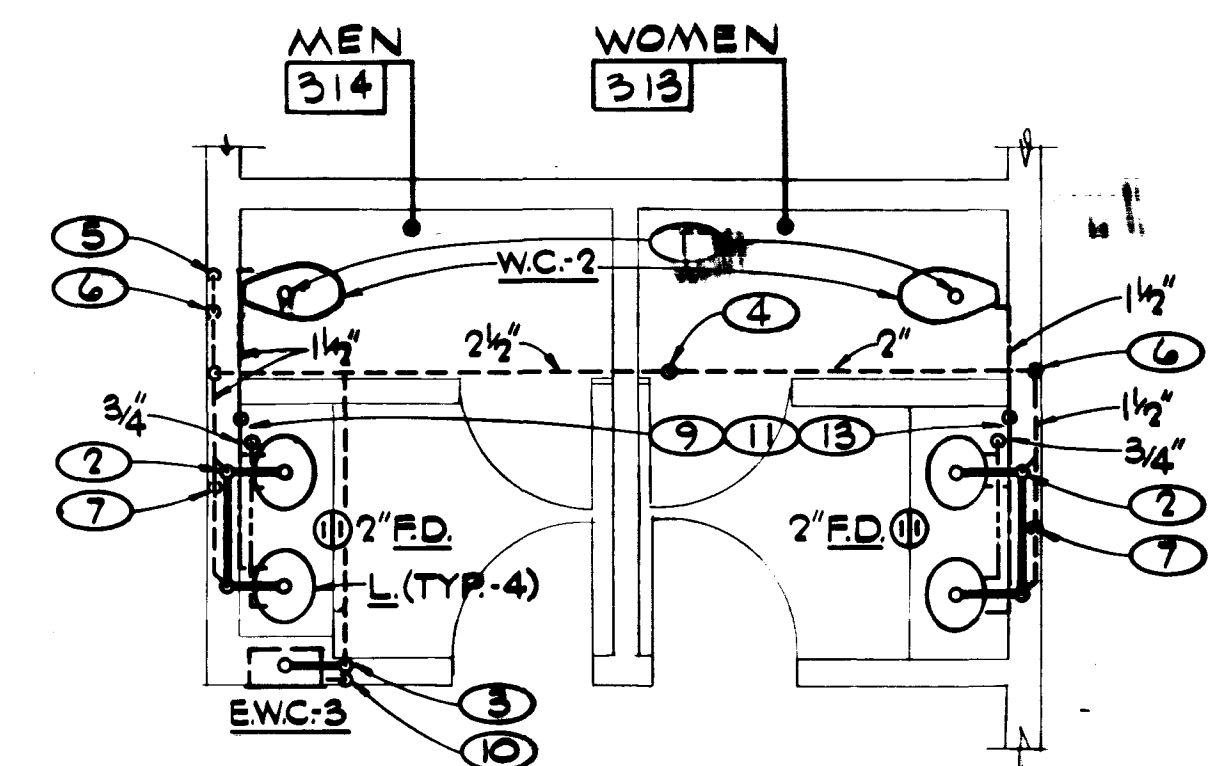

PART PLAN

1/4" = 1'-0"

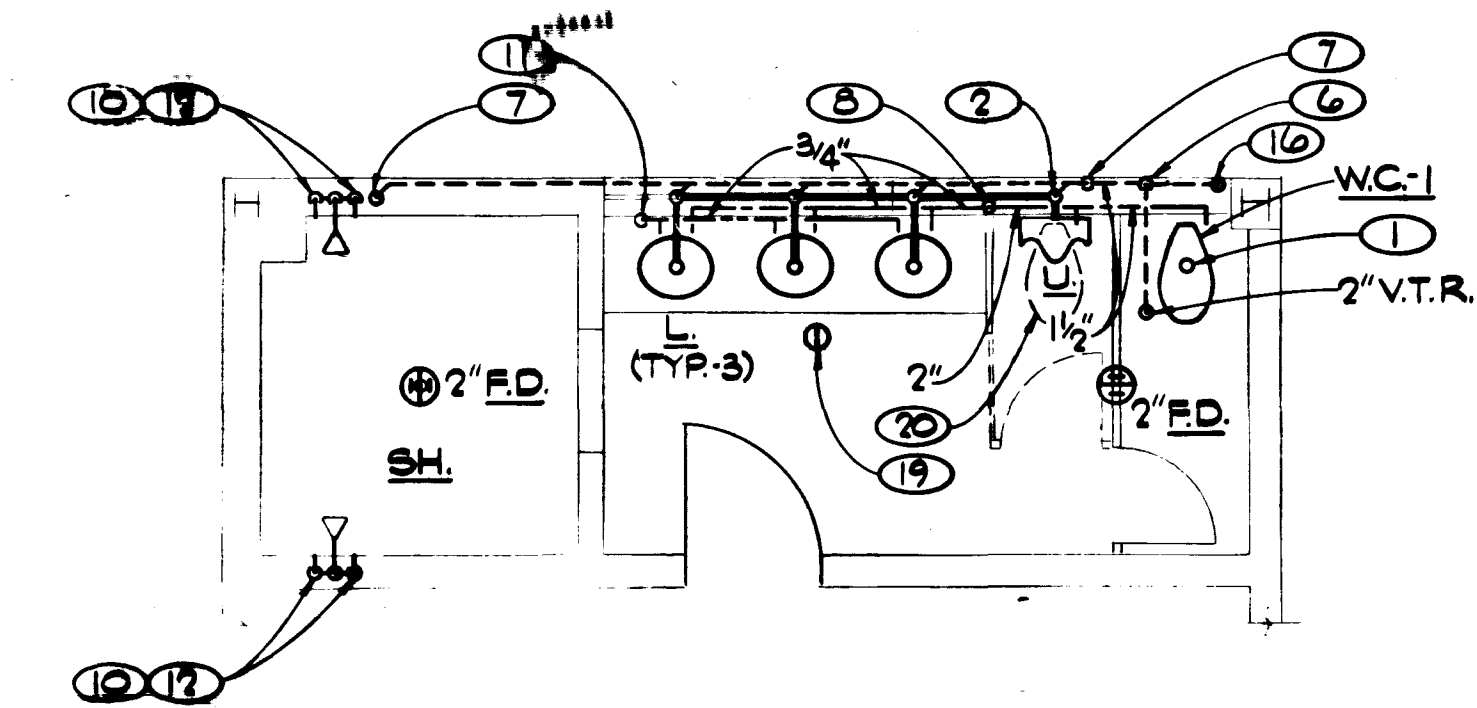

PART PLAN


1/4" = 1'-0"

HS&A HARRIS SHARP & ASSOCIATES, INCORPORATED
 2915W CHARLESTON BLVD. LAS VEGAS, NEVADA 89102 (702) 377-0125
 ARCHITECTURAL PLANNING AND INTERIOR

Sheet Title SECOND LEVEL PLUMBING PLAN
 Job Title
CENTRAL FIRE STATION
 VERIFY ALL DIMENSIONS AND CONDITIONS AT THE SITE

Job 402-1
 Date 8 NOV. 82
 Drawn By DD
 Checked E.F.D.
 Sheet No. P-4
 Of 5
 60 of 119

Dwg. # 630-74

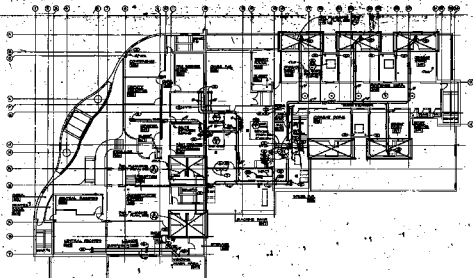

⑦ SECOND LEVEL FLOOR PLAN ⑧



⑦ EAST PLAN ⑧



⑦ EAST PLAN ⑧



⑦ EAST PLAN ⑧

NOTES

- ① 1/4" = 1'
- ② 1/4" = 1'
- ③ 1/4" = 1'
- ④ 1/4" = 1'
- ⑤ 1/4" = 1'
- ⑥ 1/4" = 1'
- ⑦ 1/4" = 1'
- ⑧ 1/4" = 1'
- ⑨ 1/4" = 1'
- ⑩ 1/4" = 1'
- ⑪ 1/4" = 1'
- ⑫ 1/4" = 1'
- ⑬ 1/4" = 1'
- ⑭ 1/4" = 1'
- ⑮ 1/4" = 1'
- ⑯ 1/4" = 1'
- ⑰ 1/4" = 1'
- ⑱ 1/4" = 1'
- ⑲ 1/4" = 1'
- ⑳ 1/4" = 1'
- ㉑ 1/4" = 1'
- ㉒ 1/4" = 1'
- ㉓ 1/4" = 1'
- ㉔ 1/4" = 1'
- ㉕ 1/4" = 1'
- ㉖ 1/4" = 1'
- ㉗ 1/4" = 1'
- ㉘ 1/4" = 1'
- ㉙ 1/4" = 1'
- ㉚ 1/4" = 1'
- ㉛ 1/4" = 1'
- ㉜ 1/4" = 1'
- ㉝ 1/4" = 1'
- ㉞ 1/4" = 1'
- ㉟ 1/4" = 1'
- ㊱ 1/4" = 1'
- ㊲ 1/4" = 1'
- ㊳ 1/4" = 1'
- ㊴ 1/4" = 1'
- ㊵ 1/4" = 1'
- ㊶ 1/4" = 1'
- ㊷ 1/4" = 1'
- ㊸ 1/4" = 1'
- ㊹ 1/4" = 1'
- ㊺ 1/4" = 1'
- ㊻ 1/4" = 1'
- ㊼ 1/4" = 1'
- ㊽ 1/4" = 1'
- ㊾ 1/4" = 1'
- ㊿ 1/4" = 1'

NOTES
 1. THIS SET IS NOT TO BE USED FOR CONSTRUCTION.
 2. THIS SET IS NOT TO BE USED FOR CONSTRUCTION.
 3. THIS SET IS NOT TO BE USED FOR CONSTRUCTION.

CENTRAL FIRE STATION