



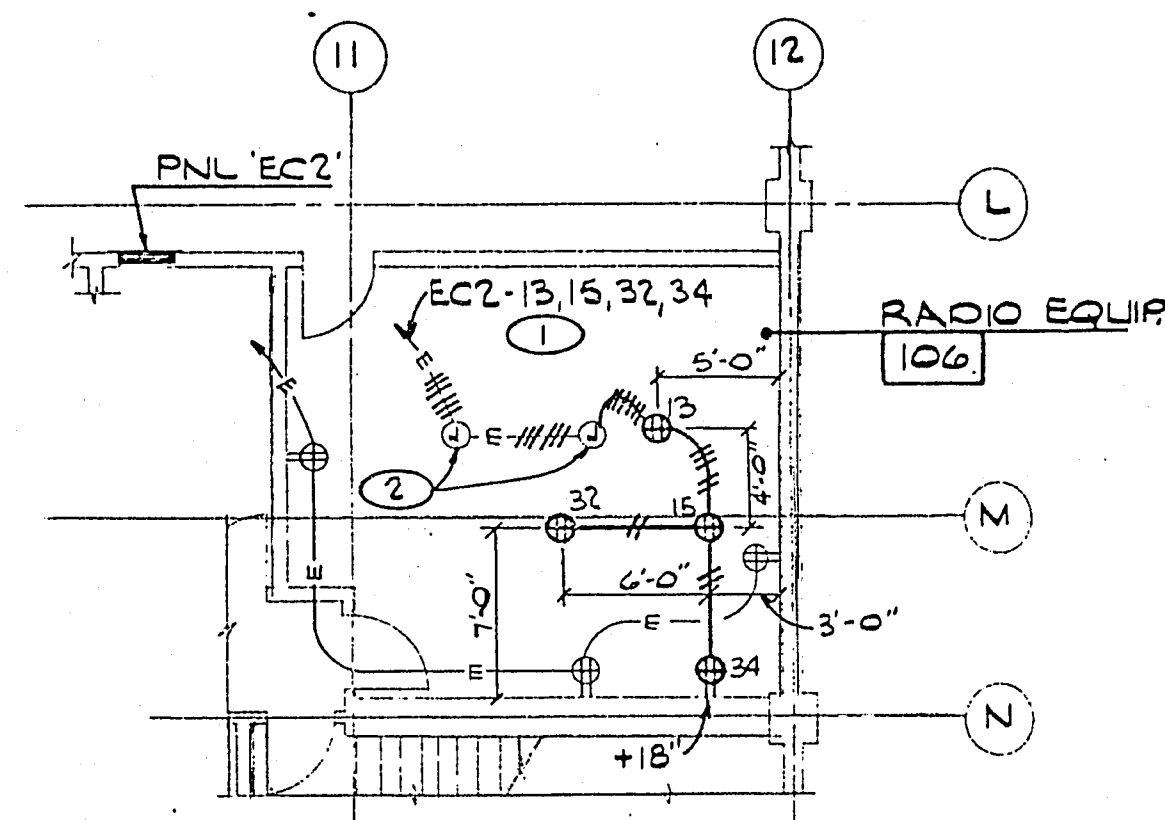

NOTES

- ① PROVIDE 1P 20A. C.B. IN EXIST SPACE FOR NEW CKTS AS INDICATED.
- ② REMOVE DBL DUPLEX, PROVIDE BLANK COVER PLATES AND PROVIDE NEW OUTLETS AS INDICATED.

JOB TITLE: CENTRAL FIRE STATION		SHEET TITLE: COMMUNICATION LEVEL- POWER PART PLAN	
HARRIS SHARP & ASSOC., INC. ARCHITECTURE-PLANNING-INTERIORS 2915 W. CHARLESTON BLVD. LAS VEGAS, NEVADA 89102 (702) 877-0125	JOB No. 482-1	DATE 2-8-84	SHEET No. Q-46
	DRAWN RWM	CHECKED G.C.	

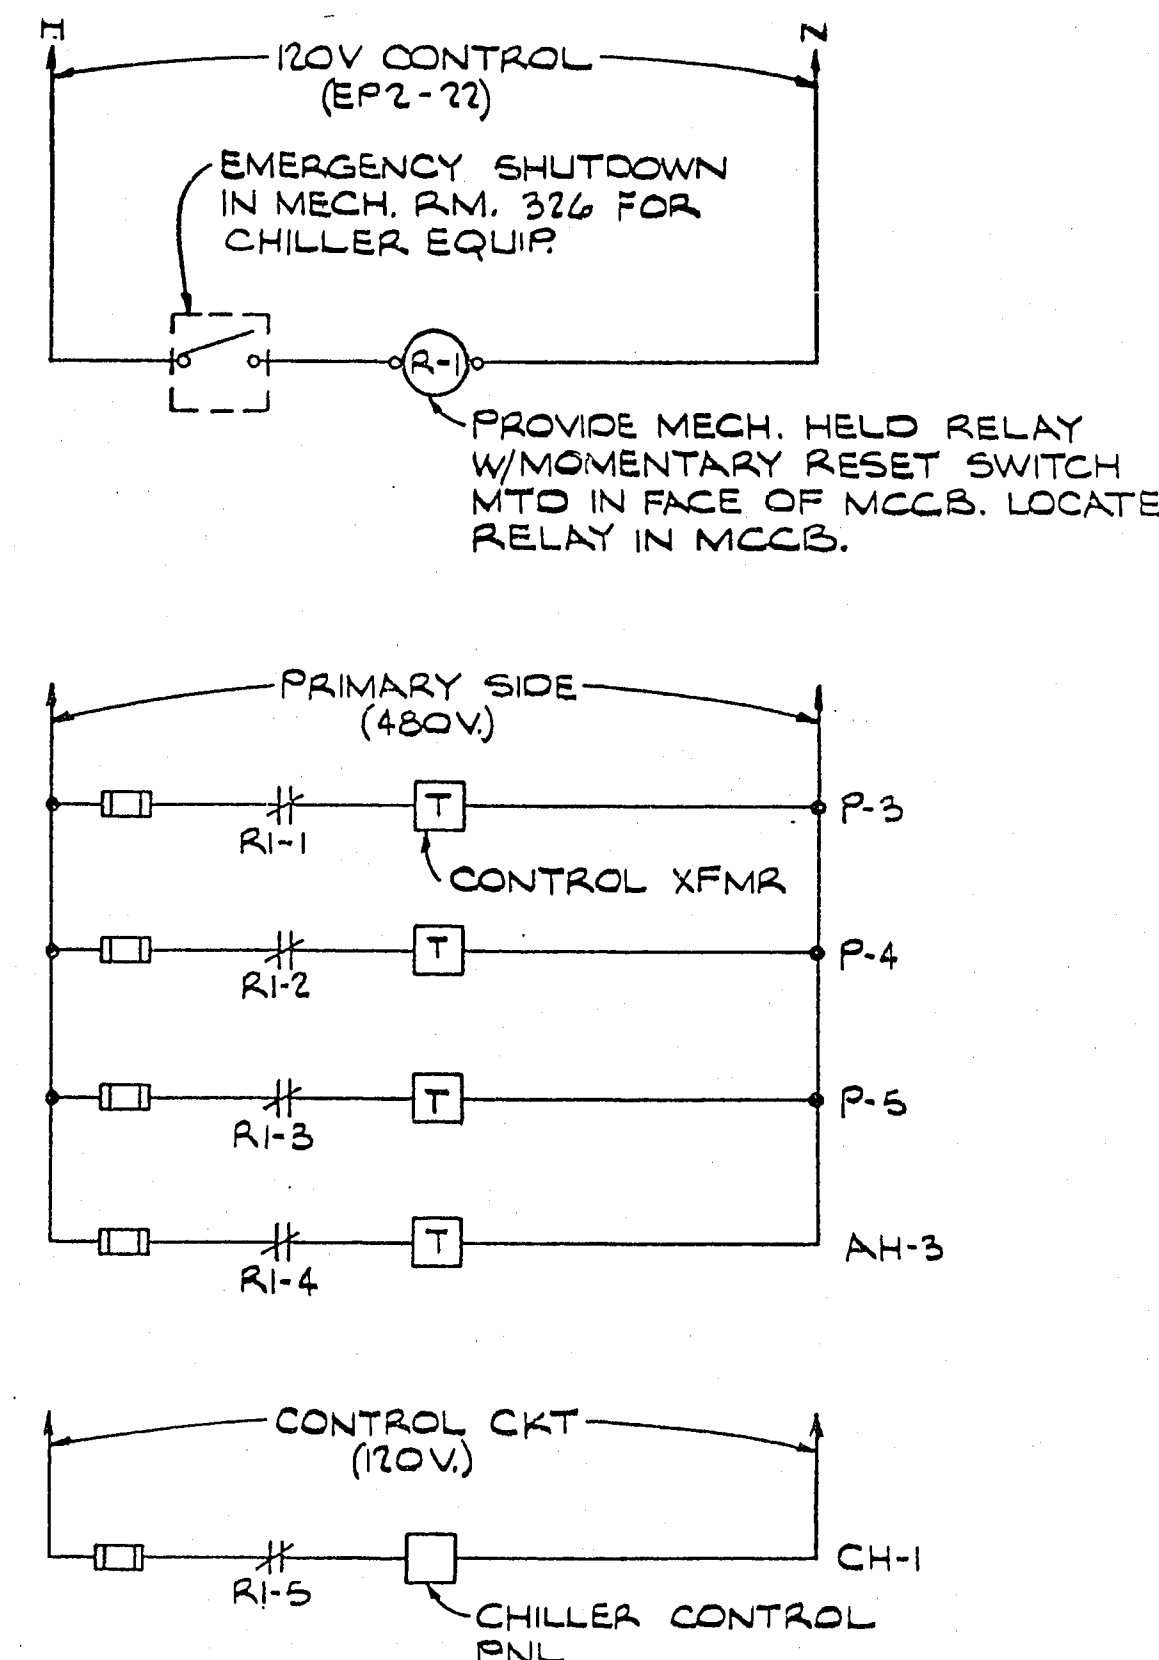

JOB TITLE: CENTRAL FIRE STATION		SHEET TITLE: CHILLER EQUIP EMERG. SHUTDOWN CONTROL DIAGRAM	
HARRIS SHARP & ASSOC., INC. ARCHITECTURE-PLANNING-INTERIORS 2915 W. CHARLESTON BLVD. LAS VEGAS, NEVADA 89102 (702) 877-0125	JOB No. 482-1	DATE 2-8-84	SHEET No. Q-47
	DRAWN RWM	CHECKED G.C.	

		Department of Public Works		Engineering Design Division															
CENTRAL FIRE STATION		REVISIONS		AND/OR		CLARIFICATION		Scale (h)		Scale (v)		W.A.							
								Fid. bk. no.		Date									
								Design by		Drawn by									