



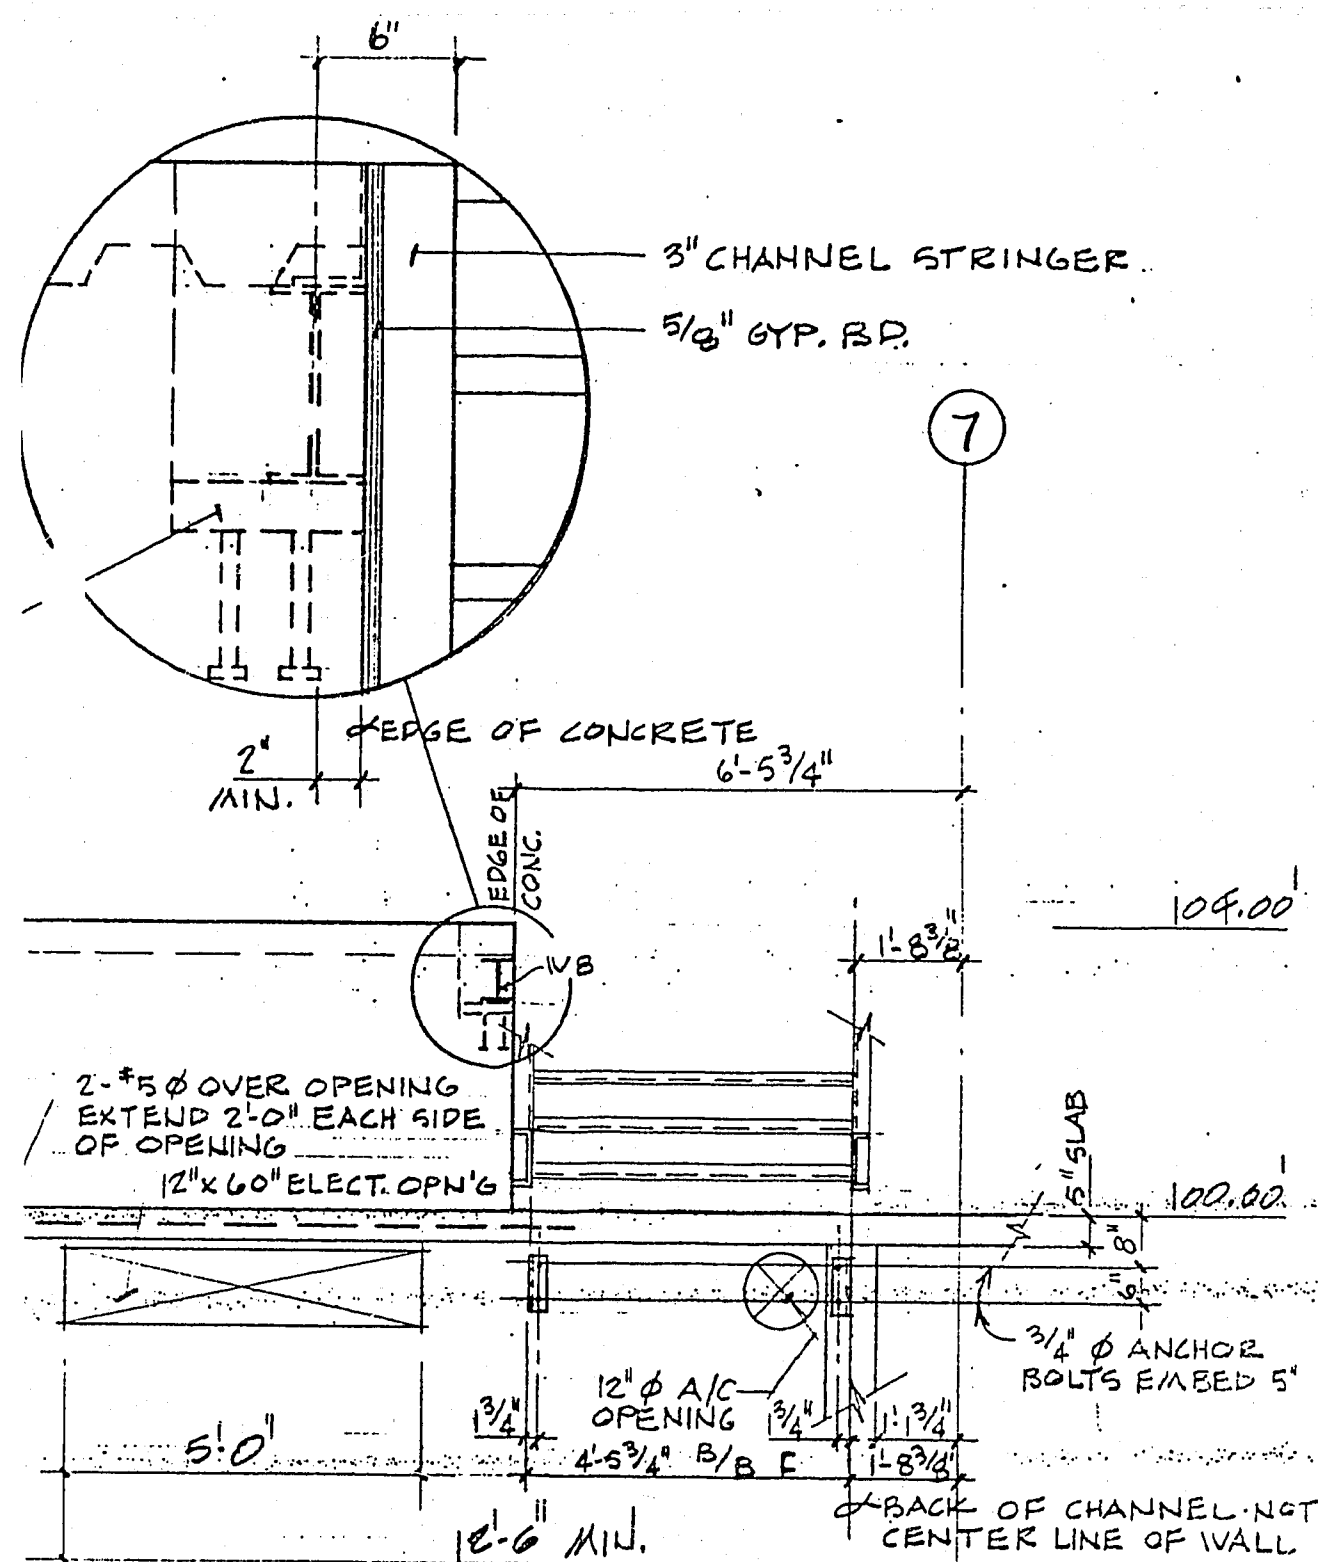


PENETRATIONS @ COLUMN LINE 'N' IN
 CONCRETE WALL (COMMUNICATIONS LEVEL)


SHEET TITLE: CENTRAL FIRE STATION		SHEET TITLE: WALL ELEVATION @ COL. LINE N7	
HARRIS SHARP & ASSOC., INC. ARCHITECTURE-PLANNING-INTERIORS 2915 W. CHARLESTON BLVD. LAS VEGAS, NEVADA 89102 (702) 877-0125	JOB No. 482-1	DATE 3-28-83	SHEET No. Q-14
DRAWN H.S.	CHECKED H.C.		

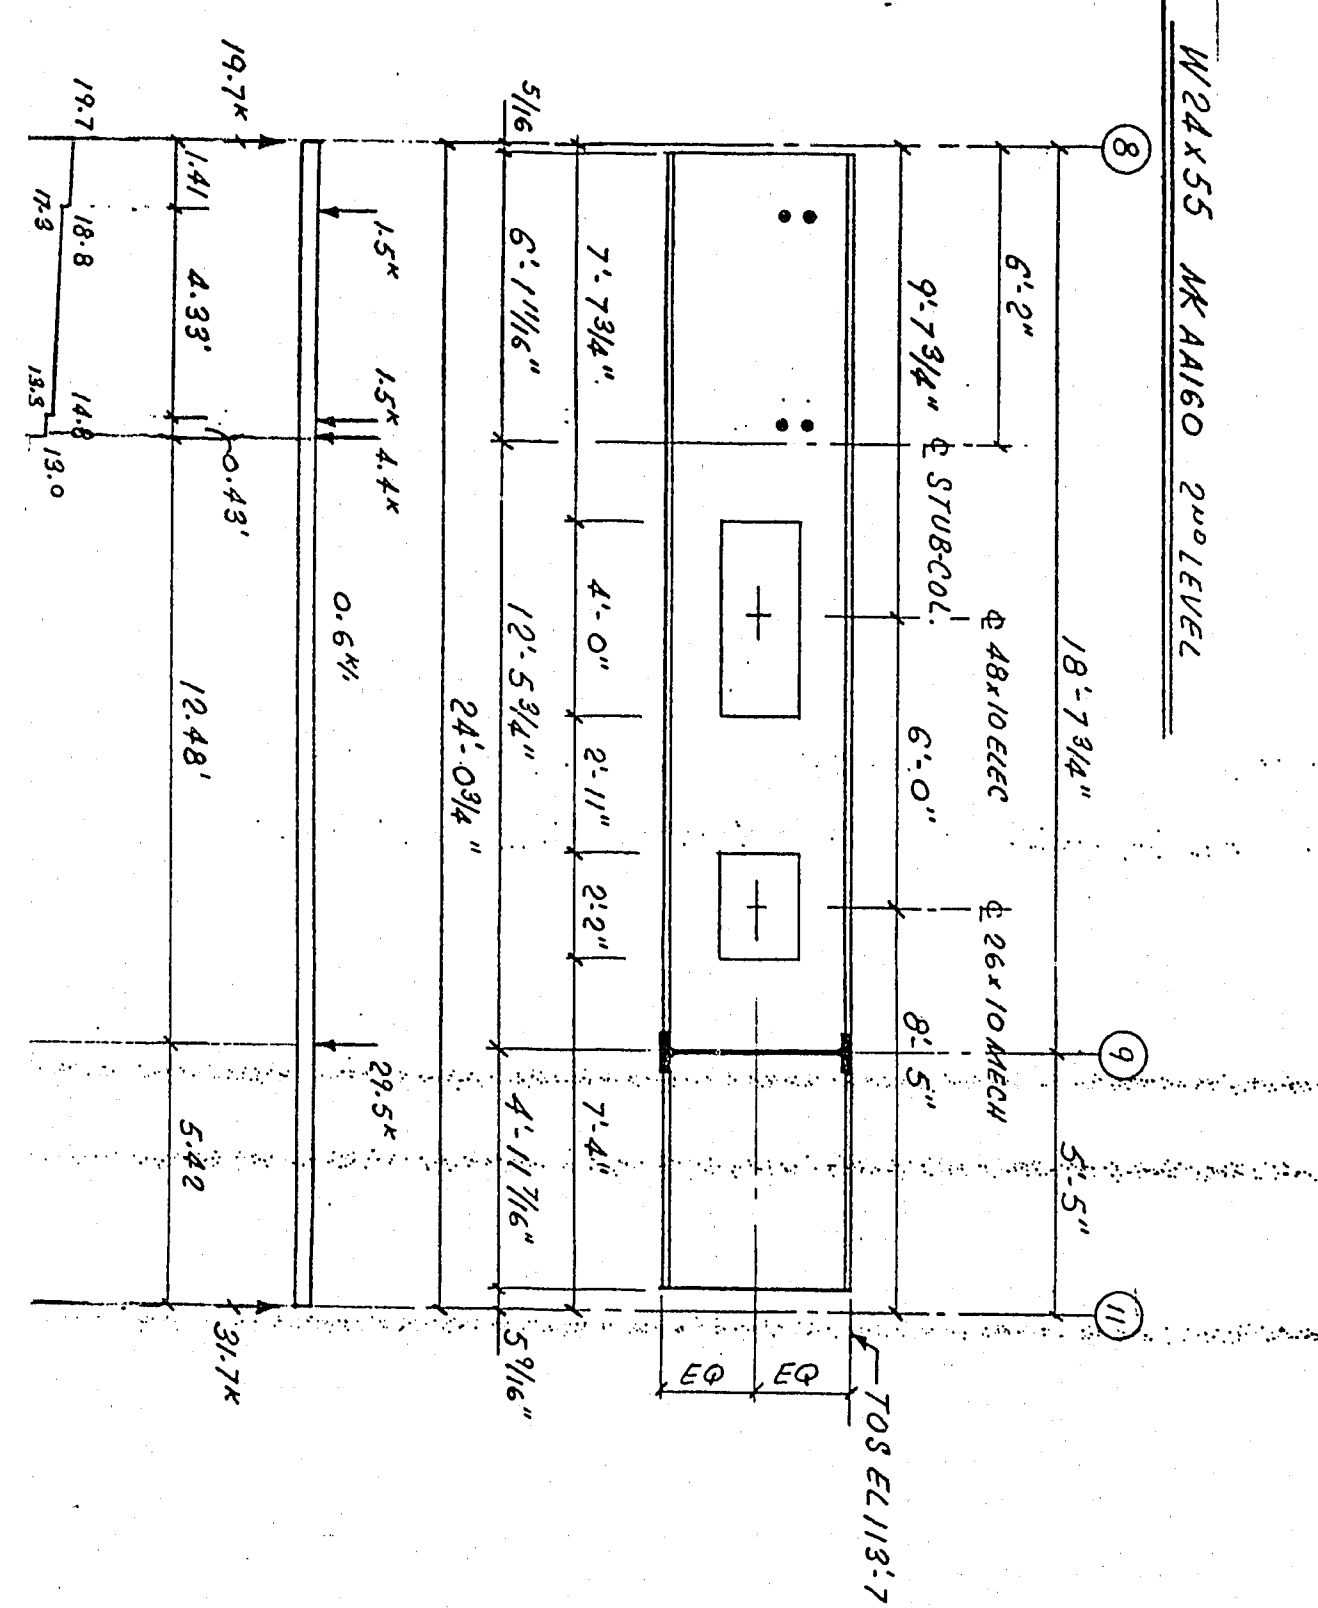

SHEET TITLE: CENTRAL FIRE STATION		SHEET TITLE: WALL ELEVATION @ COL. LINE N7	
HARRIS SHARP & ASSOC., INC. ARCHITECTURE-PLANNING-INTERIORS 2915 W. CHARLESTON BLVD. LAS VEGAS, NEVADA 89102 (702) 877-0125	JOB No. 482-1	DATE 3-28-83	SHEET No. Q-17
DRAWN H.S.	CHECKED H.C.		

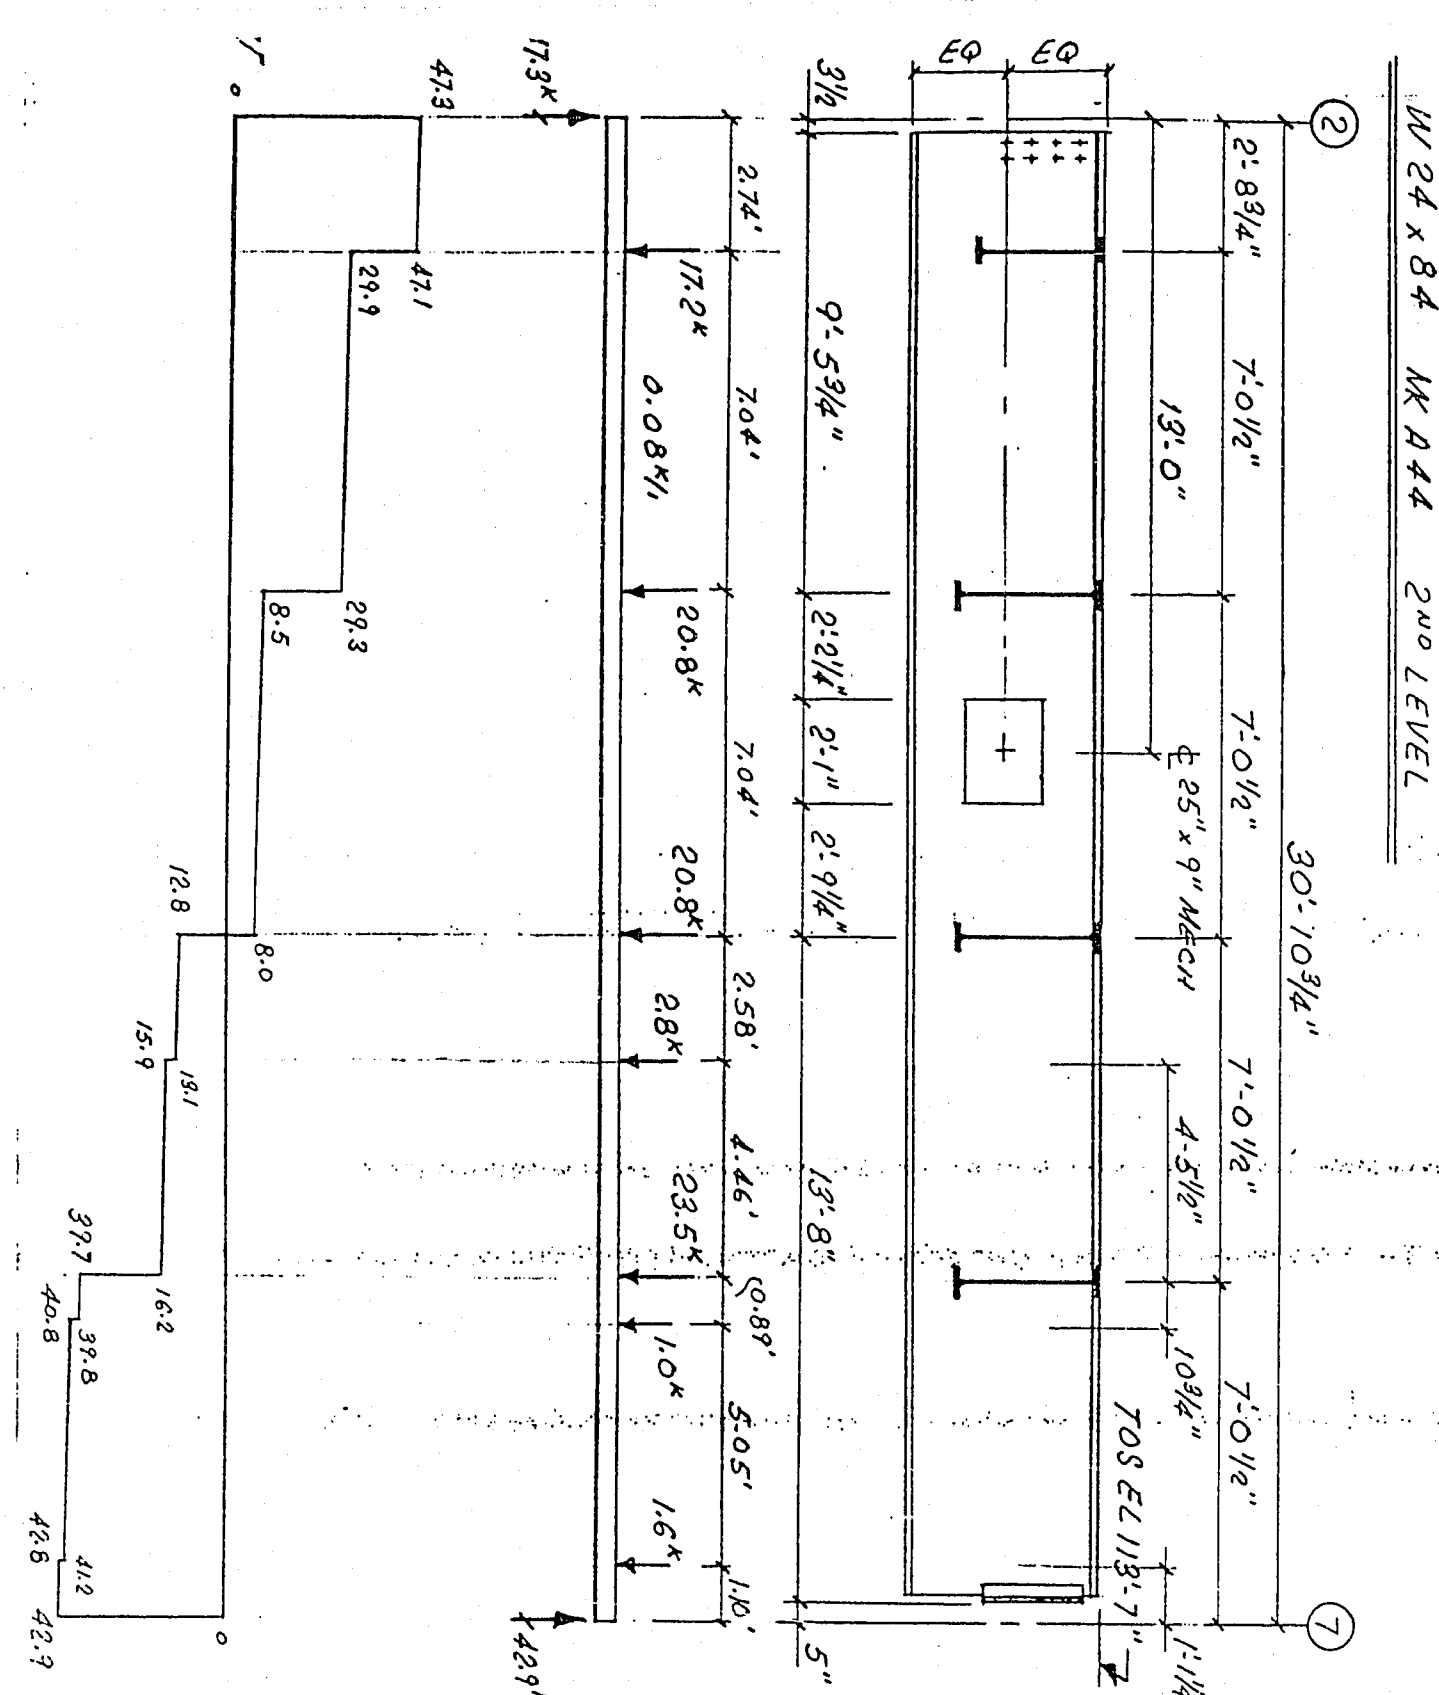

SHEET TITLE: CENTRAL FIRE STATION		SHEET TITLE: WALL ELEVATION @ COL. LINE N7	
HARRIS SHARP & ASSOC., INC. ARCHITECTURE-PLANNING-INTERIORS 2915 W. CHARLESTON BLVD. LAS VEGAS, NEVADA 89102 (702) 877-0125	JOB No. 482-1	DATE 3-28-83	SHEET No. Q-15
DRAWN H.S.	CHECKED H.C.		

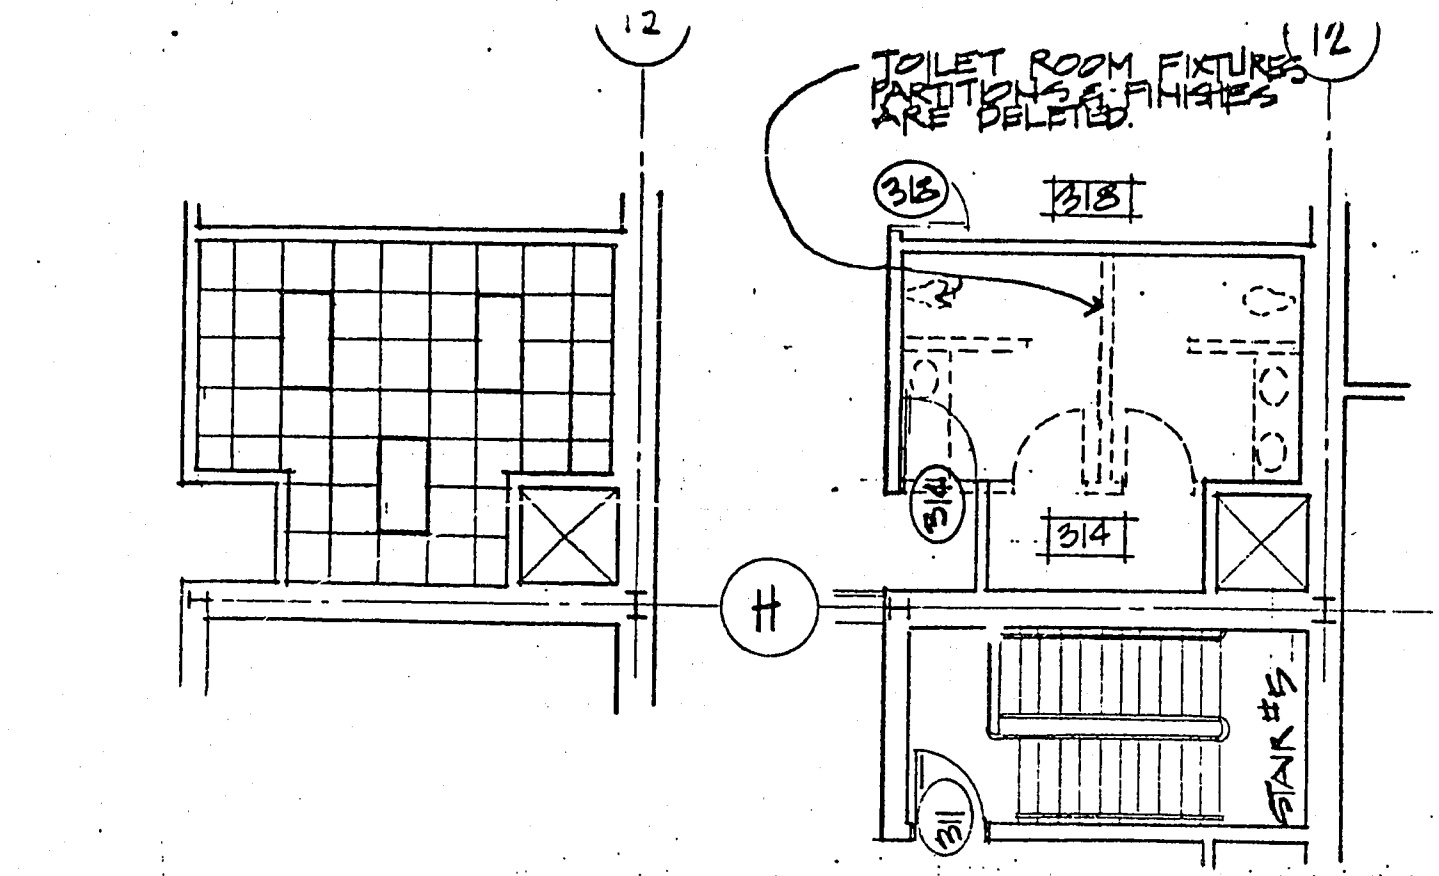

REFLECTED CEILING PLAN
 1/8" = 1'-0"

FLOOR PLAN
 1/8" = 1'-0"

REVISED ROOM FINISH
 SCHEDULE 1

FLOOR - HOLLYTEX, GOLDEN GATE PARK 40, #B341-340 TOASTED ALMOND


CEILING - BURR ACOUSTIC TILE, ARMSTRONG CORTEGA PARCHMENT

WALLS - PAINT, AMERITONE #291 F - CEREAL


BASE - RUBBER, BURKE #602 P

NOTE -
 1. DOOR NUMBER 314 TO MATCH DOOR NUMBER 313, INCL. FINISH HARDWARE

SHEET TITLE: CENTRAL FIRE SERVICES		SHEET TITLE: TOILET ROOM REVISIONS	
HARRIS SHARP & ASSOC., INC. ARCHITECTURE-PLANNING-INTERIORS 2915 W. CHARLESTON BLVD. LAS VEGAS, NEVADA 89102 (702) 877-0125	JOB No. 482-1	DATE 3-28-83	SHEET No. Q-18
DRAWN H.S.	CHECKED H.C.		

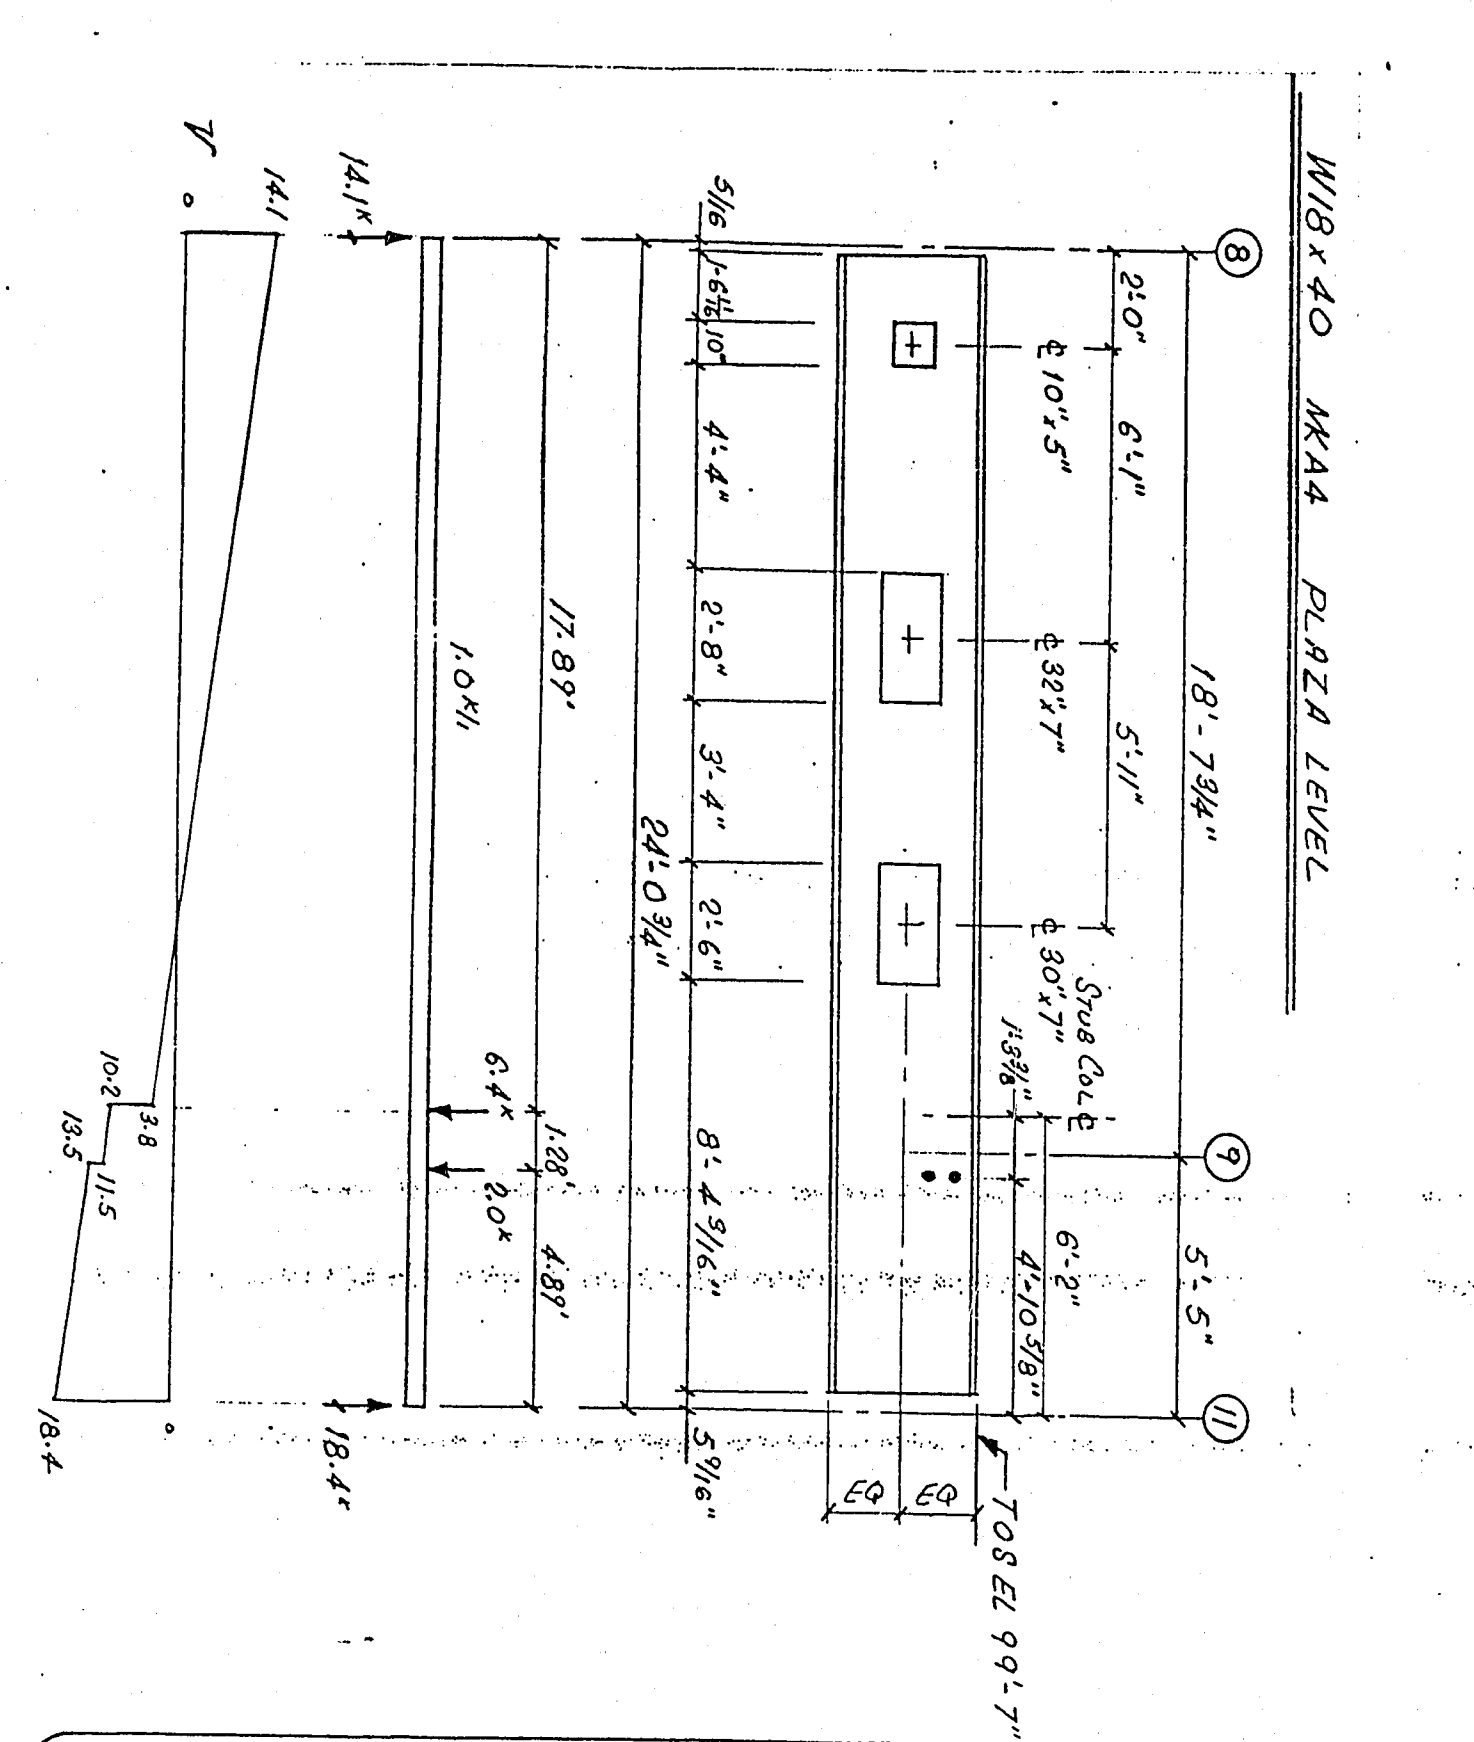


SHEET TITLE: CENTRAL FIRE STATION		SHEET TITLE: WALL ELEVATION @ COL. LINE N7	
HARRIS SHARP & ASSOC., INC. ARCHITECTURE-PLANNING-INTERIORS 2915 W. CHARLESTON BLVD. LAS VEGAS, NEVADA 89102 (702) 877-0125	JOB No. 482-1	DATE 3-28-83	SHEET No. Q-16
DRAWN H.S.	CHECKED H.C.		

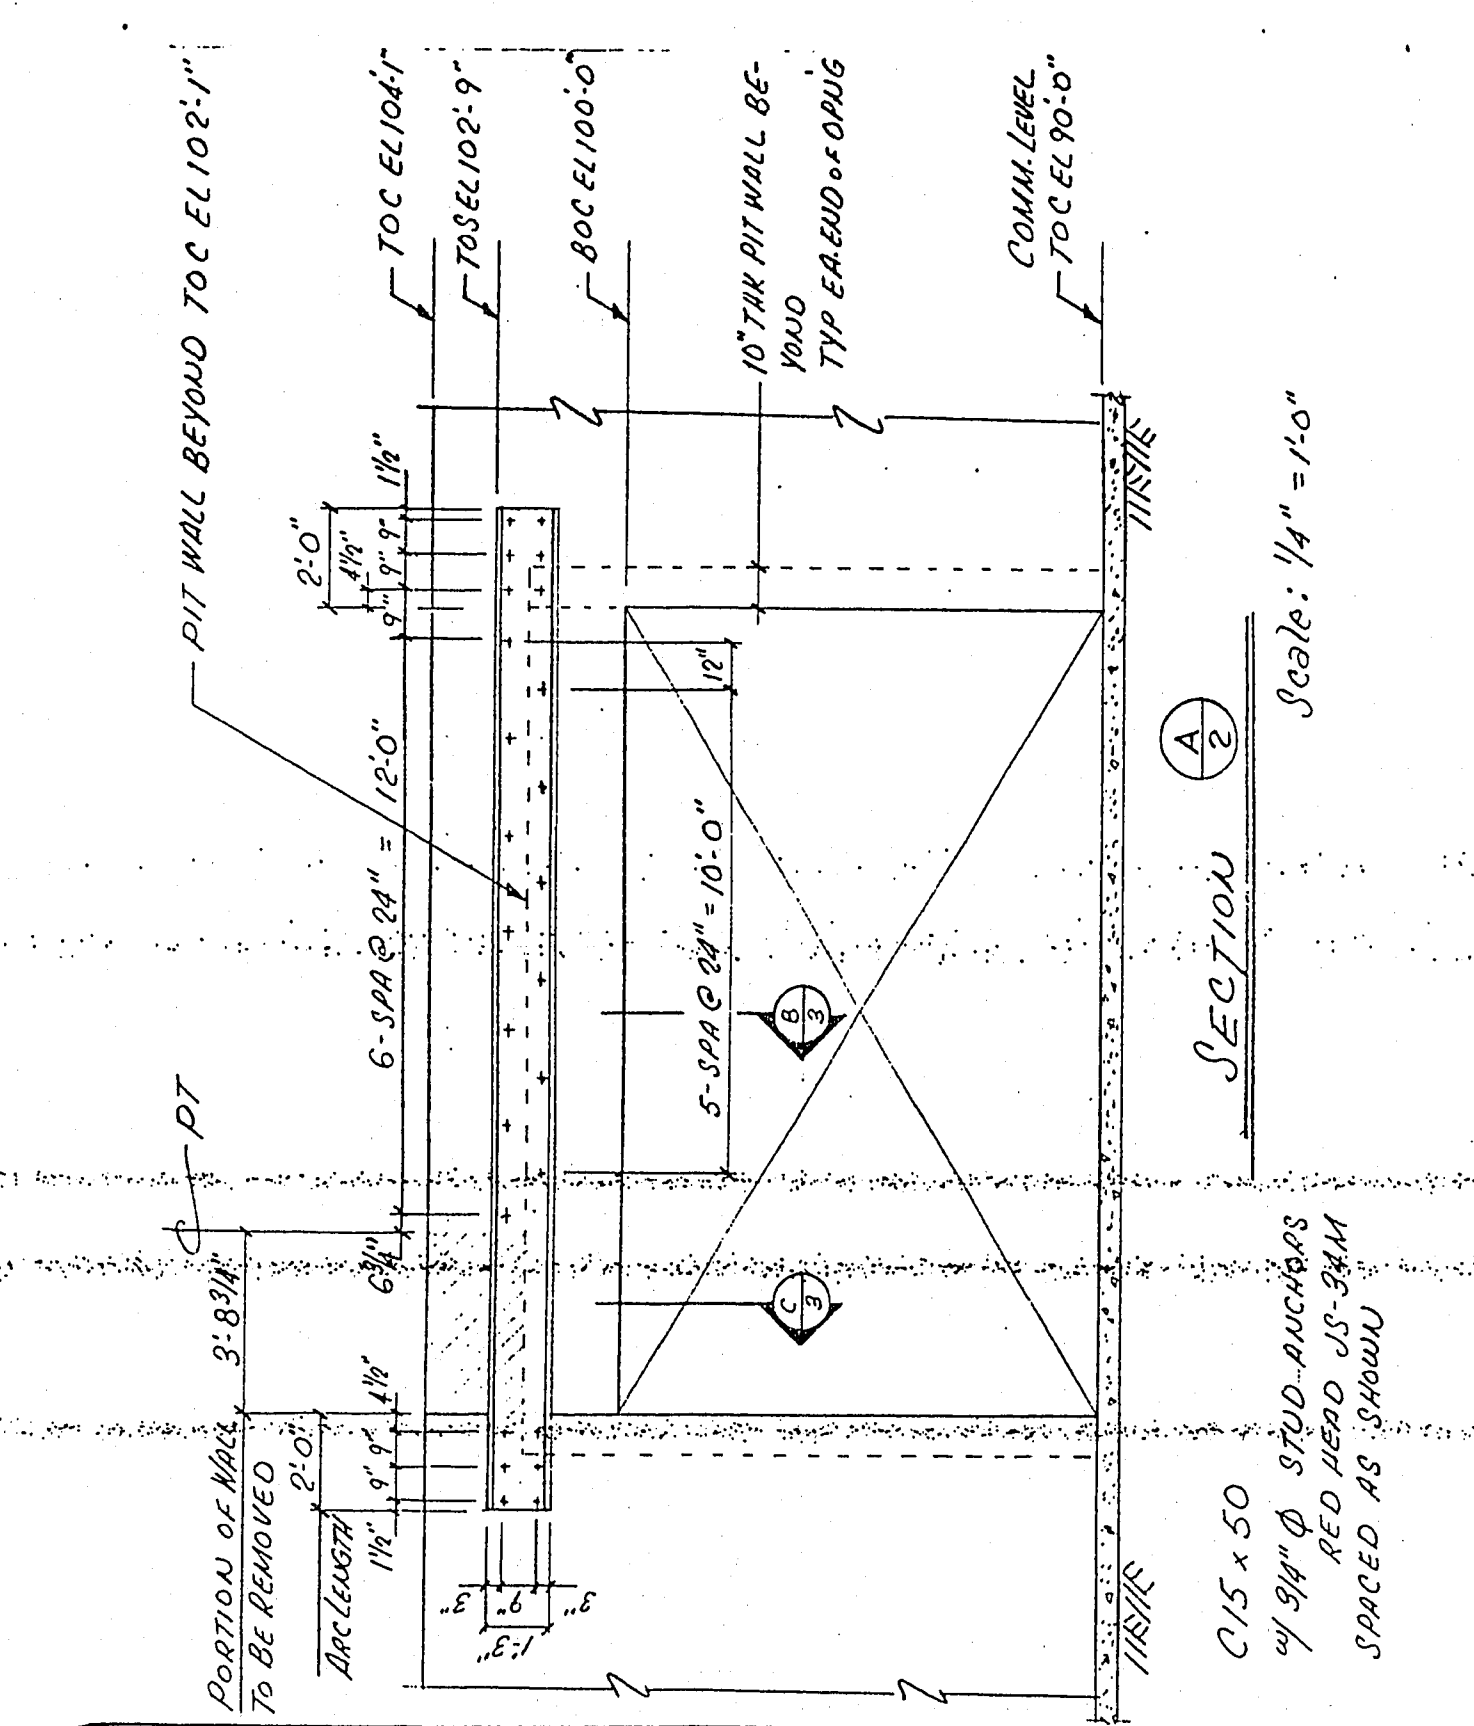

SHEET TITLE: CENTRAL FIRE STATION		SHEET TITLE: REPAIR MODIFICATION TO CONC. BM.	
HARRIS SHARP & ASSOC., INC. ARCHITECTURE-PLANNING-INTERIORS 2915 W. CHARLESTON BLVD. LAS VEGAS, NEVADA 89102 (702) 877-0125	JOB No. 482-1	DATE 3-28-83	SHEET No. Q-19
DRAWN H.S.	CHECKED H.C.		

Department of Public Works Engineering Design Division		CENTRAL FIRE STATION	
REVISIONS AND/OR CLARIFICATION		CENTRAL FIRE STATION	
Scale (h) Scale (v) W.A.		Scale (h) Scale (v) W.A.	
Fid. bk. no. Date		Fid. bk. no. Date	
Design by		Design by	
Drawn by		Drawn by	
Revisions		Revisions	
Date		Date	

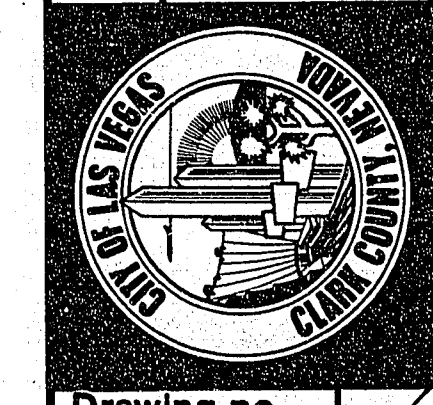

Drawing no.
 630-74

97 of 119