


# PARKING LOT POLE DETAIL

SCALE: NONE

## DOUBLE LUMINAIRE



## SINGLE LUMINAIRE

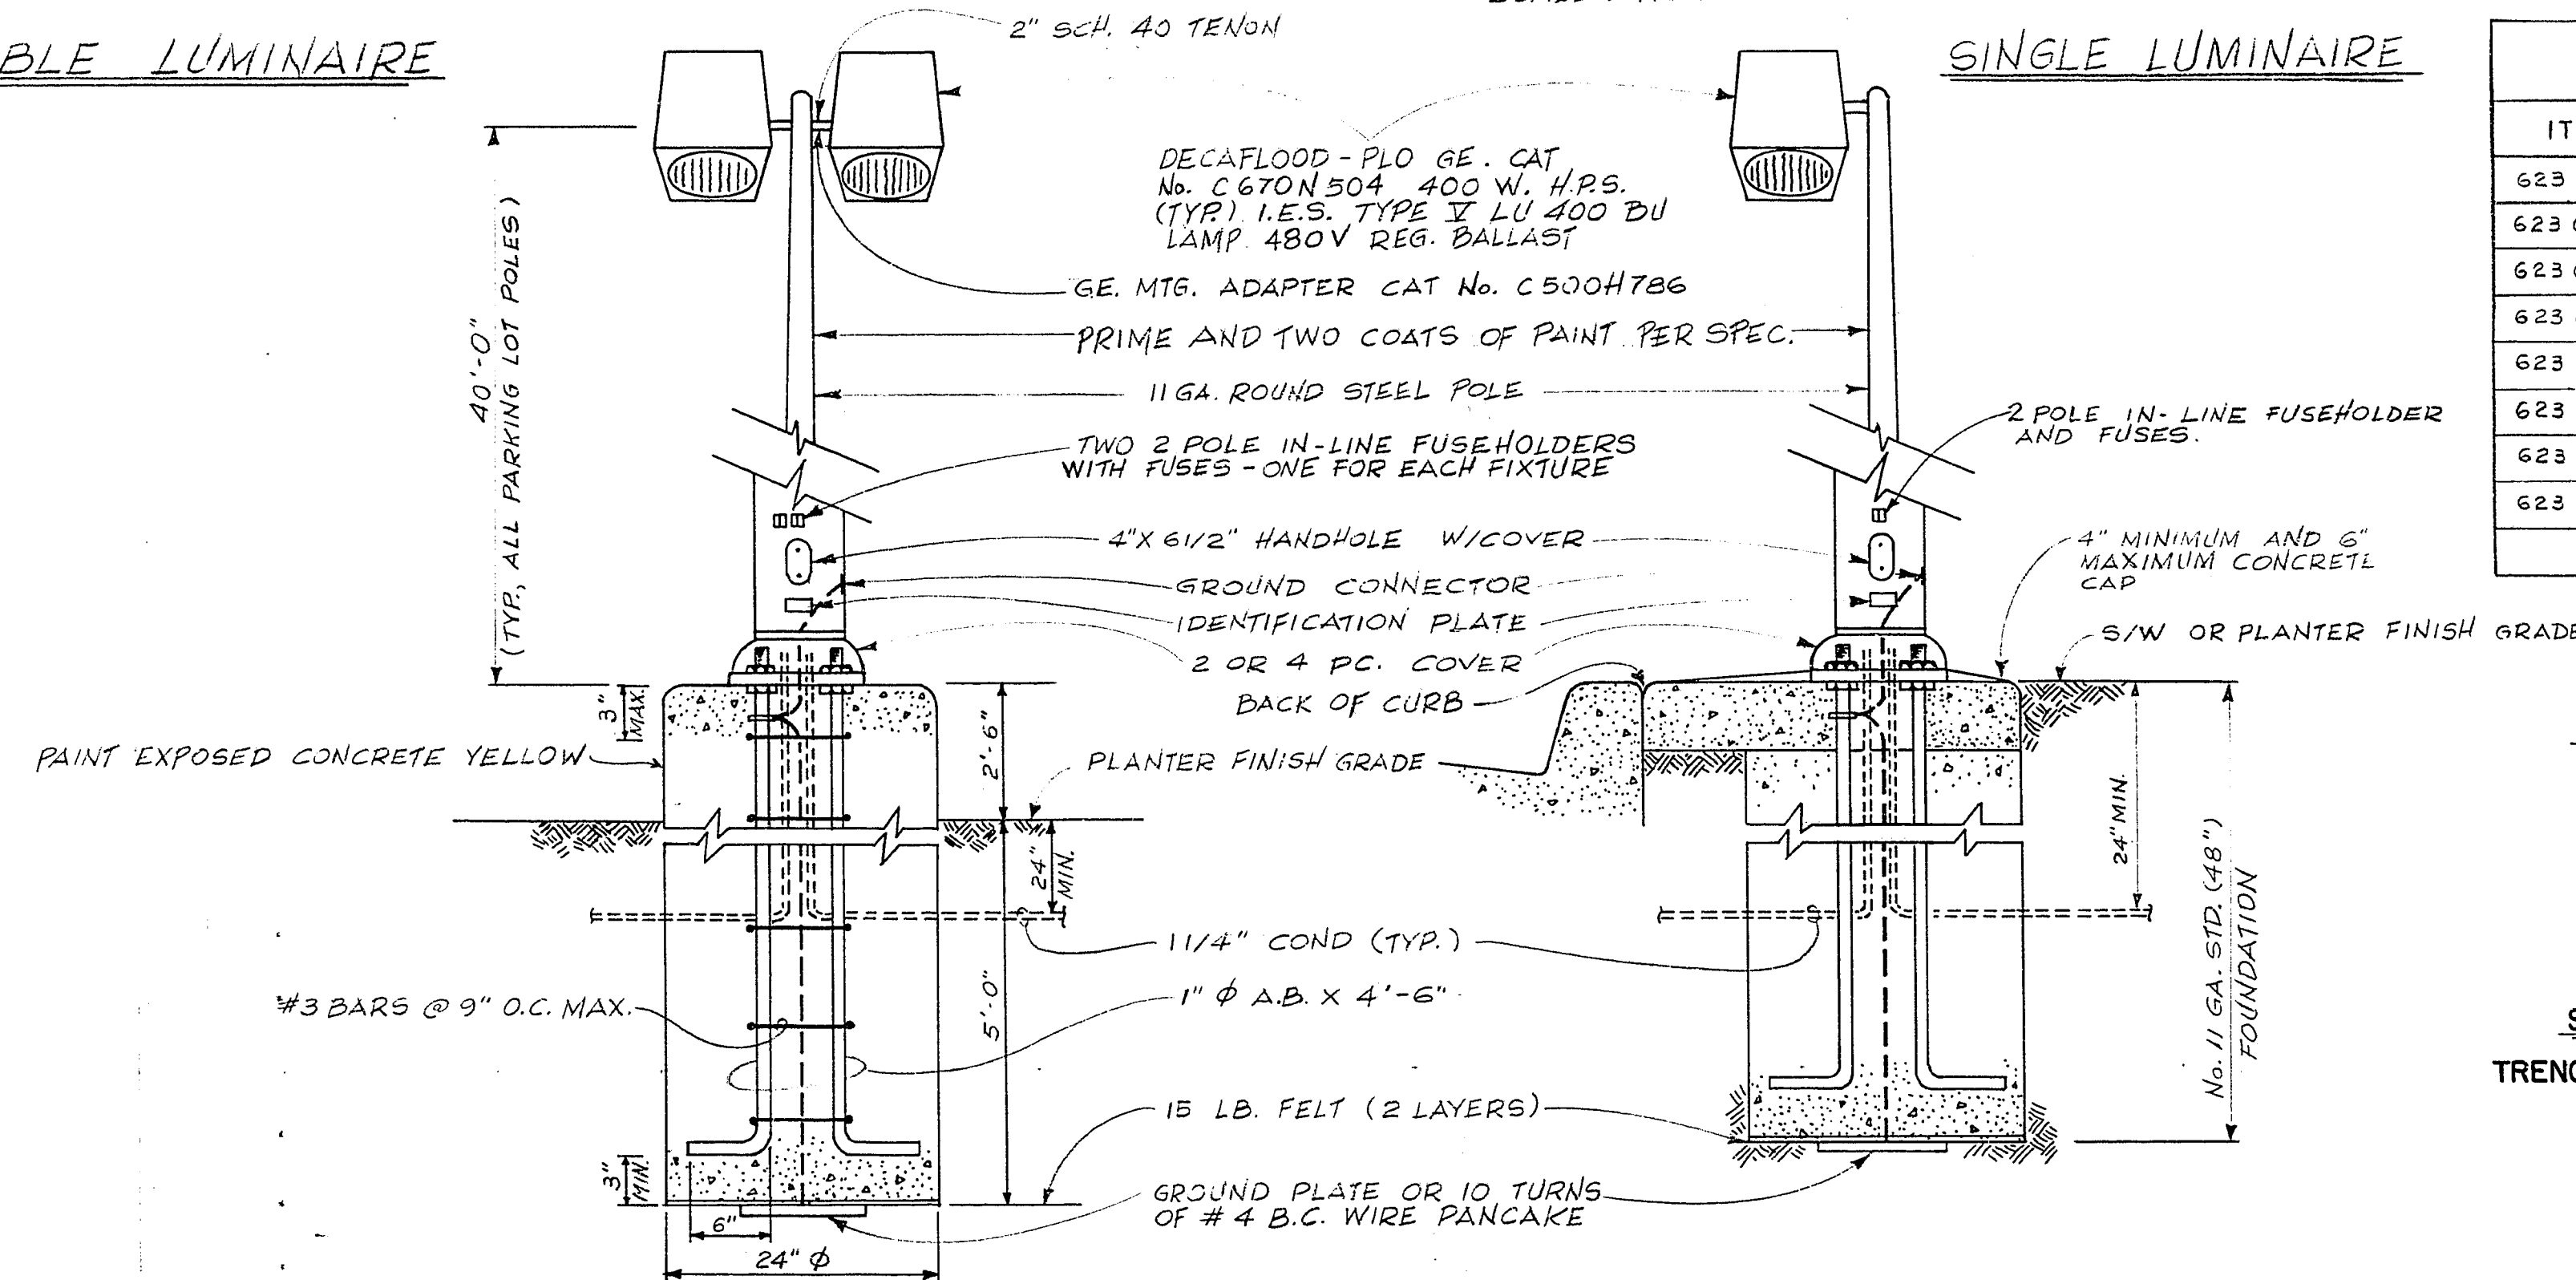

| ITEM N°       | DESCRIPTION                          | UNIT | QUANTITY |
|---------------|--------------------------------------|------|----------|
| 623 G.02.0235 | # 3 1/2 PULL BOX                     | E.A. | 2        |
| 623 G.03.0424 | 24" DEEP TRENCH/BACKFILL AND CONDUIT | L.F. | 1330     |
| 623 G.03.0648 | 48" DEEP FOUNDATION                  | E.A. | 5        |
| 623 G.03.0690 | 90" X 24" DIAM. FOUNDATION           | E.A. | 3        |
| 623 L.02.0140 | 40 FT. 11 GAUGE STEEL POLE           | E.A. | 8        |
| 623 L.02.0400 | 400 W H.P.S. FLOODLIGHT              | E.A. | 11       |
| 623 L.02.0504 | # 4 THW CONDUCTOR                    | L.F. | 4206     |
| 623 L.02.0508 | # 8 THW CONDUCTOR                    | L.F. | 1432     |

## LEGEND

- 400W H.P.S. LUMINAIRE MOUNTED ON 40 FT. POLE
- 2-400W H.P.S. LUMINAIRES MOUNTED ON 40 FT. POLE
- No. 3 1/2 PULL BOX

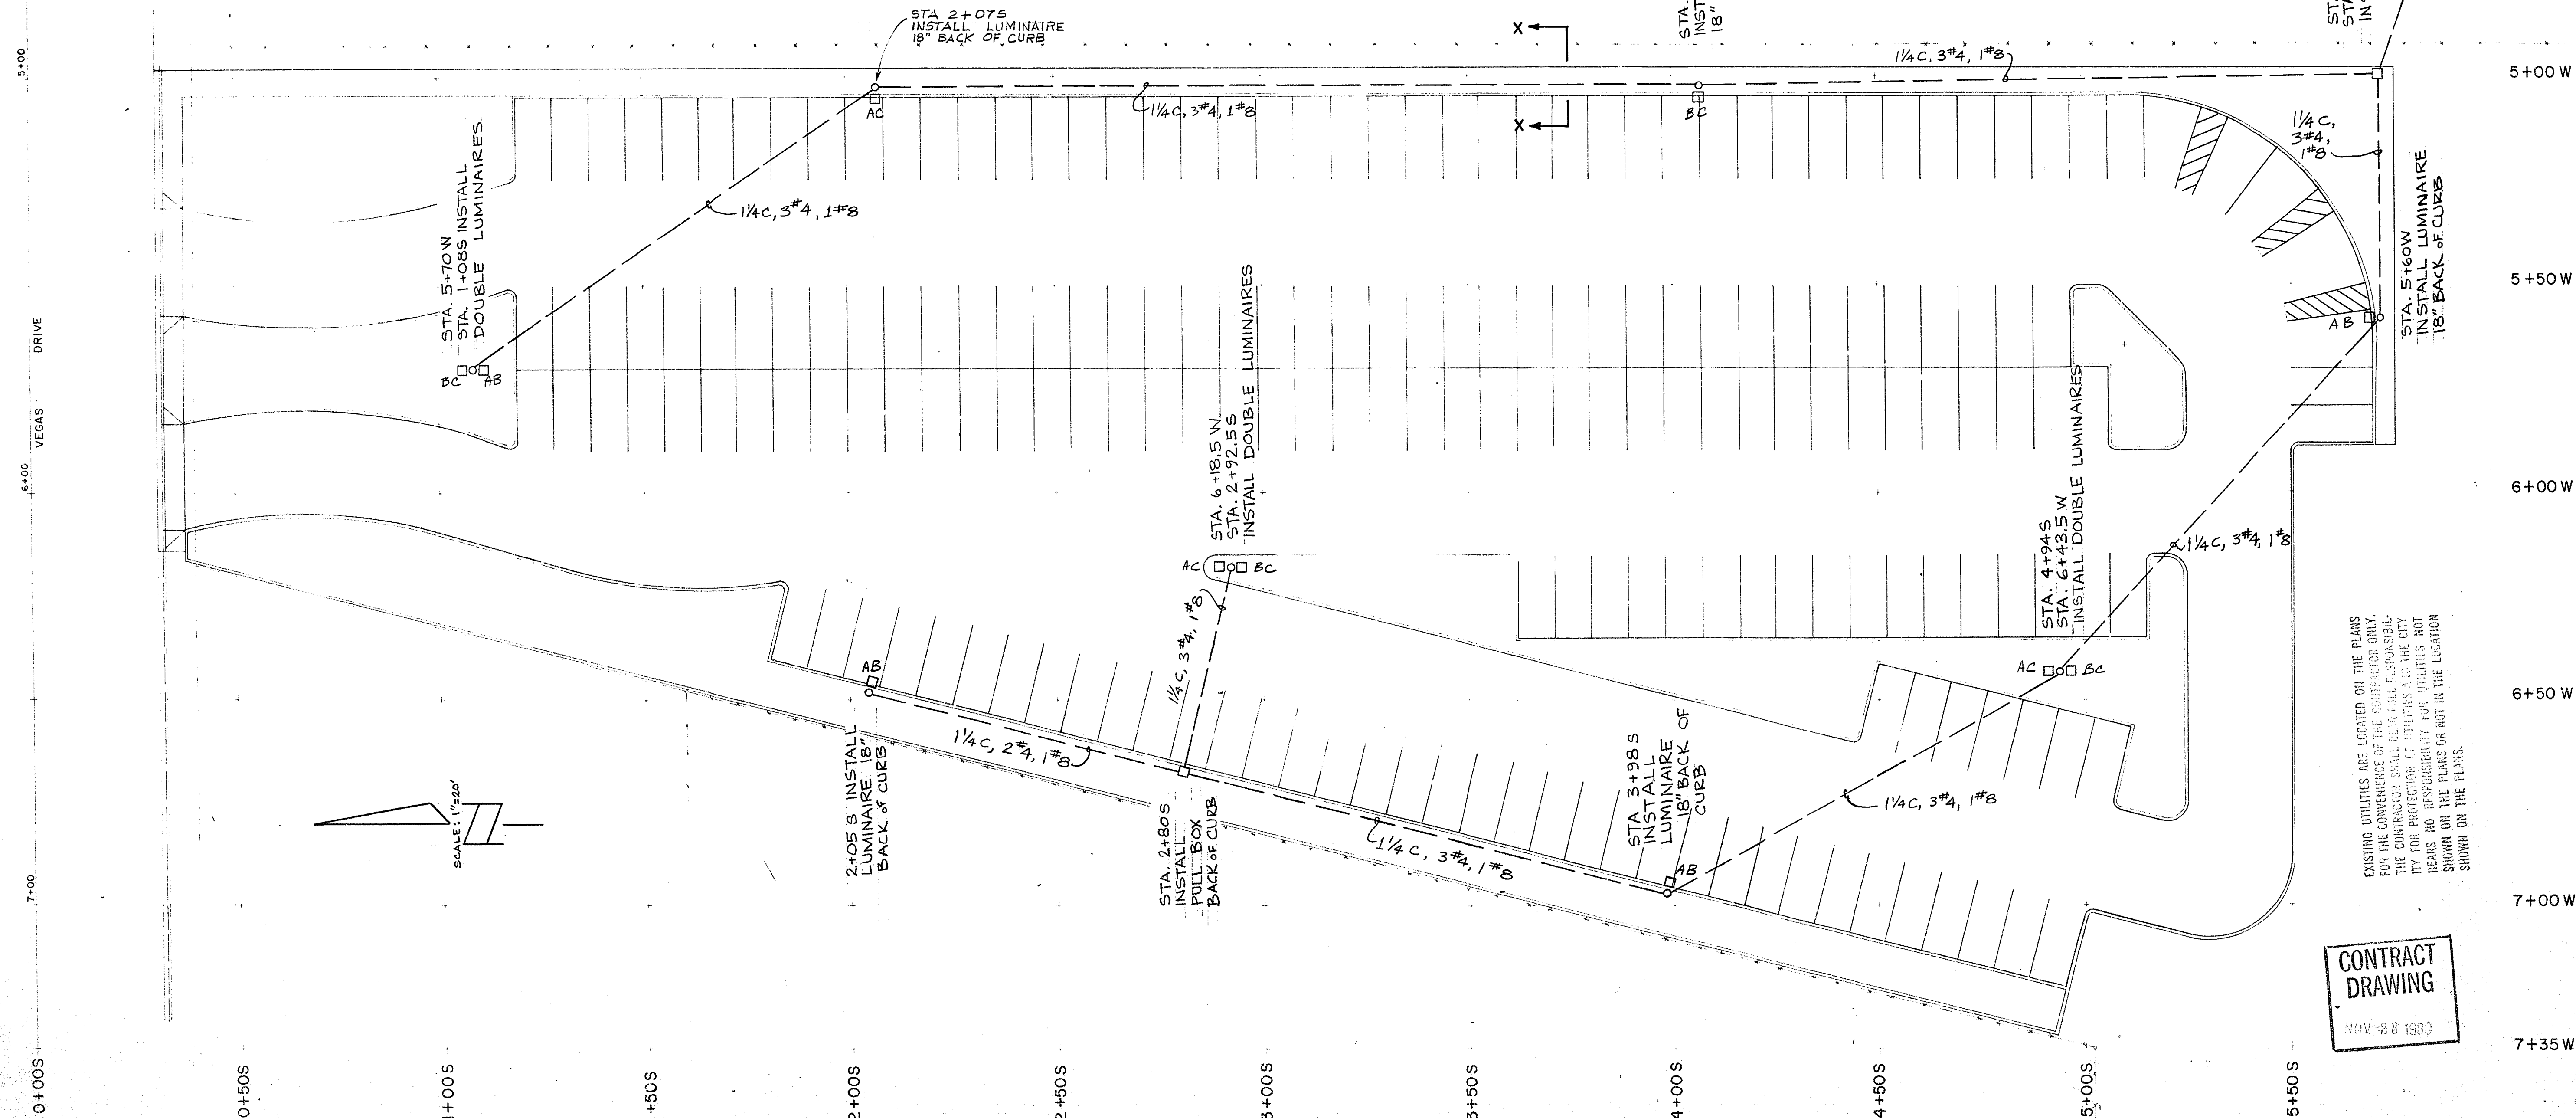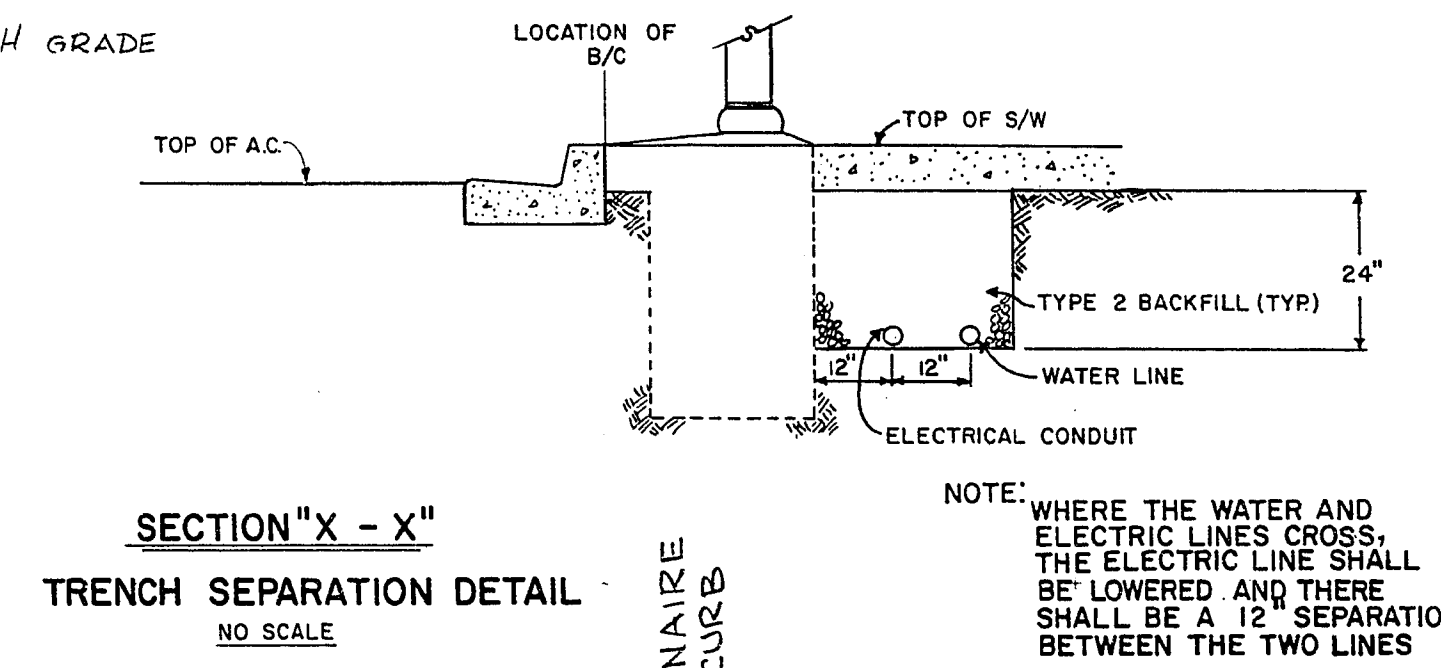

CONTRACT  
DRAWING

NOV 28 1980

Department of Public Services Engineering Design Division  
PARKING LOT ADDITION  
LIGHTING PLAN

ED FOUNTAIN PARK  
PHASE II



Drawing no.  
675-22A

BID N° 81. 3550.3

SHEET 7 of 13

05-13-89  
18-51-58