


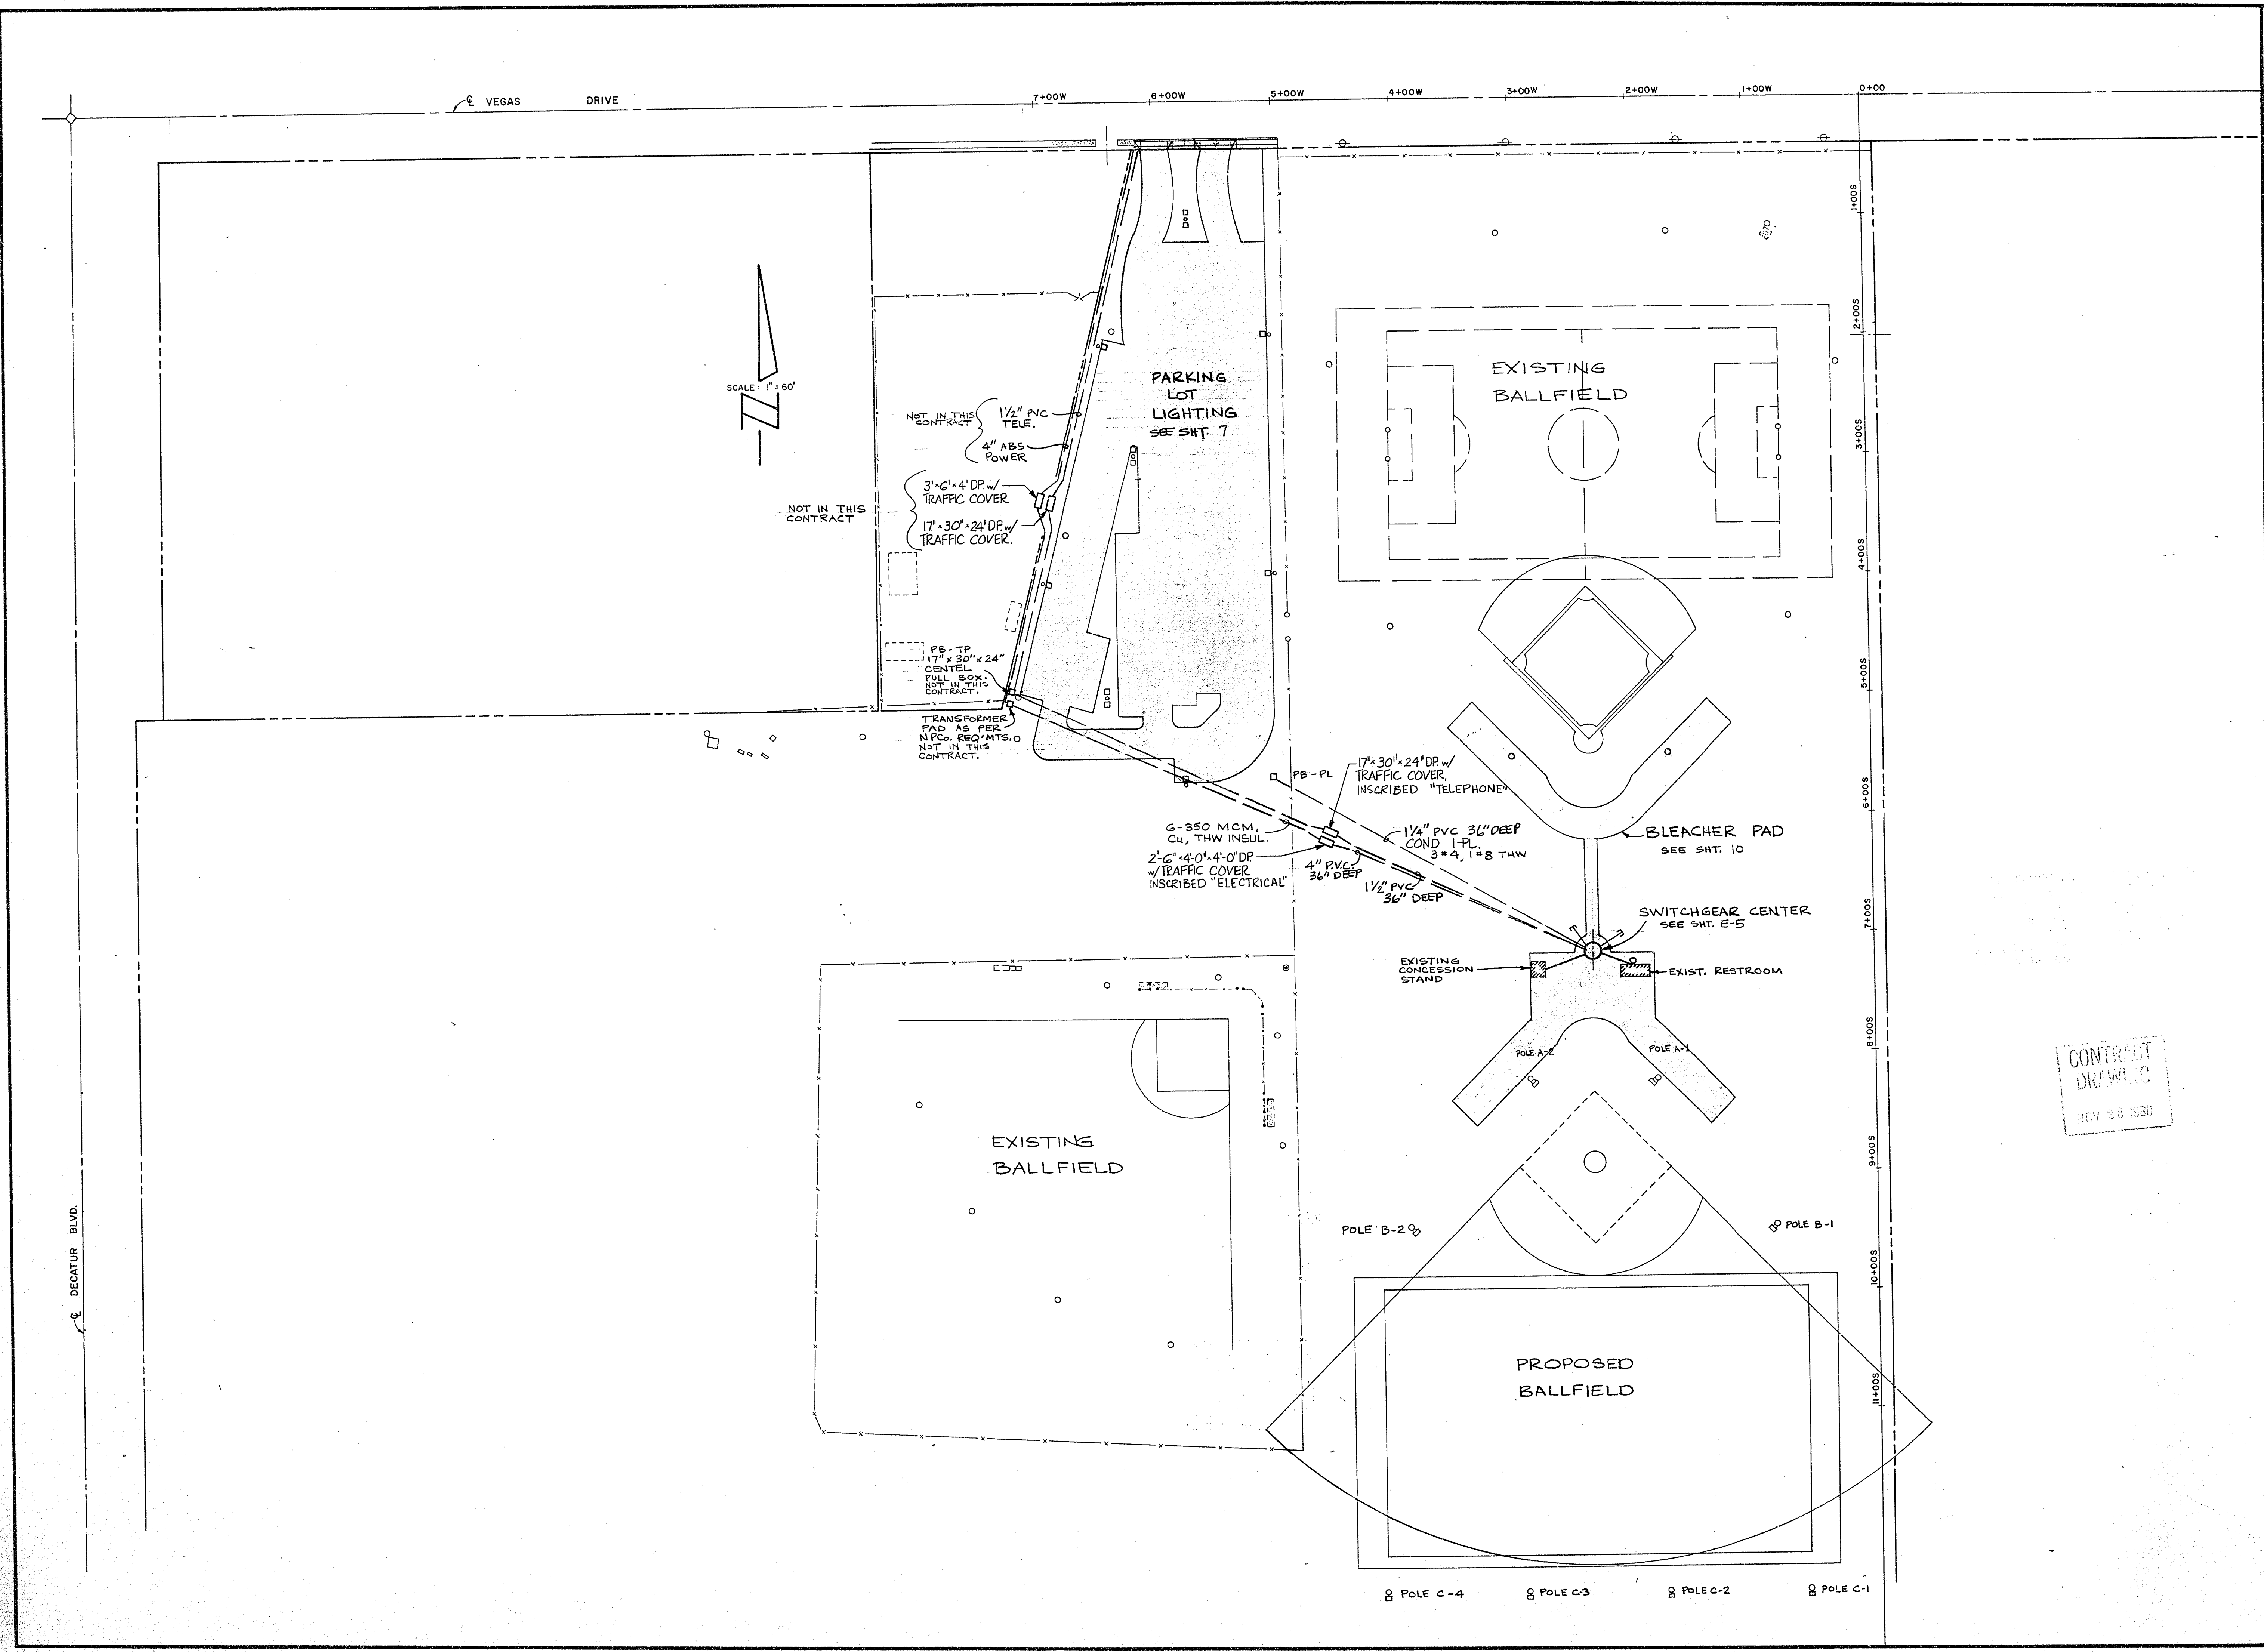

CONTRACT
DRAWING
NOV 23 1980

		Scale (h) 1" = 60'		Scale (v) —	W.A. 0022	Revisions	Date
Department of Public Services		Engineering Design Division		Fid. bk. no. 78-2X	Date APRIL, 1980	Design by S. MORSE	Drawn by F. LEE
FOUNTAIN PARK		ELECTRICAL		SITE PLAN			
PHASE II							
		Drawing no. 675-22A		E1			

86-81-50