


SCALE 1"=40'

- LEGEND**
- FINISH GRADE EL.
 - TOP OF SLOPE
 - CONC. PAVEMENT
 - A.C. PAVEMENT
 - EXISTING CONTOUR
 - T.C. TOP OF CURB
 - F.L. FLOW LINE
 - F.S. FINISH SURFACE
 - SEWER MAIN
 - WATER MAIN

B-B SECTION THROUGH PROTECTIVE BEEM.
No Scale

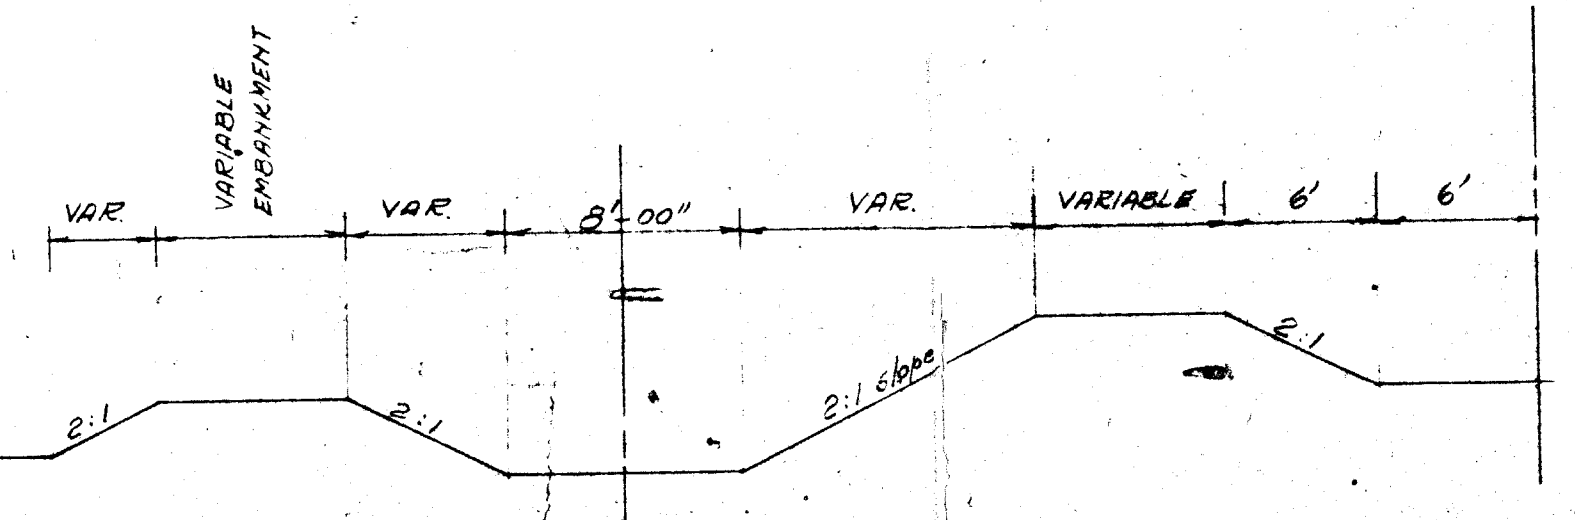

SECTION A-A
No Scale

APPROVALS

[Signature] 12/12/62
City Engineer

[Signature] 12-12-62
Field Engineer

DESIGNED JR WESTERN ENGINEERS, INC.
DRAWN EB LAS VEGAS NEVADA
CHECKED RK APPROVED [Signature] DATE 2/1/62

MEMBER OF THE
ZICK & SHARP
ARCHITECTS - ENGINEERS
1106 S. MAIN ST.
LAS VEGAS, NEVADA

FROM THE OFFICE OF:
ZICK & SHARP
ARCHITECTS - ENGINEERS
1106 S. MAIN ST.
LAS VEGAS, NEVADA

NO. DATE REVISED BY

SHEET TITLE: OFFSITE UTILITY PLAN
JOB TITLE: WASHINGTON JUNIOR HIGH SCHOOL
LAS VEGAS, NEVADA

JOB NUMBER: 106-4
DATE: 2-1-62
DRAWN BY: EB
CHECKED BY: RK
SHEET NUMBER: 01

VERIFY ALL DIMENSIONS AND CONDITIONS AT THE SITE

ALL LOCAL DESIGN ARRANGEMENTS AND PLANS INDICATED OR REFERENCED BY THIS DRAWING ARE THE PROPERTY OF THE ARCHITECTS AND ENGINEERS. THE ARCHITECTS AND ENGINEERS SHALL NOT BE RESPONSIBLE FOR THE DESIGN OR CONSTRUCTION OF ANY LOCAL DESIGN ARRANGEMENTS OR PLANS WHICH ARE NOT INDICATED OR REFERENCED BY THIS DRAWING. THE ARCHITECTS AND ENGINEERS SHALL NOT BE RESPONSIBLE FOR THE DESIGN OR CONSTRUCTION OF ANY LOCAL DESIGN ARRANGEMENTS OR PLANS WHICH ARE NOT INDICATED OR REFERENCED BY THIS DRAWING. THE ARCHITECTS AND ENGINEERS SHALL NOT BE RESPONSIBLE FOR THE DESIGN OR CONSTRUCTION OF ANY LOCAL DESIGN ARRANGEMENTS OR PLANS WHICH ARE NOT INDICATED OR REFERENCED BY THIS DRAWING.