




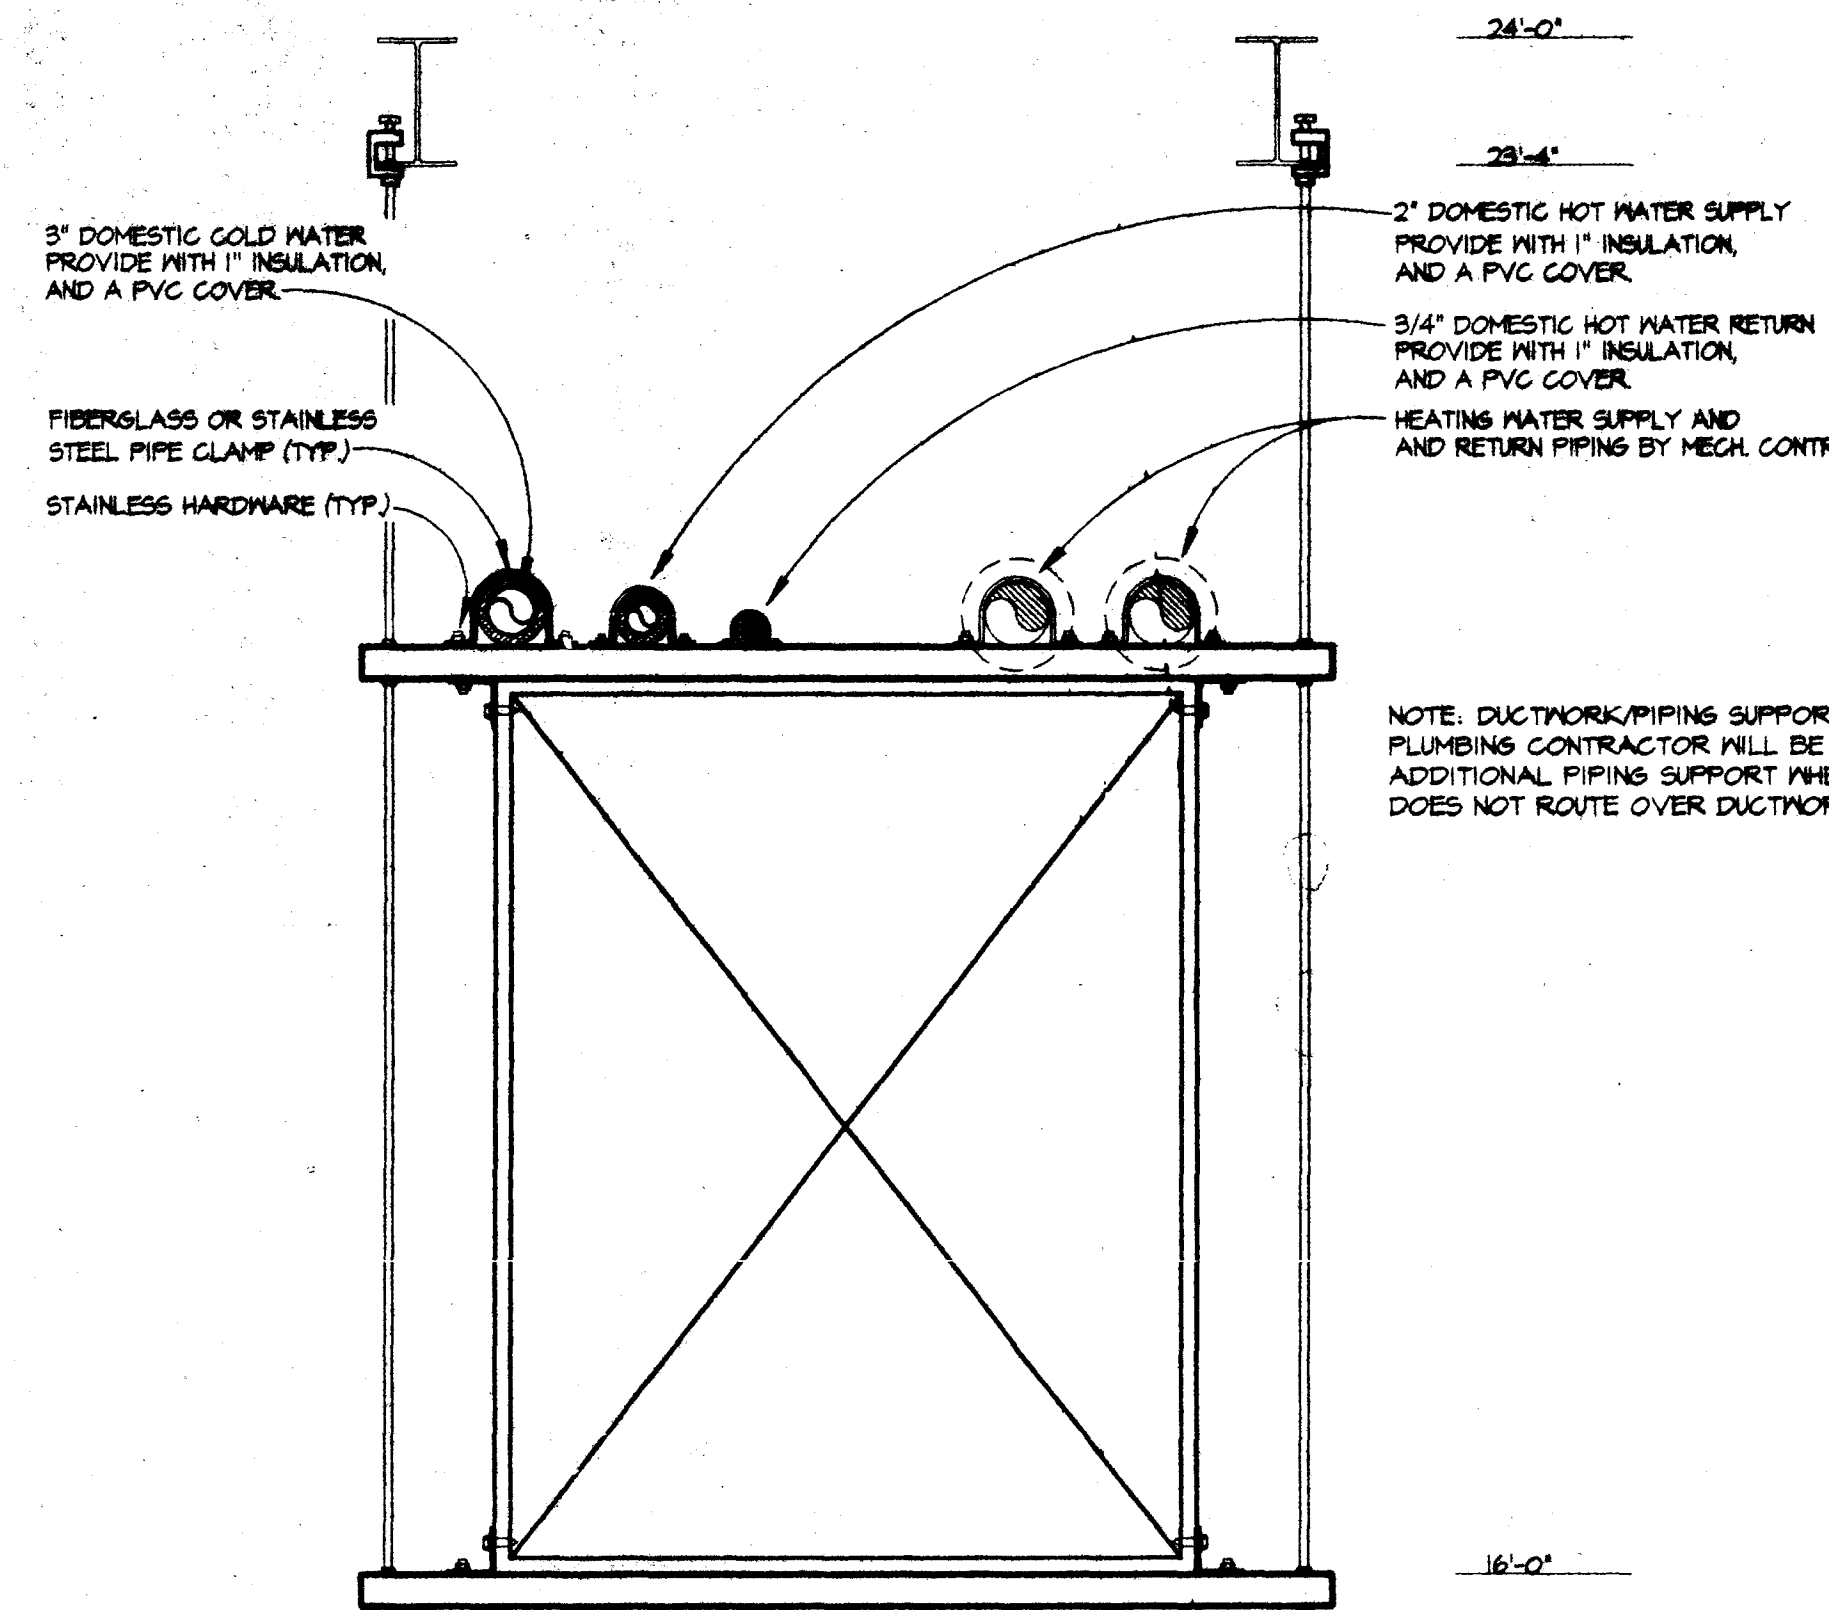


PIPING SUPPORT DETAIL 14
NTS (P4.1)

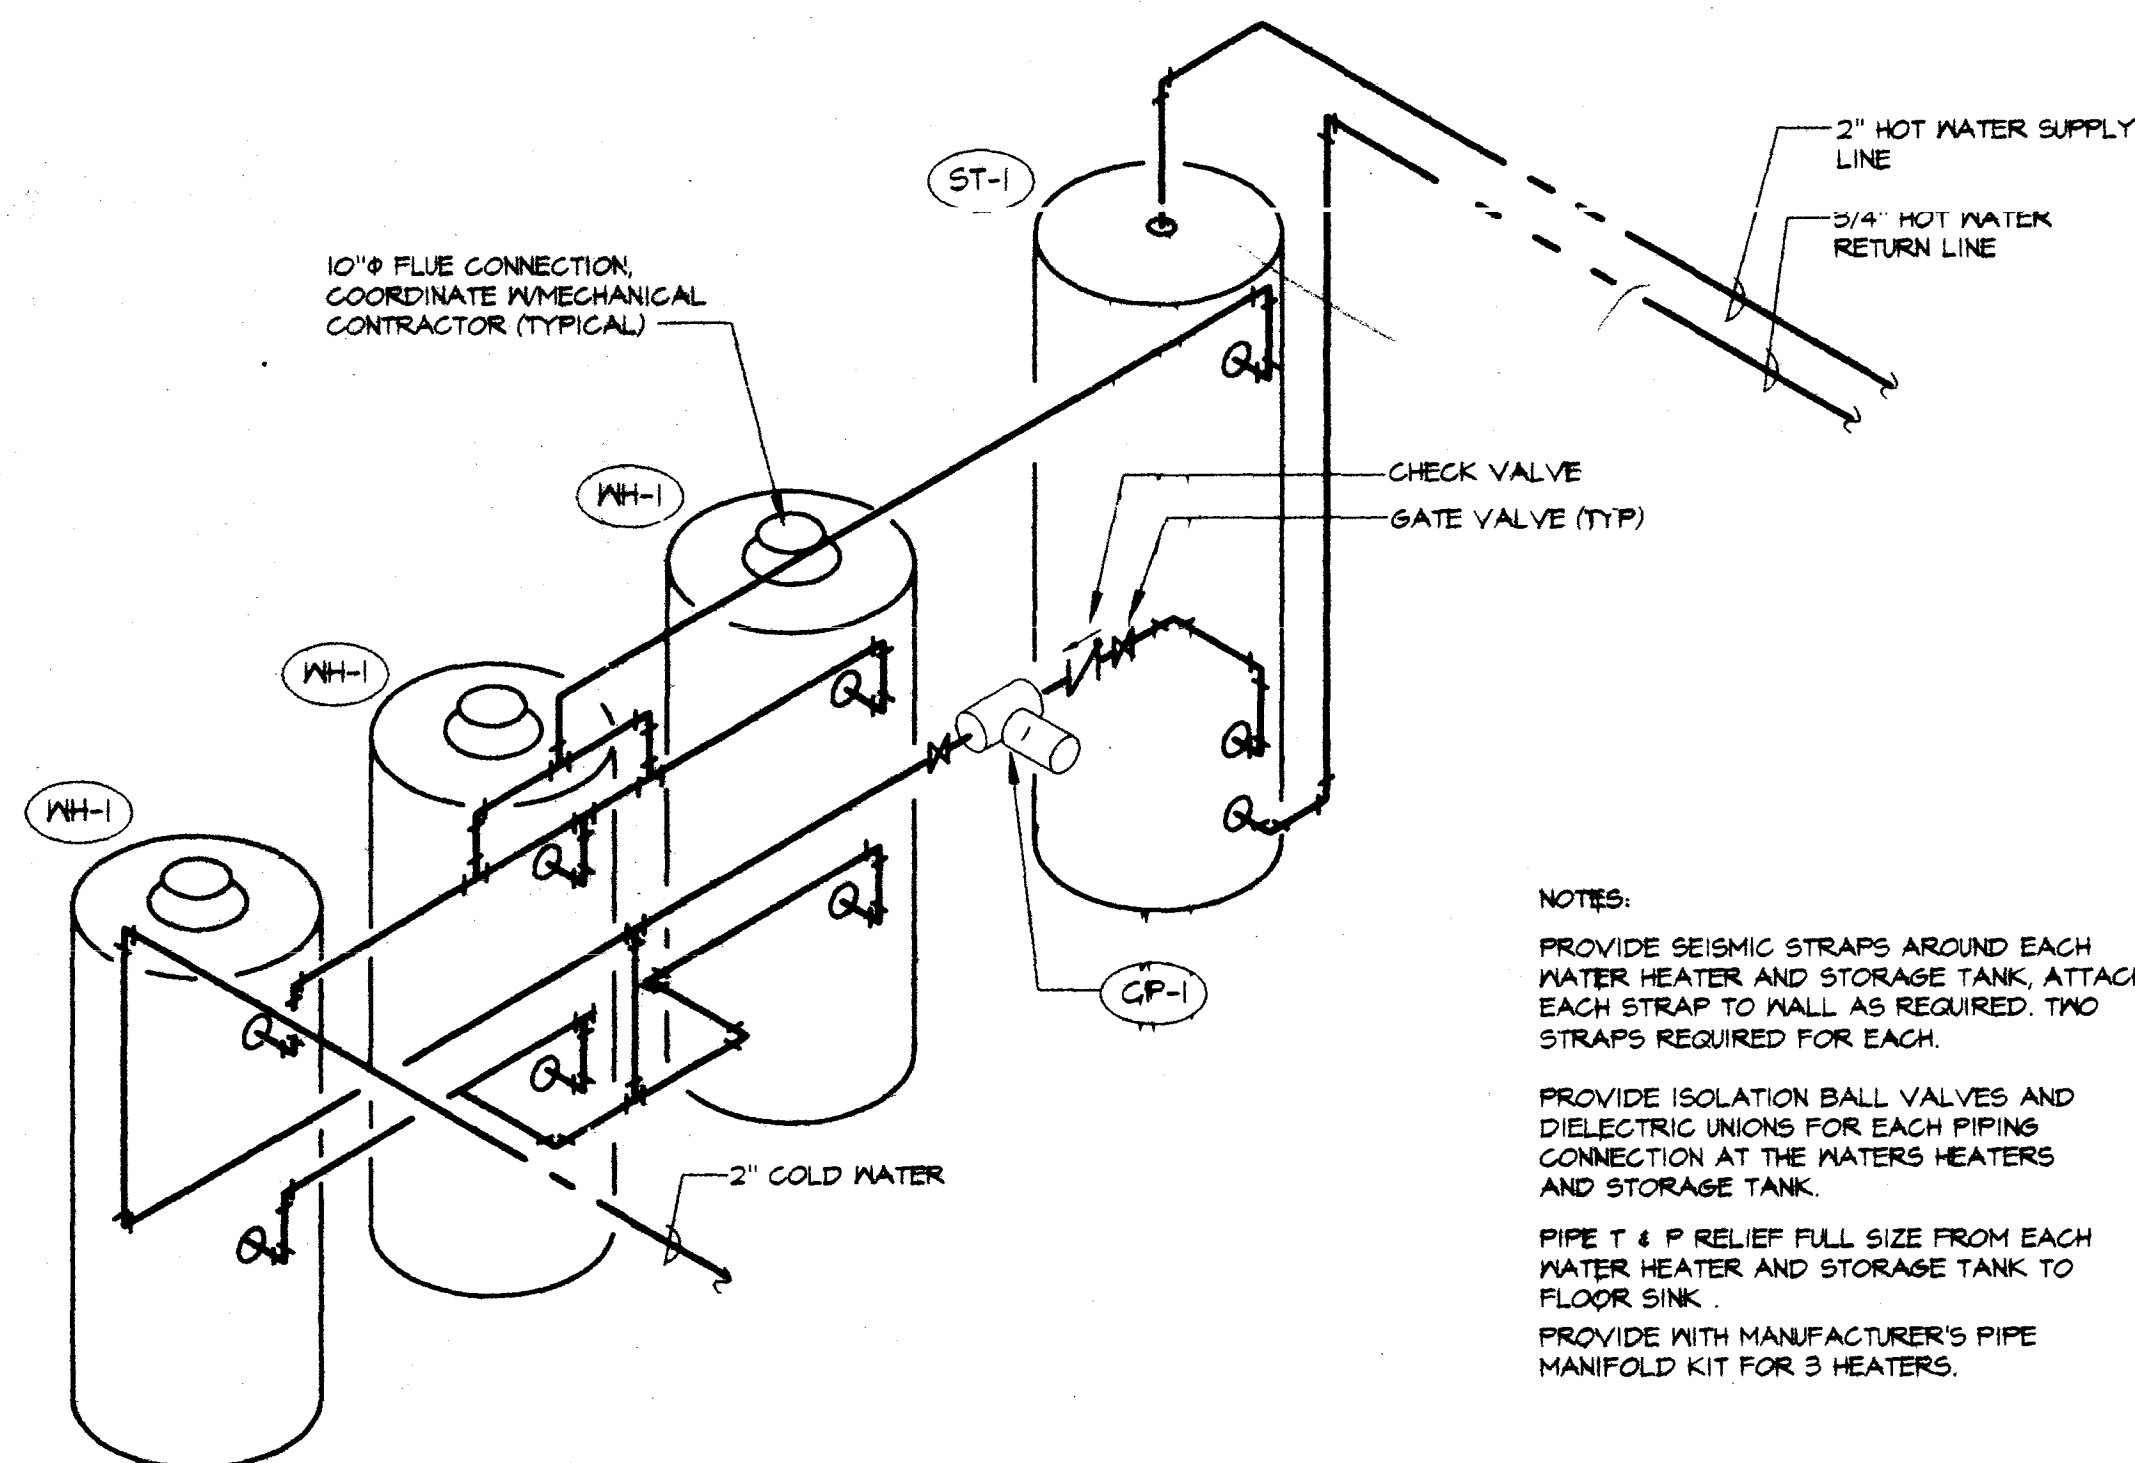


WATER HEATER DETAIL 15
NTS (P4.1)

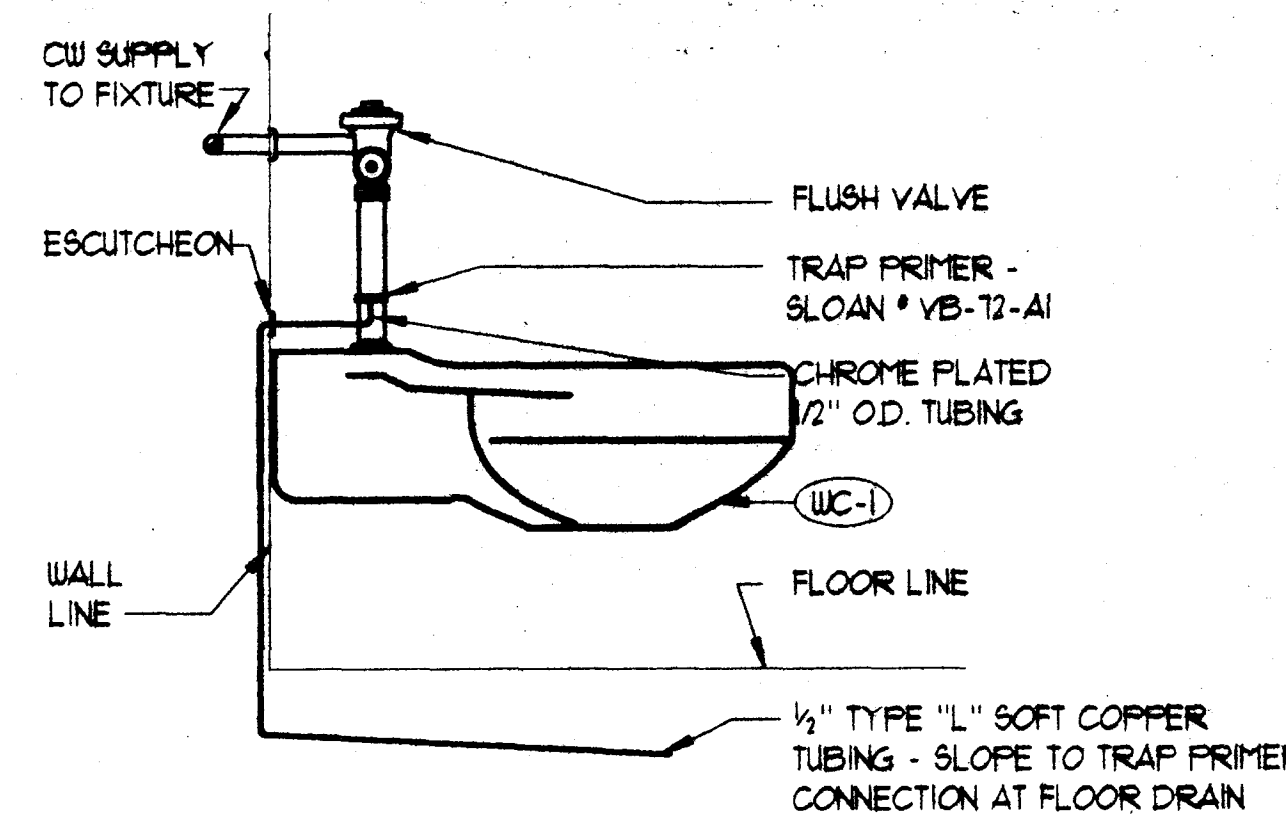


TRAP PRIMER PIPING DETAIL 9
NTS (P4.1)

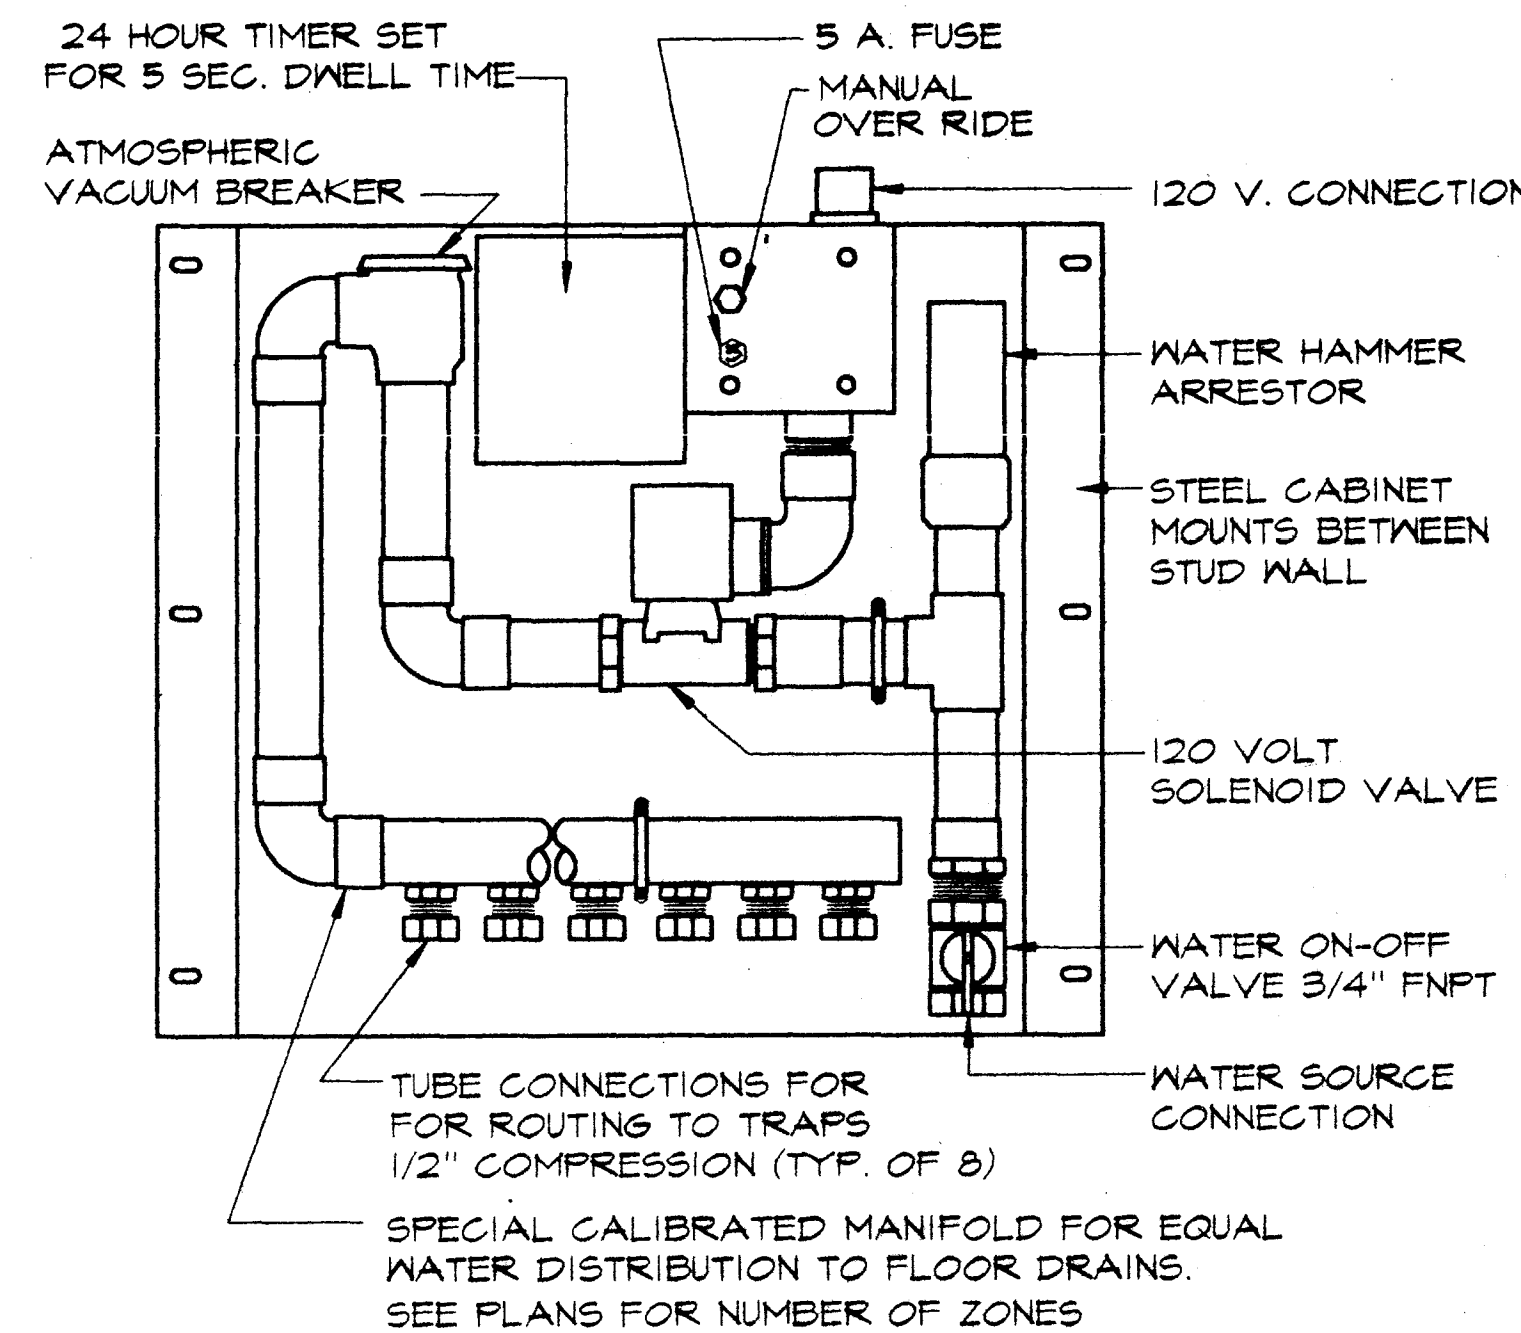


TRAP PRIMER MANIFOLD DETAIL 10
NTS (P4.1)

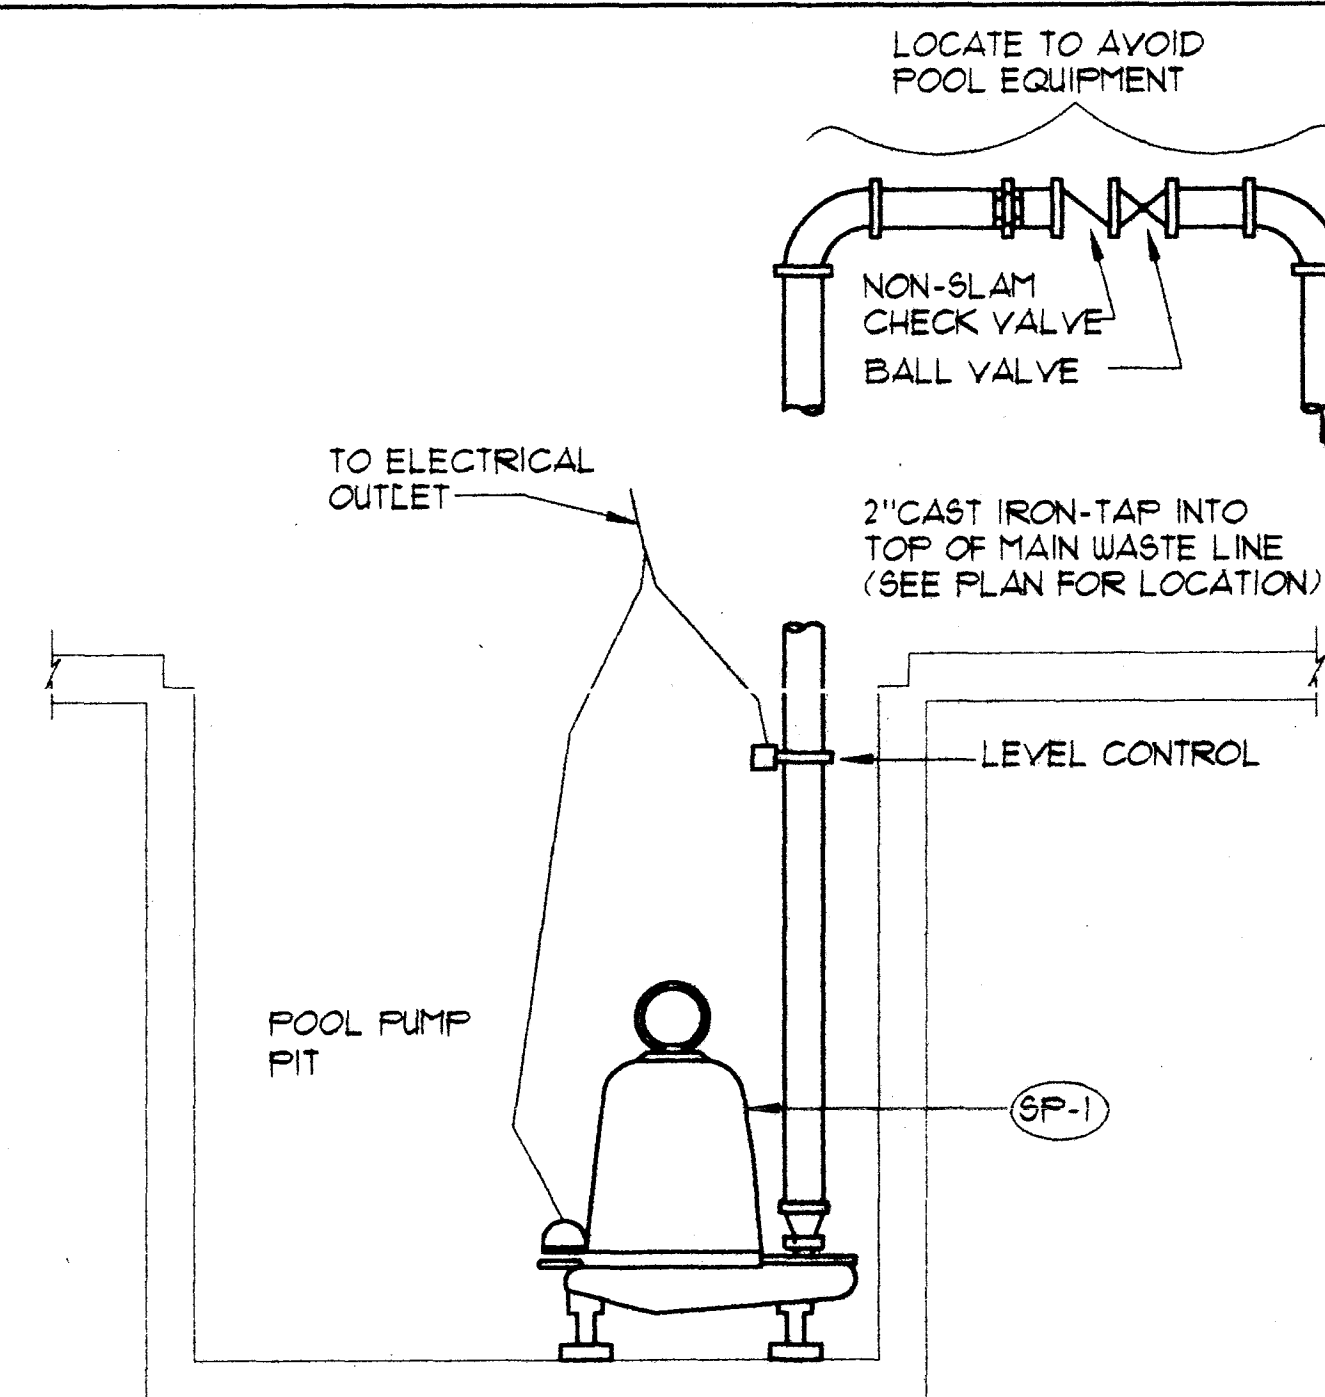


SUMP PUMP DETAIL 11
NTS (P4.1)

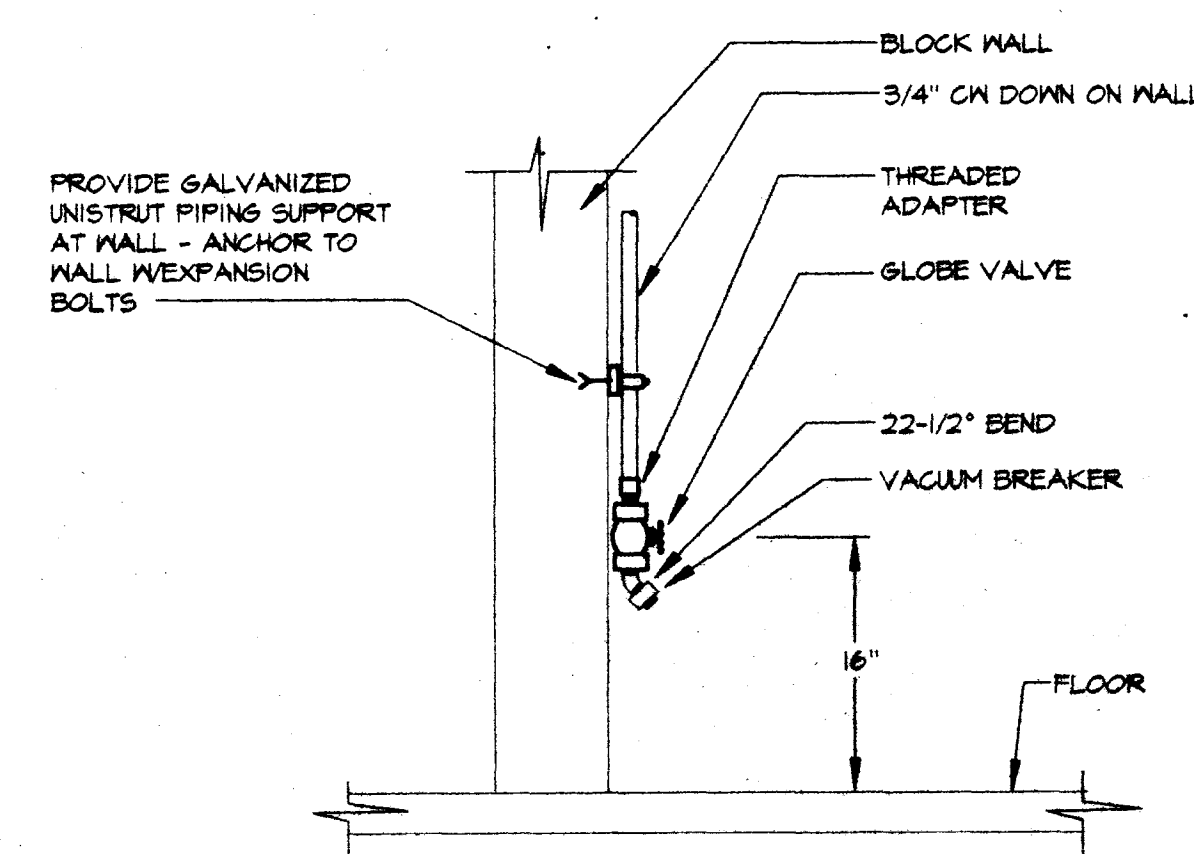


HOSE BIBB DETAIL @ POOL 12
NTS (P4.1)

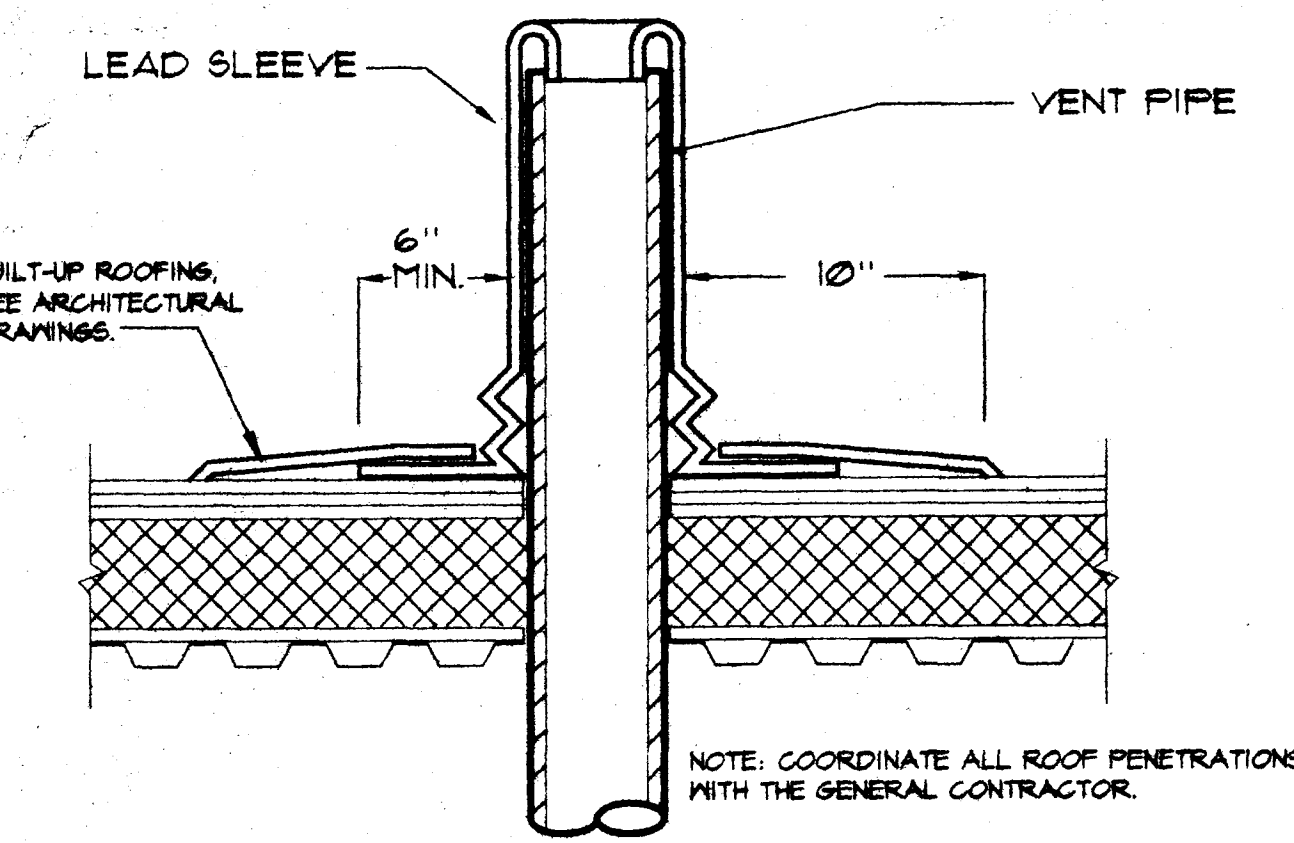


VENT PIPE THRU ROOF DETAIL 5
NTS (P4.1)

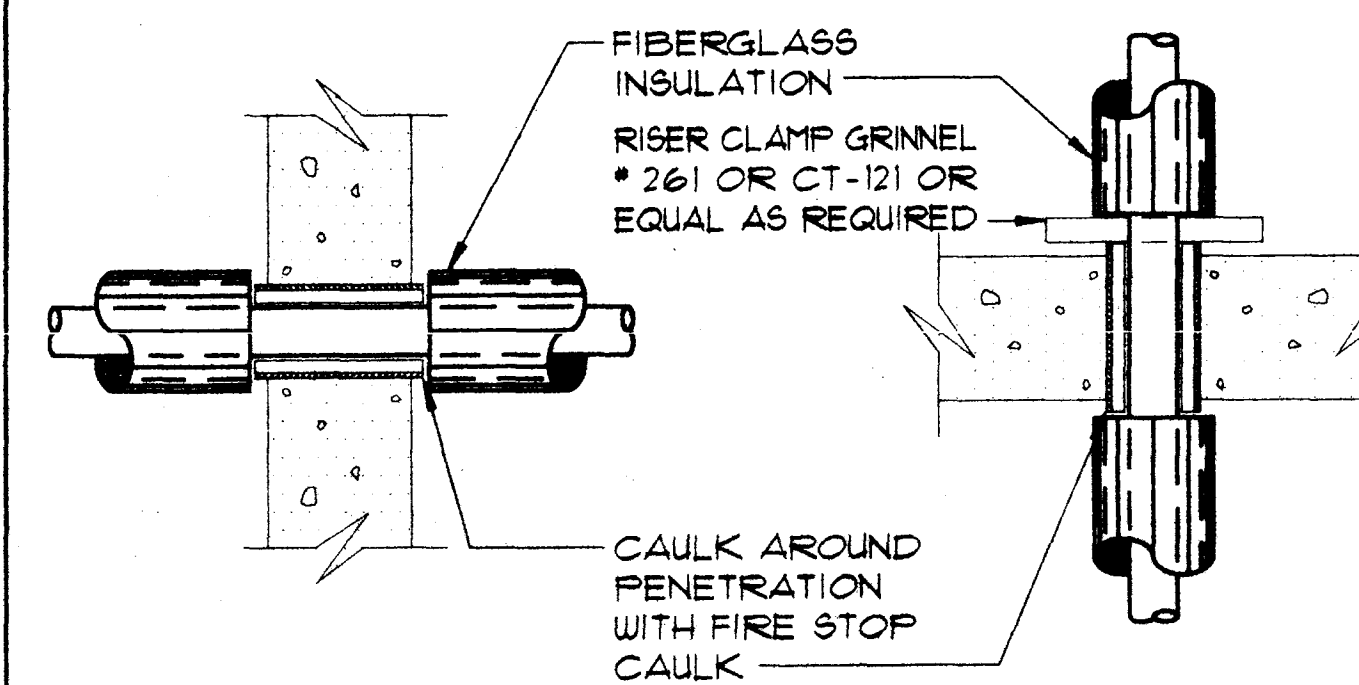


PIPING PENETRATION DETAIL 6
NTS (P4.1)

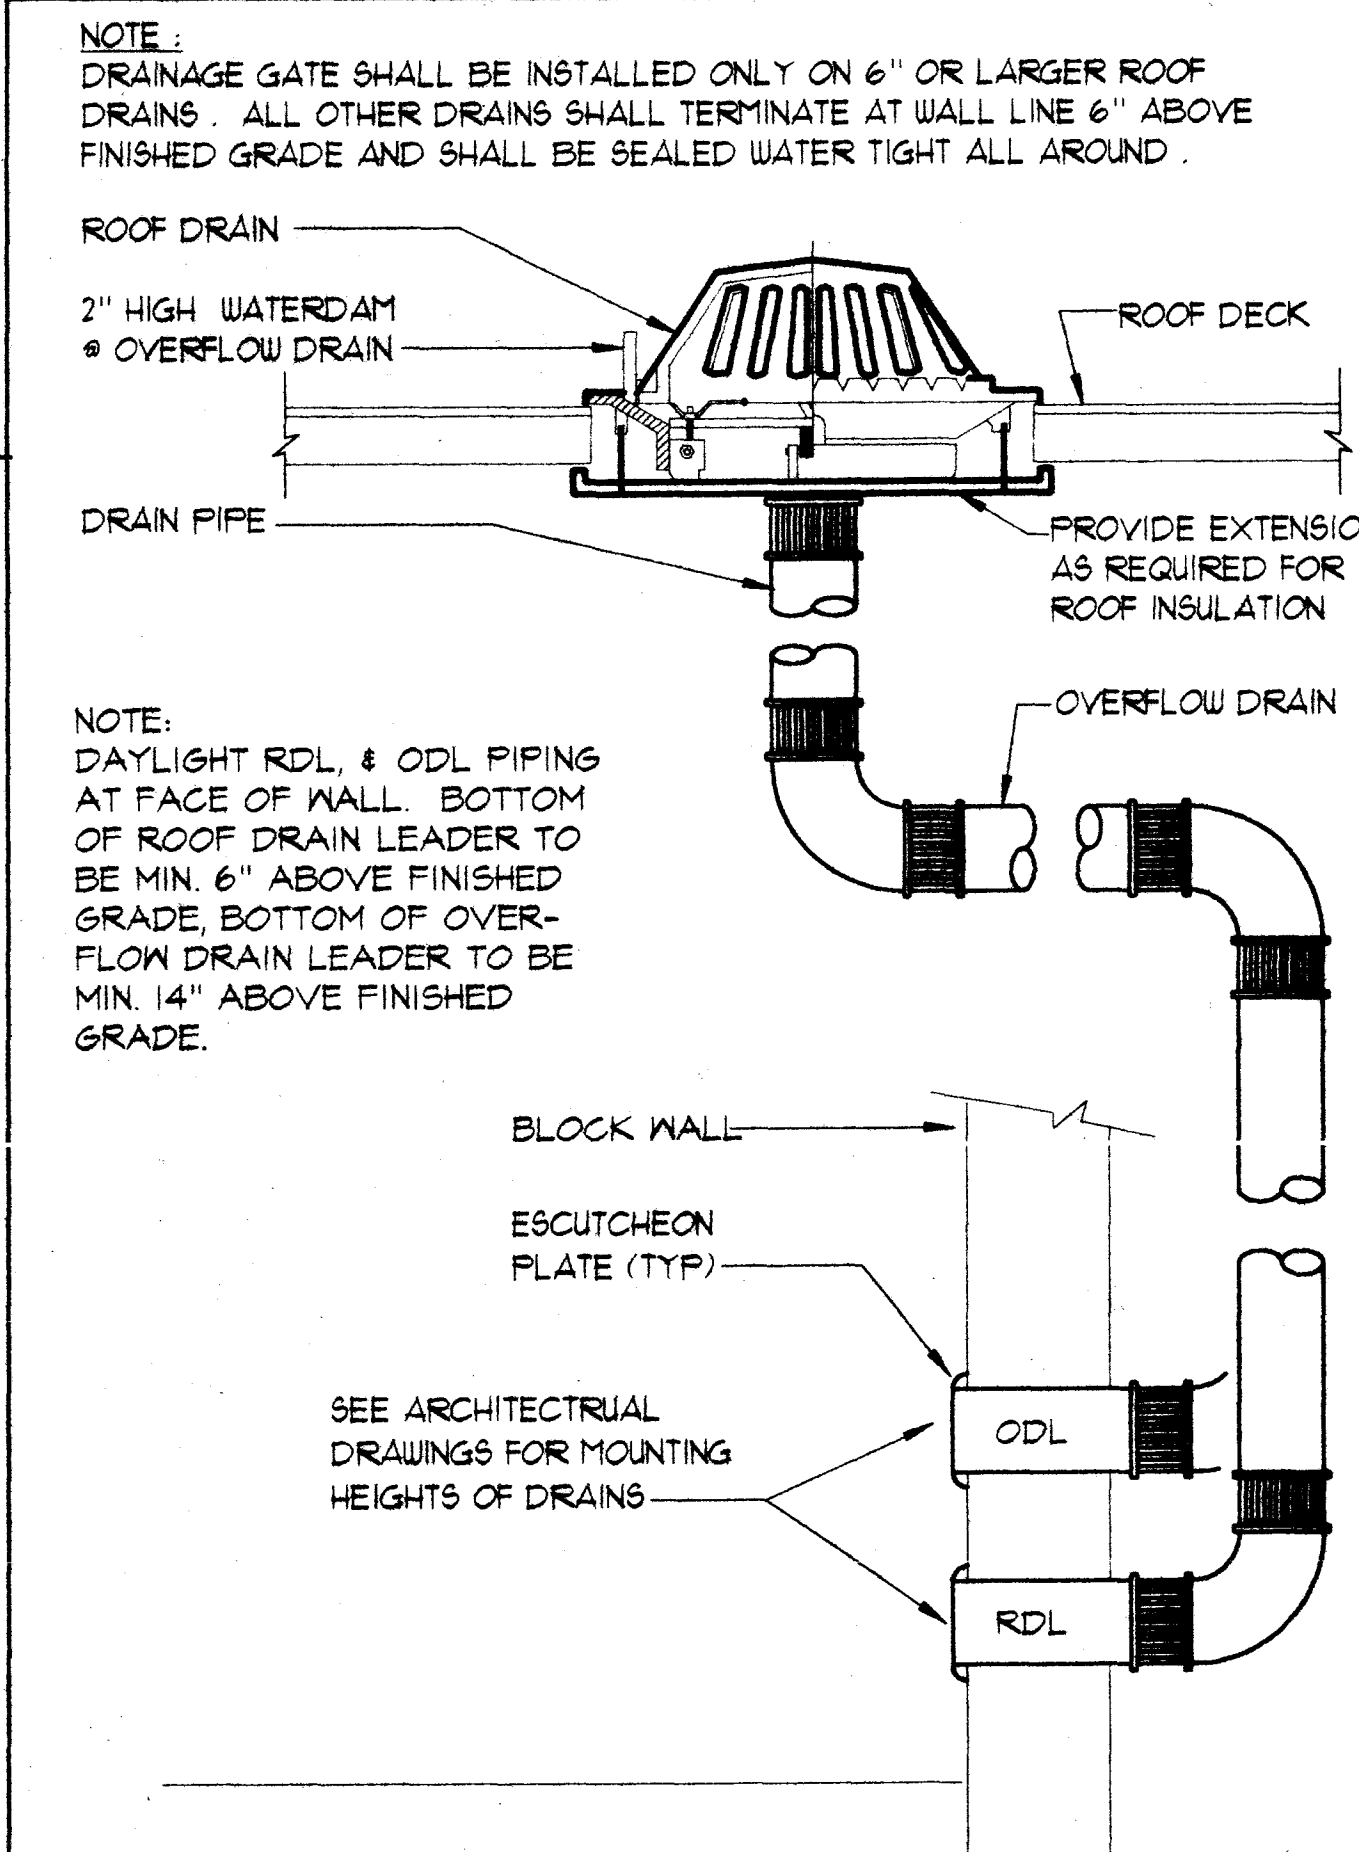


ROOF DRAIN DETAIL 7
NTS (P4.1)

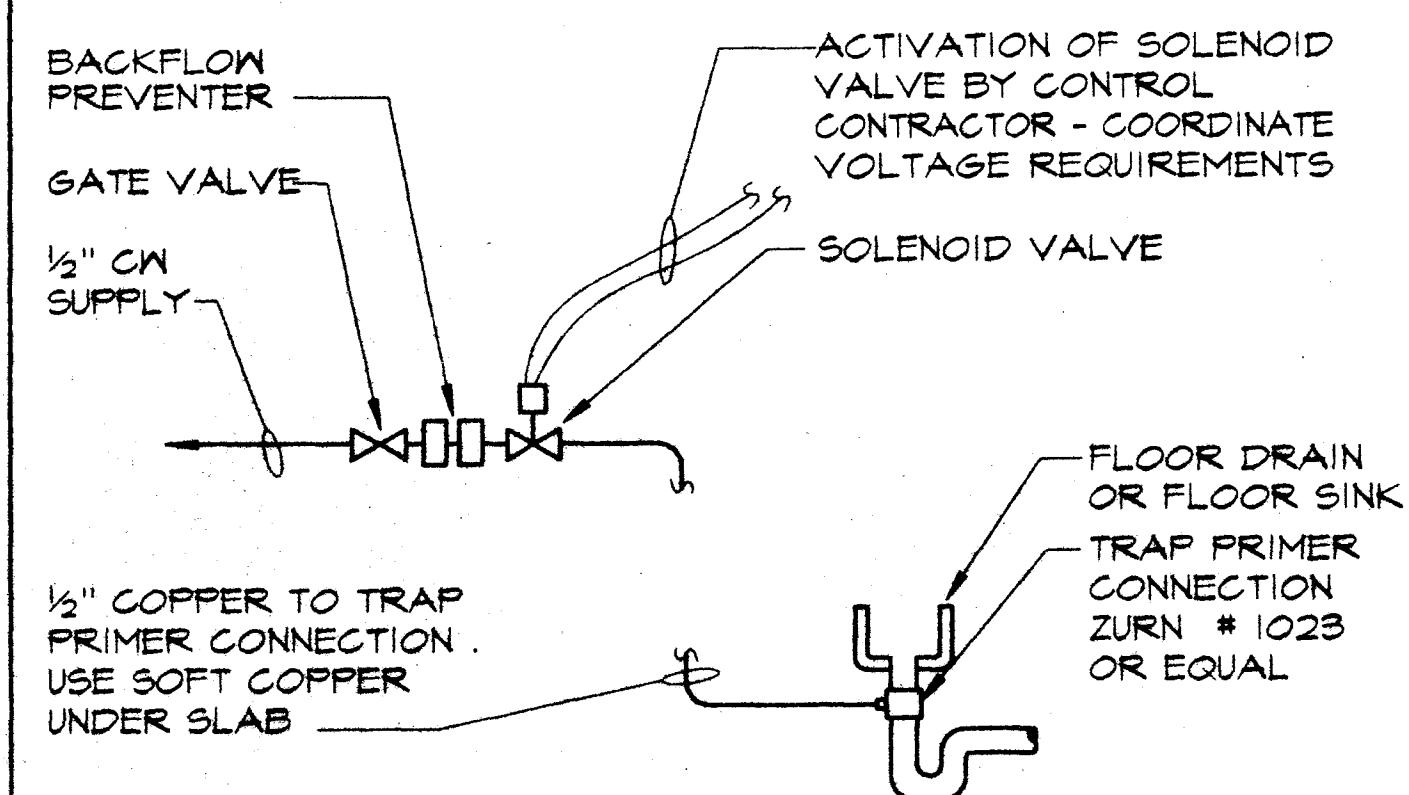


TRAP PRIMER DETAIL 8
NTS (MECHANICAL ROOM) (P4.1)

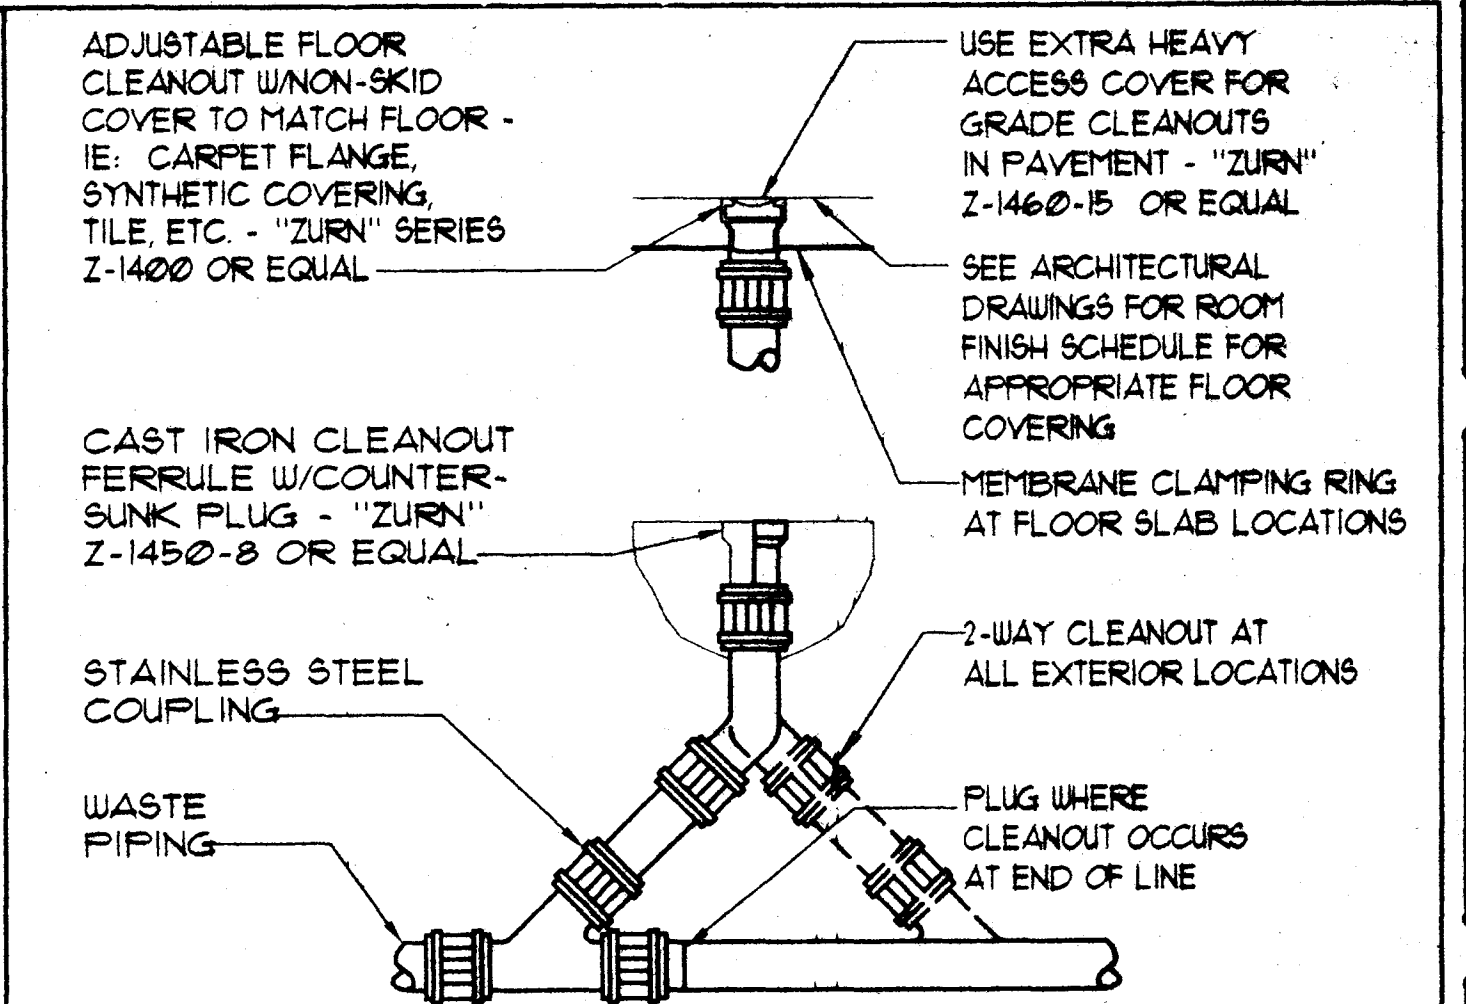


CLEANOUT DETAIL 1
NTS (P4.1)

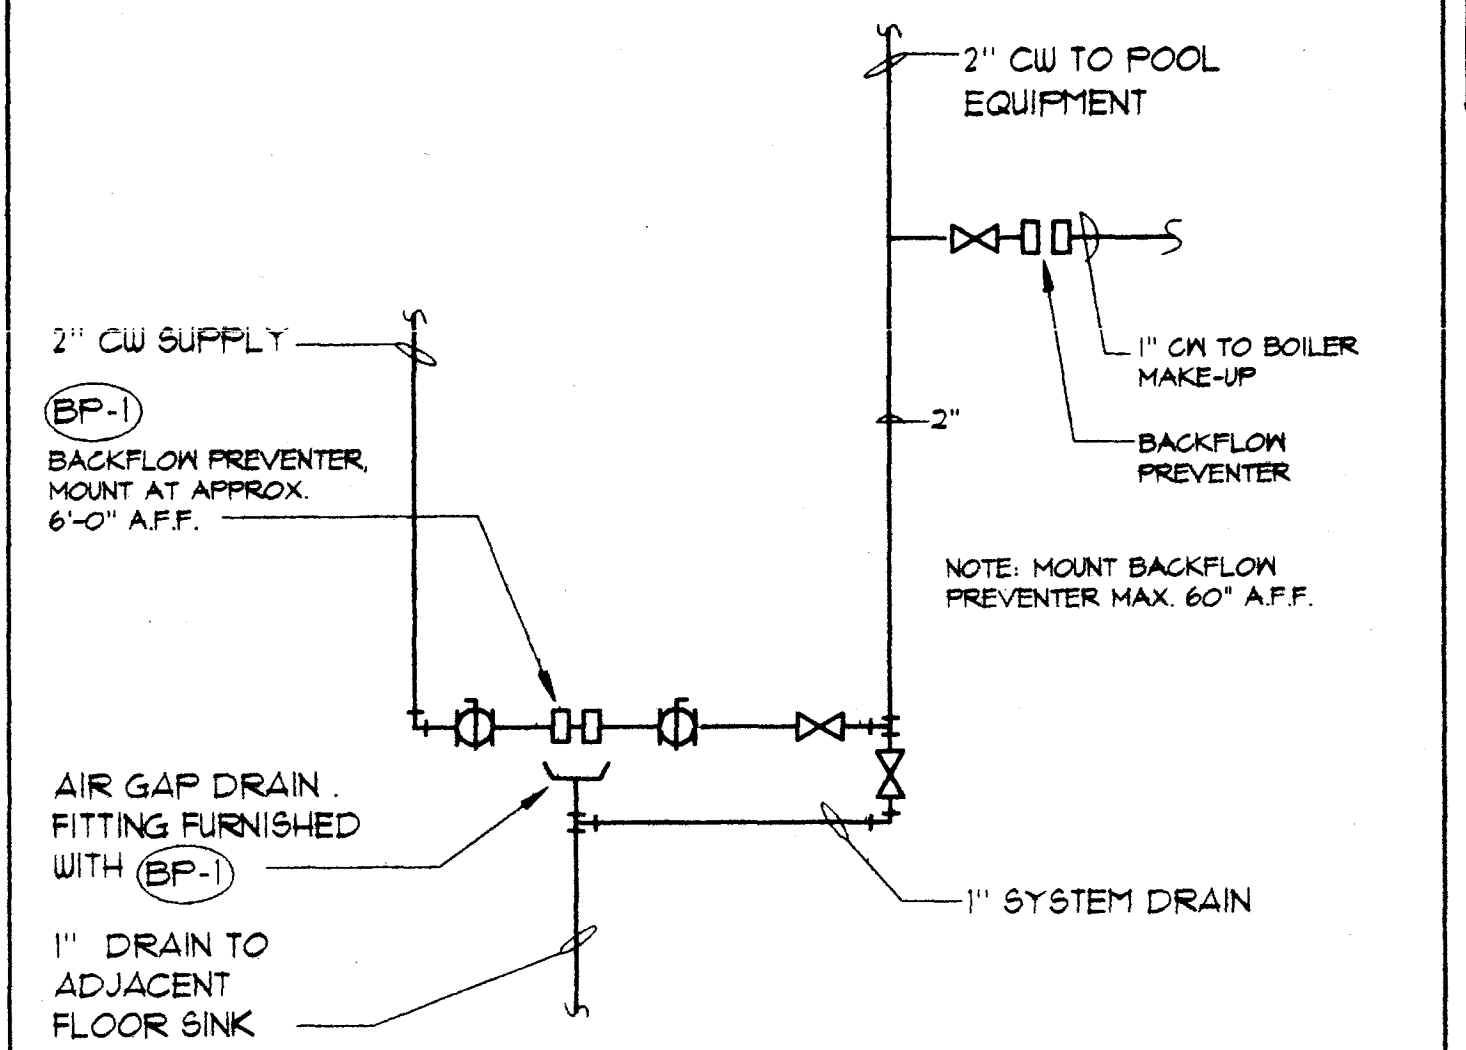

BACKFLOW PREVENTER DETAIL 2
NTS (P4.1)

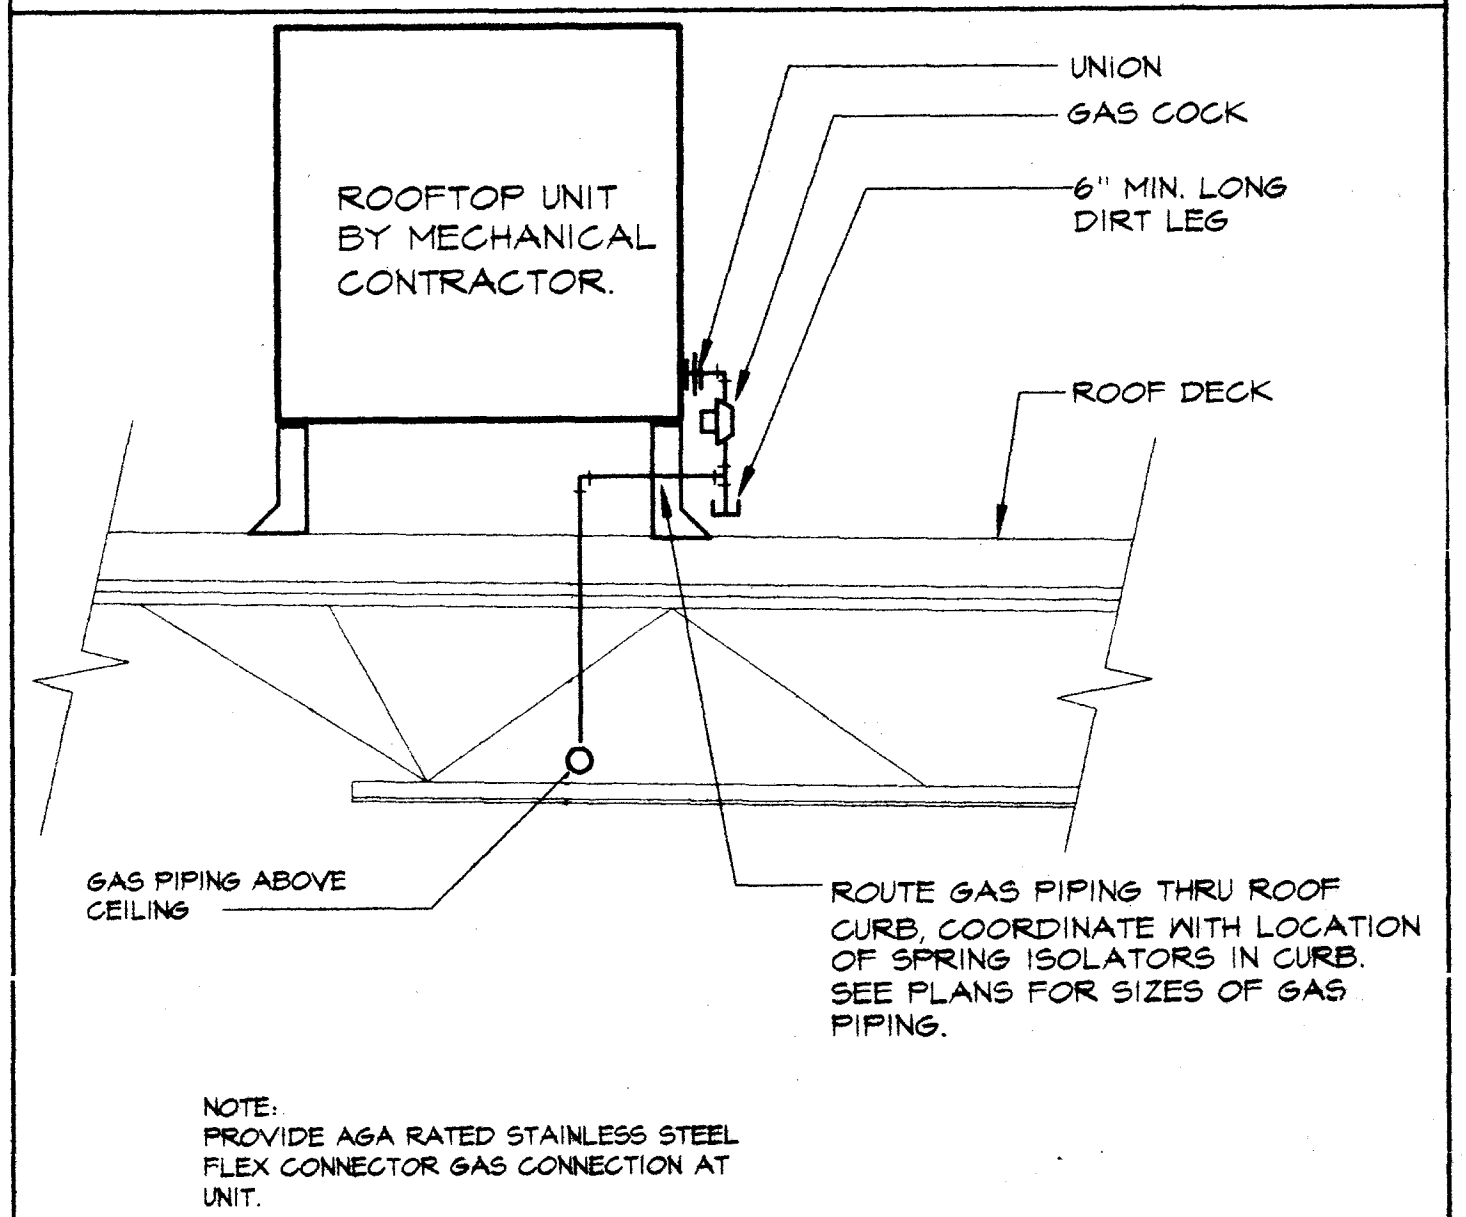

GAS CONNECTION AT ROOFTOP UNITS 3
NO SCALE: (P4.1)

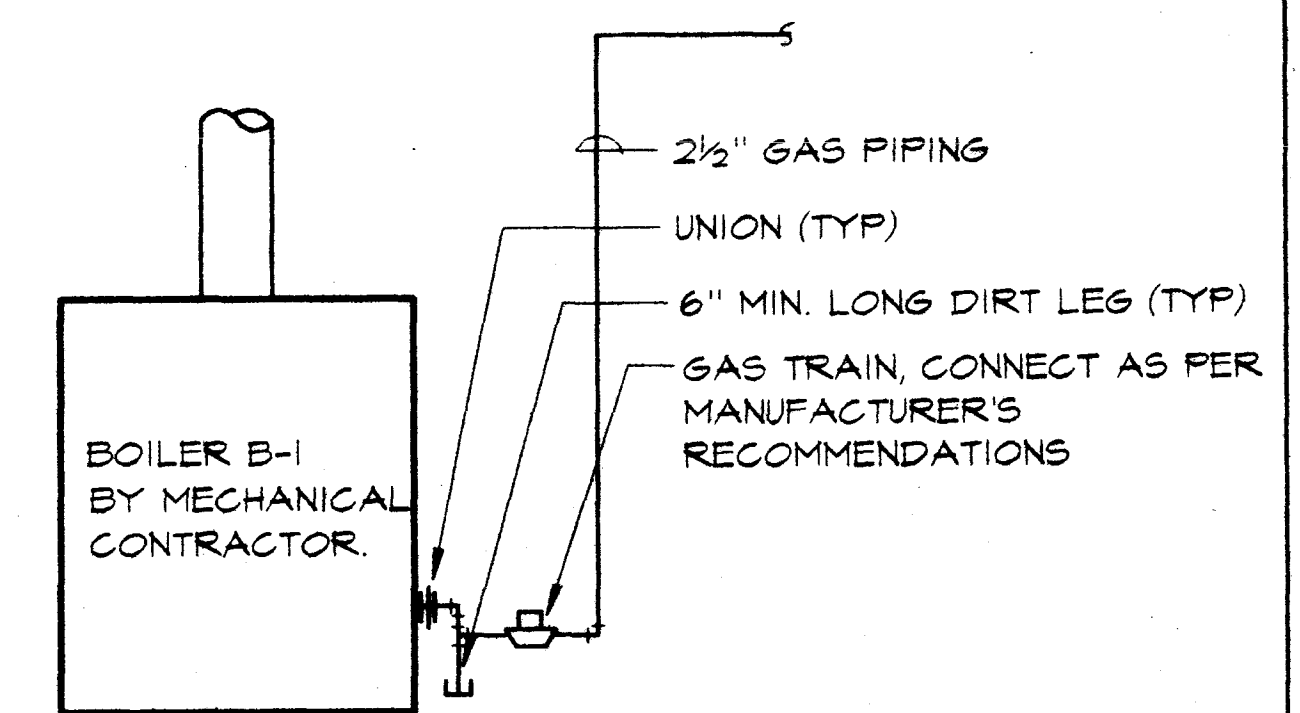

GAS CONNECTION AT BOILERS DETAIL 4
NO SCALE: (P4.1)


PETTY & ASSOCIATES, INC.
 MECHANICAL ENGINEERING CONSULTANTS
 1375 GREG STREET, SUITE 108
 SPARKS, NEVADA 89431
 (702) 358-5777 FAX 358-1118

SWISHER & HALL
 AIA, LIMITED
 ARCHITECTURE AND PLANNING
 1400 SOUTH LAS VEGAS BLVD., SUITE C
 LAS VEGAS, NEVADA 89128
 702.363.2222 702.363.6060 (FAX)


AS BUILT
 PLUMBING DETAILS
 MUNICIPAL POOL AT DULA CENTER
 CITY OF LAS VEGAS

Job no: 9100400
 Date: ETH
 Drawn by: 09/25/1997
 Checked by: WRP


Issued for 75% SUBMITTAL

sheet no. **P4.1**
 94 OF 104


674-22

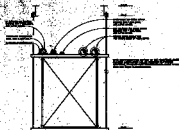

TYPICAL SUPPORT DETAIL

 


TRAP PRIMER PUMP DETAIL

 

VENT PIPE THRU ROOF DETAIL



 
CLEANOUT DETAIL




TRAP PRIMER MANIFOLD DETAIL



 
PIPE PENETRATION DETAIL




SCUPPER PREVENTER DETAIL

 


WATER HEATER DETAIL

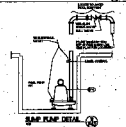


SUMP PUMP DETAIL

 


ROOF DRAIN DETAIL

 

GAS CONNECTION AT ROOFTOP UNITS

 

VENT PIPE DETAIL AT ROOF

 

TRAP PRIMER DETAIL



GAS CONNECTION AT WALL DETAIL