


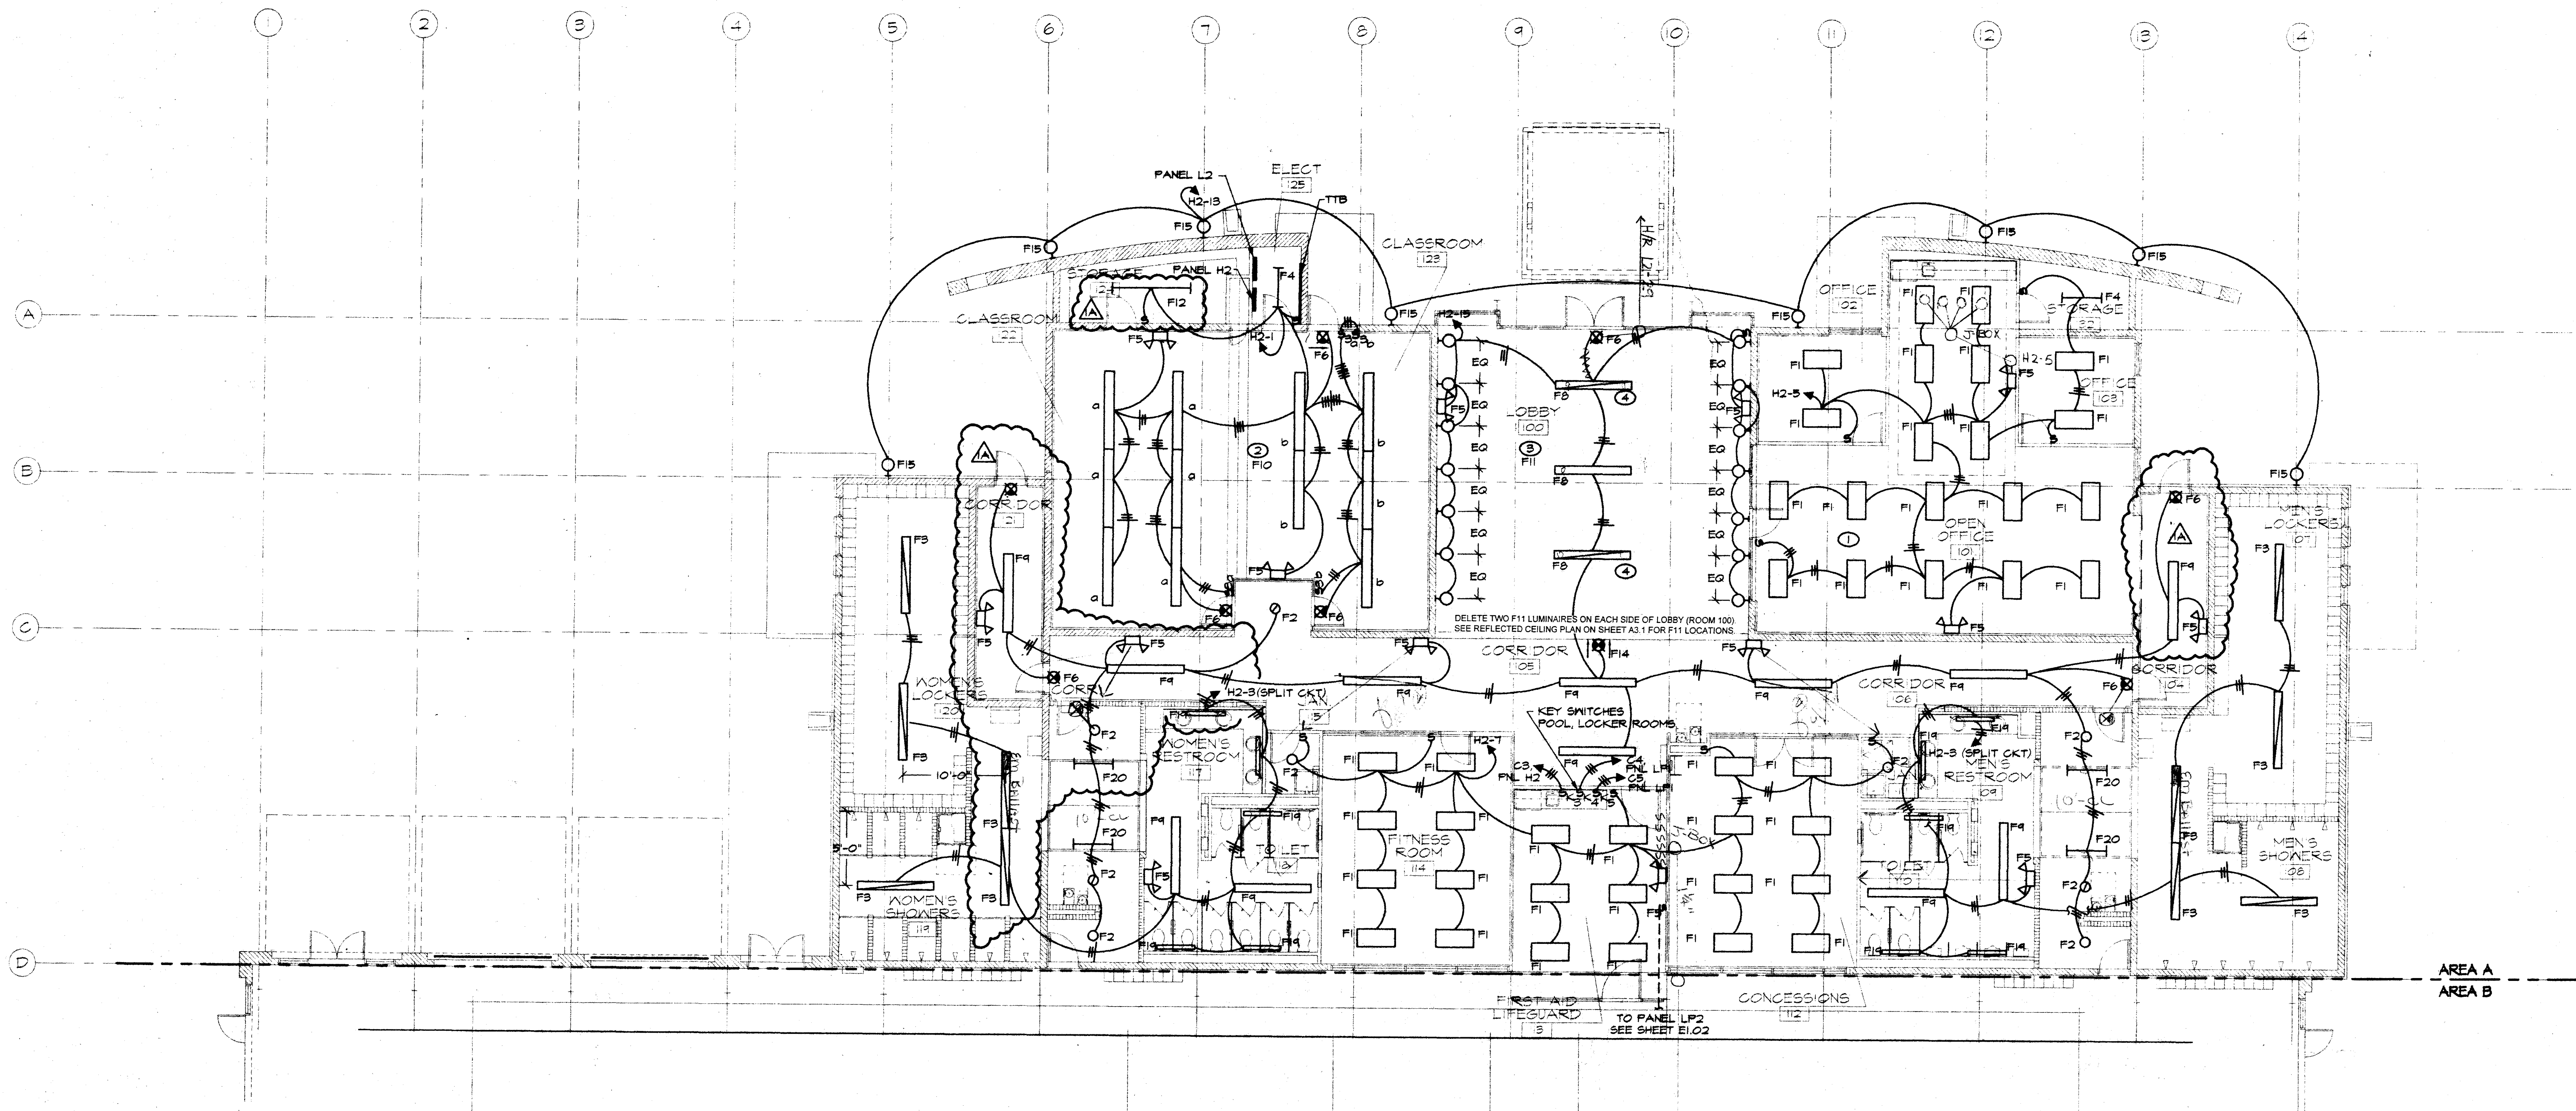

ELECTRICAL LIGHTING PLAN SCALE: 1/8"=1'-0"

NOTES:

- ① PROVIDE MULLION MOUNTED SWITCH
- ② ALL LUMINAIRES IN THIS ROOM ARE F10 UNLESS NOTED OTHERWISE
- ③ ALL LUMINAIRES IN THIS ROOM ARE F11 UNLESS NOTED OTHERWISE
- ④ CONNECT FIXTURE UNSWITCHED FOR NIGHT LIGHT OPERATION

JBOX FOR ROOF PANELS

AS BUILT

TJKROB CONSULTING ENGINEERS, INC.
1919 S. JONES BLVD. SUITE B
LAS VEGAS, NEVADA 89102
(702) 871-3621
ELECTRICAL ENGINEERING

sheet title
**PARTIAL ELECTRICAL FLOOR PLAN-LIGHTING
BATH HOUSE**
job title
MUNICIPAL POOL AT DULA CENTER
job no.
TJ15/LT6A
date
12-14-41
drawn by
DSN/DRS
checked by
TOM KROB

issued for
PLAN REVIEW

sheet no.
E1.01
98 OF 104
of


SWISHER & HALL
AIA, LIMITED
ARCHITECTURE AND PLANNING
2801 NORTH TNEVADA W60126
LAS VEGAS, NEVADA 89126
702.363.2222 702.363.6060 (FAX)

revision
PLAN CHECK COMMENTS
12-14-41

Swisher & Hall
AIA, Limited
Architecture and Planning
Copyright 1998 ©

sheet

67422

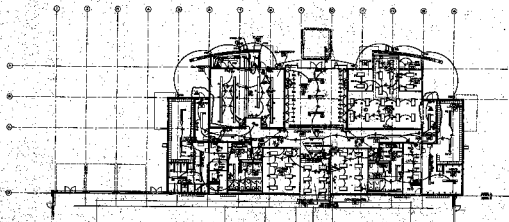

ELECTRICAL SYMBOLS

- 1. POWER SOURCE
- 2. SWITCHING POINT
- 3. ELECTRICAL EQUIPMENT
- 4. ELECTRICAL CABLE

AS BUILT

KROB
ENGINEERING
INCORPORATED

SWINER & HALL
AIA, LIMITED
CONSTRUCTORS, 227, CHANCERY
ST. LONDON, E.C. 4

GENERAL ELECTRICAL WORK PLANS
WITHIN THE
GENERAL ELECTRICAL WORK PLANS

AS BUILT

ELCO