




ARCHITECTURE AND PLANNING
2801 NORTH TENNY WAY, SUITE
LAS VEGAS, NEVADA 891
702.363.3222 • 702.363.6060 (FAX)

146" 1'-2

11-25-97

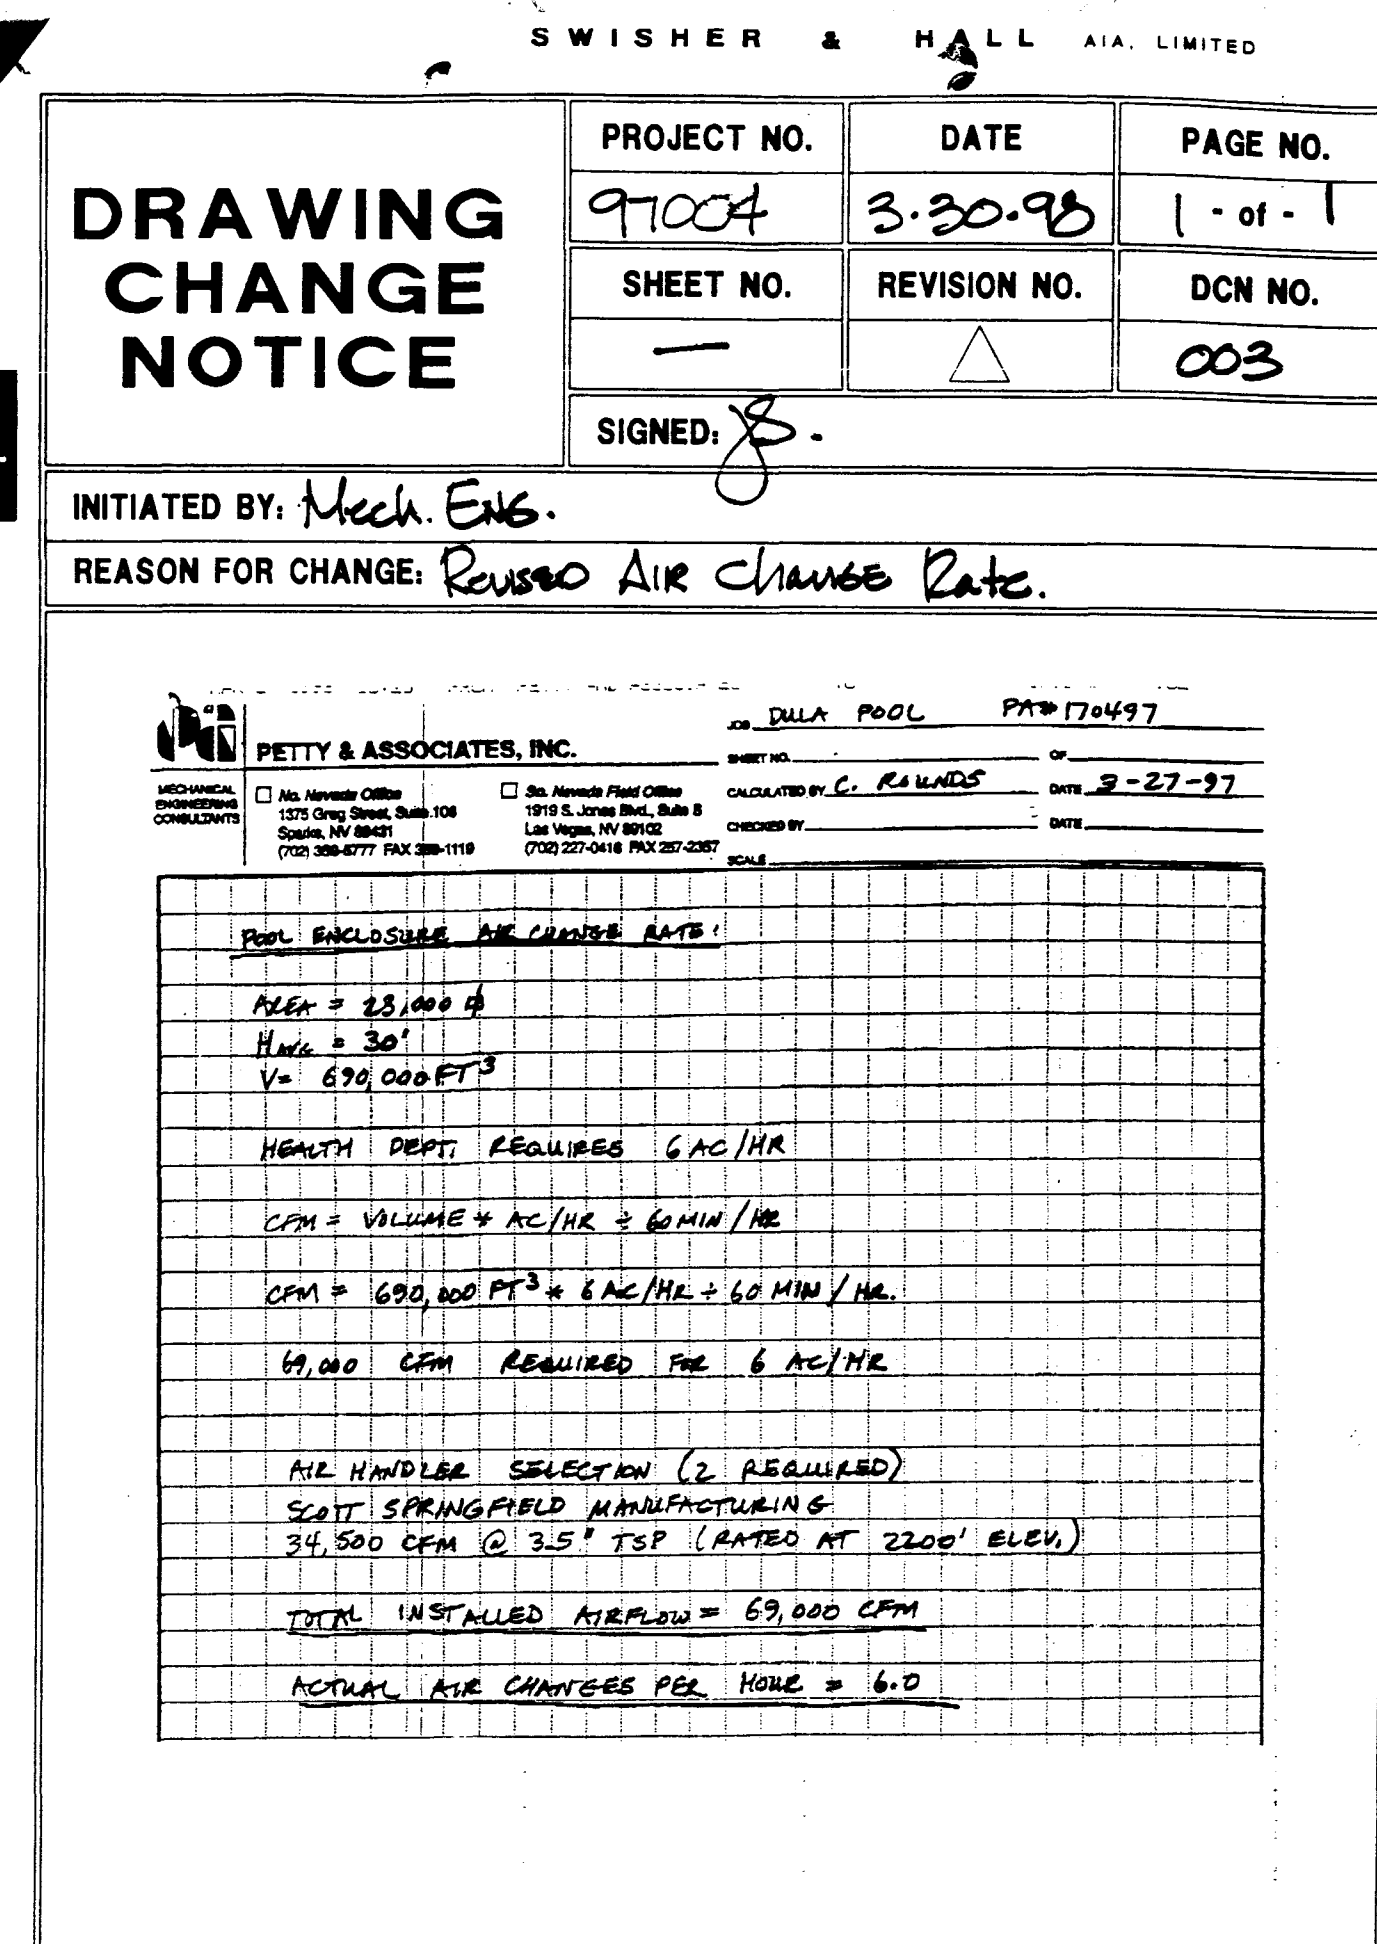

PIA
MECHANICAL
ENGINEERING

PA# 170497

SOCIATES, INC.

AS BUILT

issued for
PLAN
REVIEW

sheet no.

M2.3
82 OF 104

674-22

MECHANICAL ROOF PLAN

MUNICIPAL POOL AT DULA CENTER CITY OF LAS VEGAS

job no:
97004.00
date:
10-10-97
drawn by:
C.L.R.
checked by:

issued for
PLAN
REVIEW

sheet no.

M2.3
82 OF 104

674-22

SWISHER & HALL
AIA, LIMITED
ARCHITECTURE AND PLANNING
2801 NORTH TENAYA WAY, SUITE C
LAS VEGAS, NEVADA 89128
702.368.2222 702.363.0060 (FAX)

**SWISHER & HALL
AIA, LIMITED**

ARCHITECTURE AND PLANNING
2801 NORTH TENAYA WAY, SUITE C
LAS VEGAS, NEVADA 89128
702.369.2222 702.363.6060 (FAX)



MECHANICAL ROOF PLAN

MUNICIPAL POOL AT DULA CENTER CITY OF LAS VEGAS

job no:
97004.00
date:
10-10-97
drawn by:
C.L.R.
checked by:


issued for
PLAN
REVIEW

sheet no.

M2.3
82 OF 104

674-22

TECHNICAL ROOF PLAN

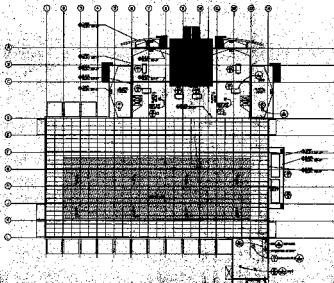

DRAWING CHANGE NOTICE

WORK IN PROGRESS
REVISIONS

NO.	DATE	BY	CHKD.	REVISION
1	10/10/77	...	...	...
2	...	...	...	...
3	...	...	...	...
4	...	...	...	...
5	...	...	...	...
6	...	...	...	...
7	...	...	...	...
8	...	...	...	...
9	...	...	...	...
10	...	...	...	...
11	...	...	...	...

AS BUILT

TECHNICAL ROOF PLAN

SWISSER & HALL
ARCHITECTS
P.C.

SWISSER & HALL
ARCHITECTS
P.C.