
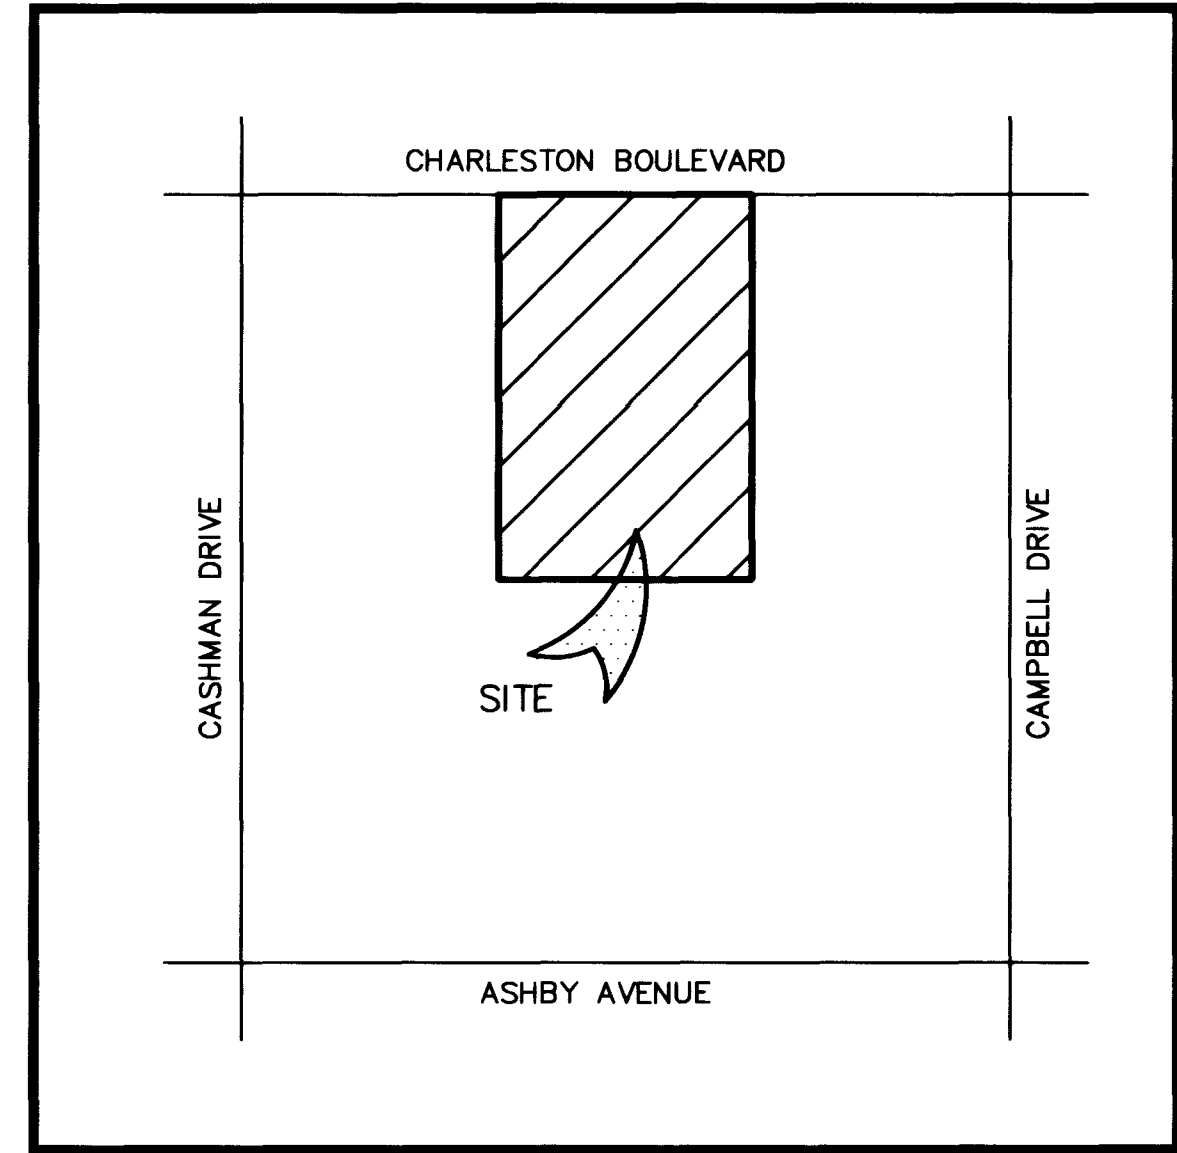


H:\Projects\354040\DWG\PC-VIC Tue Jul 21 16:14:33 1998 PLOTTED BY: SLB

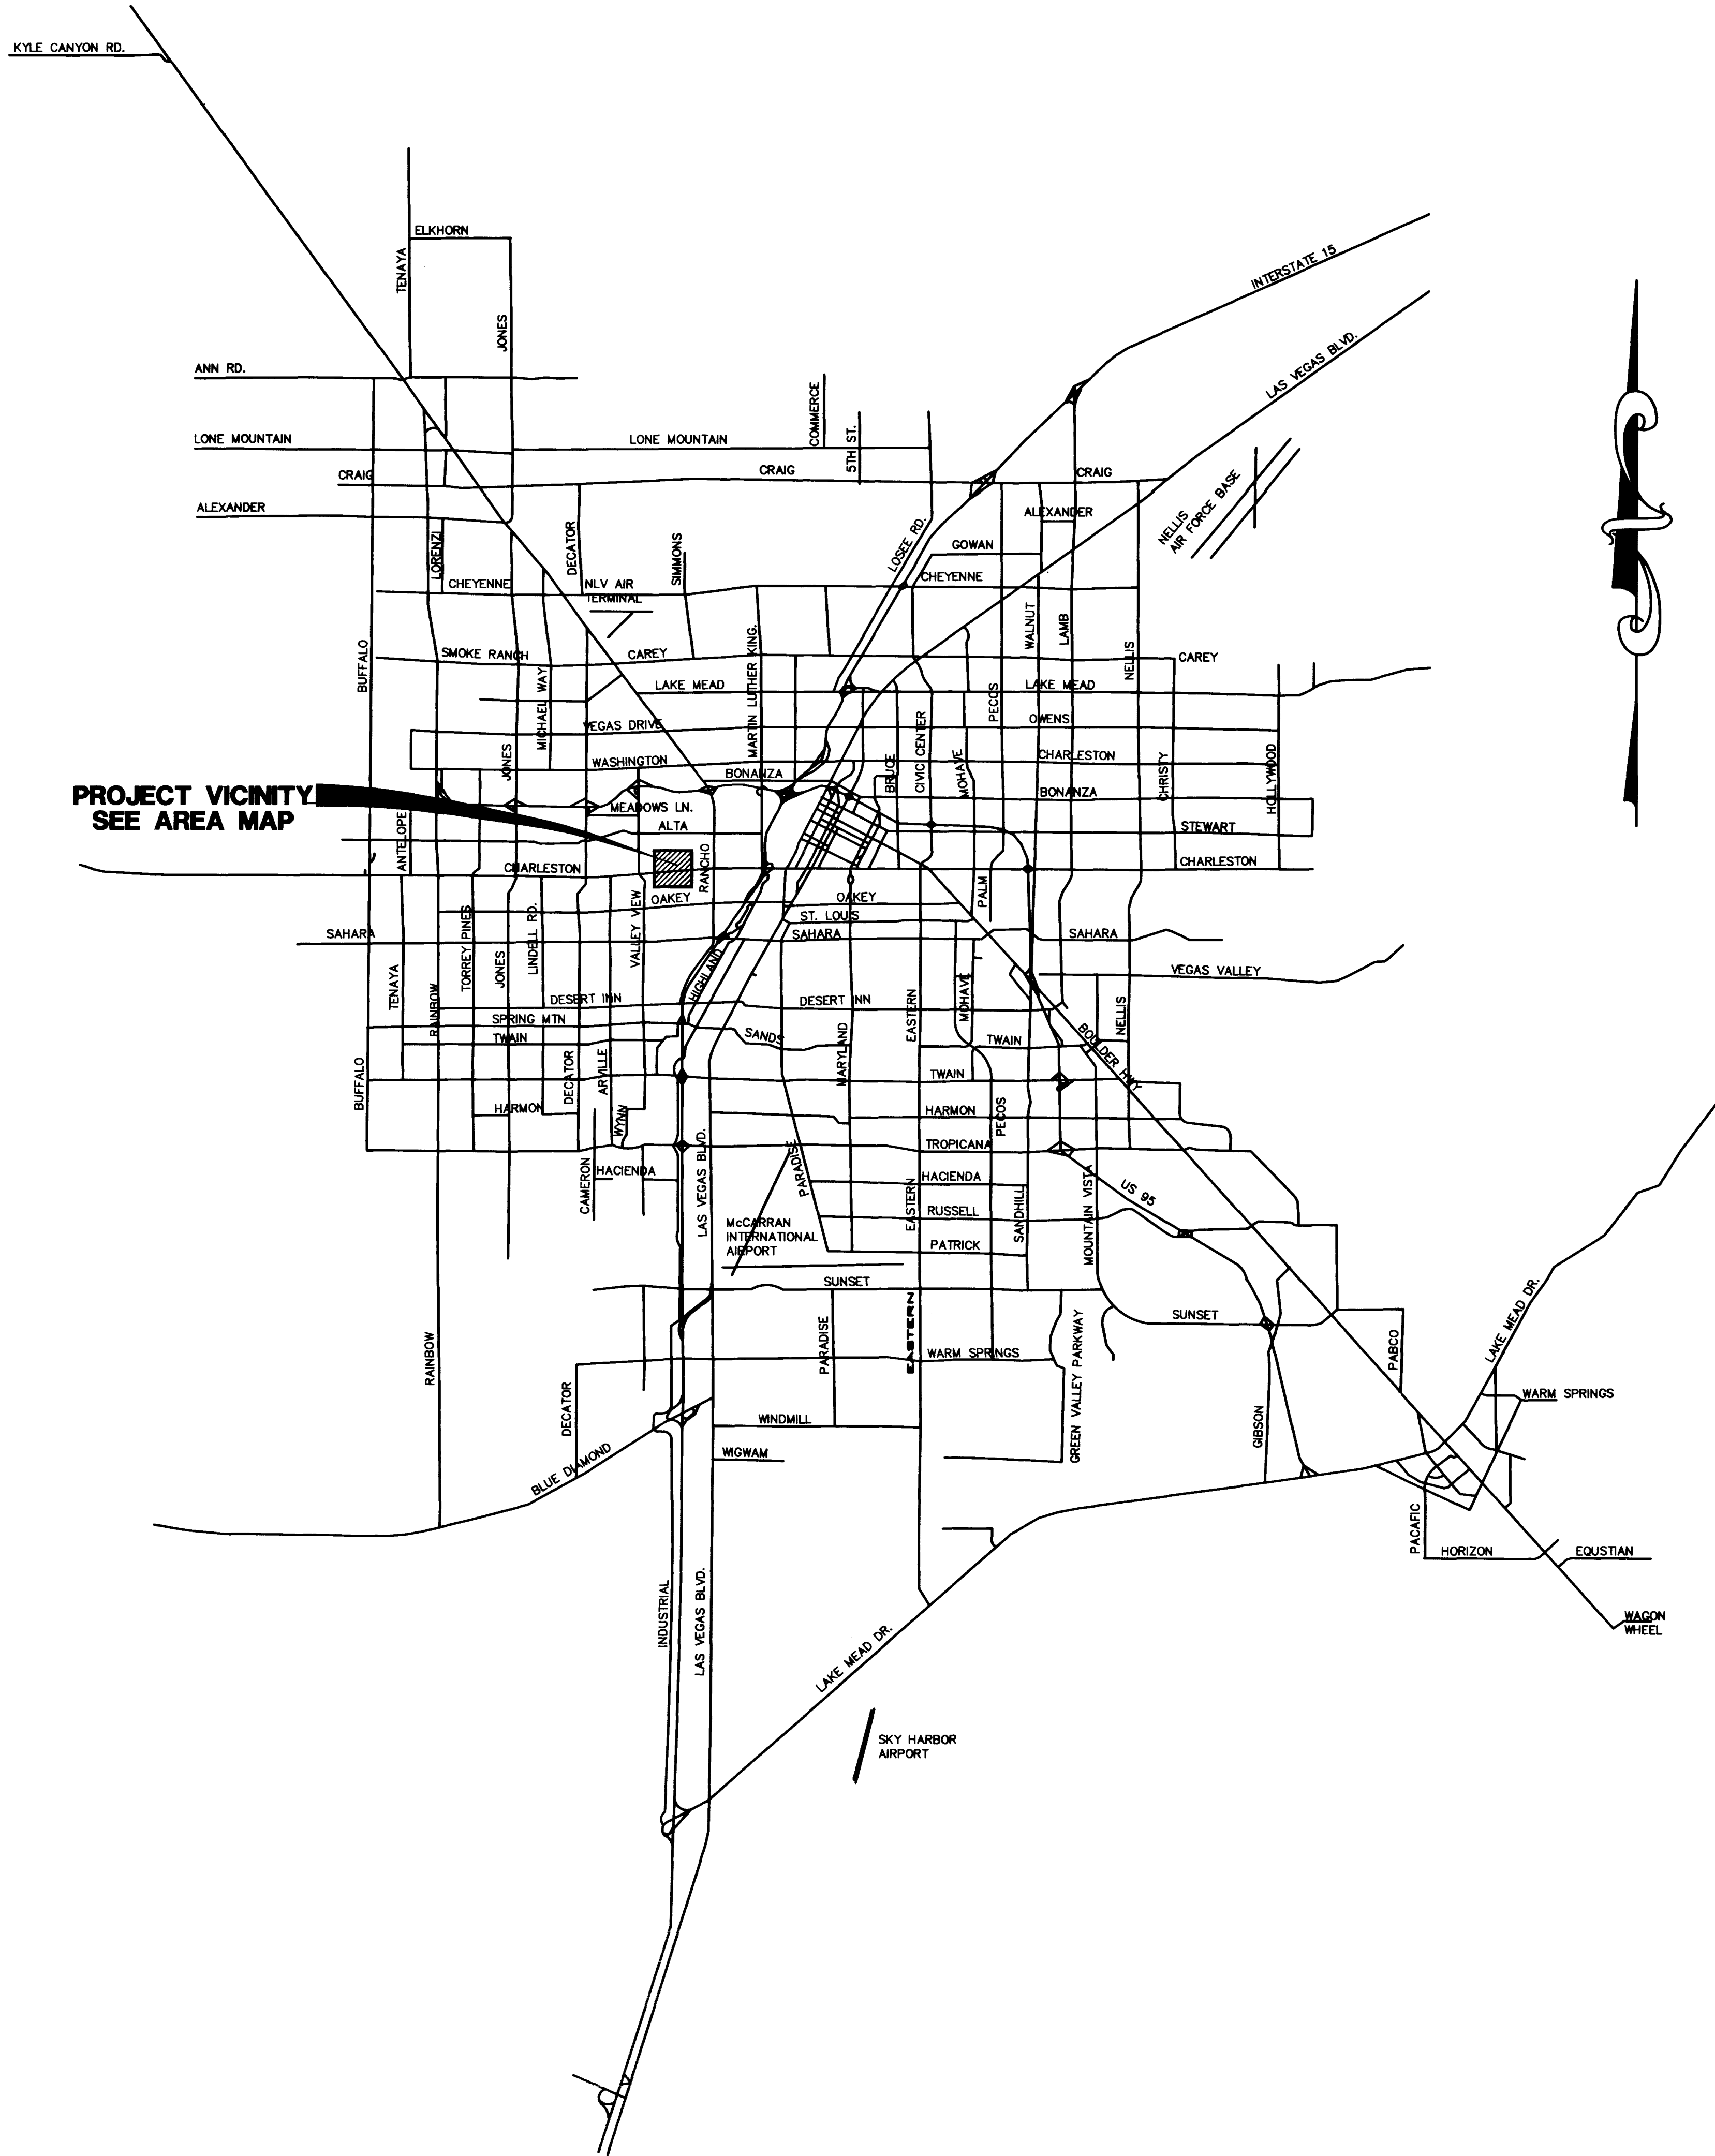

AREA MAP
SCALE: NONE

SHEET INDEX

SHEET #	SHEET	DESCRIPTION
1	C1	COVER SHEET
2	C2	VICINITY MAP
3	C3	GENERAL NOTES SHEET
4	C4	QUANTITY AND SCHEDULE SHEET
5	C5	MASTER UTILITY PLAN
6	G1	GRADING PLAN
7	G2	GRADING PLAN SECTIONS & DETAILS
8	D1	DEMOLITION PLAN
9	H1	HORIZONTAL CONTROL PLAN
5A	C5A	FIRE ACCESS LANE

DISCLAIMER NOTE

UTILITY LOCATIONS SHOWN HEREON ARE APPROXIMATE ONLY. IT SHALL BE THE CONTRACTOR'S RESPONSIBILITY TO DETERMINE THE EXACT HORIZONTAL AND VERTICAL LOCATION OF ALL EXISTING UNDERGROUND AND OVERHEAD UTILITIES PRIOR TO COMMENCING CONSTRUCTION. NO REPRESENTATION IS MADE THAT ALL EXISTING UTILITIES ARE SHOWN HEREON. THE ENGINEER ASSUMES NO RESPONSIBILITY FOR UTILITIES NOT SHOWN OR UTILITIES NOT SHOWN IN THEIR PROPER LOCATION.

Avoid cutting underground utility lines. If it is costly.
Call before you Dig
1-800-227-2600
UNDERGROUND SERVICE (USA)

Avoid overhead power line contact.
Call before you OVERHEAD
1-702-593-6111
NEVADA POWER CORPORATION AND SAFETY SERVICES DEPARTMENT

SHEET		TITLE	
DRAWN BY: SLB/JSB		PROJECT NO: 554-040-981	
DESIGNED BY: PK		SCALE:	
CHECKED BY:		SHEET	
PROJECT NO: 554-040-981		C2	
DRAWING NO. 107-V2912		2 OF 9 SHEETS	
TERRA WEST DEVELOPMENT 2685 S. RAINBOW #201 LAS VEGAS, NV 89102 (702) 362-1054 / 362-8552			
L. R. NELSON CONSULTING ENGINEERS, INC. 3035 East Pottsdam Lane Suite 9 Las Vegas, Nevada 89120 (702) 798-7978 (702) 551-2226 FAX			
• STRUCTURAL • CIVIL • SURVEY			
REV. DATE BY			
1/24/97 RT ADD SHEET CSA TO DWG. PKG. 113-3-17			

