

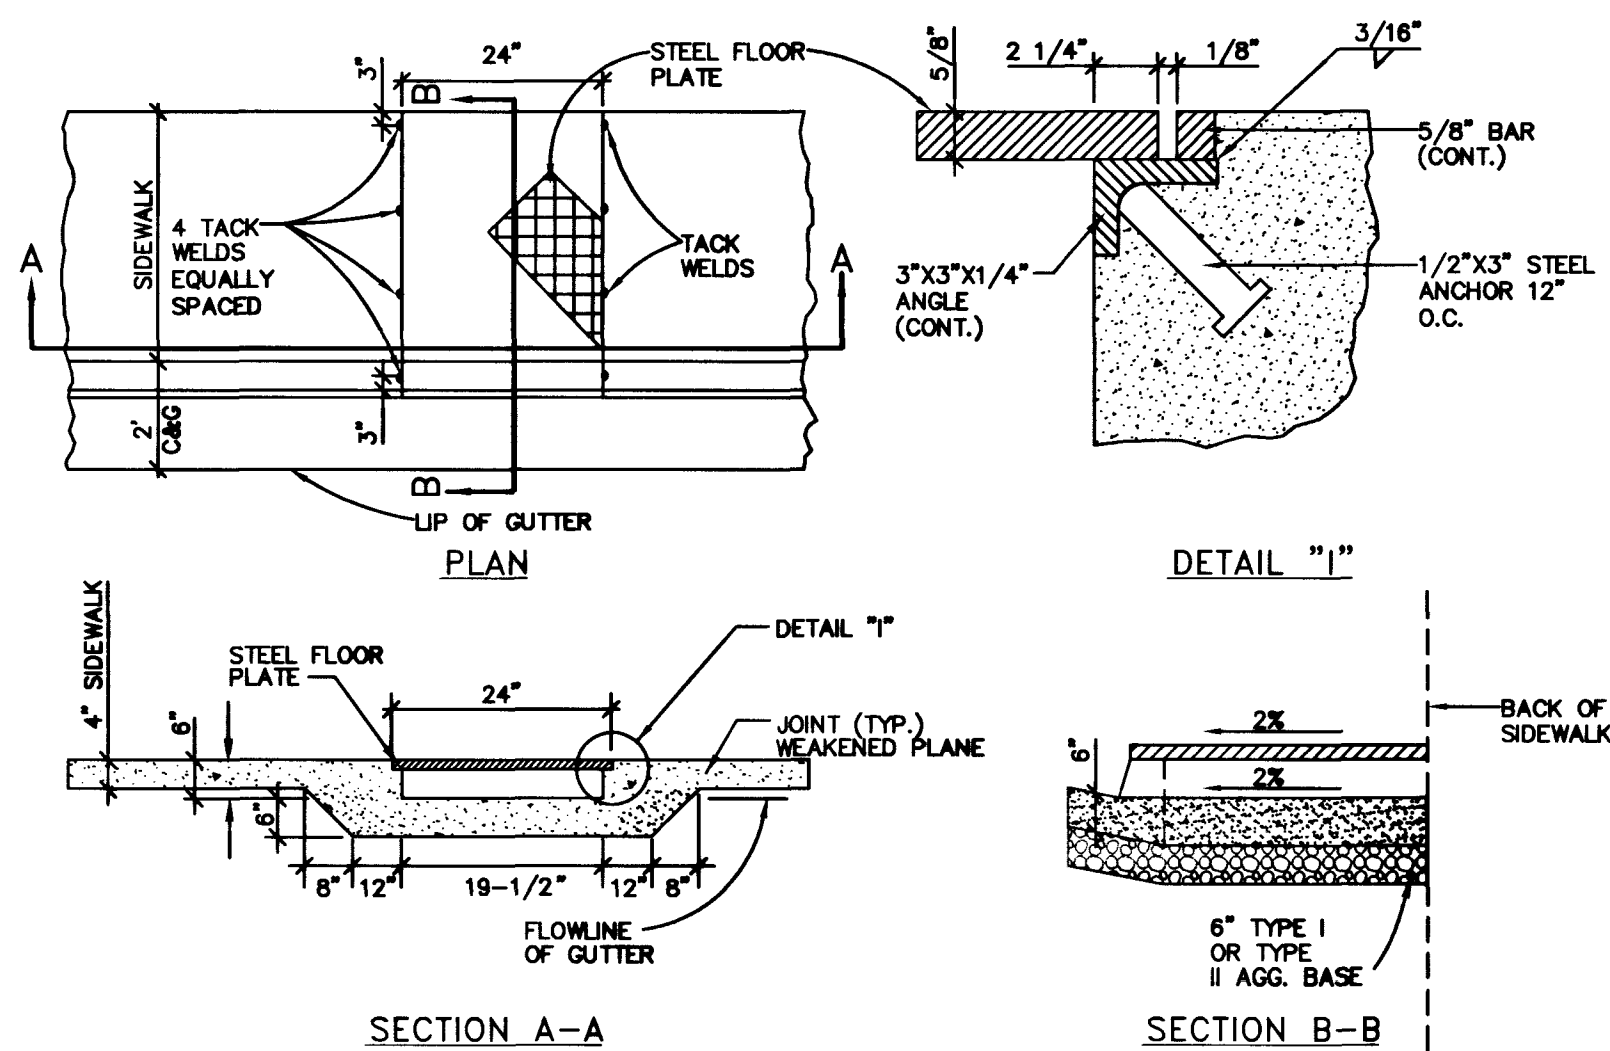
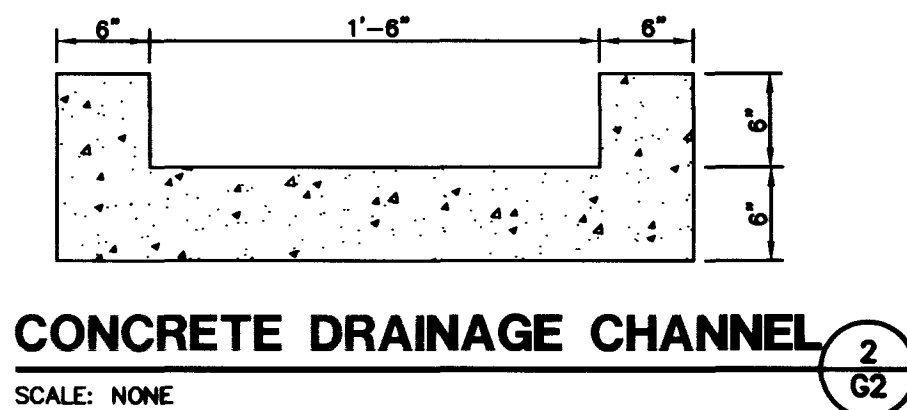
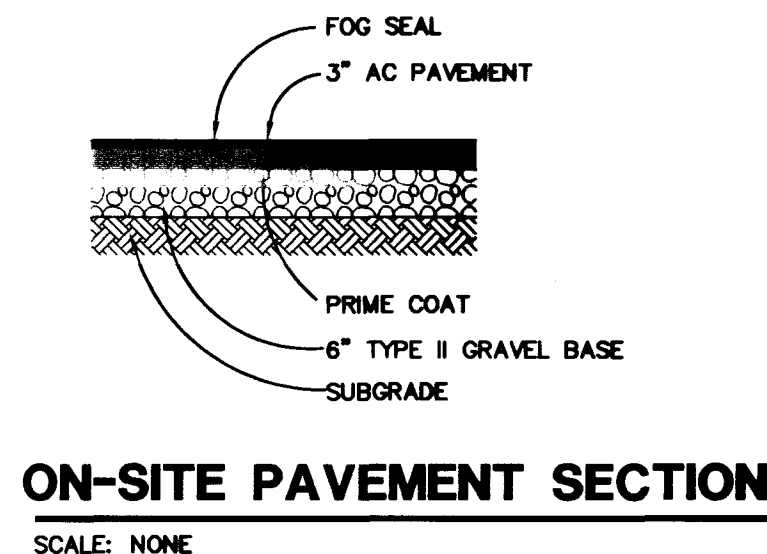
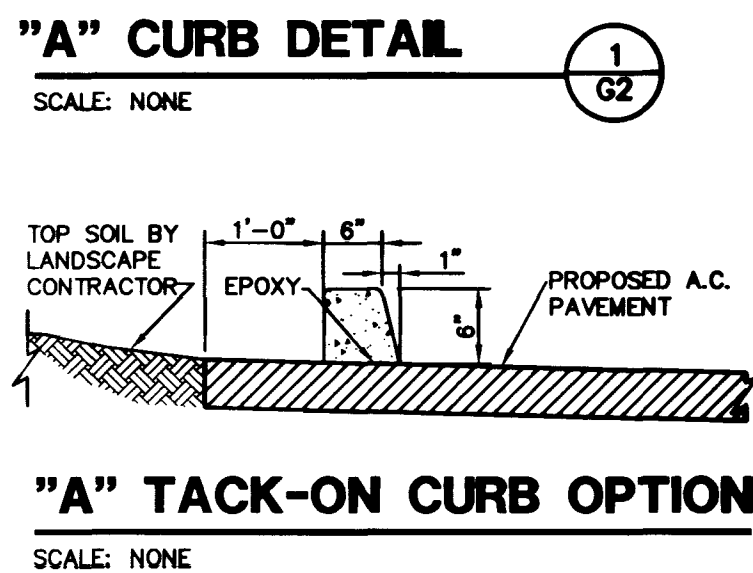
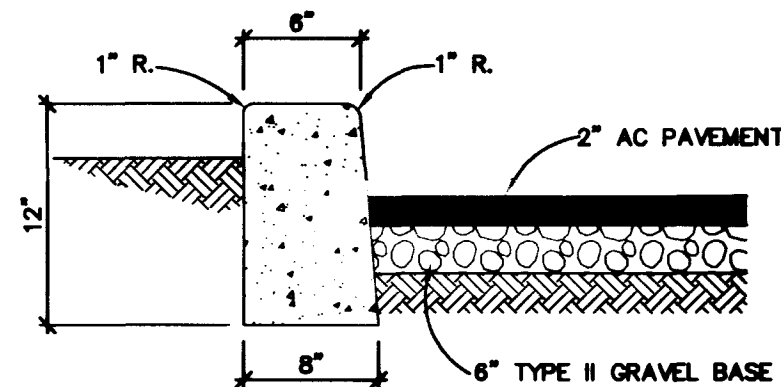
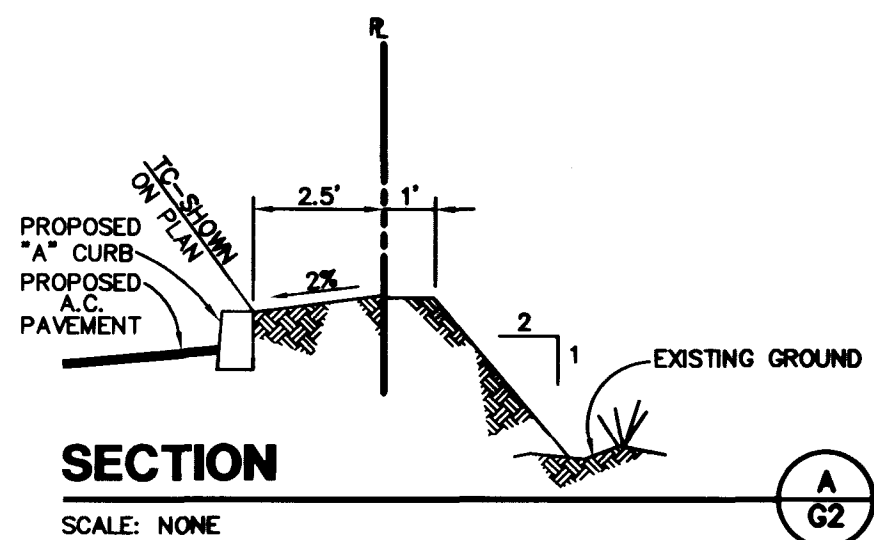
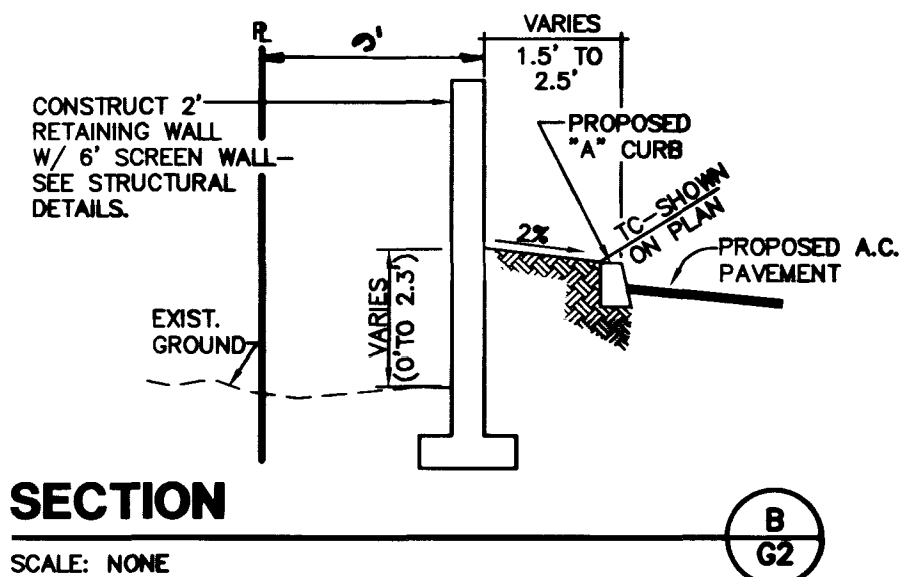
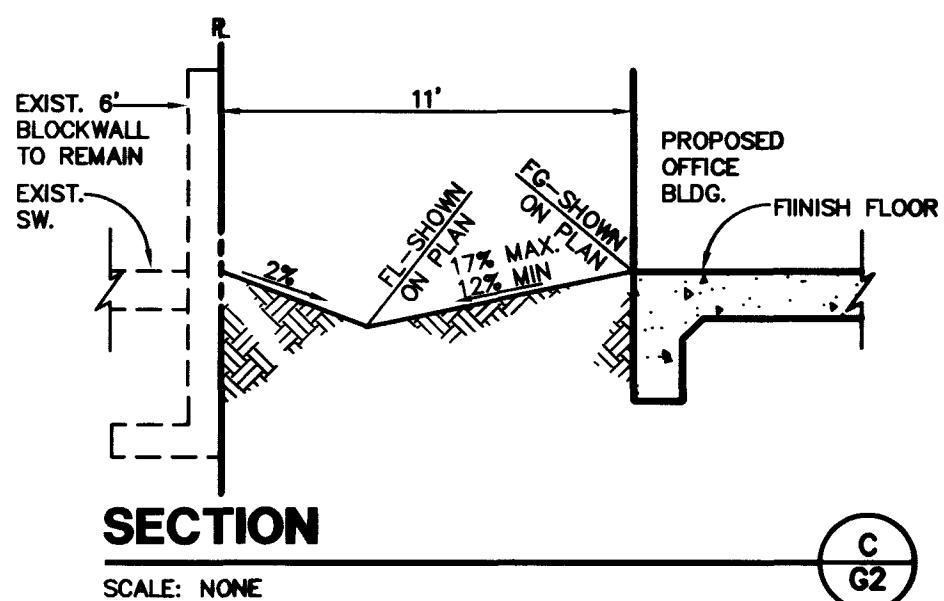
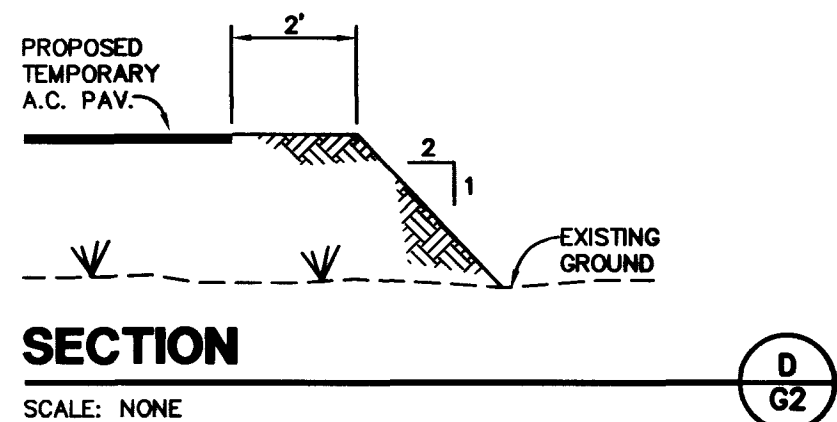
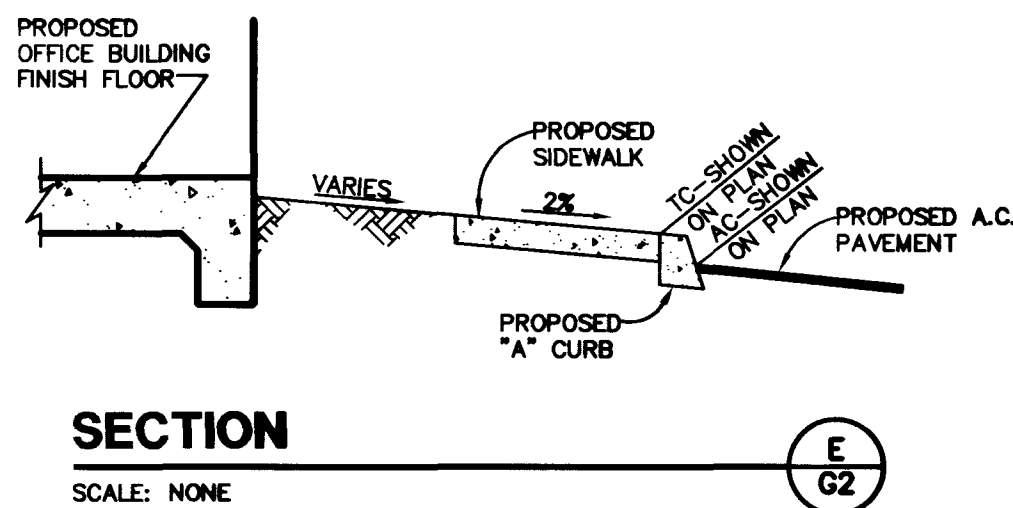


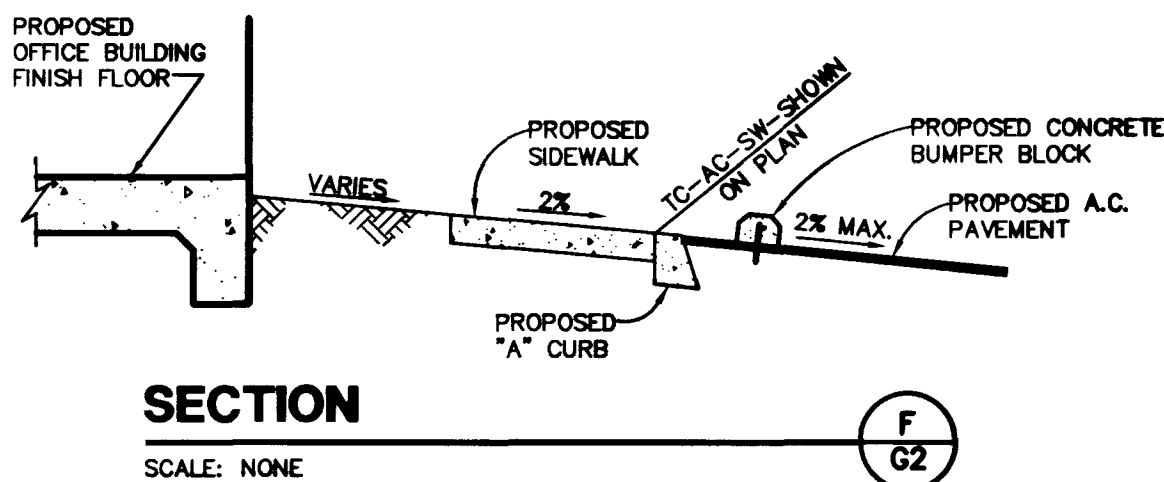

NOTE: ALL EXPOSED PARTS SHALL BE GALVANIZED AND ALL GALVANIZING DAMAGED BY FABRICATION OR INSTALLATION SHALL RECEIVE TWO COATS OF ALUMINUM PAINT (GALVANOX OR EQUAL).

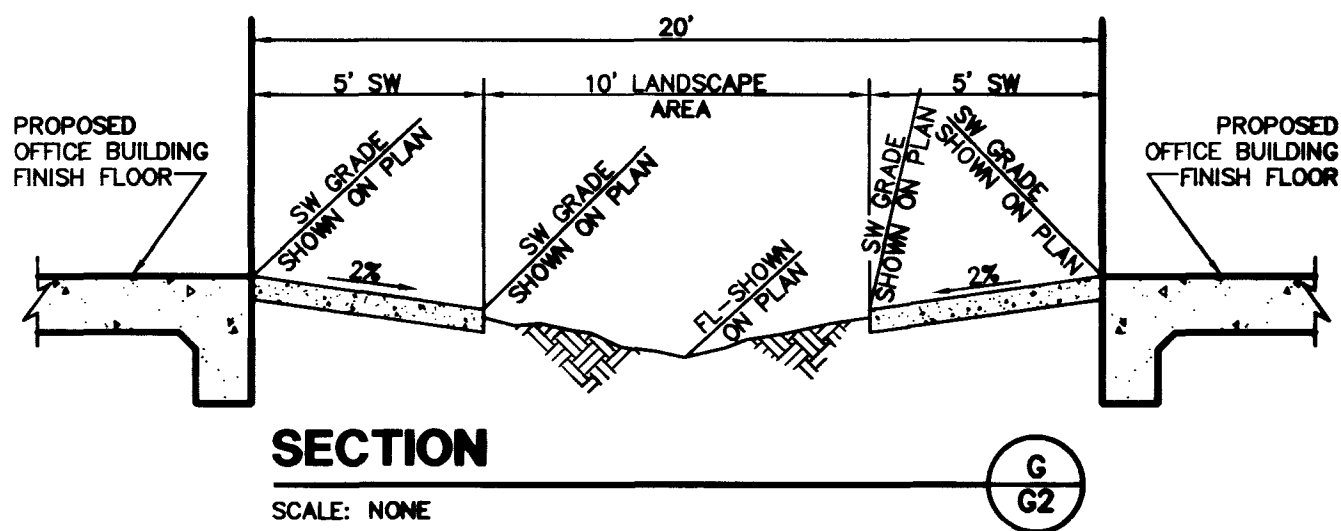

DISCLAIMER NOTE

UTILITY LOCATIONS SHOWN HEREON ARE APPROXIMATE ONLY. IT SHALL BE THE CONTRACTOR'S RESPONSIBILITY TO DETERMINE THE EXACT HORIZONTAL AND VERTICAL LOCATION OF ALL EXISTING UNDERGROUND AND OVERHEAD UTILITIES PRIOR TO COMMENCING CONSTRUCTION. NO REPRESENTATION IS MADE THAT ALL EXISTING UTILITIES ARE SHOWN HEREON. THE ENGINEER ASSUMES NO RESPONSIBILITY FOR UTILITIES NOT SHOWN OR UTILITIES NOT SHOWN IN THEIR PROPER LOCATION.

Avoid cutting underground utility lines. If's costly.
Call before you dig
1-800-227-2600
UNDERGROUND SERVICE (USA)

Avoid overhead power line contact
Call before you overhead
1-702-593-6111
OVERHEAD POWER DEPARTMENT AND SAFETY SERVICES DEPARTMENT

TERRA WEST DEVELOPMENT

GRADING PLANS
SEWER DETAILS

SHEET

DRAWN BY:
JSC

DESIGNED BY:
JSC

CHECKED BY:

PROJECT NO:
554-040-981

SCALE:

DATE:

BY:

REVISION

107-V2912

L. R. NELSON CONSULTING ENGINEERS, INC.

OFFICE PROJECT
CHARLESTON / CAMPBELL

TITLE

DESIGNED BY:
JSC

CHECKED BY:

PROJECT NO:
554-040-981


SCALE:

DATE:

BY:

REVISION

107-V2912

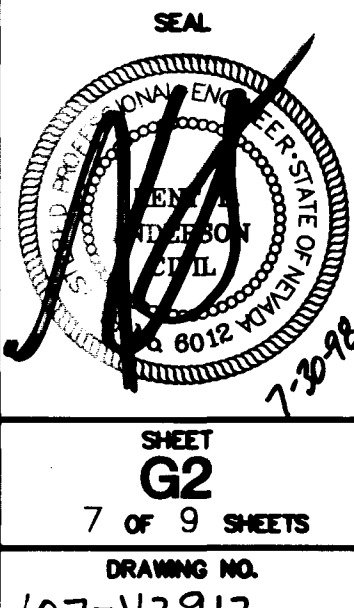

SHEET
G2

7 OF 9 SHEETS

DRAWING NO.

107-V2912

