

NOTICE!

EXISTING UTILITIES ARE SHOWN ON PLANS FOR THE CONVENIENCE OF THE CONTRACTOR ONLY. THE CONTRACTOR IS RESPONSIBLE FOR THE PROTECTION OF ALL UTILITIES. THE ENGINEER BEARS NO RESPONSIBILITY FOR UTILITIES NOT SHOWN OR SHOWN INCORRECTLY.

Call BEFORE YOU Dig

1-800-227-2600
UNDERGROUND SERVICE (USA)

NOTE:

CornerStone Engineering Incorporated ASSUMES NO RESPONSIBILITY FOR EXISTING UTILITY LOCATIONS, SHOWN OR NOT SHOWN. THE UTILITIES SHOWN ON THIS DRAWING HAVE BEEN PLOTTED FROM RECORD INFORMATION AND ARE FOR THE CONVENIENCE OF THE CONTRACTOR ONLY. IT IS THE CONTRACTOR'S RESPONSIBILITY TO FIELD VERIFY THE LOCATION AND DEPTH OF ALL RELEVANT UTILITIES PRIOR TO COMMENCEMENT OF ANY CONSTRUCTION. IF A CONFLICT OR DISCREPANCY IS DISCOVERED, THE CONTRACTOR IS TO NOTIFY THE ENGINEER OR WORK IN WRITING, IMMEDIATELY.

PLAN QUANTITIES

8" PVC FIRE SERVICE	571 LF
FIRE HYDRANT ASSEMBLY	1 EA
FREE STANDING FDC	1 EA
PV	1 EA
8" DCDA	1 EA
8" PVC WATER	2 LF

CONTRACTOR IS RESPONSIBLE TO VERIFY THESE QUANTITIES FOR THEIR PURPOSES OF BIDDING. THE QUANTITIES SHOWN ARE AN ESTIMATE FOR BIDDING PURPOSES ONLY.

BENCHMARK

USC&GS BRASS CAP STAMPED S-169,
NEAR THE EAST R/W OF RANCHO ROAD, 500 FEET NORTH
OF ANN ROAD NEAR MILE MARKER 87.20

NAVD88 ELEVATION = 2358.87 FEET
718.986 METERS


BASIS OF BEARINGS

N 89°10'14" E BEING THE NORTH LINE OF
THE NORTHWEST QUARTER (NW 1/4) OF
SECTION 34, TOWNSHIP 19 SOUTH, RANGE 60 EAST,
M.D.M., AS SHOWN IN FILE 55 OF SURVEYS, AT PAGE 25,
OFFICIAL RECORDS, CLARK COUNTY, NEVADA

**INSTALLATION OF DOUBLE CHECK DETECTOR
ASSEMBLY 8"**


THE DOUBLE CHECK DETECTOR ASSEMBLY SHALL BE
INSTALLED IN ACCORDANCE WITH THE UDAC'S PLATE 208.
ANY BLOCK WALL OR OTHER FENCE MATERIAL SHALL BE
DESIGNED AND CONSTRUCTED AROUND THE OUTSIDE OF
THE EASEMENT(S), SO AS TO ALLOW THE DISTRICT DIRECT
ACCESS FROM THE ADJACENT RIGHT-OF-WAY.

THIS PROPERTY MAY HAVE STATIC WATER PRESSURE IN EXCESS
OF 80 PSI. THE UNIFORM PLUMBING CODE REQUIRES THAT
INDIVIDUAL, ON-SITE (PRIVATE), PRESSURE REDUCING VALVES BE
INSTALLED WHENEVER THE PRESSURE EXCEEDS 80 PSI. PRVS
ARE THE DEVELOPER'S RESPONSIBILITY AND WILL NOT BE
INSPECTED OR INCLUDED IN THE ACCEPTANCE OF LVWD FACILITIES.

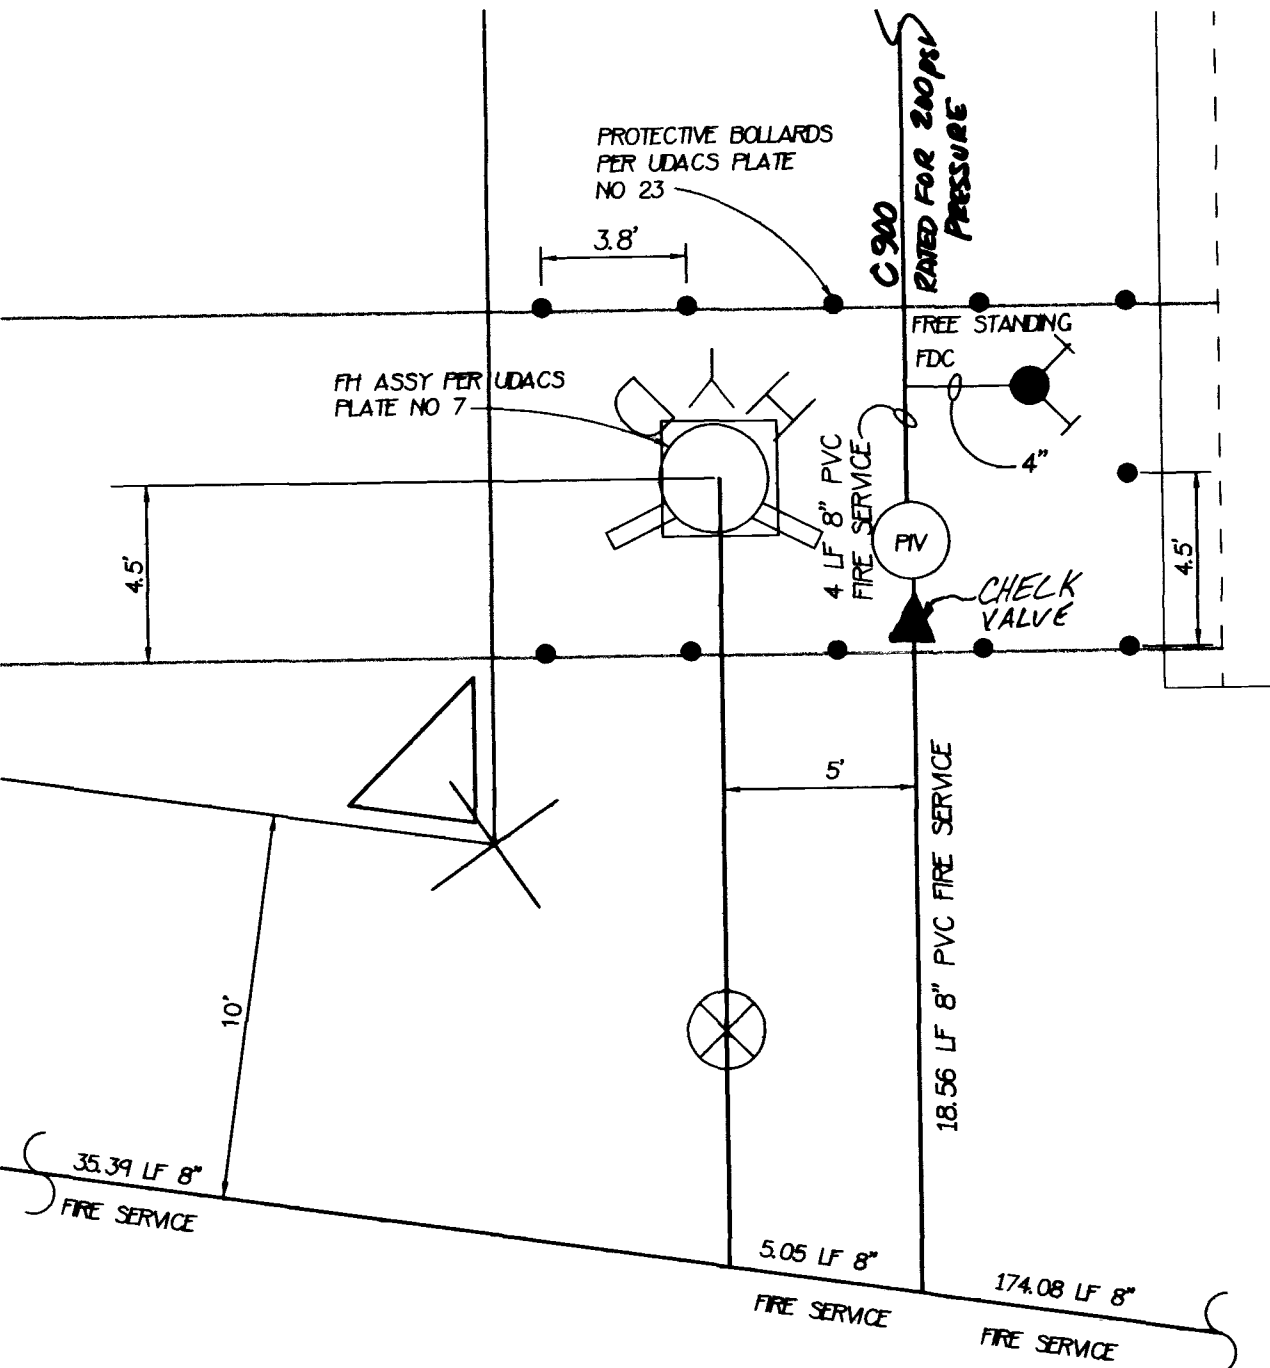

FH-PV DETAIL

NO SCALE

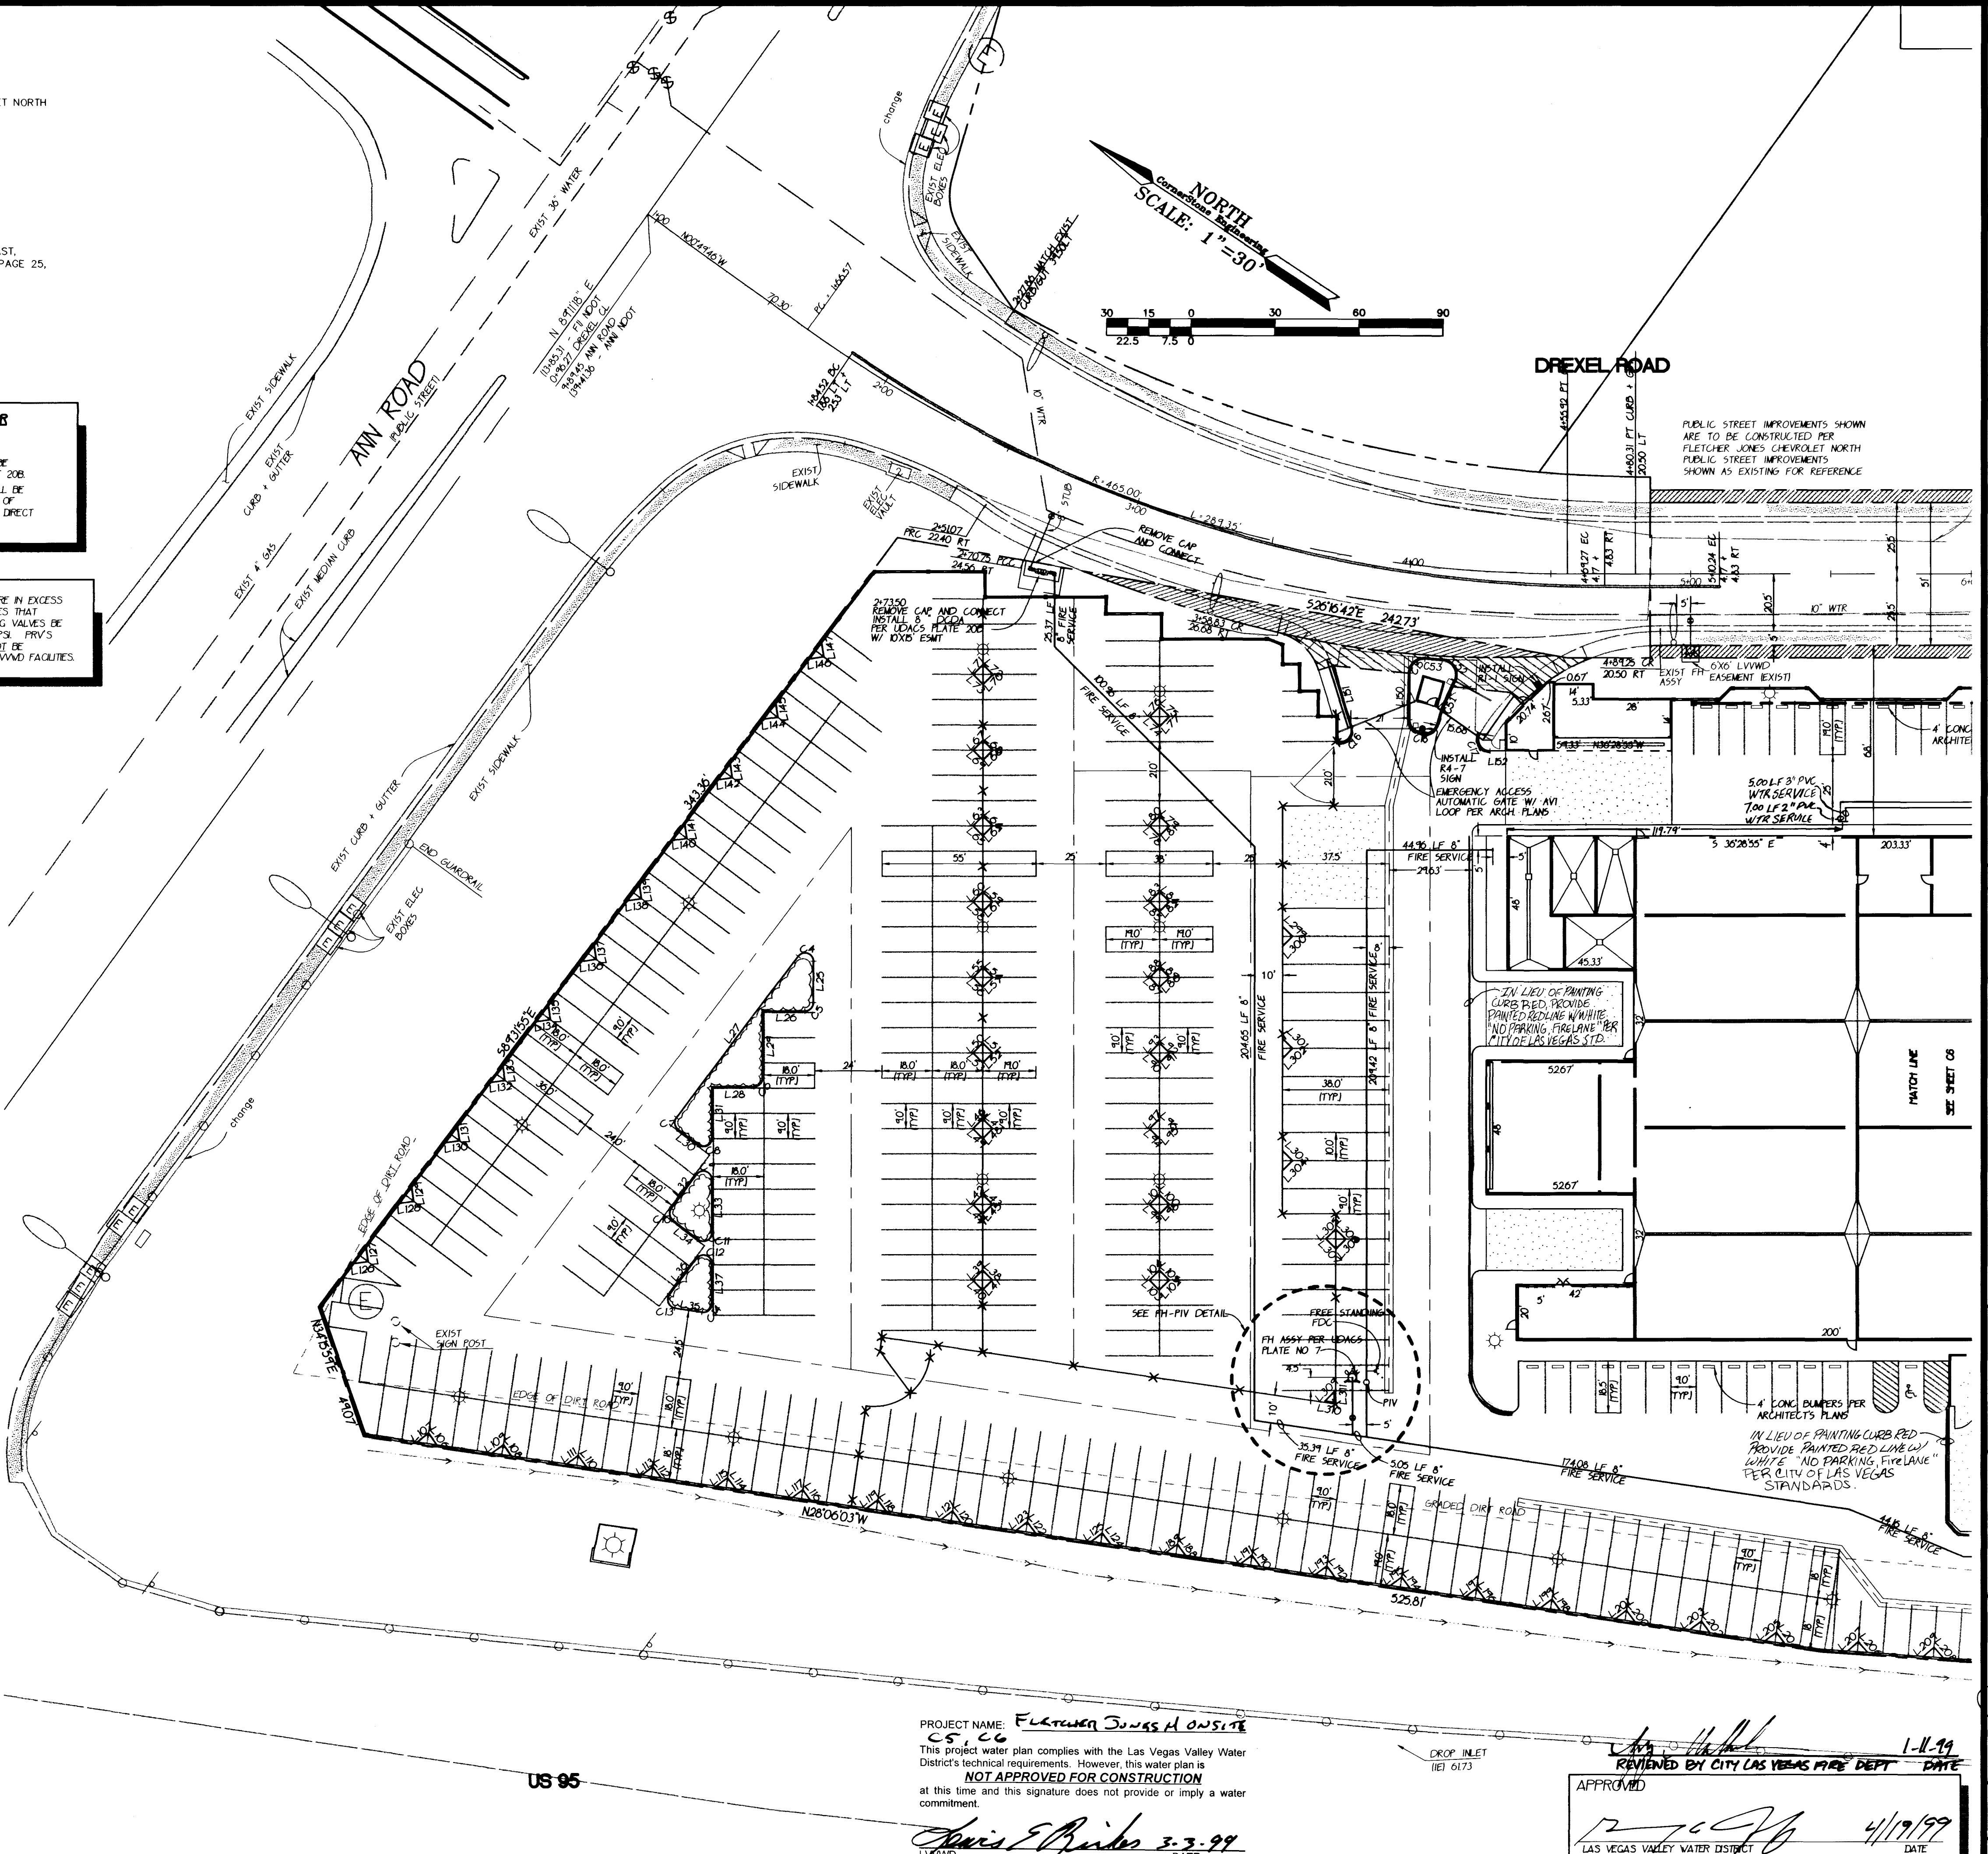

PROJECT NAME: **Fletcher Jones Home Site**
C5, C6
This project water plan complies with the Las Vegas Valley Water District's technical requirements. However, this water plan is
NOT APPROVED FOR CONSTRUCTION
at this time and this signature does not provide or imply a water commitment.

James E. Bridges 3-3-99
DATE

REVIEWED BY CITY LAS VEGAS FIRE DEPT. DATE: 1-11-99
APPROVED: 4/19/99
LAS VEGAS VALLEY WATER DISTRICT

FLETCHER JONES MANAGEMENT GROUP
175 E RENO AVE, SUITE C-6
LAS VEGAS, NV 89109
702-739-8800 FAX 702-739-0486

CornerStone Engineering Inc.
3600 S EASTERN AVE SUITE 102
LAS VEGAS, NV 89109
702-731-4711 FAX 702-731-4788

UTILITY PLAN + HORIZONTAL CONTROL

FLETCHER JONES NORTH CHEVROLET
ANN ROAD + US 95
ON-SITE PLANS

FILENAME: 136-SUDWG
XREF FILES: 136-WSTDWG
CHECKED BY: DRAWN BY: SCALE: 1"=30'
PROJECT NO: 136-00

DATE: JAN. 6, 1999

SHEET: 5 OF 8 SHEETS
DRAWING NO. 107-V2892

14645 15163

NOTES

THE UNIVERSITY OF CHICAGO
CHICAGO, ILLINOIS
60637
U.S.A.

2000
 2001
 2002
 2003
 2004
 2005
 2006
 2007
 2008
 2009
 2010
 2011
 2012
 2013
 2014
 2015
 2016
 2017
 2018
 2019
 2020
 2021
 2022
 2023
 2024
 2025
 2026
 2027
 2028
 2029
 2030

RESEARCH

STANDARD FORM NO. 5010-108
 PRINTED ON RECYCLED PAPER, 100% POST CONSUMER WASTE
 100% RECYCLED PAPER, 100% POST CONSUMER WASTE
 100% RECYCLED PAPER, 100% POST CONSUMER WASTE
 100% RECYCLED PAPER, 100% POST CONSUMER WASTE

STATE OF NEW YORK

CONTACT: info@hugoboss.com
WEBSITE: www.hugoboss.com

APPENDIX B. TEST 2 SAMPLE ANSWERS


602-443-7341

INTERNET


DECLARATION

BY APPOINTMENT ONLY
NO CASH, NO CREDIT

15 JULY 2004

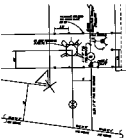

HH-PV DETAIL

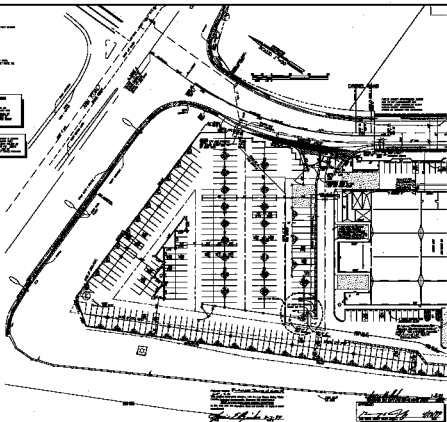[illegible]