

# IMPROVEMENT PLANS


FOR

# FLYNN GALLAGHER CORP. CENTER

CITY OF LAS VEGAS  
STATE OF NEVADA

NORTHWEST PROPERTIES, L.L.C.


6900 WESTCLIFF DRIVE, #505  
LAS VEGAS, NEVADA 89128  
(702) 256-3781

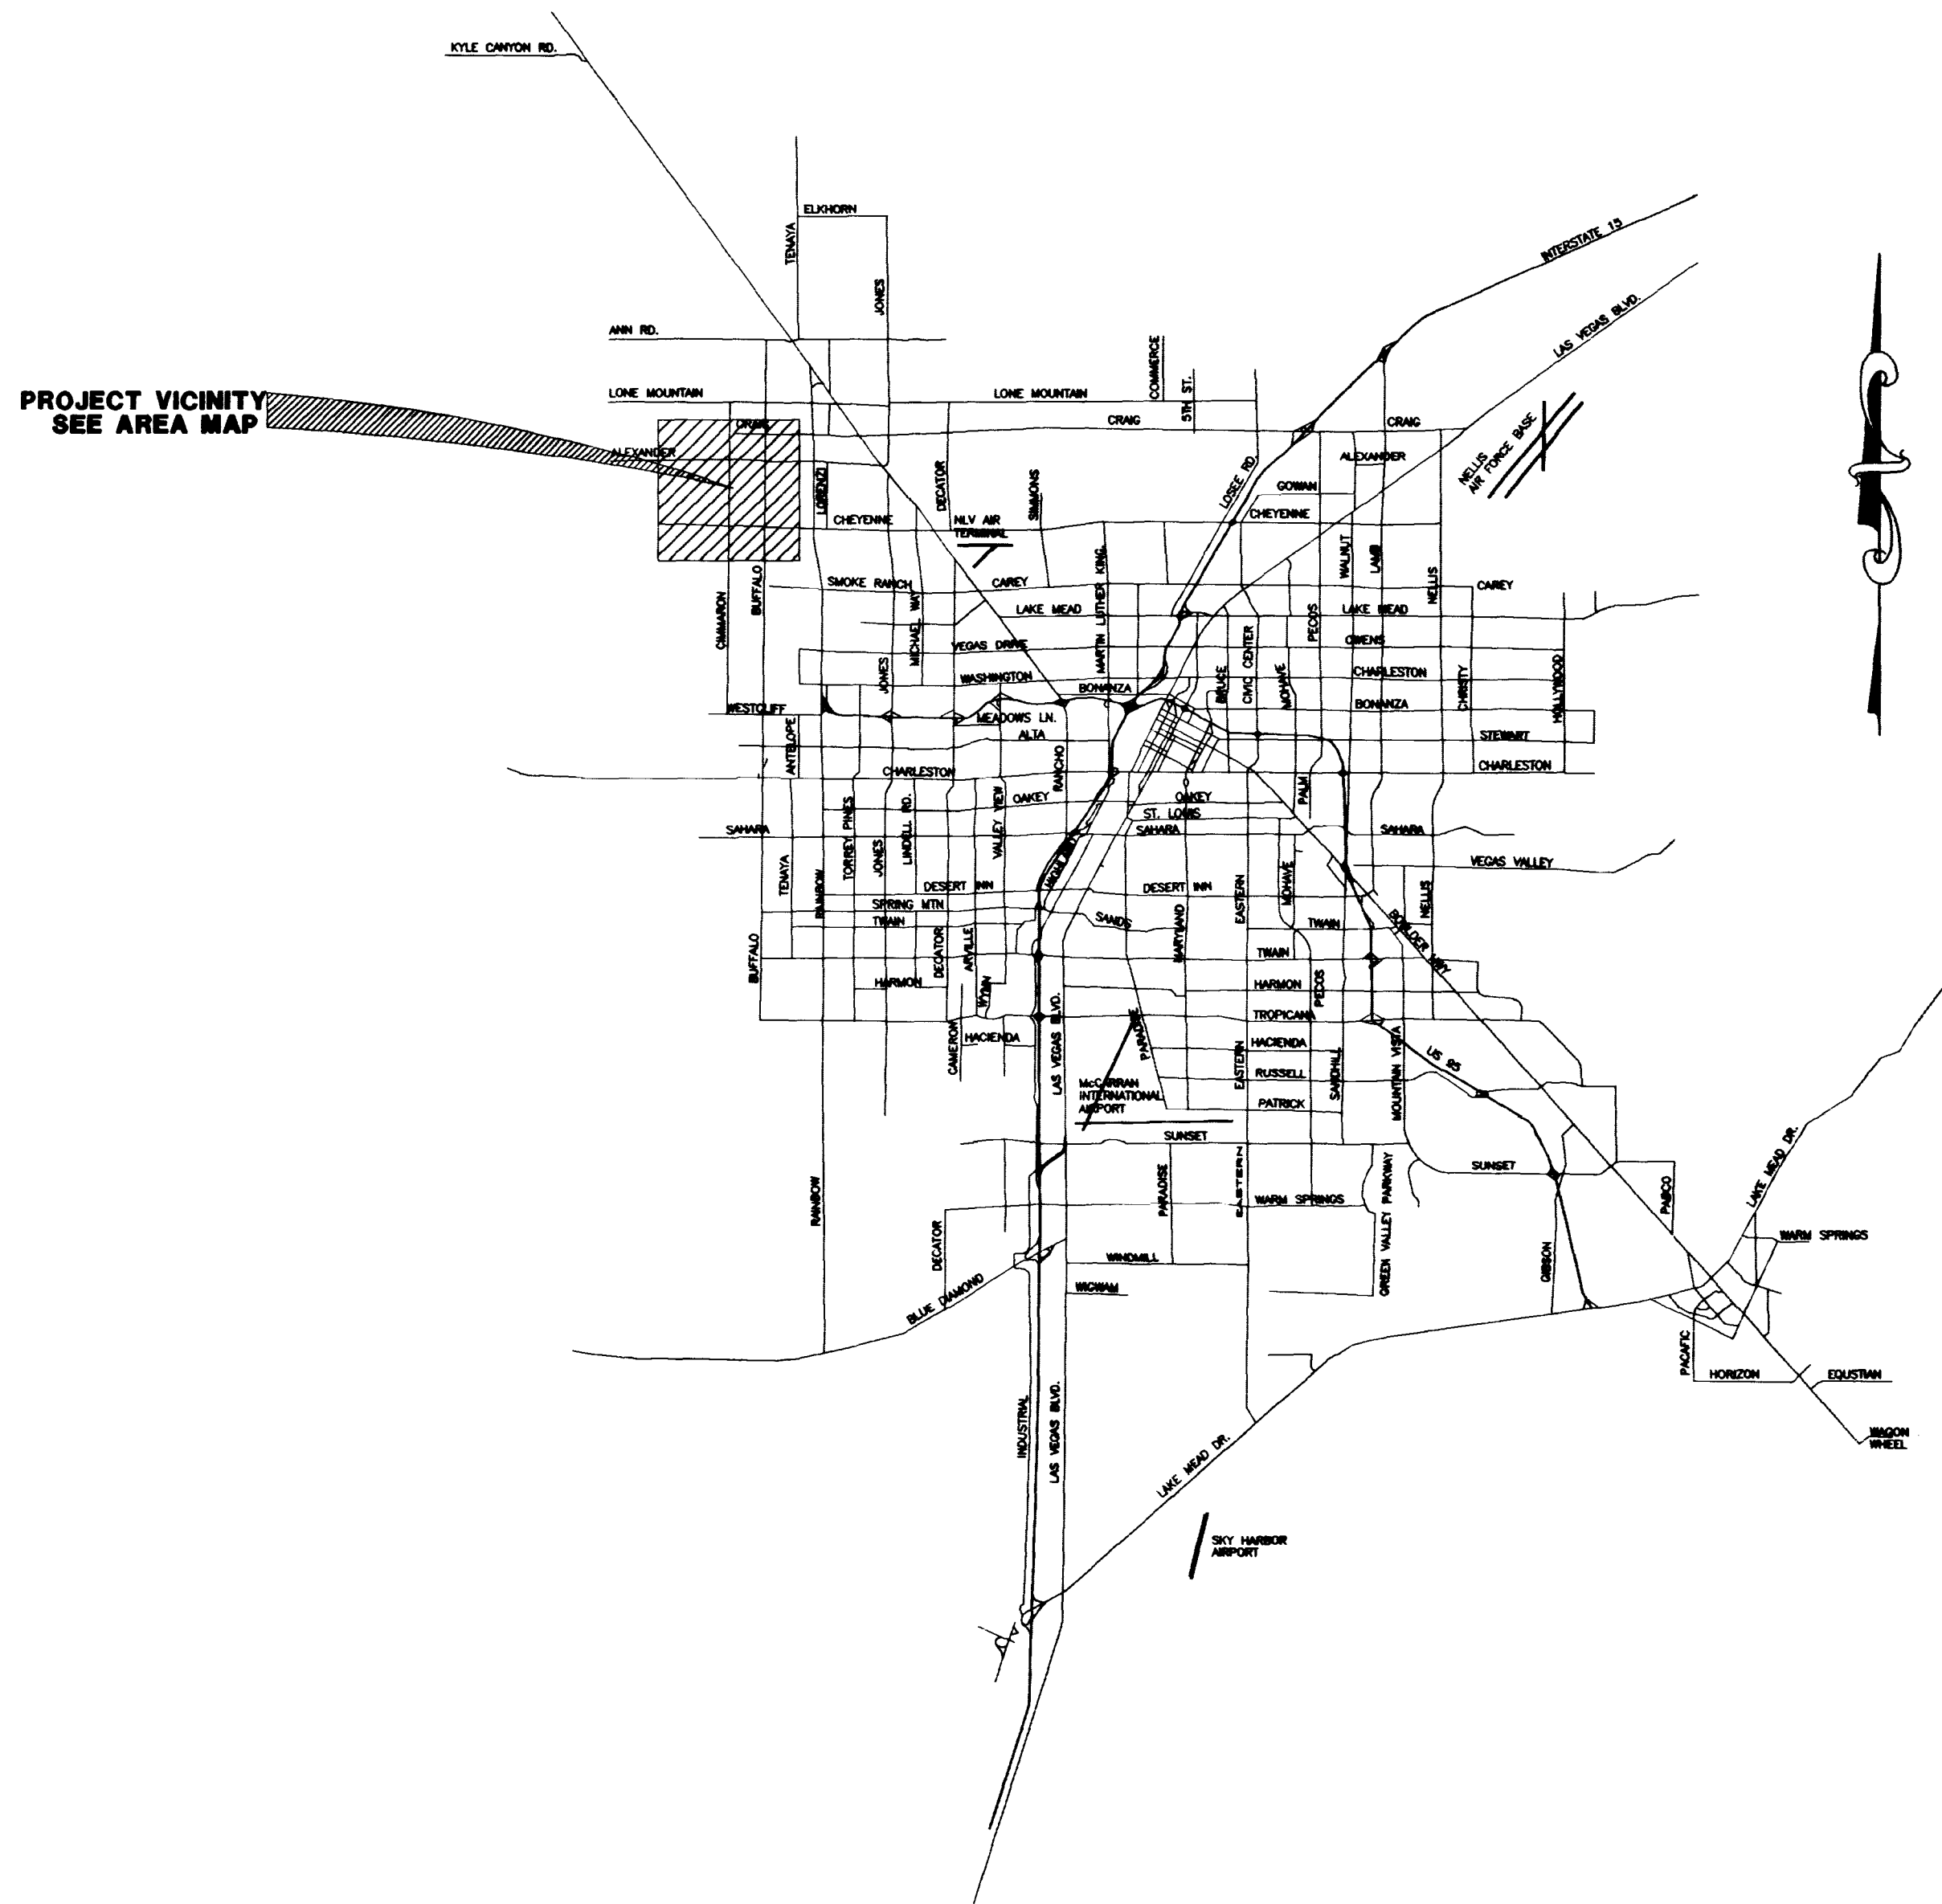

SHEET INDEX

| SHEET # | DESCRIPTION                   |
|---------|-------------------------------|
| 1       | C1 COVER SHEET & VICINITY MAP |
| 2       | C2 GENERAL NOTES & QUANTITIES |
| 3       | C3 UTILITY PLAN               |
| 4       | C4 UTILITY PLAN               |
| 5       | C5 UTILITY PLAN               |
| 6       | C6 UTILITY PLAN               |
| 7       | G1 GRADING PLAN               |
| 8       | G2 GRADING PLAN               |
| 9       | G3 GRADING PLAN               |
| 10      | G4 GRADING PLAN               |
| 11      | S1 SECTIONS PLAN              |
| 12      | H1 HORIZONTAL CONTROL PLAN    |
| 13      | H2 HORIZONTAL CONTROL PLAN    |
| 14      | H3 HORIZONTAL CONTROL PLAN    |
| 15      | H4 HORIZONTAL CONTROL PLAN    |

SHEET LAYOUT INDEX

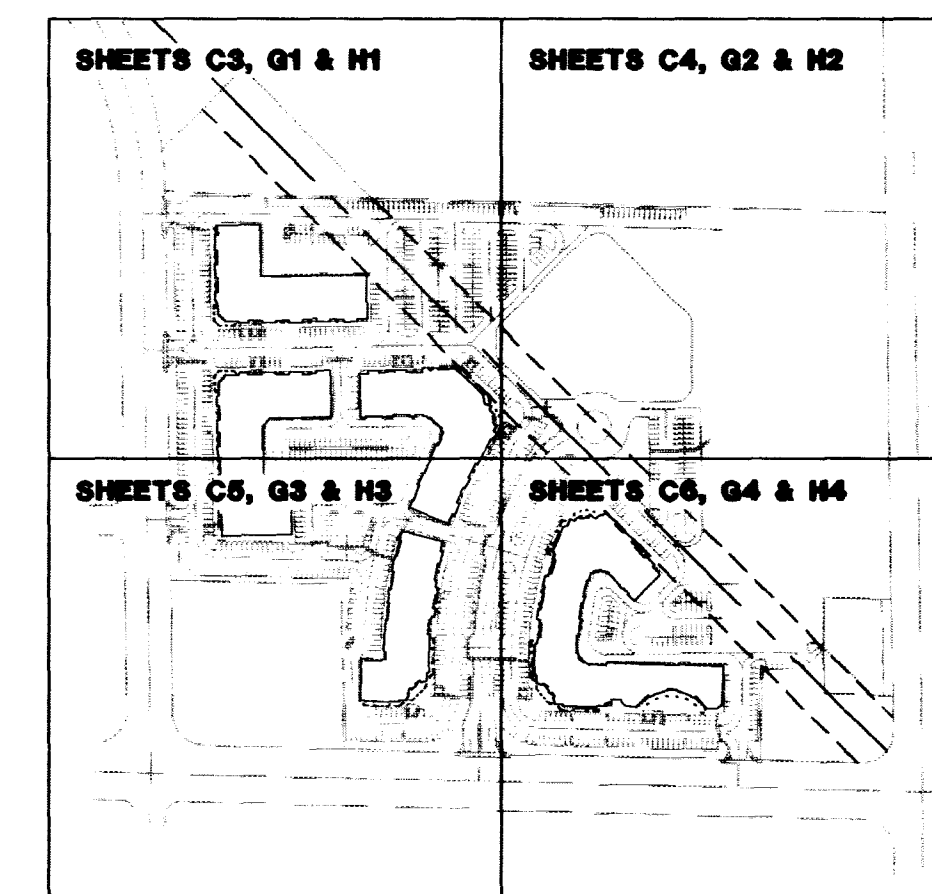

## APPROVALS

*Charles Kajkowski* 1-14-99  
CHARLES KAJKOWSKI, JR., PE#4784 DATE  
CITY PLANNING ENGINEER


APPROVAL OF THESE PLANS IS LIMITED TO THOSE IMPROVEMENTS  
CONSTRUCTED IN THE DEDICATED RIGHT-OF-WAY AND/OR DEDICATED  
EASEMENTS. THIS APPROVAL DOES NOT AUTHORIZE THE CONSTRUCTION  
OF ANY IMPROVEMENTS THAT DEVIATE FROM ADOPTED STANDARDS  
AND/OR SPECIFICATIONS, EXCEPT THOSE SPECIFICALLY LISTED UNDER  
DEVIATIONS FROM STANDARD. THE ENGINEER SHALL RESOLVE ANY  
DEVIATION OTHER THAN THOSE LISTED IN DEVIATIONS FROM STANDARDS  
IN FAVOR OF THE UNIFORM STANDARD DRAWINGS AND SPECIFICATIONS  
CLARK COUNTY AREA NEVADA.

 10, 27, 98  
CITY OF MARSHALL DATE

LAS VEGAS VALLEY WATER DISTRICT

*Curt Lambert* 10-28-98  
NEVADA POWER COMPANY DATE

 10/27/99  
SOUTHWEST GAS CORP. DATE

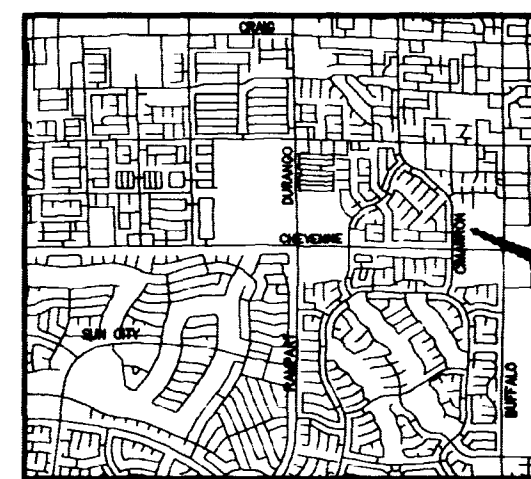

AREA MAP  
SCALE: NONE



C1  
1 OF 15 SHEETS  
DRAWING NO.  
107-V2965

**NORTHWEST PROPERTIES, L.L.C.**

**AGRA Infrastructure, Inc.**  
ENGINEERING GLOBAL SOLUTIONS  
3016 W. CHARLESTON BOULEVARD, SUITE 180  
CHARLESTON, SC 29405  
803.733.7811

---

**FLYNN GALLAGHER CORP. CENTER**  
NWC OF CHEYENNE & BUFFALO  
APN 138-09-801-018 & 019

DRAWN BY: \_\_\_\_\_  
PAK \_\_\_\_\_  
AUG'98 \_\_\_\_\_

PAK \_\_\_\_\_ AUG'98

CHECKED BY: \_\_\_\_\_



10  
MICHAEL J. REHAN  
CIVIL  
No. 1068A


C1  
1 OF 15 SHEETS  
DRAWING NO.  
107-V2965

IMPROVEMENT PLANS  
FOR  
FLYNN GALLAGHER CORP. CENTER

CITY OF LAS VEGAS  
STATE OF NEVADA

NORTHWEST PROPERTIES, L.L.C.

8900 WESTCLIFF DRIVE, #306  
LAS VEGAS, NEVADA 89128  
(702) 258-3781

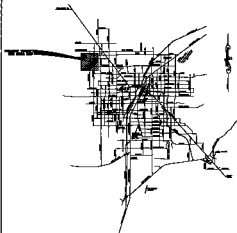

| COUNTRY - REGION |                            |
|------------------|----------------------------|
| WORLD            | DESCRIPTION                |
| 1                | 12 BRASS BELL & BRASS BELL |
| 2                | 13 BRASS BELL & BRASS BELL |
| 3                | 14 BRASS BELL              |
| 4                | 15 BRASS BELL              |
| 5                | 16 BRASS BELL              |
| 6                | 17 BRASS BELL              |
| 7                | 18 BRASS BELL              |
| 8                | 19 BRASS BELL              |
| 9                | 20 BRASS BELL              |
| 10               | 21 BRASS BELL              |
| 11               | 22 BRASS BELL              |
| 12               | 23 BRASS BELL              |
| 88               | 99 BRASS BELL              |
| 89               | 100 BRASS BELL             |
| 90               | 101 BRASS BELL             |
| 91               | 102 BRASS BELL             |
| 92               | 103 BRASS BELL             |
| 93               | 104 BRASS BELL             |
| 94               | 105 BRASS BELL             |
| 95               | 106 BRASS BELL             |
| 96               | 107 BRASS BELL             |
| 97               | 108 BRASS BELL             |
| 98               | 109 BRASS BELL             |
| 99               | 110 BRASS BELL             |
| 100              | 111 BRASS BELL             |



AREA MAN

ADDITIONALS  
*W. L. Hall* 1-17-89

© 1997 by The McGraw-Hill Companies, Inc. All rights reserved. Printed in the United States of America. This publication is protected by copyright. Any unauthorized distribution or reproduction of this work is prohibited. For more information, contact The McGraw-Hill Companies, Inc., 1221 Avenue of the Americas, New York, NY 10020-1095.

*[Signature]*

THE JOURNAL OF THE ATMOSPHERIC SCIENCES 55

\_\_\_\_\_ Date: \_\_\_\_\_



1. 10-15 mm.

**AGRA International, Inc.**  
200 N. 2nd St., Suite 200  
St. Paul, MN 55101  
Tel: 612/222-1111  
Fax: 612/222-1112

|            |                                                      |
|------------|------------------------------------------------------|
| CONAIR INC | PLUMB BALLACHER CORP, COPTER<br>AND P COPTER & PARTS |
|------------|------------------------------------------------------|

|      |      |      |      |
|------|------|------|------|
| 1000 | 1000 | 1000 | 1000 |
| 1000 | 1000 | 1000 | 1000 |
| 1000 | 1000 | 1000 | 1000 |
| 1000 | 1000 | 1000 | 1000 |