

BENCHMARK and VERT. DATUM

CITY OF LAS VEGAS
BENCH MARK #11V106S4
RIVET & PLATE IN TOP OF CURB, NORTHEAST RETURN
OF SAHARA AVENUE & GRAND CANYON DRIVE.
ELEVATION= 869.7072 METERS (NAVD 88)

CONVERSION TO U.S. SURVEY FEET
3.280833333 x 869.7072 = 2853.364 FEET

BASIS OF BEARING

CENTERLINE OF WEST SAHARA AVENUE PER THE
RECORDED SUBDIVISION PLAT OF WELLINGTON
COMMERCIAL CENTER (A COMMERCIAL
SUBDIVISION), RECORDED JAN. 14, 1998, BOOK
82, PAGE 86 OF PLATS BEARING BEING
S89°47'47"W.

LAS VEGAS FIRE DEPARTMENT

FIRE FLOW IS 2,875 GPM AT 20 PSI RESIDUAL PRESSURE

BASED ON: 45,771 SF
SQUARE FOOTAGE: 45,771 SF
AREA BETWEEN 4 HOUR AREA
SEPARATION WALLS: 0 SF
BUILDING HEIGHT: 44 FT
NUMBER OF STORIES: 3
TYPE OF CONSTRUCTION: V-N
OCCUPANCY: R-1
FULL AUTOMATIC FIRE SYSTEM: YES


K. M. M. 4/29/99
CITY FIRE MARSHAL
AZARANG MIRKHAH, P.E. DATE

CONSTRUCTION NOTE

ALL EXISTING UTILITY STRUCTURES WITHIN CONSTRUCTION
AREA SHALL BE ADJUSTED TO MATCH FINISH GRADE
(I.E. WV, BOX, MH, ANNOUE BOX, FH, TEL. BOX, ETC.)



SEWER CONTRIBUTION

AVERAGE FLOW = 0.018 MGD
PEAK FLOW = 0.063 MGD

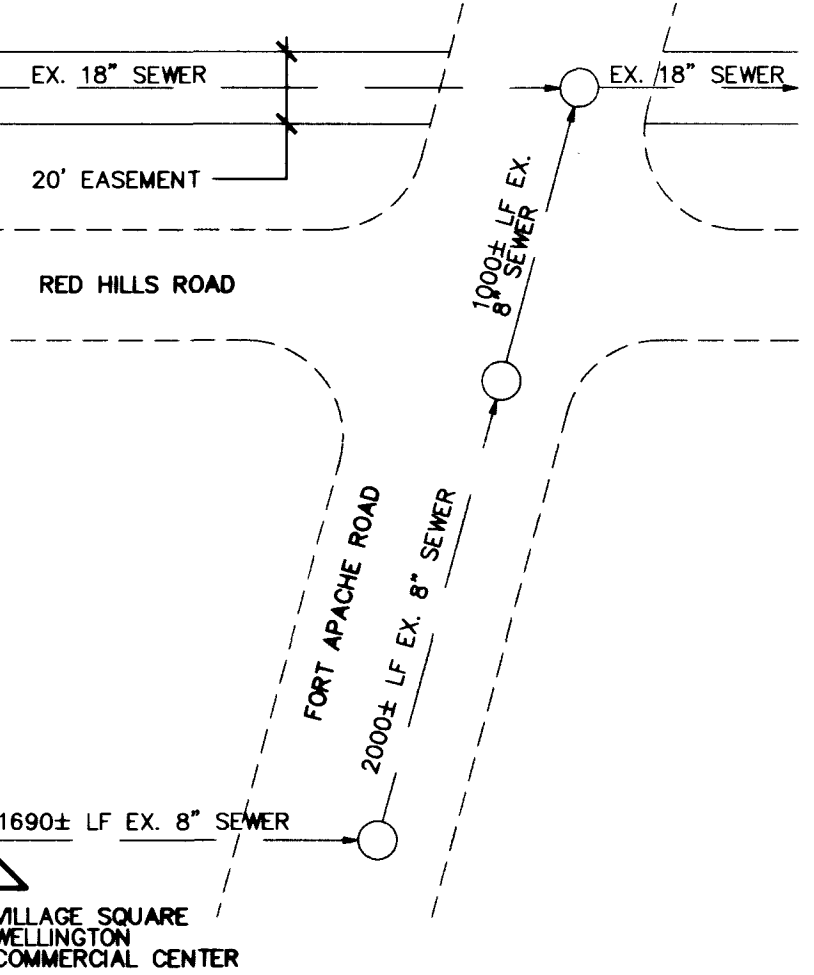

LOCATION MAP

NOT TO SCALE
8" SEWER DISCHARGES INTO 18" SEWER NORTH
OF RED HILLS RD. AND FORT APACHE RD.

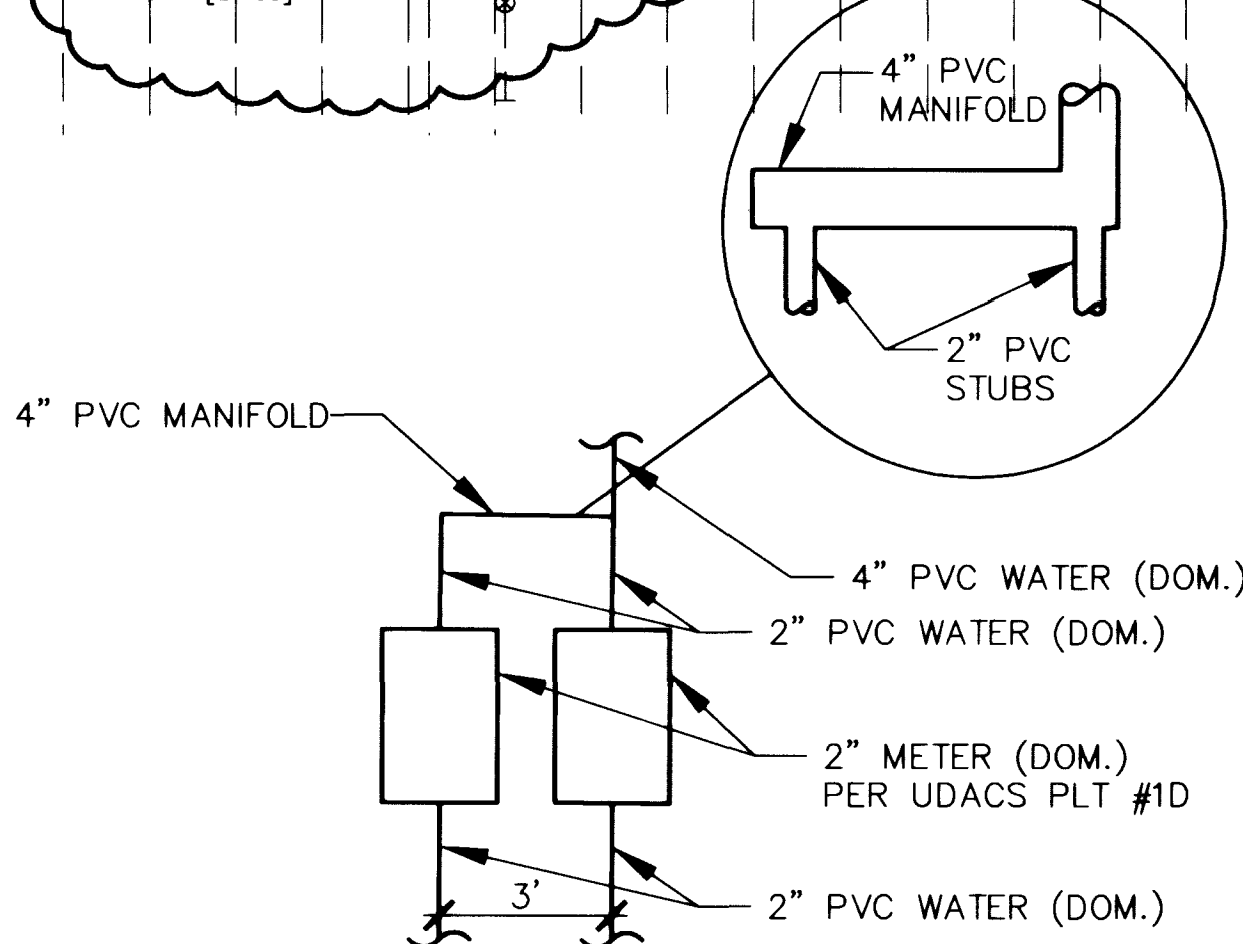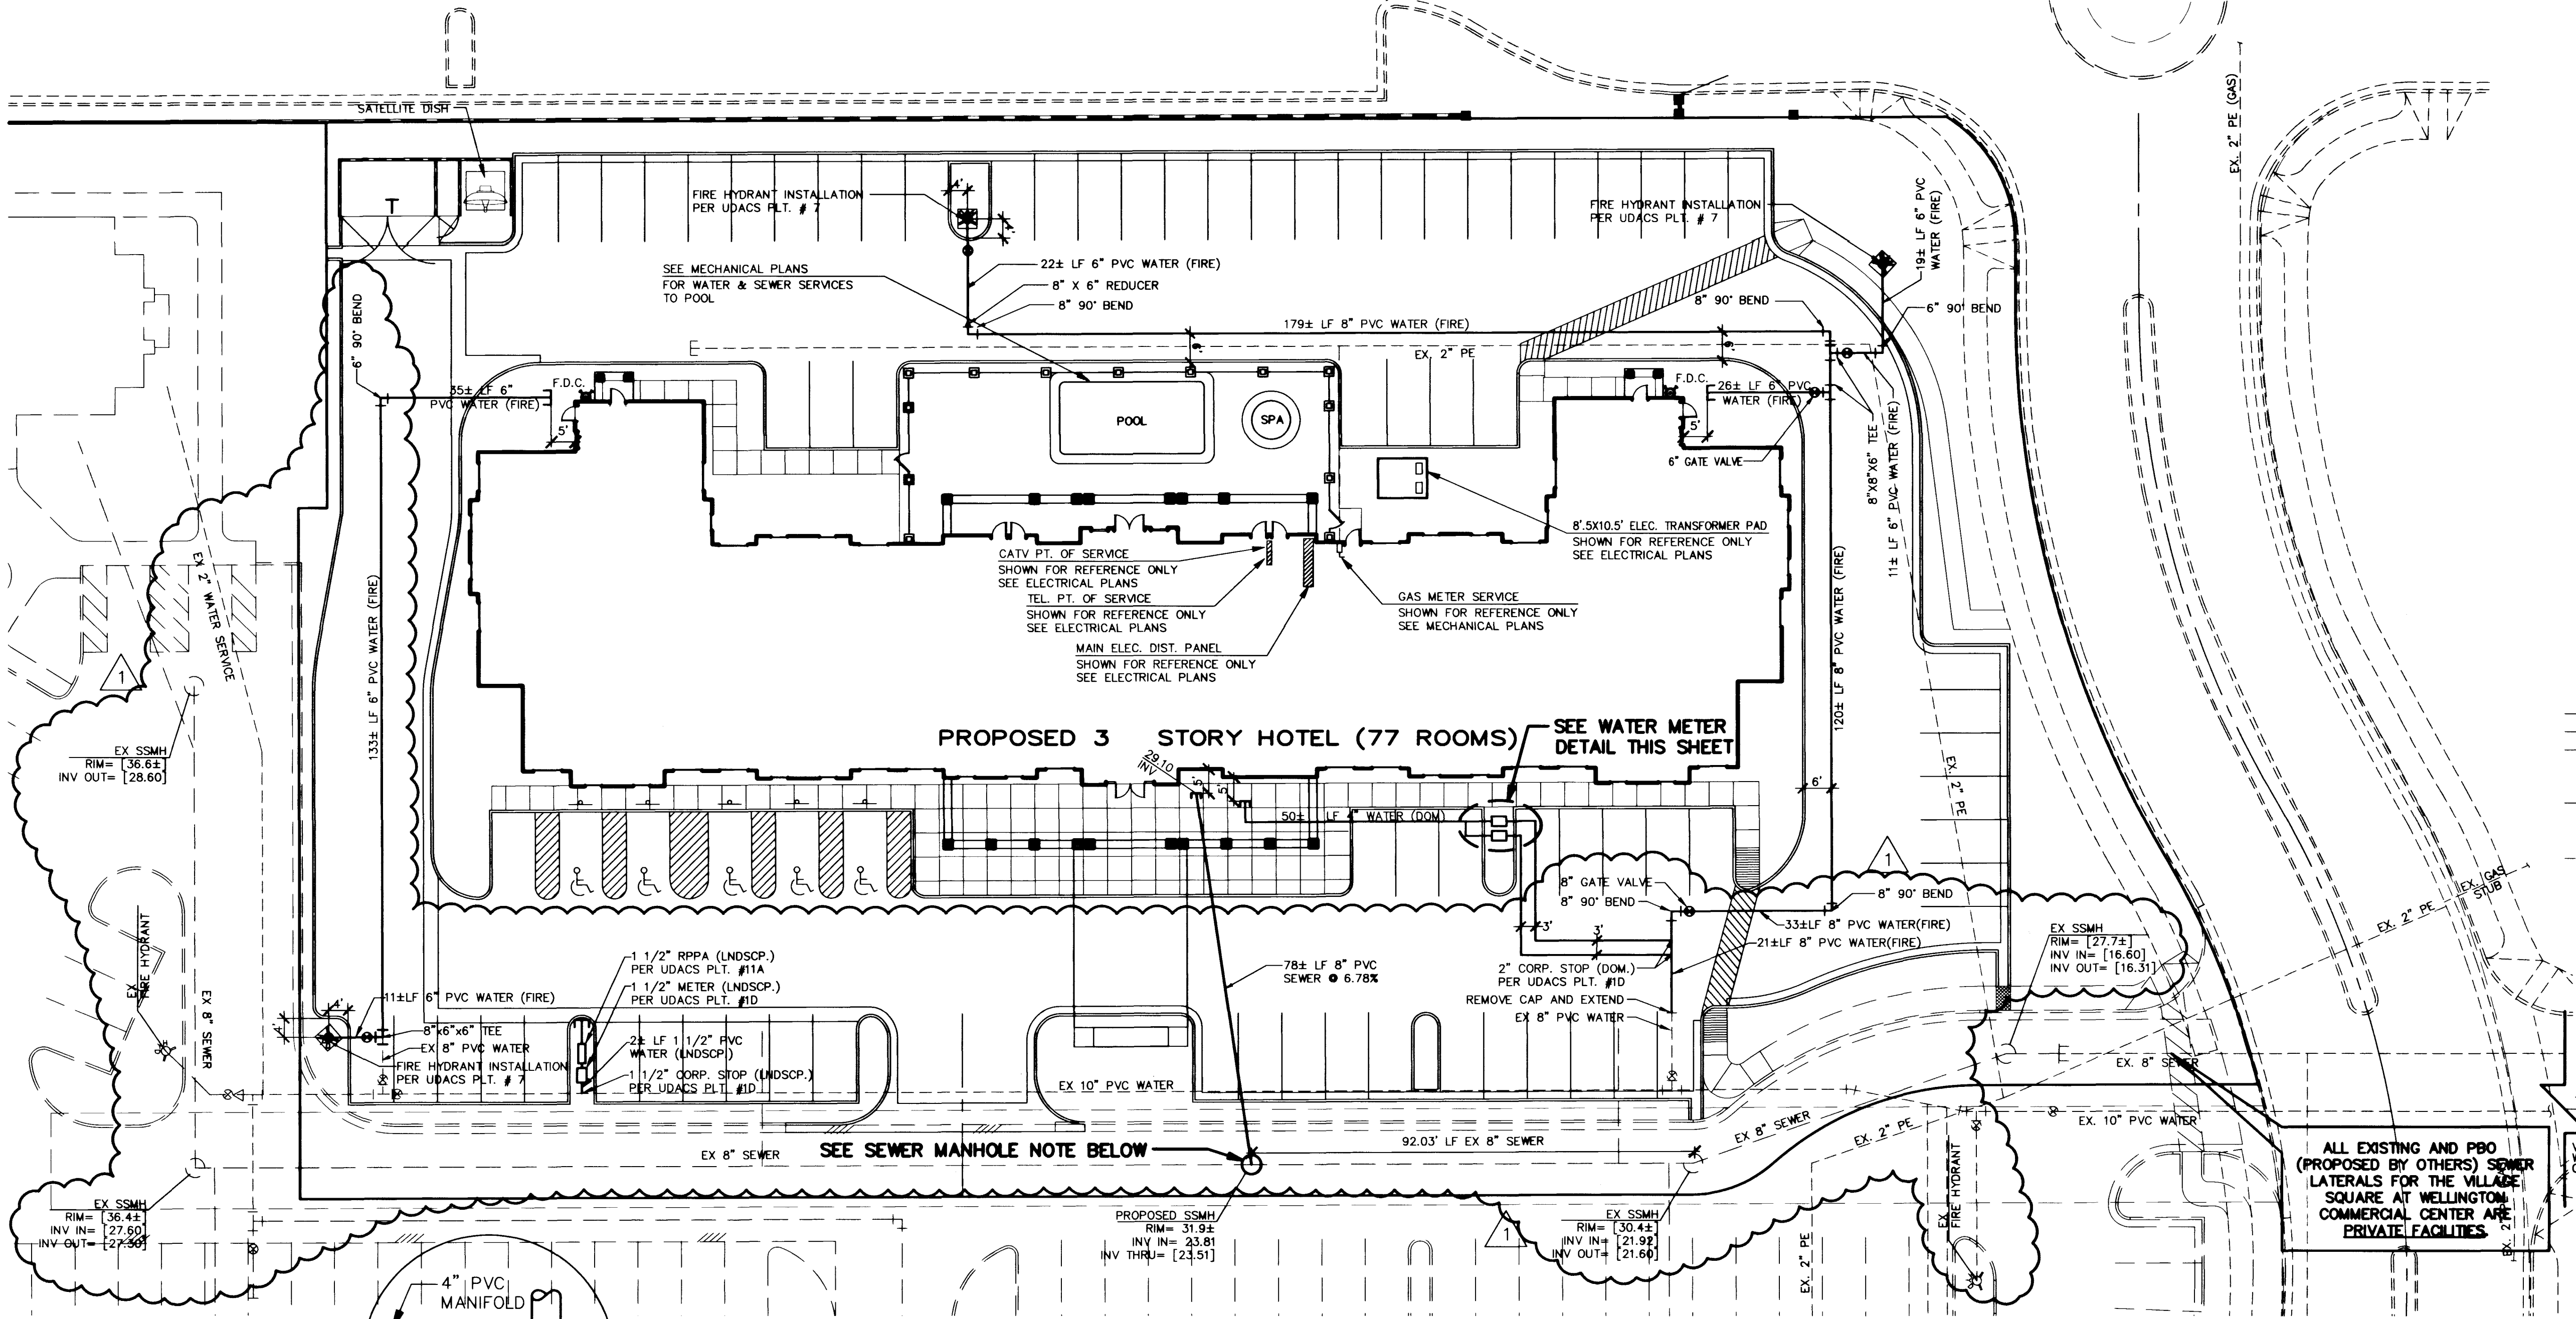

- * 66± TOTAL LF PRIVATE 2" PVC WATER
- * 53± TOTAL LF PRIVATE 4" PVC WATER


WATER METER DETAIL
NOT TO SCALE

NOTES:

ALL DIMENSIONS TO UTILITIES ARE TO CENTERLINE
OF PIPE UNLESS INDICATED OTHERWISE.
ALL UTILITY DIMENSIONS ARE FROM THE BACK OF CURB
TO CENTERLINE OF PIPE UNLESS INDICATED OTHERWISE.
CONTRACTOR SHALL VERIFY HORIZONTAL AND
VERTICAL ALIGNMENT OF EXISTING UTILITIES AND
NOTIFY THE DESIGN ENGINEER IMMEDIATELY
ON ANY DISCREPANCIES PRIOR TO CONSTRUCTION.
ONSITE UTILITIES SHOWN AS PBO (PROPOSED BY OTHERS)
ARE PROPOSED BY VTN NEVADA, ON WELLINGTON VILLAGE
SQUARE AT PECCOLE RANCH IMPROVEMENT PLANS, AND WILL BE
IN PLACE PRIOR TO THIS PROJECT'S UTILITY IMPROVEMENTS.

SEWER MANHOLE NOTE

ALL DIMENSIONS TO UTILITIES ARE TO CENTERLINE
OF PIPE UNLESS INDICATED OTHERWISE.
ALL UTILITY DIMENSIONS ARE FROM THE BACK OF CURB
TO CENTERLINE OF PIPE UNLESS INDICATED OTHERWISE.
CONTRACTOR SHALL VERIFY HORIZONTAL AND
VERTICAL ALIGNMENT OF EXISTING UTILITIES AND
NOTIFY THE DESIGN ENGINEER IMMEDIATELY
ON ANY DISCREPANCIES PRIOR TO CONSTRUCTION.
ONSITE UTILITIES SHOWN AS PBO (PROPOSED BY OTHERS)
ARE PROPOSED BY VTN NEVADA, ON WELLINGTON VILLAGE
SQUARE AT PECCOLE RANCH IMPROVEMENT PLANS, AND WILL BE
IN PLACE PRIOR TO THIS PROJECT'S UTILITY IMPROVEMENTS.

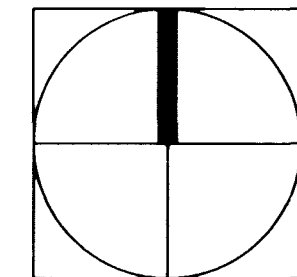

GRAPHIC SCALE

20 0 10 20 30 40 50 60 70 80
(IN FEET)
1 inch = 20 ft.

SEE SHEET C1.3 FOR
GENERAL NOTES & LEGEND
SEE SHEET C4.3 FOR
DETAILS
SEE SHEET C1.4 FOR
ESTIMATE OF QUANTITIES

Call before you OVERHEAD
1-702-593-6111
Call before you Dig.
1-800-227-2600

HOSPITALITY ASSOCIATES		EKN ENGINEERING	
MASTER UTILITY PLAN		TITLE: HAWTHORN SUITES LTD -SAHARA AVE. and FORT APACHE ROAD- CITY OF LAS VEGAS	
DRAWN BY: J.W. RIPLEY	DESIGNED BY: J.W. RIPLEY	CHECKED BY: D.E. PETERS	PROJECT NO: 99-503
DATE: 2/1/99	DATE: 2/1/99	DATE: 2/1/99	SCALE: 1" = 20'
SHEET 8 OF 10 SHEETS		SHEET C4.1	
DRAWING NO. 107-V3073		THIS IS A RE-ROT	

1998, 1999, 2000, 2679, 26