

IMPROVEMENT PLANS FOR HONDA NORTHWEST

CITY OF LAS VEGAS
STATE OF NEVADA


APN 138-12-110-013

DOLE & MARGIE BOWGREN

PORTER CONSTRUCTION
1055 EAST TROPICANA, SUITE #430
LAS VEGAS, NEVADA 89119
(702) 367-6191

SHEET INDEX

SHEET #	DESCRIPTION
1	C1 COVER SHEET & VICINITY MAP
2	C2 GENERAL NOTES & QUANTITIES
3	C3 SEWER PLAN
4	C4 WATER PLAN
5	C5 HORIZONTAL CONTROL PLAN
6	G1 GRADING PLAN
7	G2 PLAN & PROFILE (ALLEY)

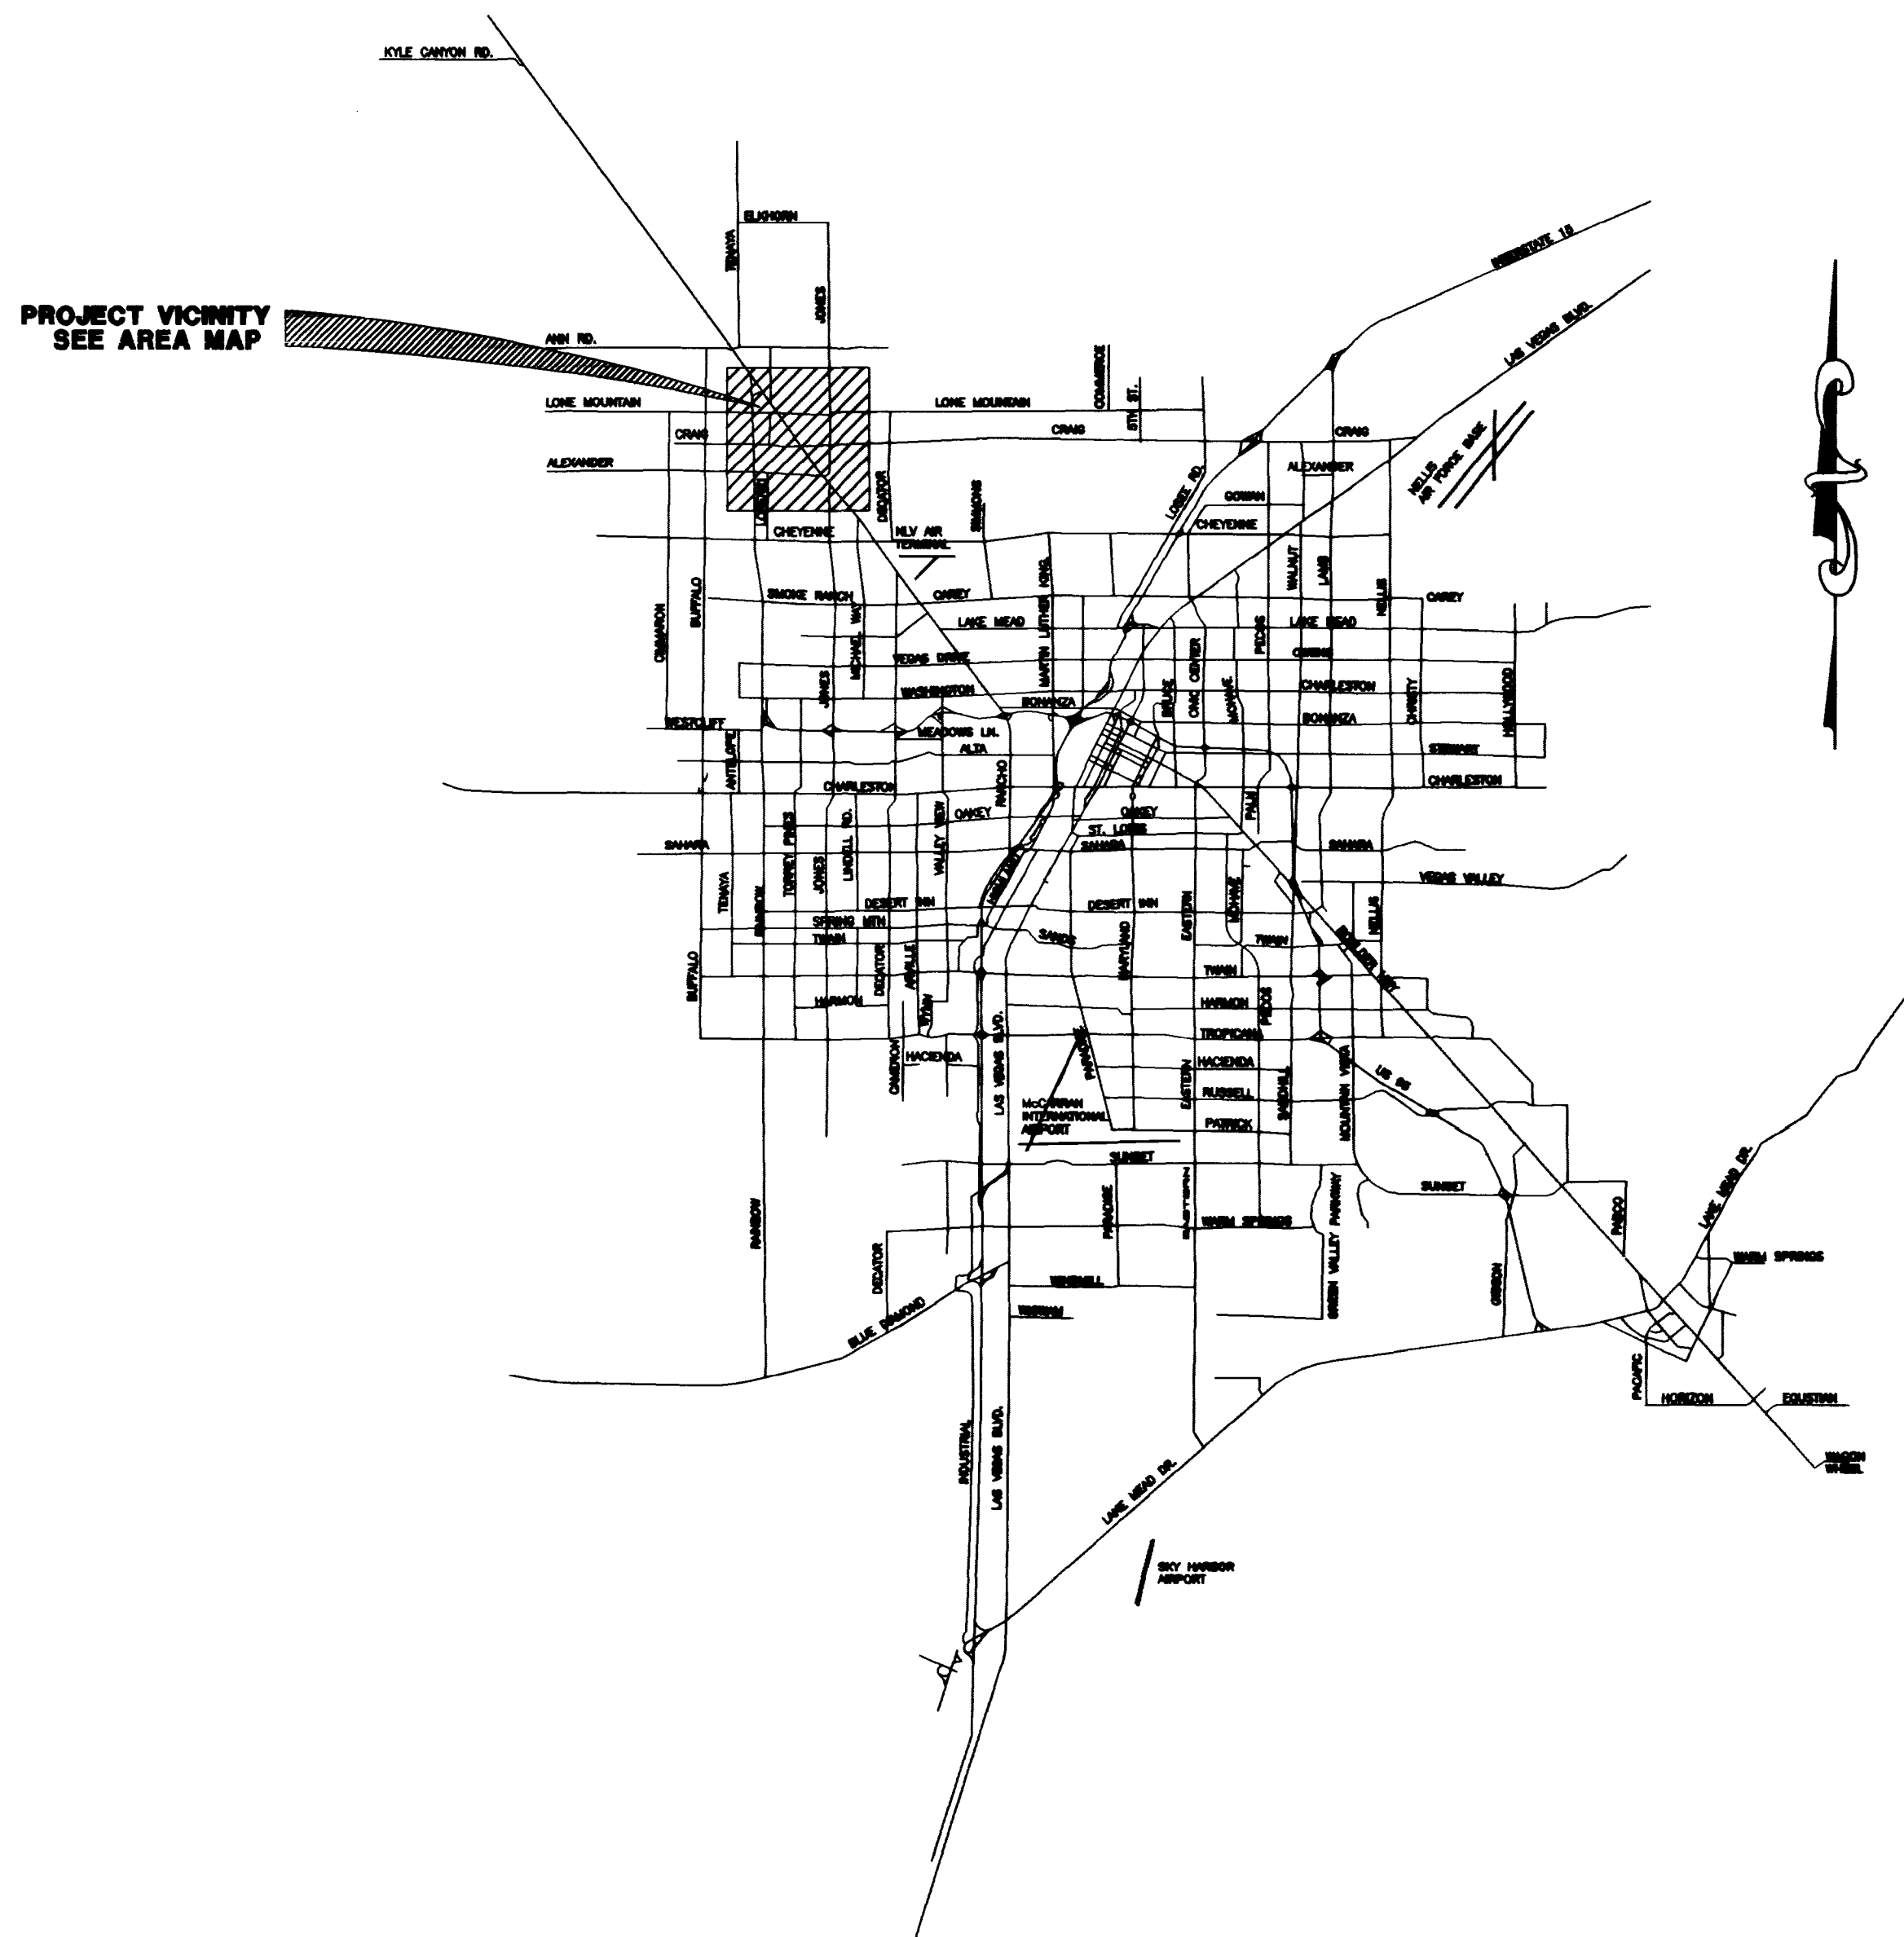

AREA MAP
SCALE: NONE

APPROVALS
Charles Kalkowski, Jr. 7-29-99
CHARLES KALKOWSKI, JR. PE#4784 DATE
CITY PLANNING ENGINEER

APPROVAL OF THESE PLANS IS LIMITED TO THOSE IMPROVEMENTS CONSTRUCTED IN THE DEDICATED RIGHT-OF-WAY AND/OR DEDICATED EASEMENTS. THIS APPROVAL DOES NOT AUTHORIZE THE CONSTRUCTION OF ANY IMPROVEMENTS THAT DEVIATE FROM ADOPTED STANDARDS AND/OR SPECIFICATIONS, EXCEPT THOSE SPECIFICALLY LISTED UNDER DEVIATIONS FROM STANDARD. THE ENGINEER SHALL RESOLVE ANY DEVIATION OTHER THAN THOSE LISTED IN DEVIATIONS FROM STANDARDS IN FAVOR OF THE UNIFORM STANDARD DRAWINGS AND SPECIFICATIONS CLARK COUNTY AREA NEVADA.

(SEE SHT. NO. 3) DATE
CITY FIRE MARSHALL

(SEE SHT. NO. 3) DATE
LAS VEGAS VALLEY WATER DISTRICT

Quanita Rodriguez 3-29-99
NEVADA POWER COMPANY DATE

Chad M. Conwell 3-25-99
SOUTHWEST GAS DATE

Call before you Dig It's a Law.
1-800-227-2600

CALL BEFORE YOU DO OVERHEAD
NEVADA POWER COMPANY

CALL 1-702-593-8111

DOLE & MARGIE BOWGREN 3800 NORTH RANCHO LAS VEGAS, NEVADA (702) 656-1955	AGRA Infrastructure Inc. ENGINEERING GLOBAL SOLUTIONS 3016 W. CHARLESTON BOULEVARD, SUITE 180 LAS VEGAS, NEVADA 89102 PHONE: (702) 878-3817 FAX: (702) 878-3716	DRAWN BY: SEPT'98 STAFF	DESIGNED BY: SEPT'98 STAFF	CHECKED BY: SEPT'98 KIKI	PROJECT NO: 02-1988-082 SCALE: N/A
		COVER SHEET HONDA NORTHWEST SWC RANCHO & DUNCAN APN 138-012-110-013 CITY OF LAS VEGAS			
1 OF 7 SHEETS DRAWING NO. 107-V3120		CIVIL 			

IMPROVEMENT PLANS FOR HONDA NORTHWEST

CITY OF LAS VEGAS
STATE OF NEVADA

APN 138-12-110-013

DOLE & MARGIE BOWGREN

PORTER CONSTRUCTION
1056 EAST TROPICANA, SUITE #430
LAS VEGAS, NEVADA 89119
(702) 387-8191

KEY

SYMBOL	DESCRIPTION
—	EXISTING PAVEMENT
—	EXISTING SIDEWALK
—	EXISTING DRIVEWAY
—	EXISTING DRIVE
—	EXISTING ALLEY
—	EXISTING UTILITY
—	EXISTING CURB
—	EXISTING GROUND
—	EXISTING FENCE
—	EXISTING WALL
—	EXISTING SIGN
—	EXISTING LIGHT
—	EXISTING TREE
—	EXISTING BUSH
—	EXISTING GRASS
—	EXISTING SAND
—	EXISTING GRAVEL
—	EXISTING ASPHALT
—	EXISTING CONCRETE
—	EXISTING BRICK
—	EXISTING STONE
—	EXISTING TILE
—	EXISTING GLASS
—	EXISTING METAL
—	EXISTING WOOD
—	EXISTING PLASTER
—	EXISTING GYPSUM
—	EXISTING LIME
—	EXISTING CEMENT
—	EXISTING SAND
—	EXISTING GRAVEL
—	EXISTING ASPHALT
—	EXISTING CONCRETE
—	EXISTING BRICK
—	EXISTING STONE
—	EXISTING TILE
—	EXISTING GLASS
—	EXISTING METAL
—	EXISTING WOOD
—	EXISTING PLASTER
—	EXISTING GYPSUM
—	EXISTING LIME
—	EXISTING CEMENT



INSET MAP

APPROVED
[Signature] 2-28-77
CITY ENGINEER

APPROVED
[Signature] 2-28-77
CITY ENGINEER



AGRA Infrastructure, Inc.
1000 S. Las Vegas Blvd., Suite 1000
Las Vegas, NV 89101
702-735-1111

AGRA Infrastructure, Inc.
1000 S. Las Vegas Blvd., Suite 1000
Las Vegas, NV 89101
702-735-1111