

C L V GENERAL NOTES

- 1. ALL CONSTRUCTION AND MATERIALS SHALL BE IN ACCORDANCE WITH THE "UNIFORM STANDARD SPECIFICATIONS FOR PUBLIC WORKS CONSTRUCTION OFF-SITE IMPROVEMENTS, CLARK COUNTY AREA NEVADA," LATEST EDITION...

C.L.V. TRAFFIC NOTES

- 1. ALL CONSTRUCTION SIGNING, BARRICADE, AND TRAFFIC DELINEATION SHALL CONFORM TO THE "NEVADA WORK ZONE TRAFFIC CONTROL HANDBOOK," LATEST EDITION...

C L V SEWER NOTES

- 1. ALL CONSTRUCTION AND MATERIALS SHALL BE IN ACCORDANCE WITH THE LATEST EDITION OF THE DESIGN AND CONSTRUCTION STANDARDS FOR WASTEWATER COLLECTION SYSTEMS AND THE UNIFORM STANDARD SPECIFICATIONS FOR PUBLIC WORKS CONSTRUCTION OFF-SITE IMPROVEMENTS...

THE WATER LINE IS INSTALLED OVER THE SEWER/STORM LINE. IF THIS DISTANCE CANNOT BE MAINTAINED BECAUSE OF PHYSICAL OBSTRUCTIONS OR THE WATER LINE MUST BE PLACED UNDER THE SEWER/STORM LINE...

C L V FIRE NOTES

- 1. ALL WORK SHALL BE DONE IN STRICT ACCORDANCE WITH THE CITY OF LAS VEGAS FIRE DEPARTMENT'S ORDINANCE #5115, "HYDRANT SPECIFICATIONS" AND "HYDRANT INSTALLATION SPECIFICATION"...

C L V GRADING NOTES

- 1. IN THE EVENT THAT ANY UNFORESEEN CONDITIONS NOT COVERED BY THESE NOTES ARE ENCOUNTERED DURING GRADING OPERATIONS, THE OWNER/ENGINEER SHALL BE IMMEDIATELY NOTIFIED FOR DIRECTION...

L V V W D NOTES


- 1. NO WORK SHALL BEGIN UNTIL THE WATER PLANS HAVE BEEN RELEASED FOR CONSTRUCTION BY LVVWD. FOLLOWING WATER PLAN APPROVAL, 48 HOUR NOTICE SHALL BE GIVEN TO THE LVVWD COMMUNICATION SUPPORT CENTER...

C L V STREET LIGHTS NOTES

- 1. ALL STREET LIGHTING INSTALLATIONS SHALL BE IN ACCORDANCE WITH THE STREET LIGHTING PLANS, THE "UNIFORM STANDARD SPECIFICATIONS FOR PUBLIC WORKS CONSTRUCTION OFF-SITE IMPROVEMENTS, CLARK COUNTY AREA NEVADA," LATEST REVISIONS...

PUBLIC WORKS UTILITY NOTES

- 1. INSPECTIONS ARE REQUIRED. CALL 24 HOURS IN ADVANCE (702) 455-6810. 2. PROPER SIGNS, BARRIERS, BARRICADES AND LIGHTS SHALL BE PLACED AND MAINTAINED IN ACCORDANCE WITH THE LATEST "MANUAL ON UNIFORM TRAFFIC CONTROL DEVICES FOR STREETS AND HIGHWAYS" AS PUBLISHED BY THE U.S. DEPARTMENT OF COMMERCE...

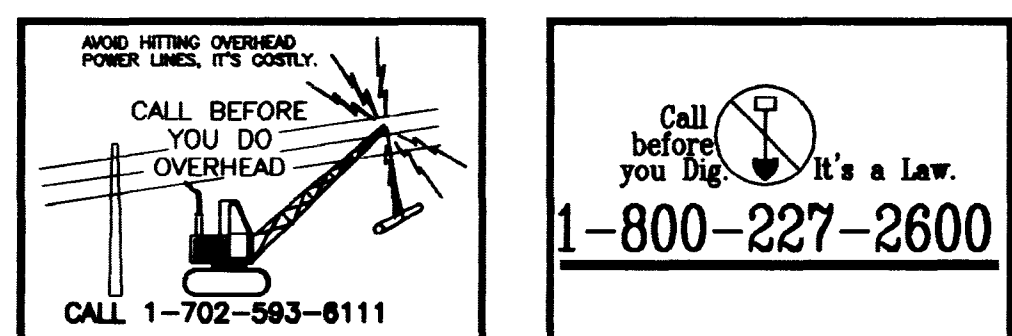

BASIS OF BEARING

BEING THE CENTERLINE OF US HIGHWAY 95 (RANCHO DRIVE) N 36°26'00" W

BENCHMARK

#700012NES. RIVET & PLATE IN TOP OF HEADWALL NORTH SIDE OF RANCHO ROAD AT JONES BOULEVARD, ELEV. 2233.076 FT OR 690.5209 METERS PER CURRENT C.L.V. DATUM (NAVD 88)

CONSTRUCTION NOTES:

SEE PLAN SHEETS

QUANTITY ESTIMATES

Table with 2 columns: Item description and Quantity. Includes items like 8" VALLEY GUTTER (450 SF), TYPE II BASE (57 CY), SIDEWALK RAMP (25 SF), etc.


DEVIATION FROM STANDARDS

NONE

GENERAL NOTE SHEET HONDA NORTHWEST

SCALE: AS NOTED

PROJECT NO: 02-198-062

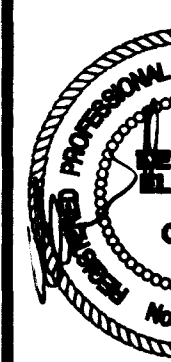

C2

2 of 7 SHEETS

DRAWING NO. 107-V3120

DOLE & MARGE BOWREN ENGINEERING GLOBAL SOLUTIONS 380 SOUTH RANCHO LAS VEGAS, NEVADA (702) 666-1955

AGRA Infrastructure, Inc. ENGINEERING GLOBAL SOLUTIONS 3016 W. LAS VEGAS, NEVADA 89102 (702) 678-3617

REVISION BY DATE

CITY OF LAS VEGAS

10/19

17177

