

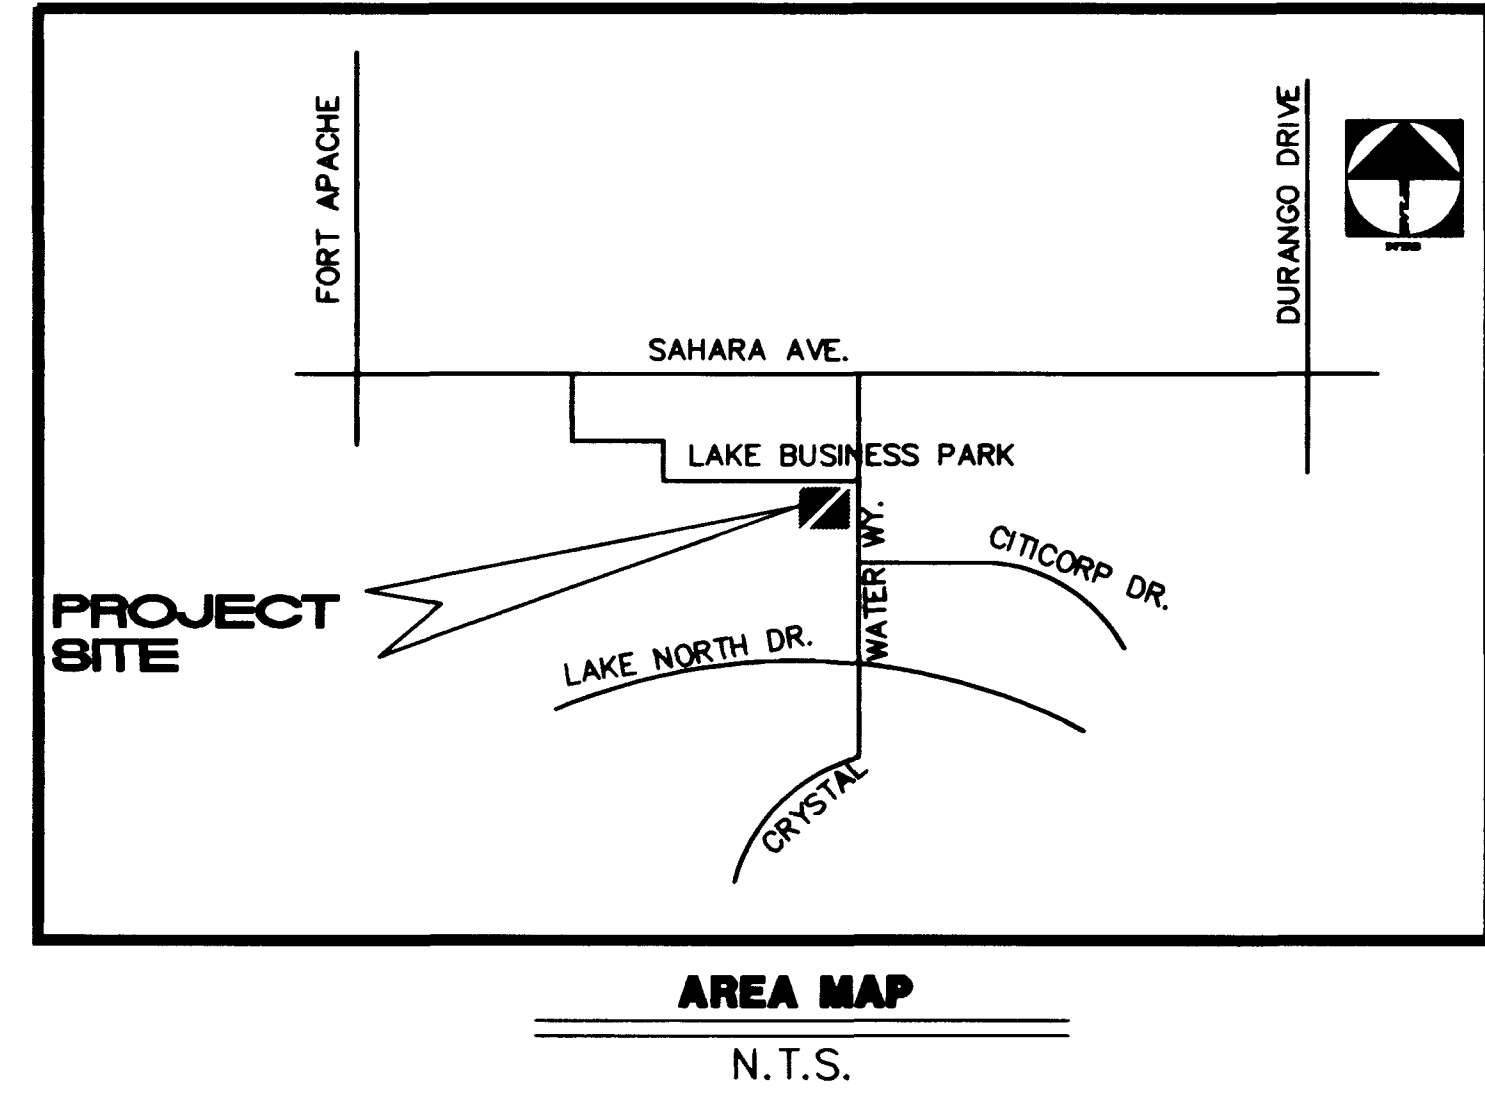


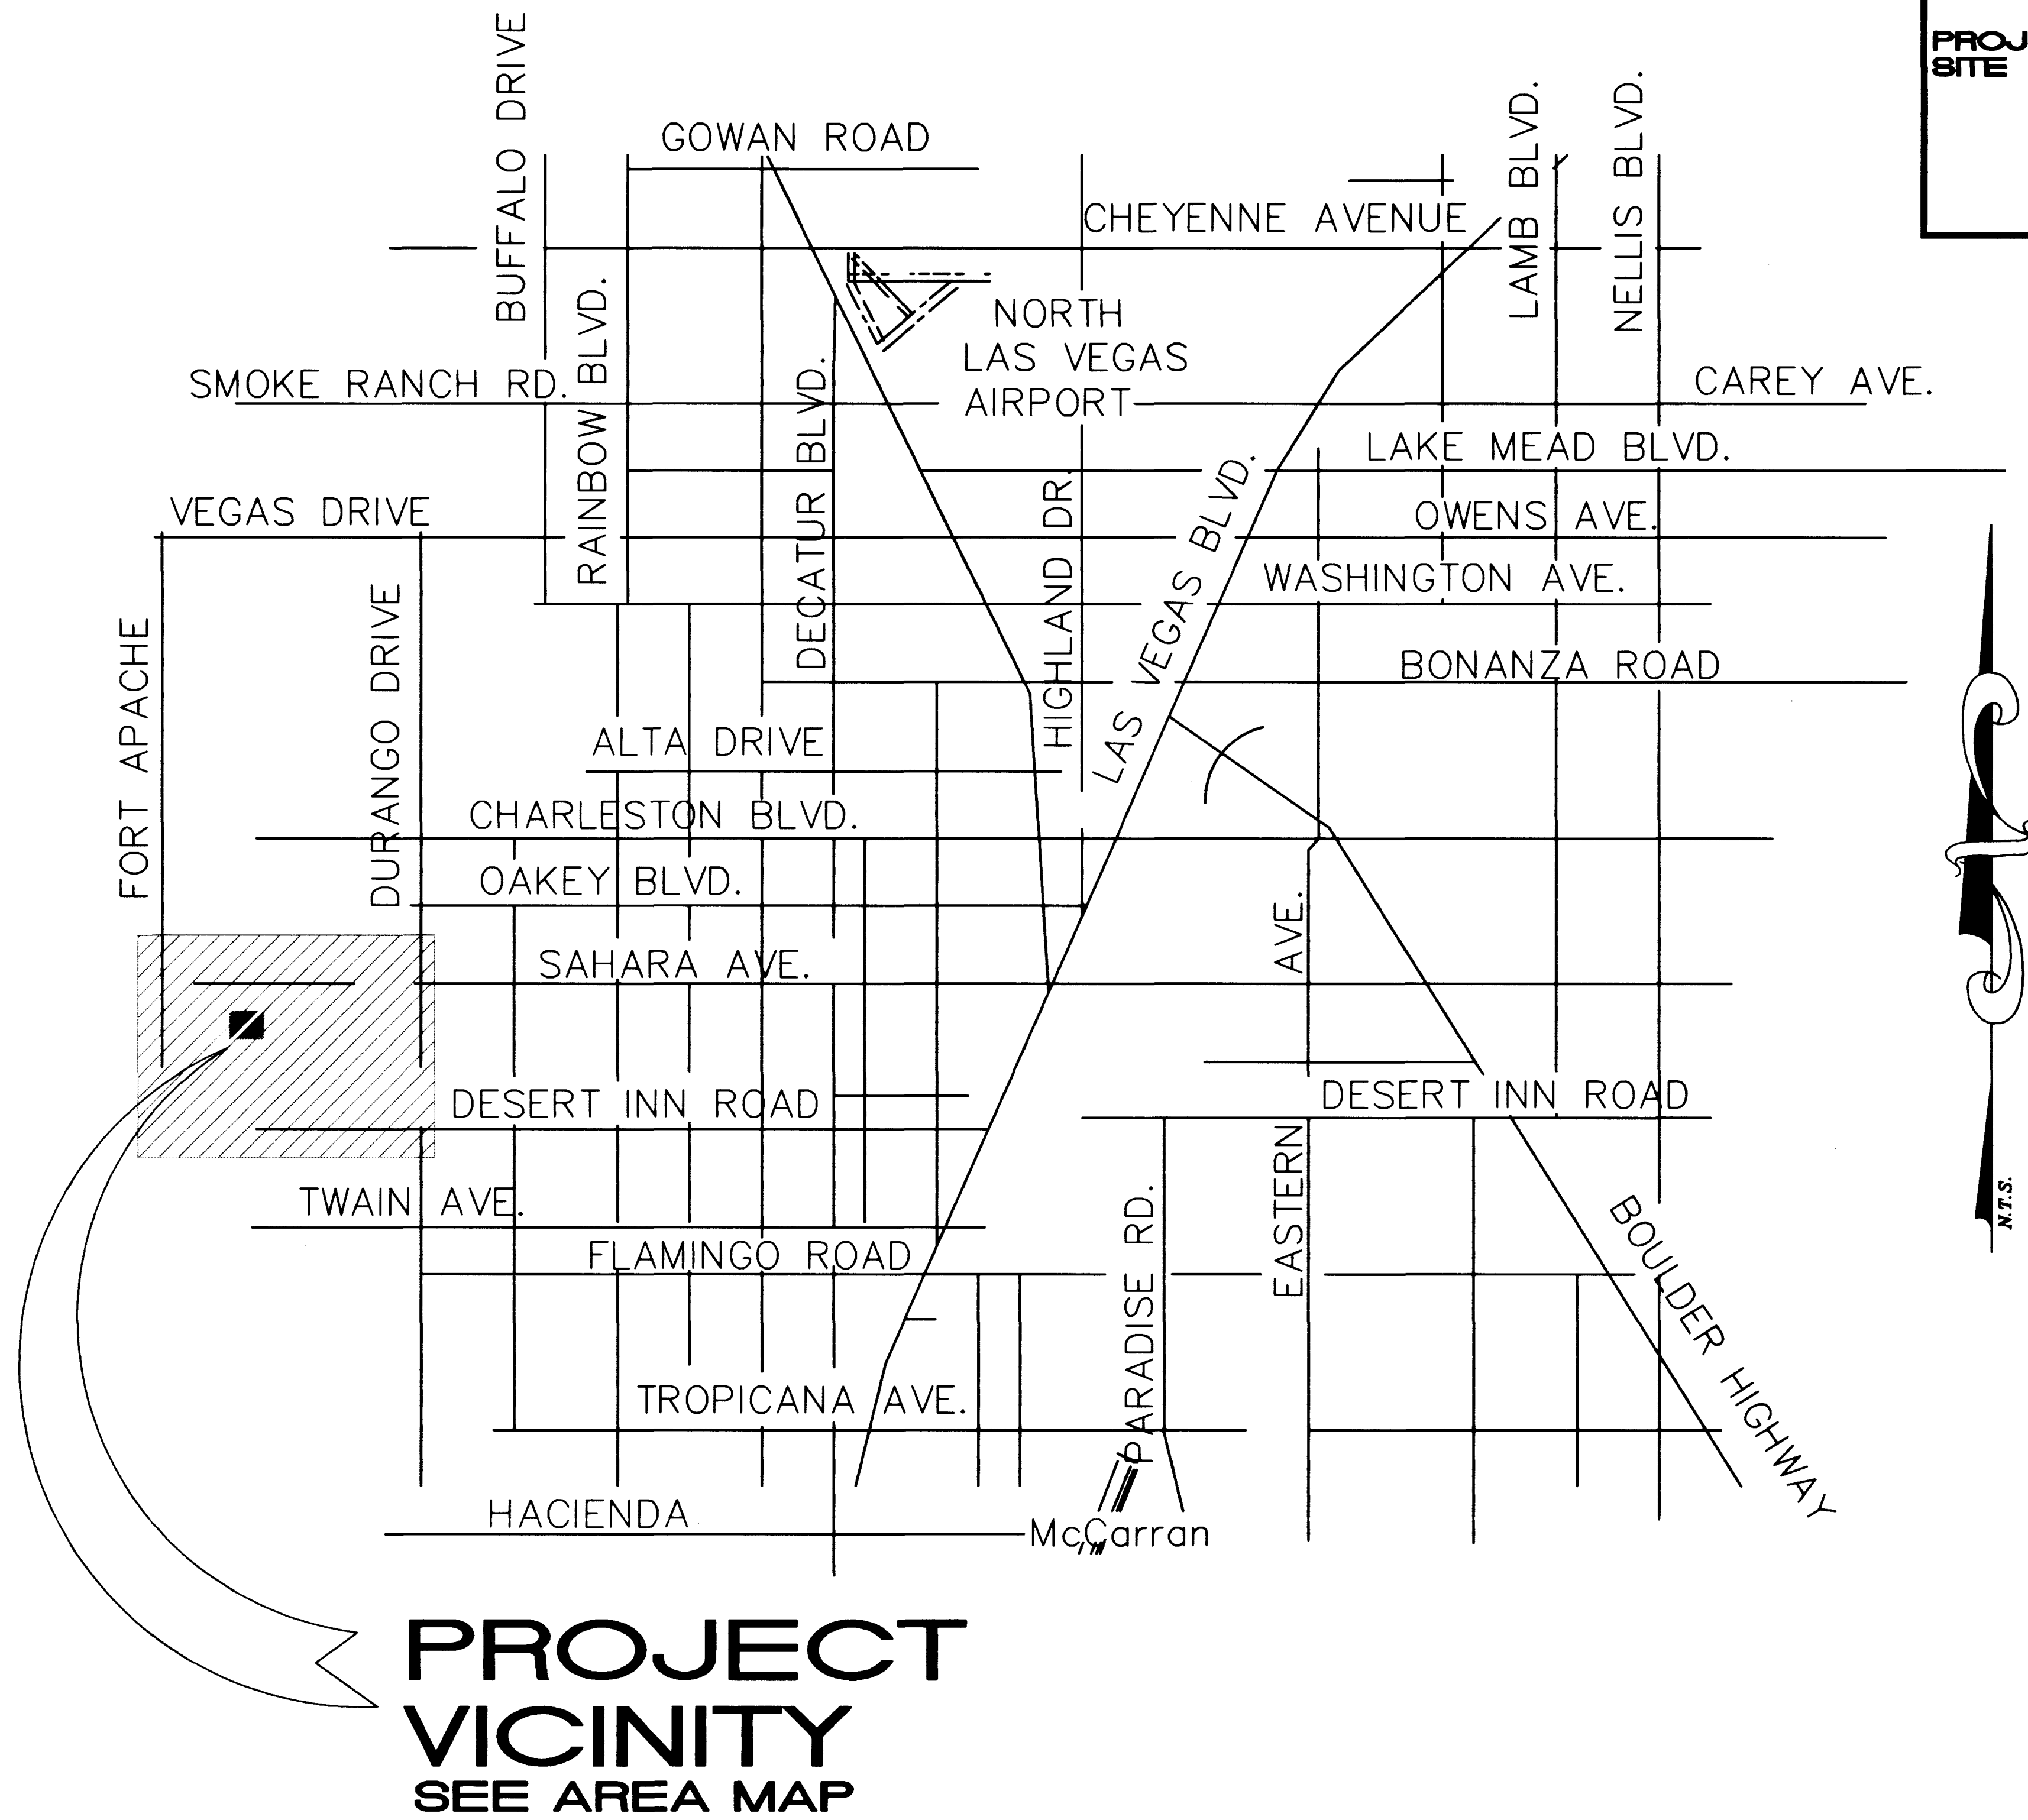

SHEET INDEX

- C1 COVER SHEET
C2 VICINITY MAP
C3 GENERAL NOTES
C4 QUANTITY SHEET
C5 HORIZONTAL CONTROL & UTILITY PLAN
C6 GRADING PLAN

Drawn by: _____ OF: _____ 11/4/97 Designed by: _____ P.J.J Checked by: _____ P.J.J	SHEET TITLE: VICINITY MAP	PROJECT: KUIAIVA DENTAL OFFICE	Project No.: _____ 49609.3A001 Scale: N/A	DR. TIM KUIAIVA 245 S. UNIVERSITY AVE. LAS VEGAS NV. 89102 (702) 264-1444	The WTLB Group ^{INC.} Engineering • Landscape Architecture 2551 N. Green Valley Pkwy., Suite 4425 HENDERSON, NV. 89014 (702) 458-2551
SEAL  KENT B. ANDERSON CIVIL PROFESSIONAL No. 6951 (EXPIRATION 07/23/2003)	SHEET C2	2 OF 6 SHEETS	DRAWING NO. 107-V2909		

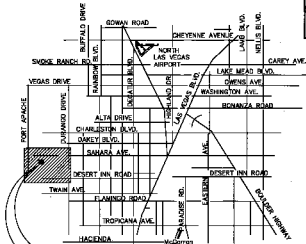

01 OWNER SHEET
 02 PLUMBING PLAN
 03 GENERAL NOTES
 04 QUANTITY SHEET
 05 FOUNDATION, CONCRETE, & UTILITY PLAN
 06 GRADING PLAN