

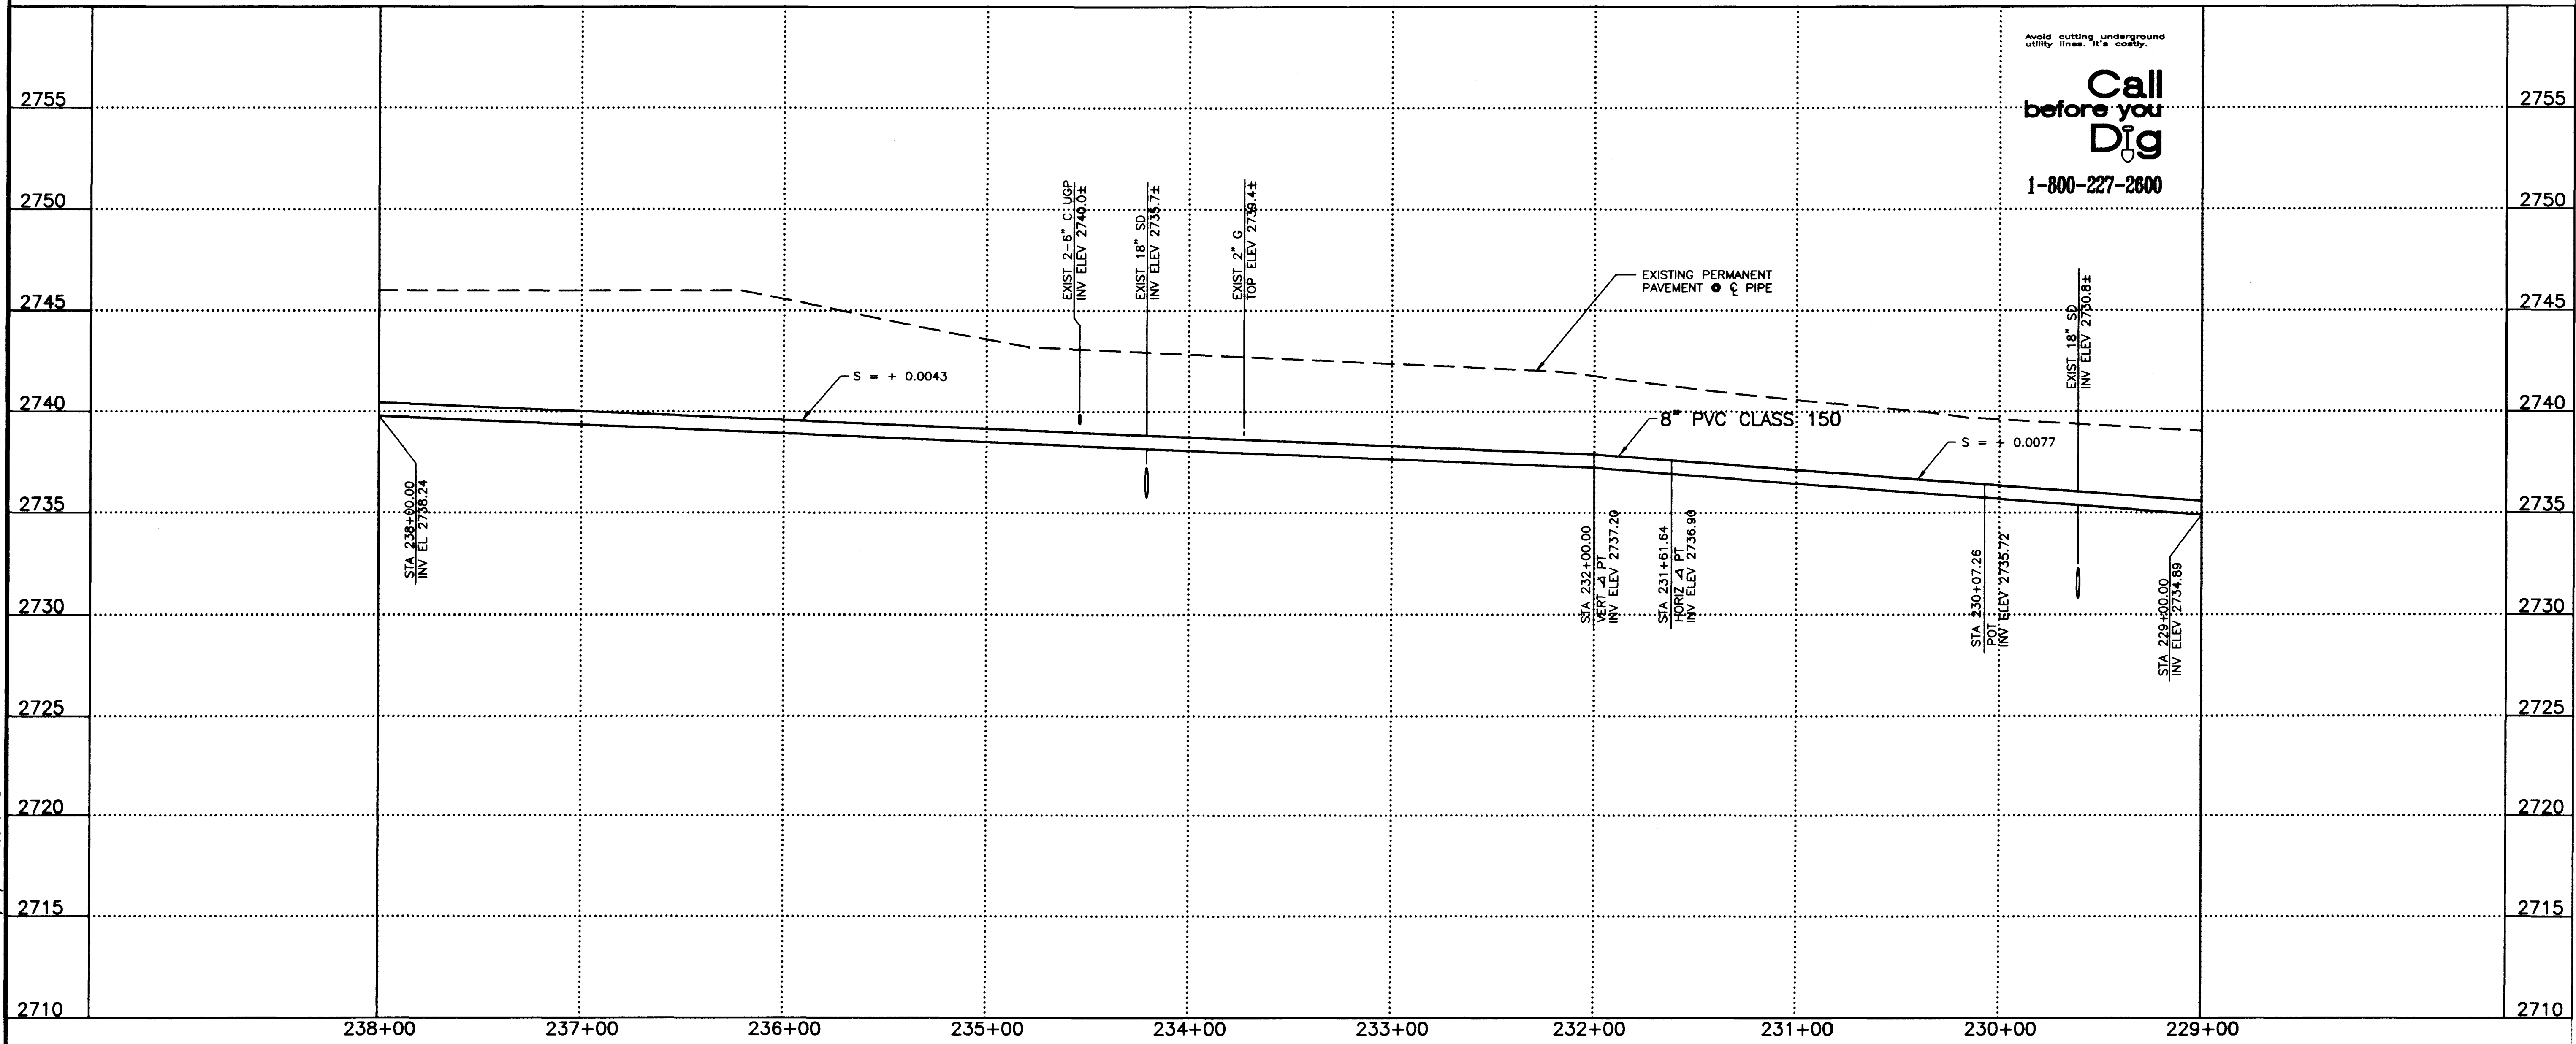


FILE: 894C21 1.0 08/12/98 16:55 CH-B

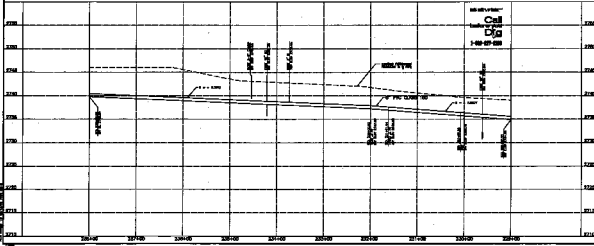

LAS VEGAS VALLEY WATER DISTRICT	
GREELEY AND HANSEN ENGINEERS 4625 SOUTH POLARIS AVENUE, SUITE 210 LAS VEGAS, NEVADA 89103	
VERIFY SCALE 1/2" = 0' 1/2"	BAR REPRESENTS ONE AND ONE HALF INCHES ON ORIGINAL
RECYCLED WATER DISTRIBUTION SYSTEM - RAMPART BLVD PIPELINE RECYCLED PIPELINE - PLAN AND PROFILE STA 229+00 TO STA 238+00	
SCALE HORIZ. SCALE 1" = 40'	VERT. SCALE 1" = 4'
894C21.DWG Plot 08/12/98 16:55	
DRAWN BY: R. ALLEE 1/19/98	CHECKED BY: W. PETERSON 6/10/98
RECOMMENDED BY: RAN G. JANDA 12/02 R.P.E. NO. DATE	APPROVED BY: ANDREW W. RICHARDSON 8/16/98 R.P.E. NO. DATE
CONTRACT NUMBER 894	
DRAWING NUMBER C21 SHEET 29 OF 51	

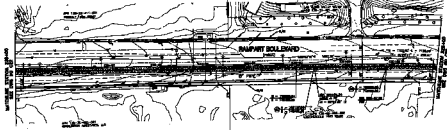

LOS ANGELES VALLEY WATER DISTRICT
 GREELY AND HAMLEN
 TRAFFIC
 485 SOUTH PALMER AVENUE, SUITE 213
 LOS ANGELES, CALIF. 90008

VERT. SCALE
 1" = 10'

HORIZONTAL SCALE
 1" = 100'

RECYCLED PAPER - 100% POST CONSUMER WASTE
 RECYCLED PAPER - 100% POST CONSUMER WASTE
 RECYCLED PAPER - 100% POST CONSUMER WASTE

894