


FILE: 894C08 1:0 08/12/98 16:46 GH-B

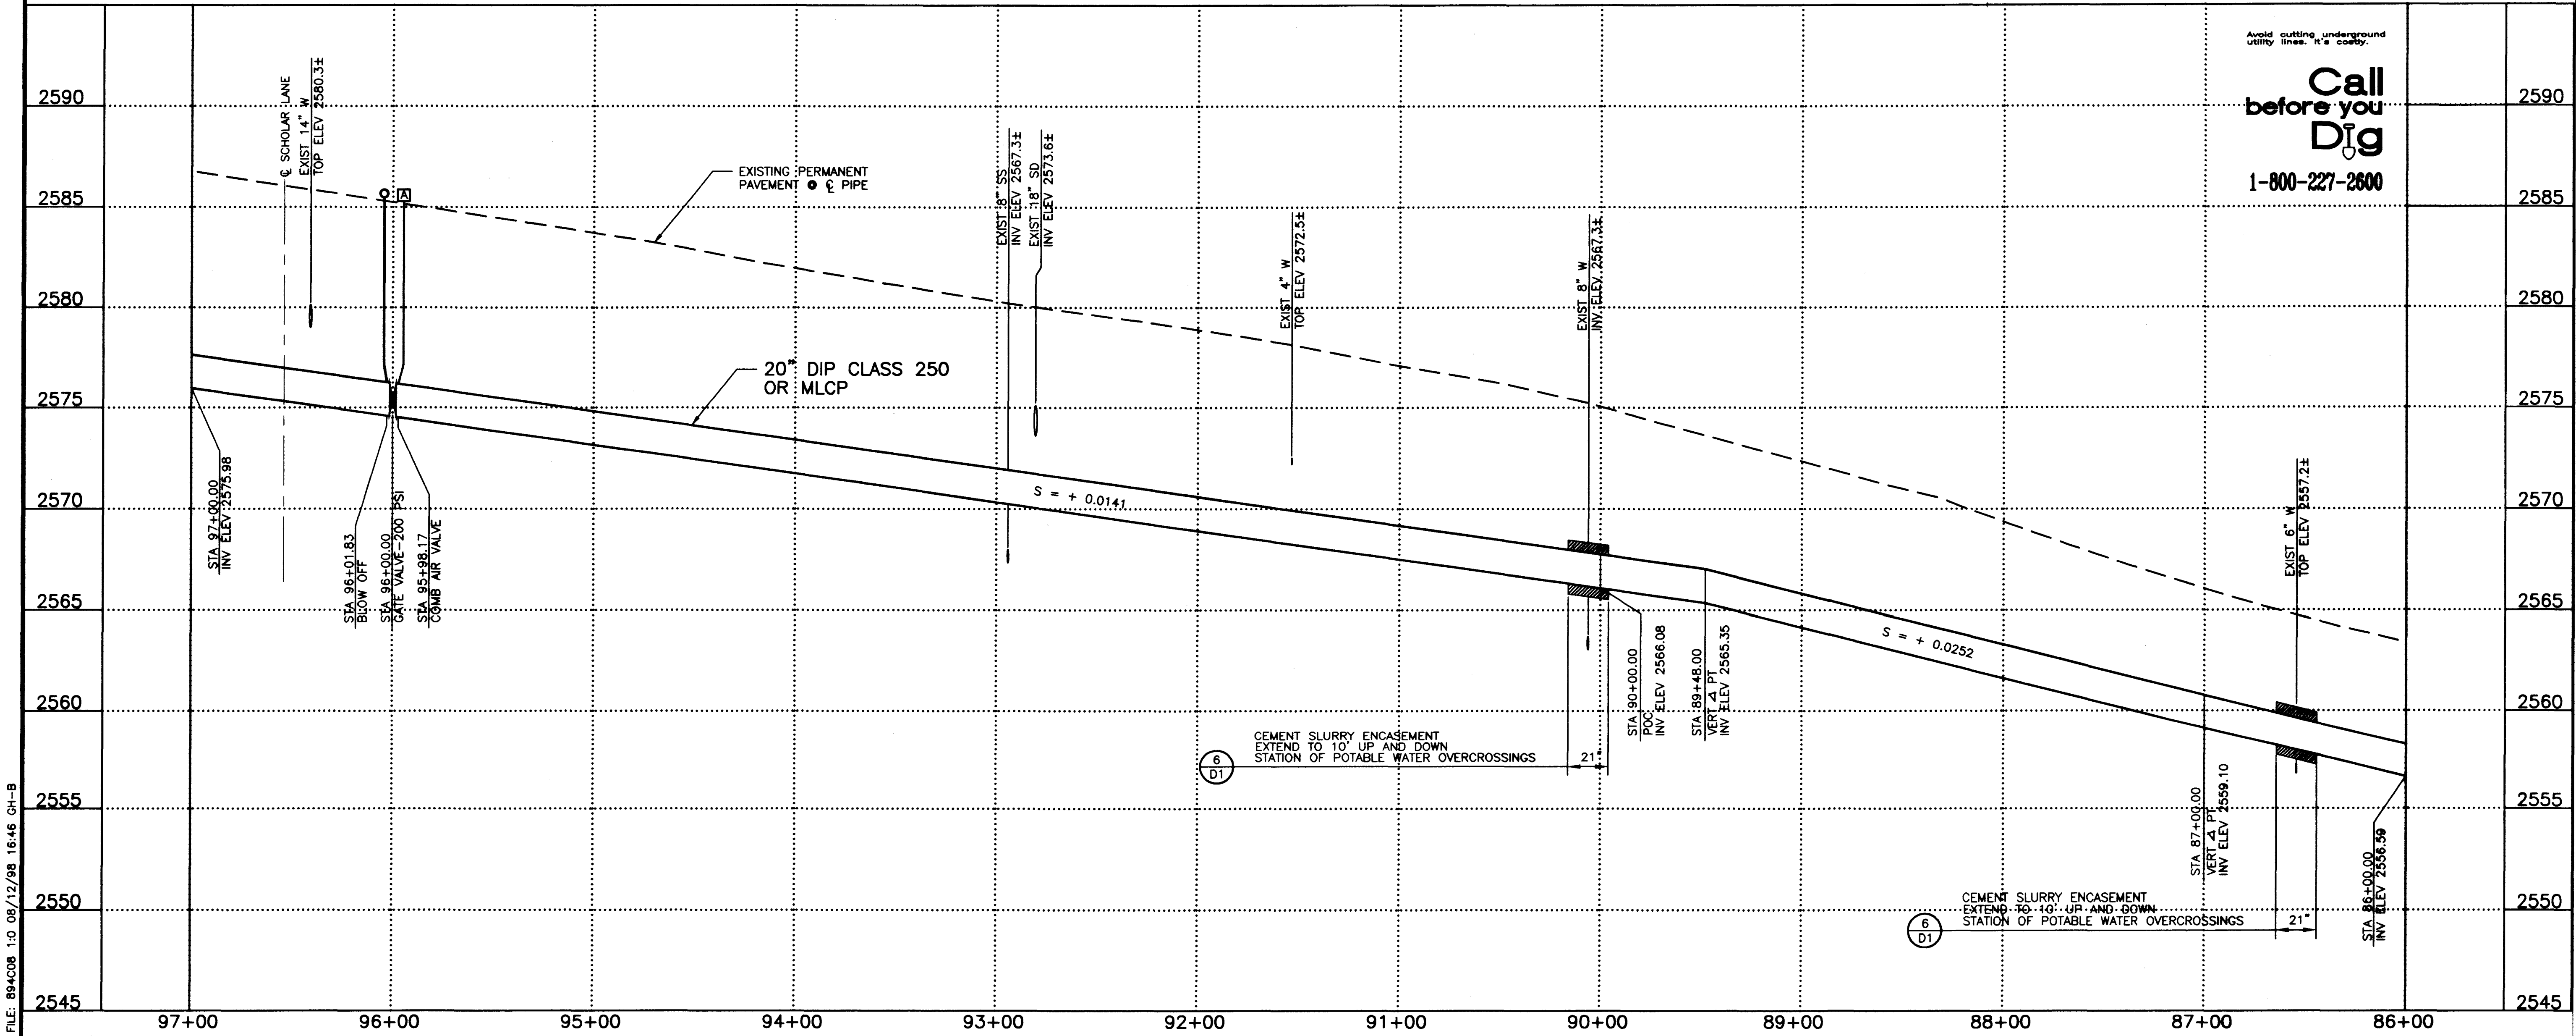

11489

LAS VEGAS VALLEY WATER DISTRICT	
GREELEY AND HANSEN ENGINEERS 4625 SOUTH POLARIS AVENUE, SUITE 210 LAS VEGAS, NEVADA 89103	
VERIFY SCALE 1/2" = 10' 1/2" = 10'	SCALE HORIZ. SCALE 1" = 40' VERT. SCALE 1" = 4'
RECYCLED WATER DISTRIBUTION SYSTEM - RAMPART BLVD PIPELINE RECYCLED PIPE - PLAN AND PROFILE STA 86+00 TO STA 97+00	
DRAWN BY: E. ATLEE 1/19/98	CHECKED BY: M. PETERSON 6/10/98
RECOMMENDED BY: R. G. JANGA 8/26/98 R.P.E. NO. DATE	APPROVED BY: ANDREW W. RICHARDSON 8/26/98 R.P.E. NO. DATE
CONTRACT NUMBER 894	
DRAWING NUMBER C8 SHEET 16 OF 51	

565-308

