



FILE: 894C10 1.0 08/12/98 16:48 CH-B

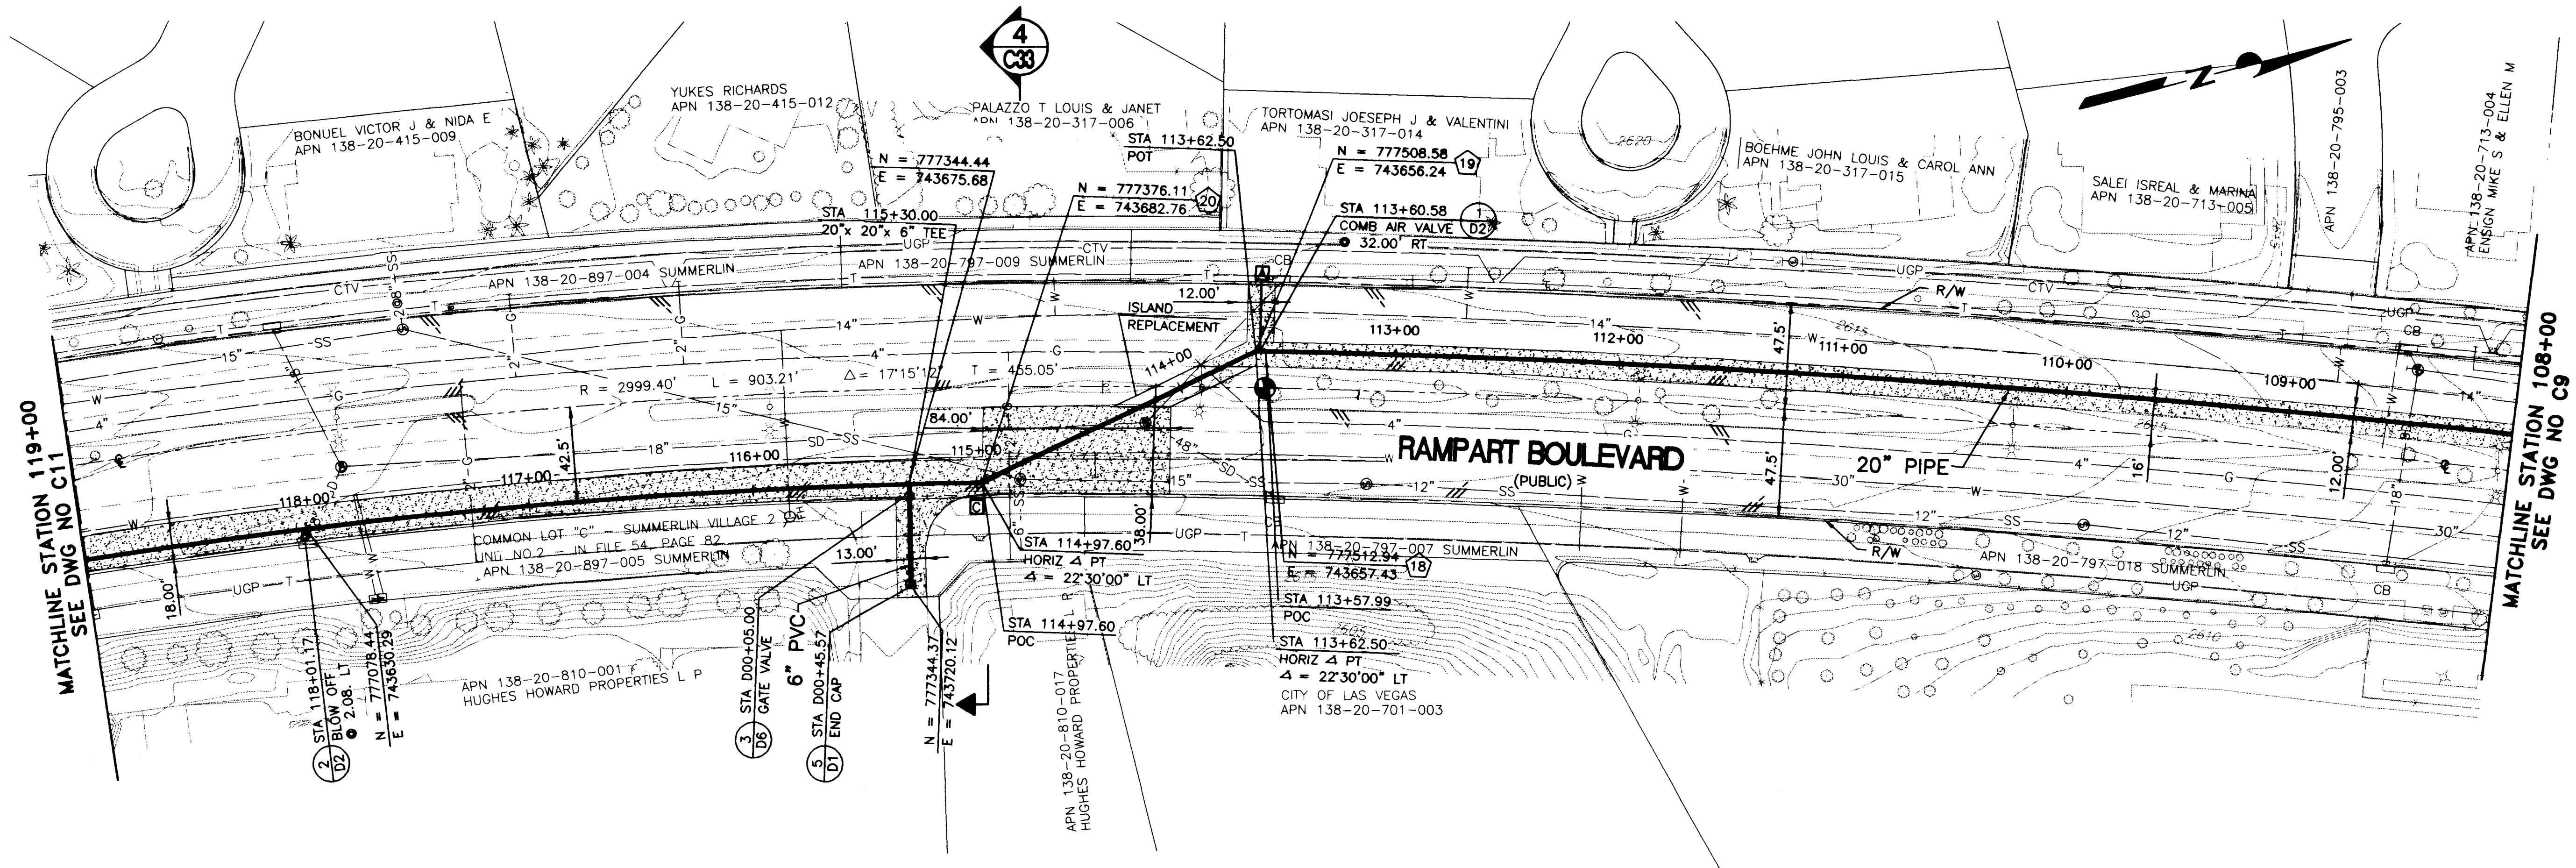


RESTRAIN ALL JOINTS FROM STA 113+51.00 TO STA 113+73.00 AND FROM STA 114+88.00 TO STA 115+07.00, AND STA D00+00 TO D00+07.

Call before you Dig
1-800-227-2600

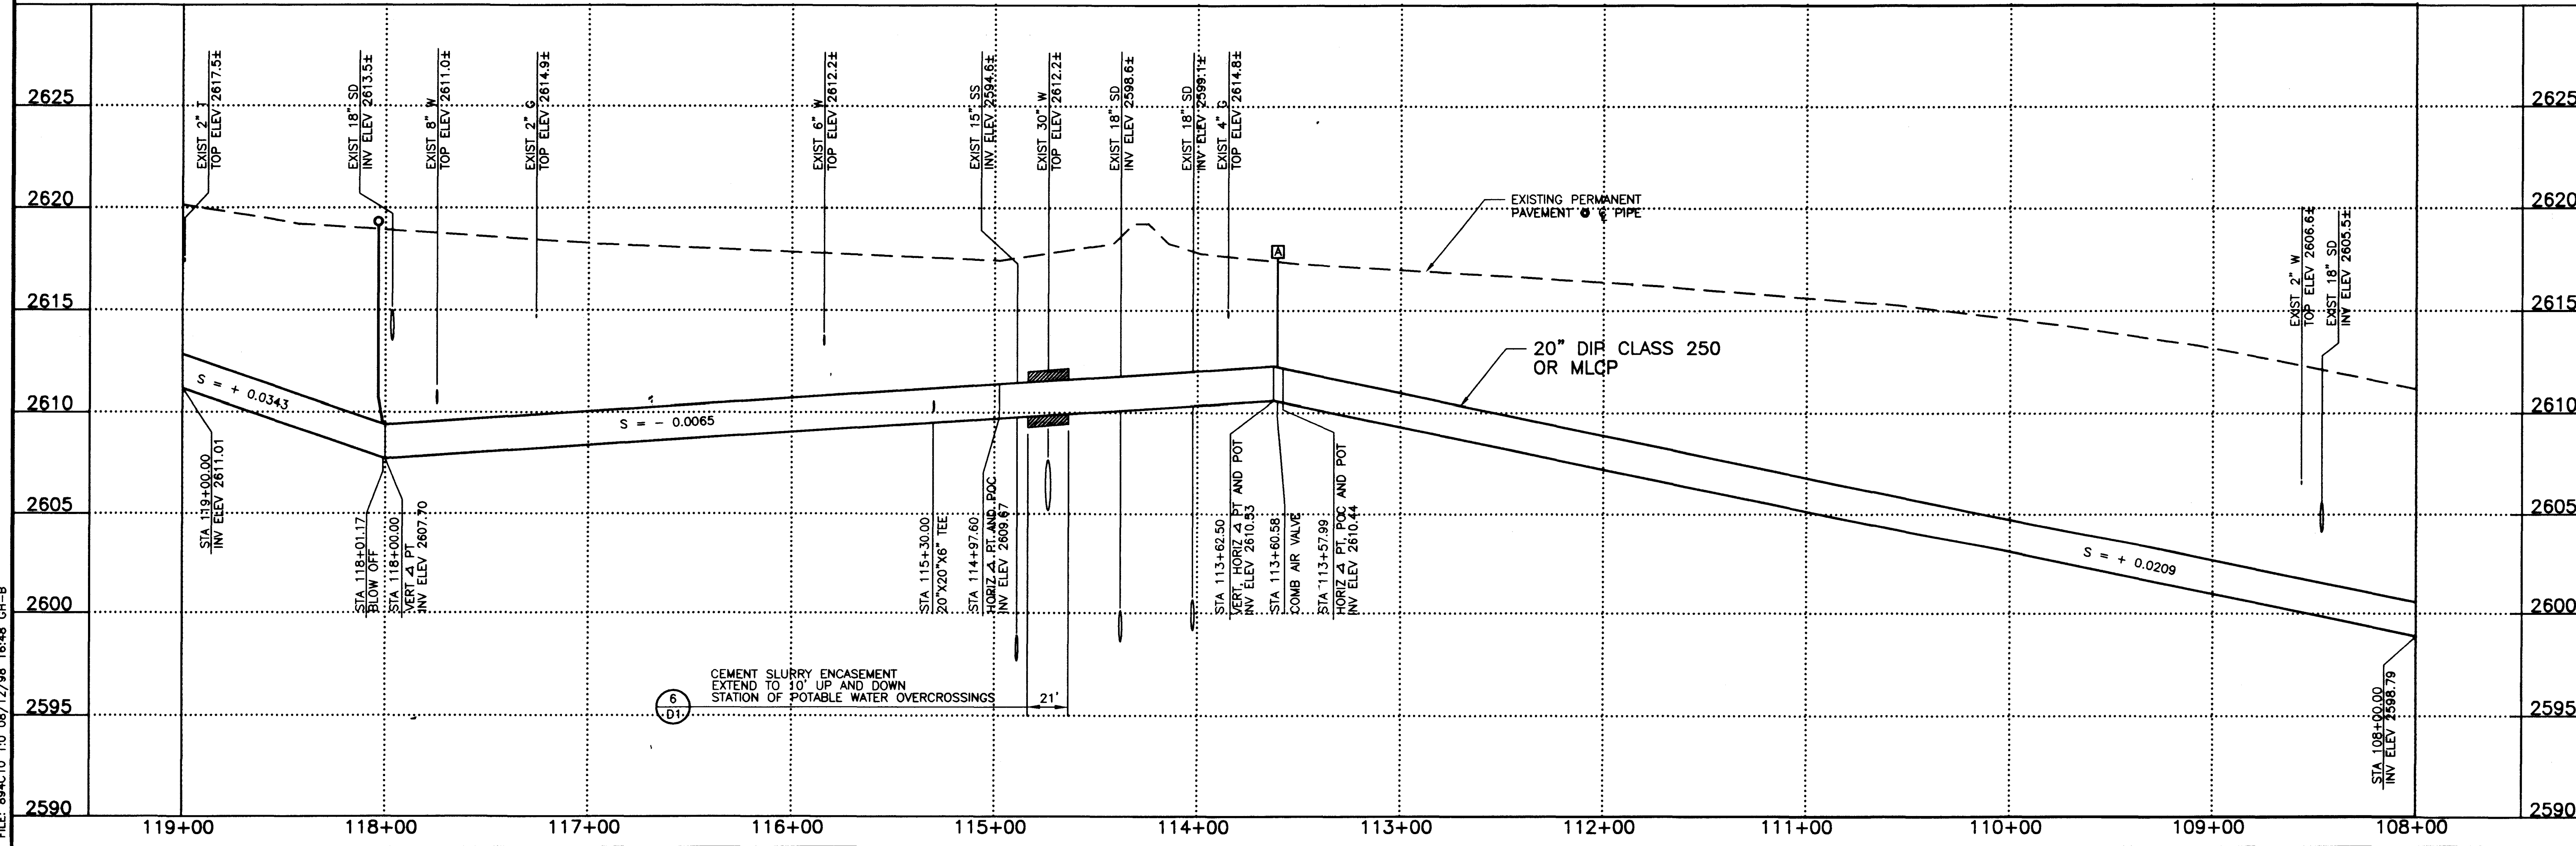


LAS VEGAS VALLEY WATER DISTRICT	
GREELEY AND HANSEN ENGINEERS	
4625 SOUTH POLARIS AVENUE, SUITE 210 LAS VEGAS, NEVADA 89103	
VERIFY SCALE 1/2" = 1' / 2"	SCALE HORIZ. SCALE 1" = 40' / 1" = 40' VERT. SCALE 1" = 4'
RECYCLED WATER DISTRIBUTION SYSTEM - RAMPART BLVD PIPELINE	
RECYCLED PIPELINE - PLAN AND PROFILE STA 108+00 TO STA 119+00	
DRAWN BY M. PETERSON	CHECKED BY M. PETERSON
RECOMMENDED BY RAM G. JANKA	DATE 8/24/98
DESIGNED BY ANDREW W. RICHARDSON	DATE 8/21/98
CONTRACT NUMBER 894	
DRAWING NUMBER C10 SHEET 18 OF 51	

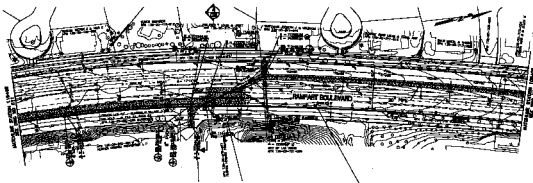

RETRACT ALL JOBS FROM STA
114+00 TO STA 114+00 AND FROM
STA 114+00 TO STA 114+00 AND
STA 114+00 TO STA 114+00
AND STA 114+00 TO STA 114+00

Cal
before you
Dig
1-800-887-8888

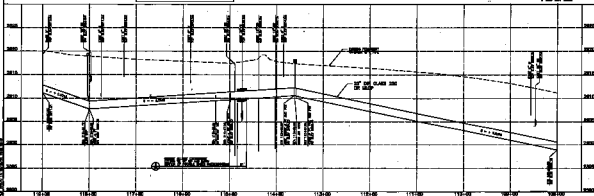

	PROJECT NO. 114+00 TO STA 114+00 STA 114+00 TO STA 114+00 STA 114+00 TO STA 114+00 STA 114+00 TO STA 114+00	RECYCLED PAPER - PLAN AND PROFILE RECYCLED PAPER - STA 114+00 TO STA 114+00	VERT SCALE 1" = 10'	USE YOUR VERT SCALE CHECKED BY: [Signature] DATE: [Date]
	894	114+00 TO STA 114+00 STA 114+00 TO STA 114+00 STA 114+00 TO STA 114+00 STA 114+00 TO STA 114+00	114+00 TO STA 114+00 STA 114+00 TO STA 114+00 STA 114+00 TO STA 114+00 STA 114+00 TO STA 114+00	114+00 TO STA 114+00 STA 114+00 TO STA 114+00 STA 114+00 TO STA 114+00 STA 114+00 TO STA 114+00