

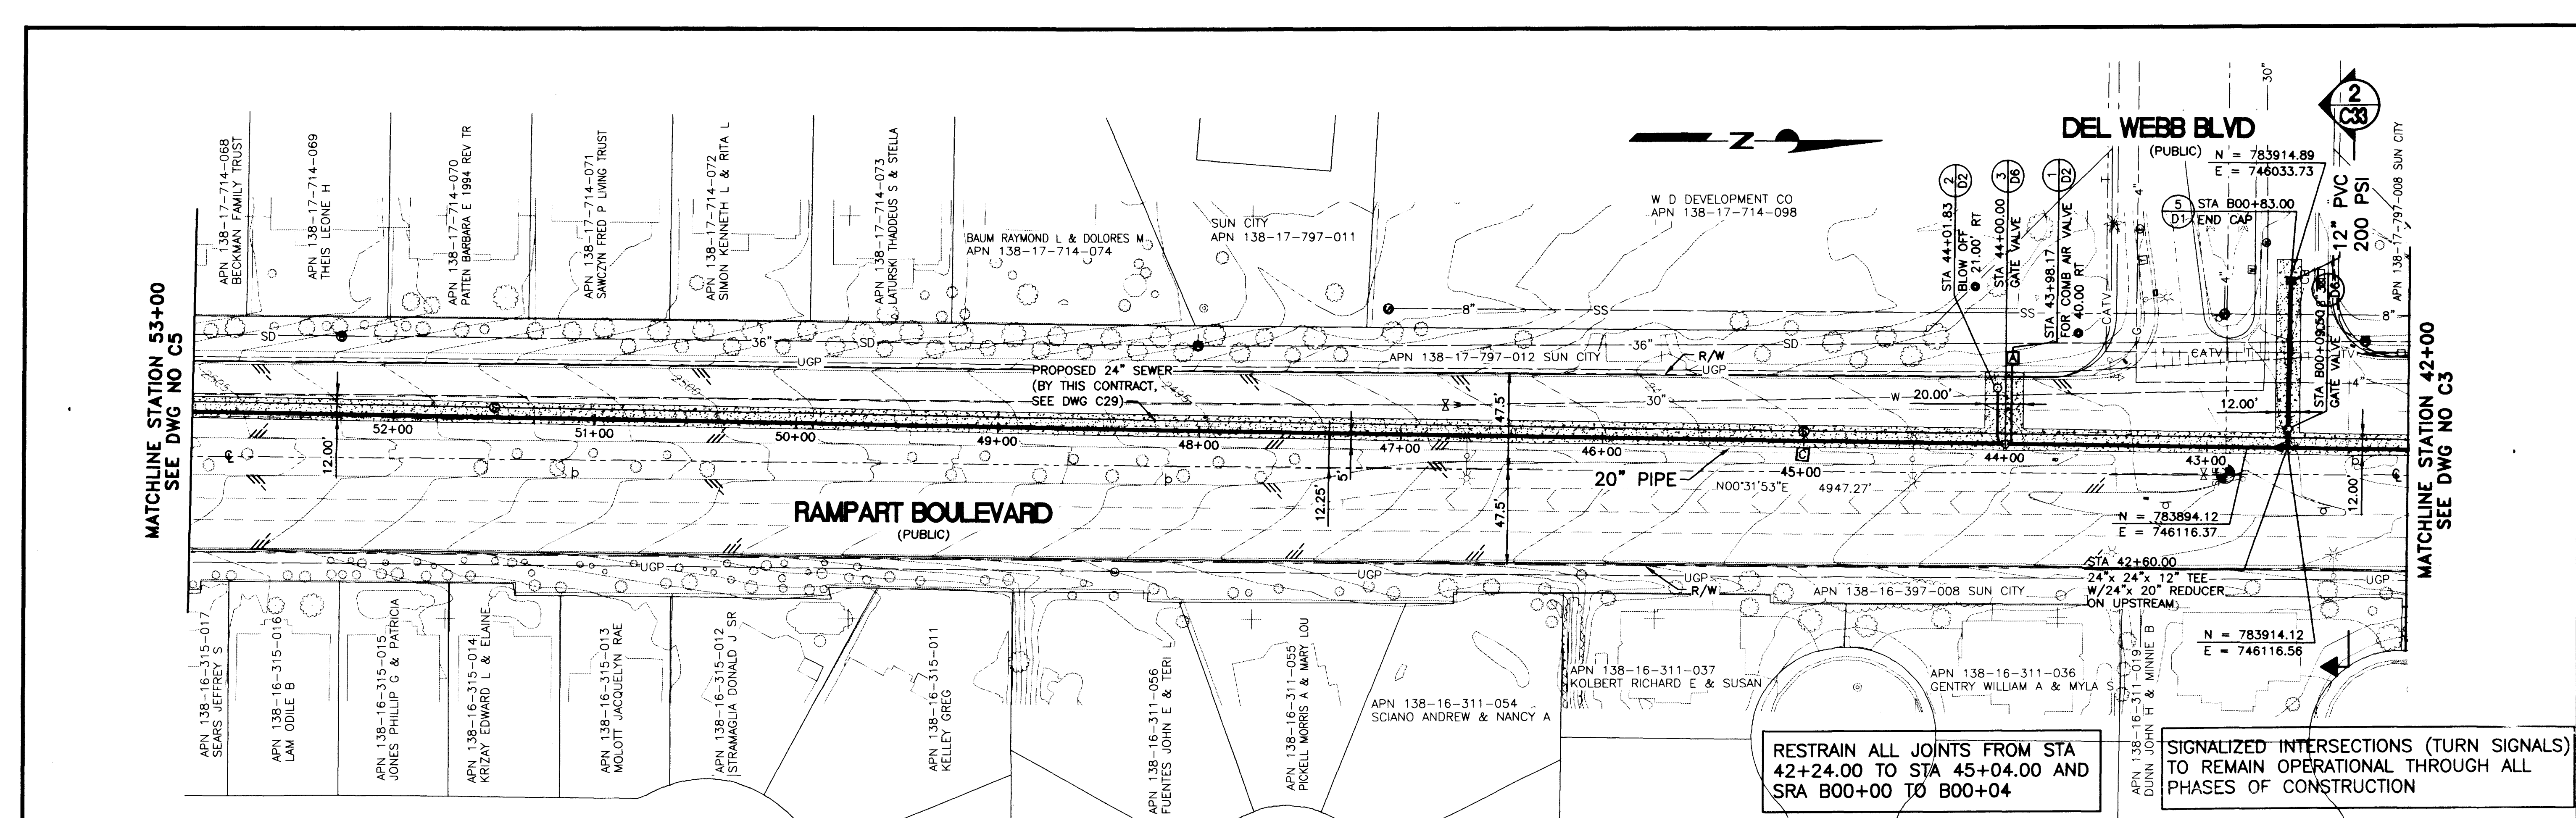
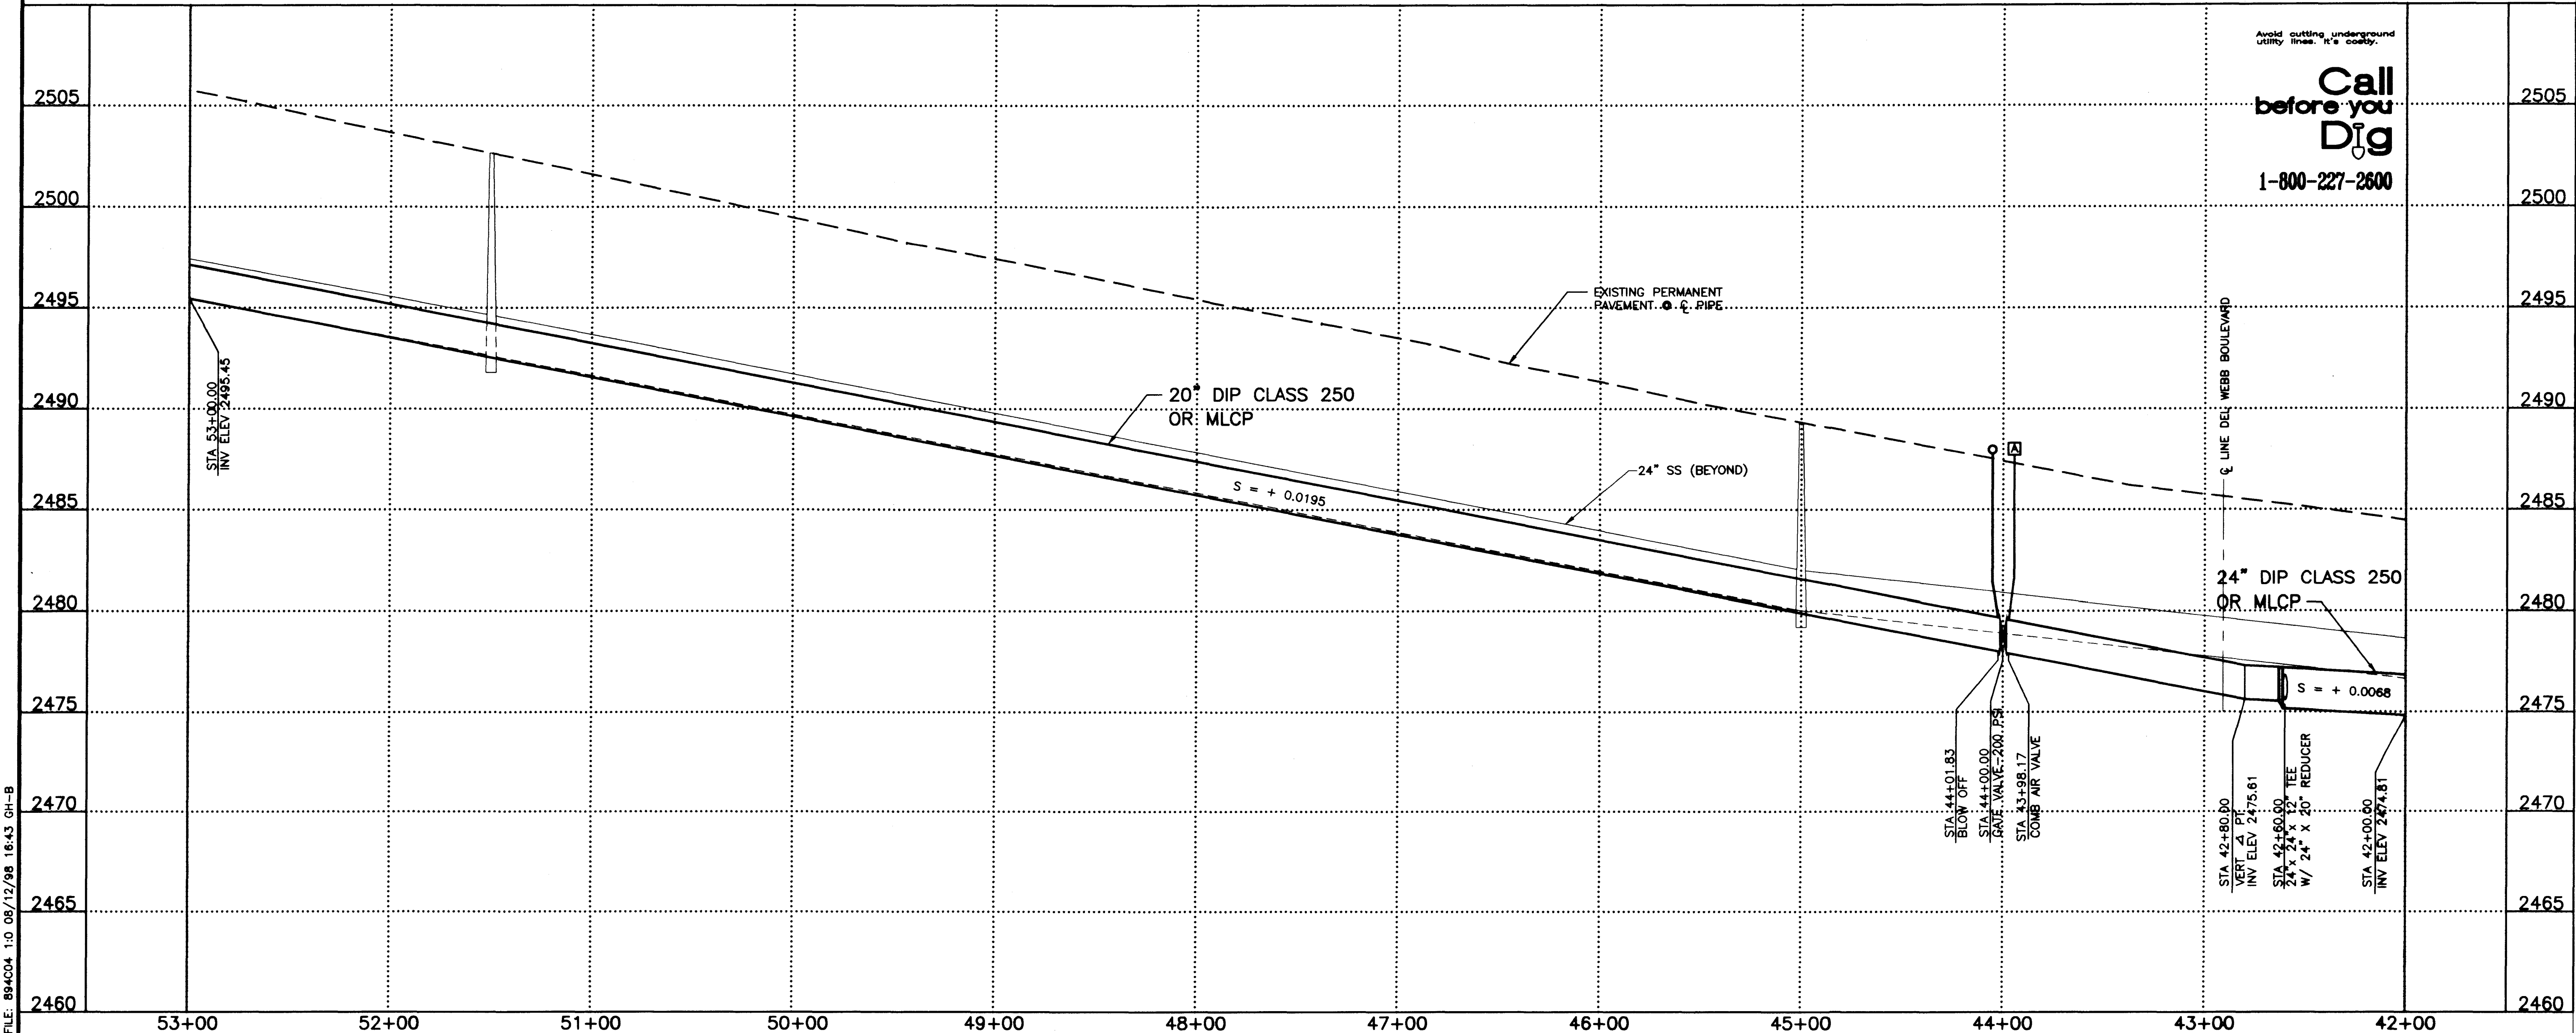


FILE: 894C04 1.0 08/12/98 16:43 GH-B

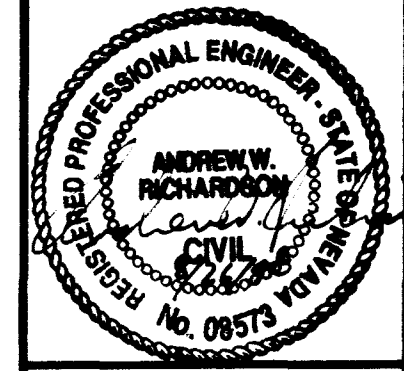


RECYCLED WATER DISTRIBUTION SYSTEM - RAMPART BLVD PIPELINE		VERIFY SCALE		LAS VEGAS VALLEY WATER DISTRICT	
RECYCLED PIPELINE - PLAN AND PROFILE		1/2" = 1'		GREELEY AND HANSEN	
STA 42+00 TO STA 53+00		ONE AND ONE-HALF INCHES ON ORIGINAL		ENGINEERS	
				4625 SOUTH POLARIS AVENUE, SUITE 210	
				LAS VEGAS, NEVADA 89103	
DRAWN BY: R. ATLEE		1/19/98			
CHECKED BY: M. PETERSON		8/10/98			
RECOMMENDED BY: R. G. JANG		12/02			
APPROVED BY: ANDREW W. RICHARDSON		8/10/98			
DATE: 8/24/98		R.P.E. NO. DATE		CONTRACT NUMBER	
				894	
				DRAWING NUMBER C4	
				SHEET 12 OF 51	

MUSKOGEE STATION BRIDGE

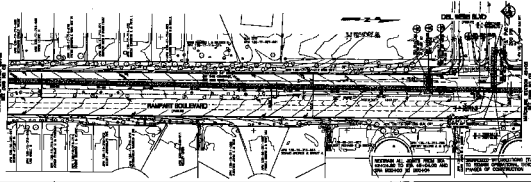

RETRACT ALL JERSEY FROM STA 42+00 TO STA 43+00 AND STA 43+00 TO STA 44+00

RETRACTED INFORMATION TURN SIGNALS TO REMAIN OPERATIONAL, DISCARD ALL PAPER OF CONSTRUCTION

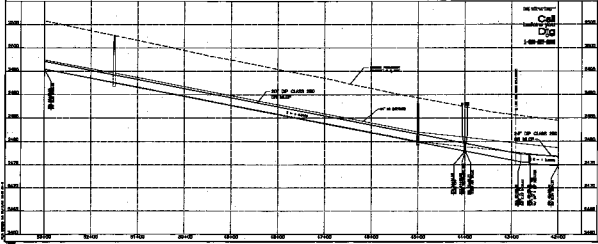

US VETERAN VALLEY ROAD BRIDGE
 GREGORY AND HANSEN
 ENGINEERS
 4405 SOUTH 7TH AVE. SUITE 200
 LAS VEGAS, NEVADA 89103

VERTY SCALE
 1" = 10'

RETRACTED INFORMATION TURN SIGNALS TO REMAIN OPERATIONAL, DISCARD ALL PAPER OF CONSTRUCTION

894