

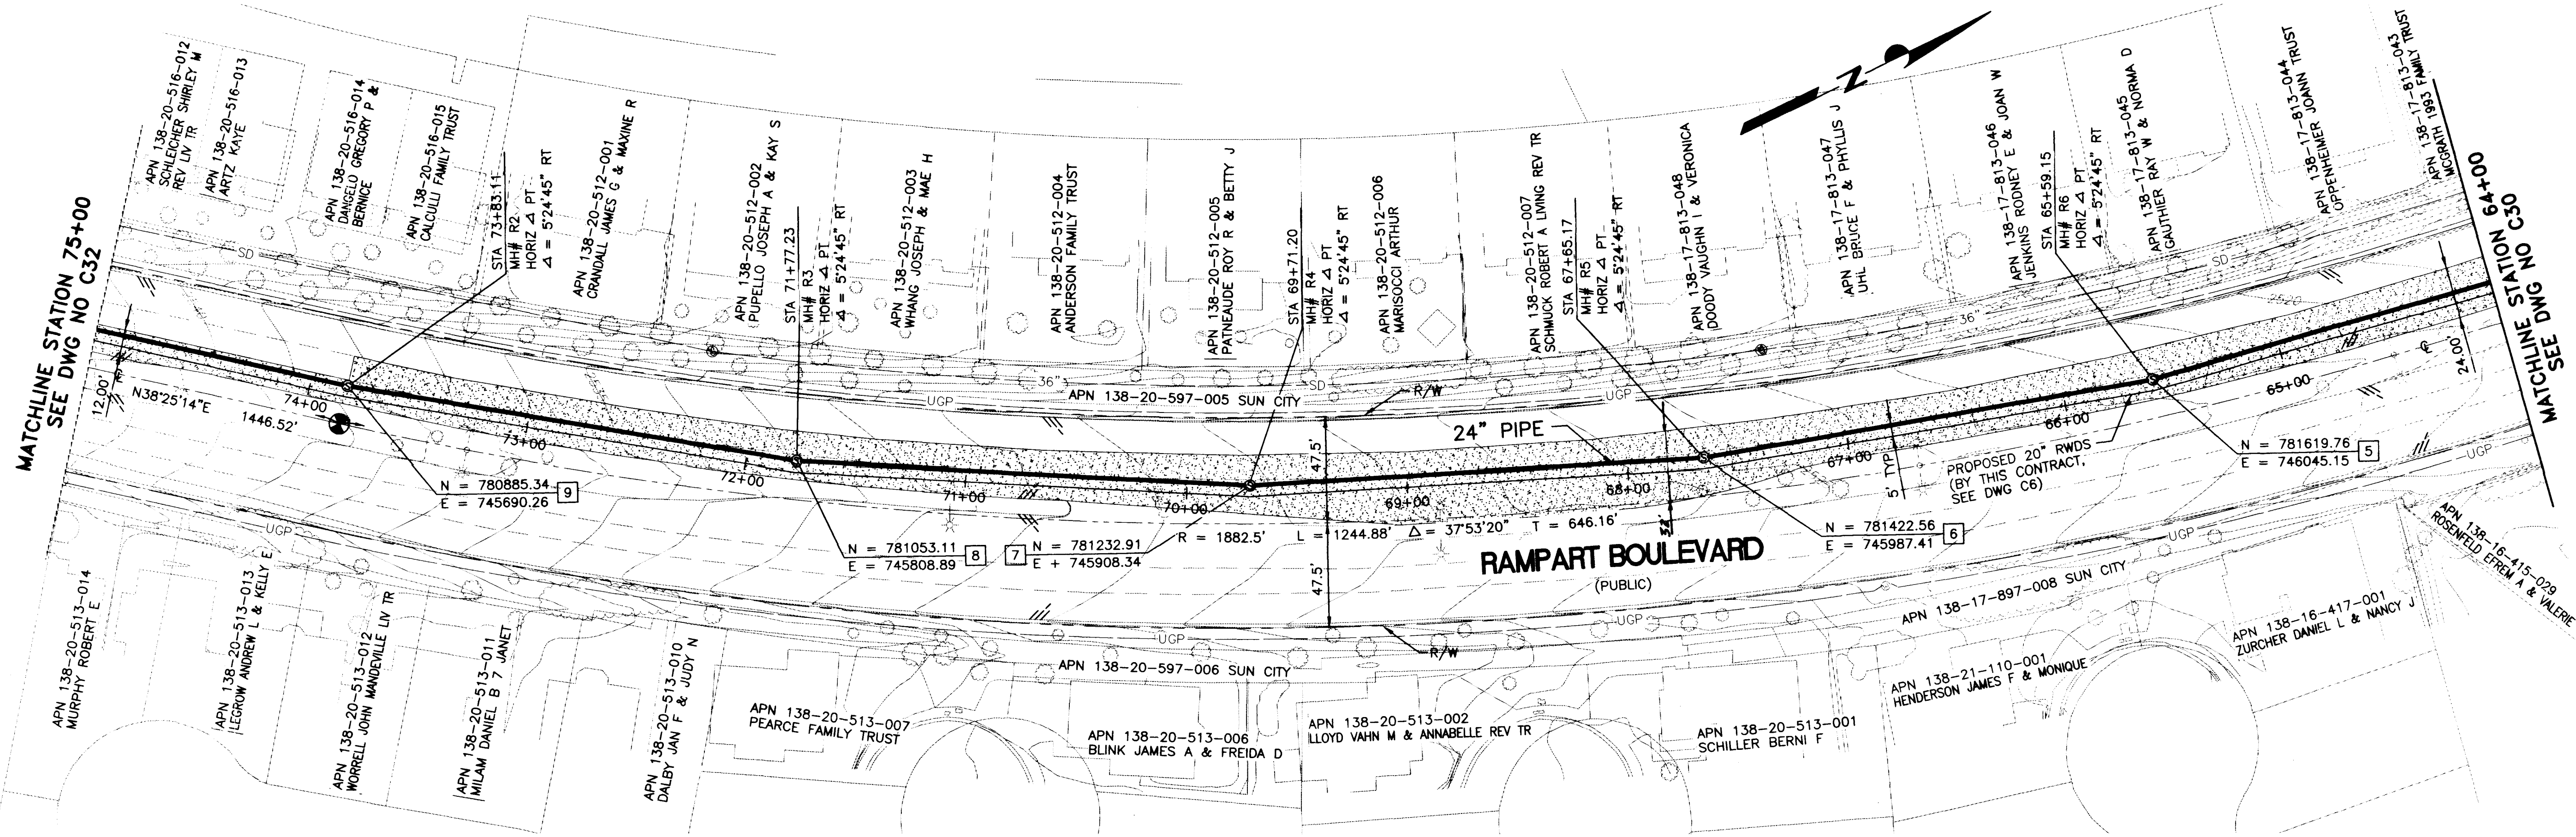


FILE: 894C31 1:0 08/12/98 17:01 GH-B

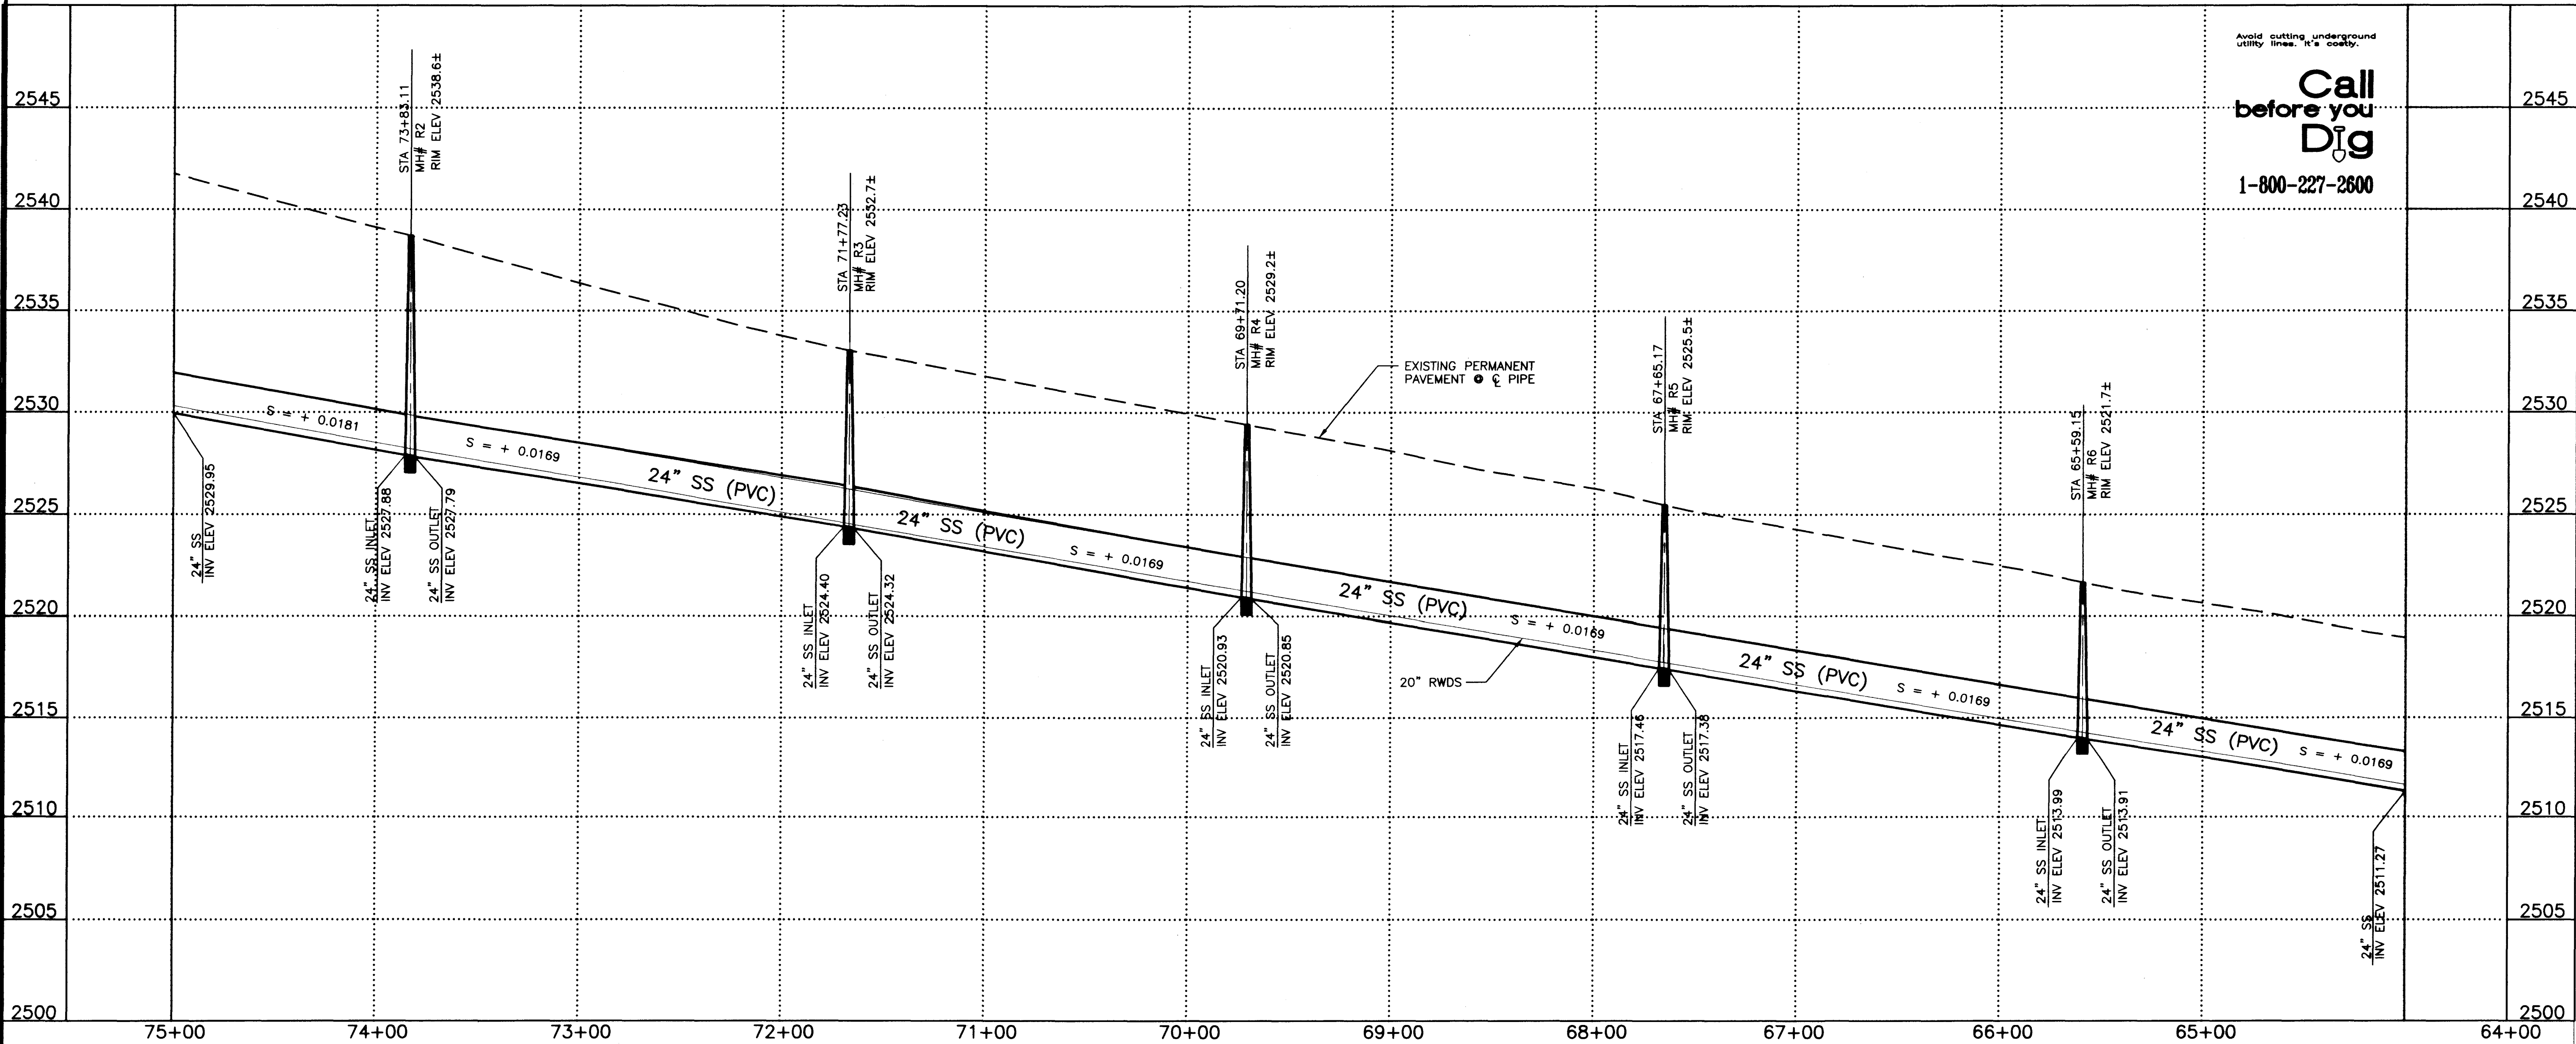

CONTRACT NUMBER
894
DRAWING NUMBER C31
SHEET 39 OF 51

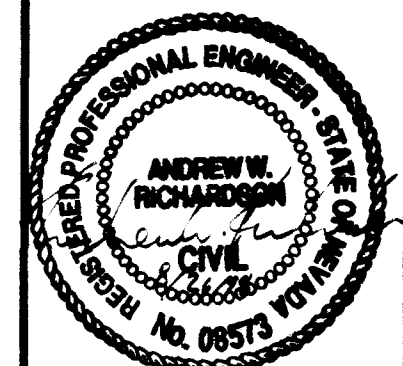

DRAWN BY: R. ATLEE
CHECKED BY: M. PETERSON
RECOMMENDED BY: *Andrew W. Richardson*
DATE: 8/16/98
R.P.E. NO. DATE: 12702
APPROVED BY: *Andrew W. Richardson*
DATE: 8/16/98
R.P.E. NO. DATE: 8573

RECYCLED WATER DISTRIBUTION SYSTEM - RAMPART BLVD PIPELINE
INFLUENT SEWER - PLAN AND PROFILE
STA 64+00 TO STA 75+00

SCALE
HORIZ SCALE
1" = 40'
VERT SCALE
1" = 4'

894C31.DWG Plot 08/12/98 17:01

VERIFY SCALE
1/2" = 0' 1/2"

BAR REPRESENTS
ONE AND ONE-HALF
INCHES ON ORIGINAL

LAS VEGAS VALLEY WATER DISTRICT
GREELEY AND HANSEN
ENGINEERS
4625 SOUTH POLARIS AVENUE, SUITE 210
LAS VEGAS, NEVADA 89103

