



FILE: 894C23 1:0 08/12/98 16:58 GH-B

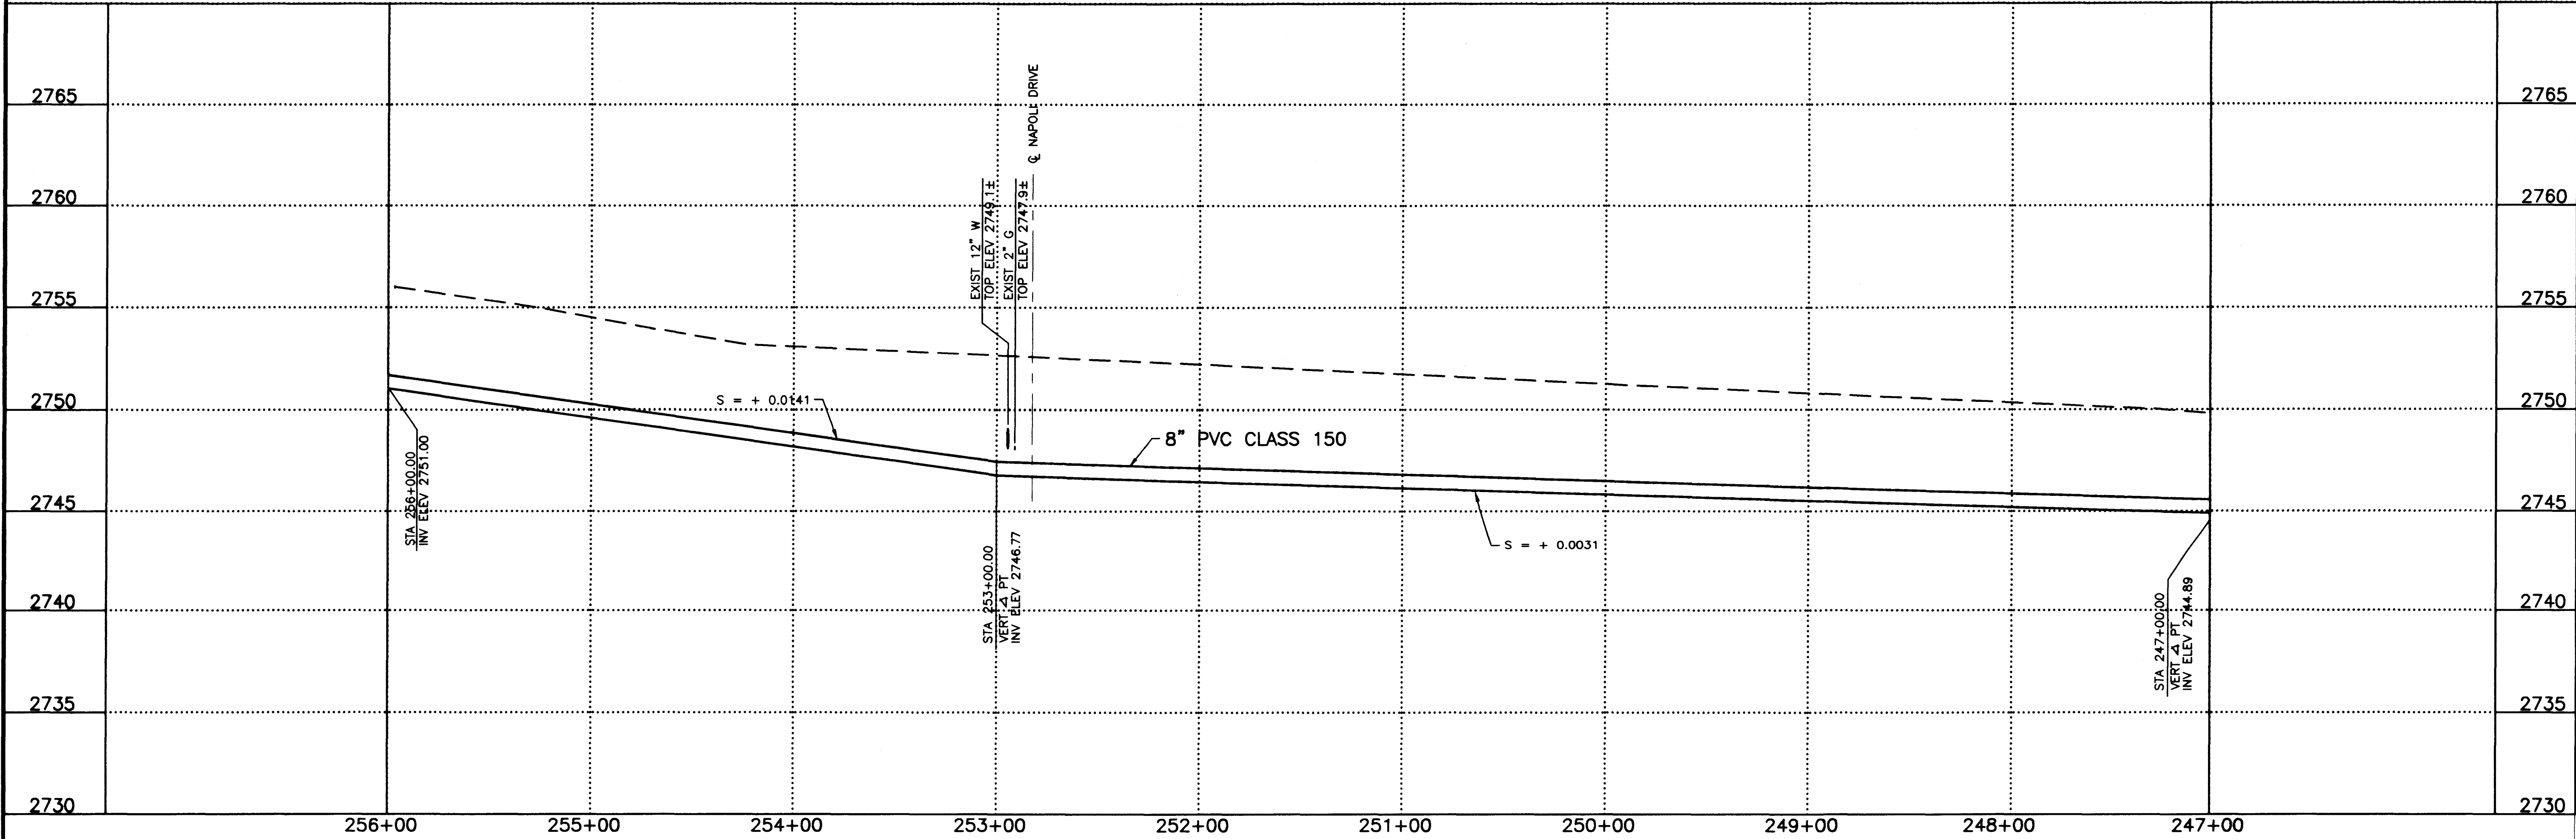

Avoid cutting underground
utility lines. It's costly.

**Call
before you
Dig**

1-800-227-2800

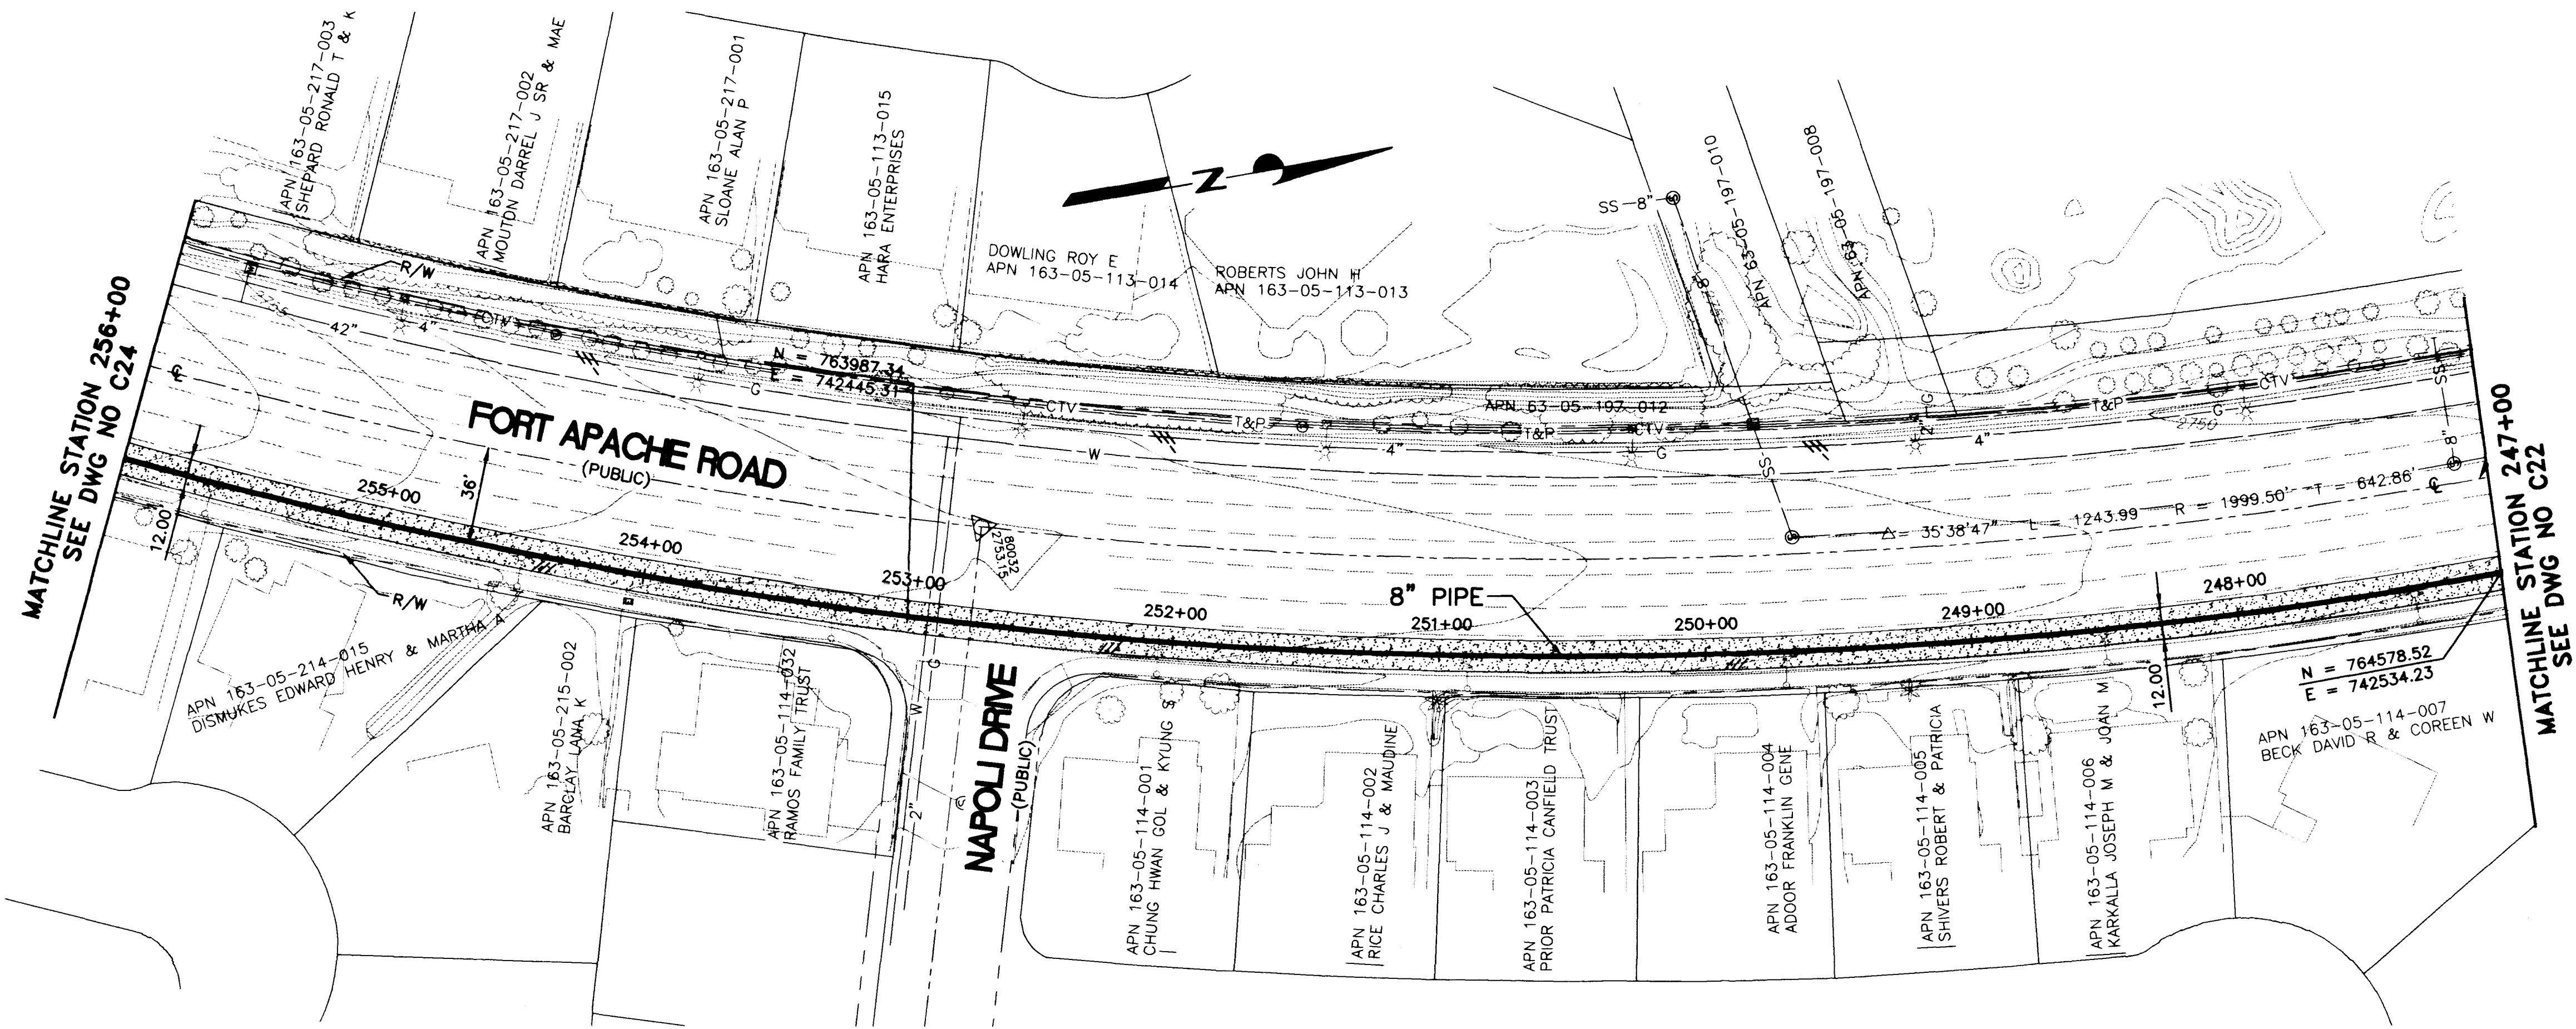

CONTRACT NUMBER 894	DATE 1/19/98
DRAWING NUMBER C23 SHEET 31 OF 51	REVISIONS 1. 1/19/98 2. 6/10/98
DRAWN BY: R. ATLEE CHECKED BY: M. PETERSON RECOMMENDED BY: [Signature] DATE: 8/14/98 R.P.E. NO. DATE ANDREW W. RICHARDSON 8573 8/26/98	

RECYCLED WATER DISTRIBUTION SYSTEM - RAMPART BLVD PIPELINE	SCALE HORIZ. SCALE 1" = 40' VERT. SCALE 1" = 4'
RECYCLED PIPELINE - PLAN AND PROFILE STA 247+00 TO STA 256+00	DATE 08/12/98 PLOT 16:58

VERIFY SCALE 1/2" 0 1/2"	BAR REPRESENTS ONE AND ONE-HALF INCHES ON ORIGINAL
-----------------------------	--

LAS VEGAS VALLEY WATER DISTRICT	GREELEY AND HANSEN ENGINEERS 4625 SOUTH POLARIS AVENUE, SUITE 210 LAS VEGAS, NEVADA 89103
---------------------------------	--

LAS VEGAS WILLYS WIDER STREET
 CUNNINGHAM AND HARRISON
 1000 WILLYS AVENUE, SUITE 210
 LAS VEGAS, NEVADA 89102

VERTICAL SCALE
 1" = 10' V.E.

RECYCLED WILLYS WIDER STREET - IMPROVE FOR TRAFFIC
 RECYCLED PAVEMENT - PLAN AND PROFILE
 STA 247+00 TO STA 258+00

894

1" = 10' H.E.
 1" = 10' V.E.

