



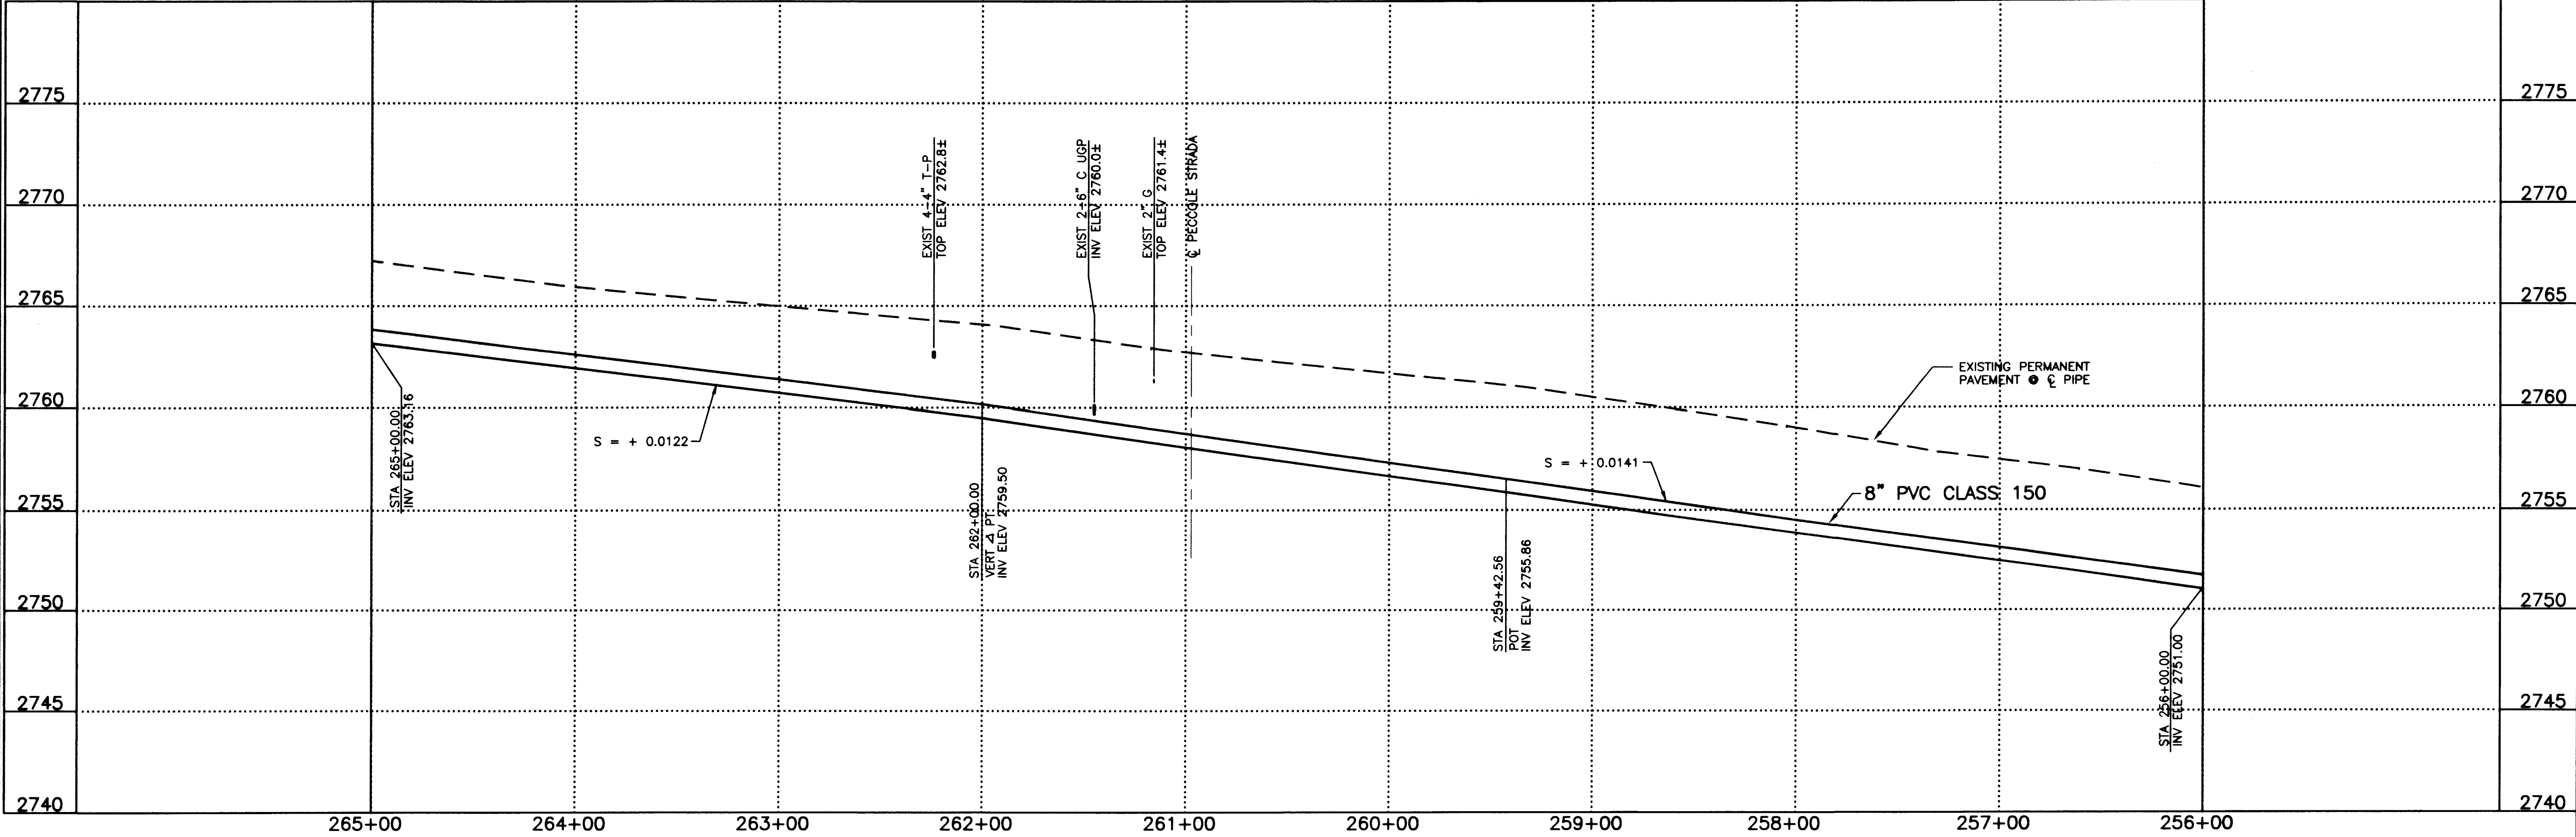

MATCHLINE STATION 265+00
SEE DWG NO C25

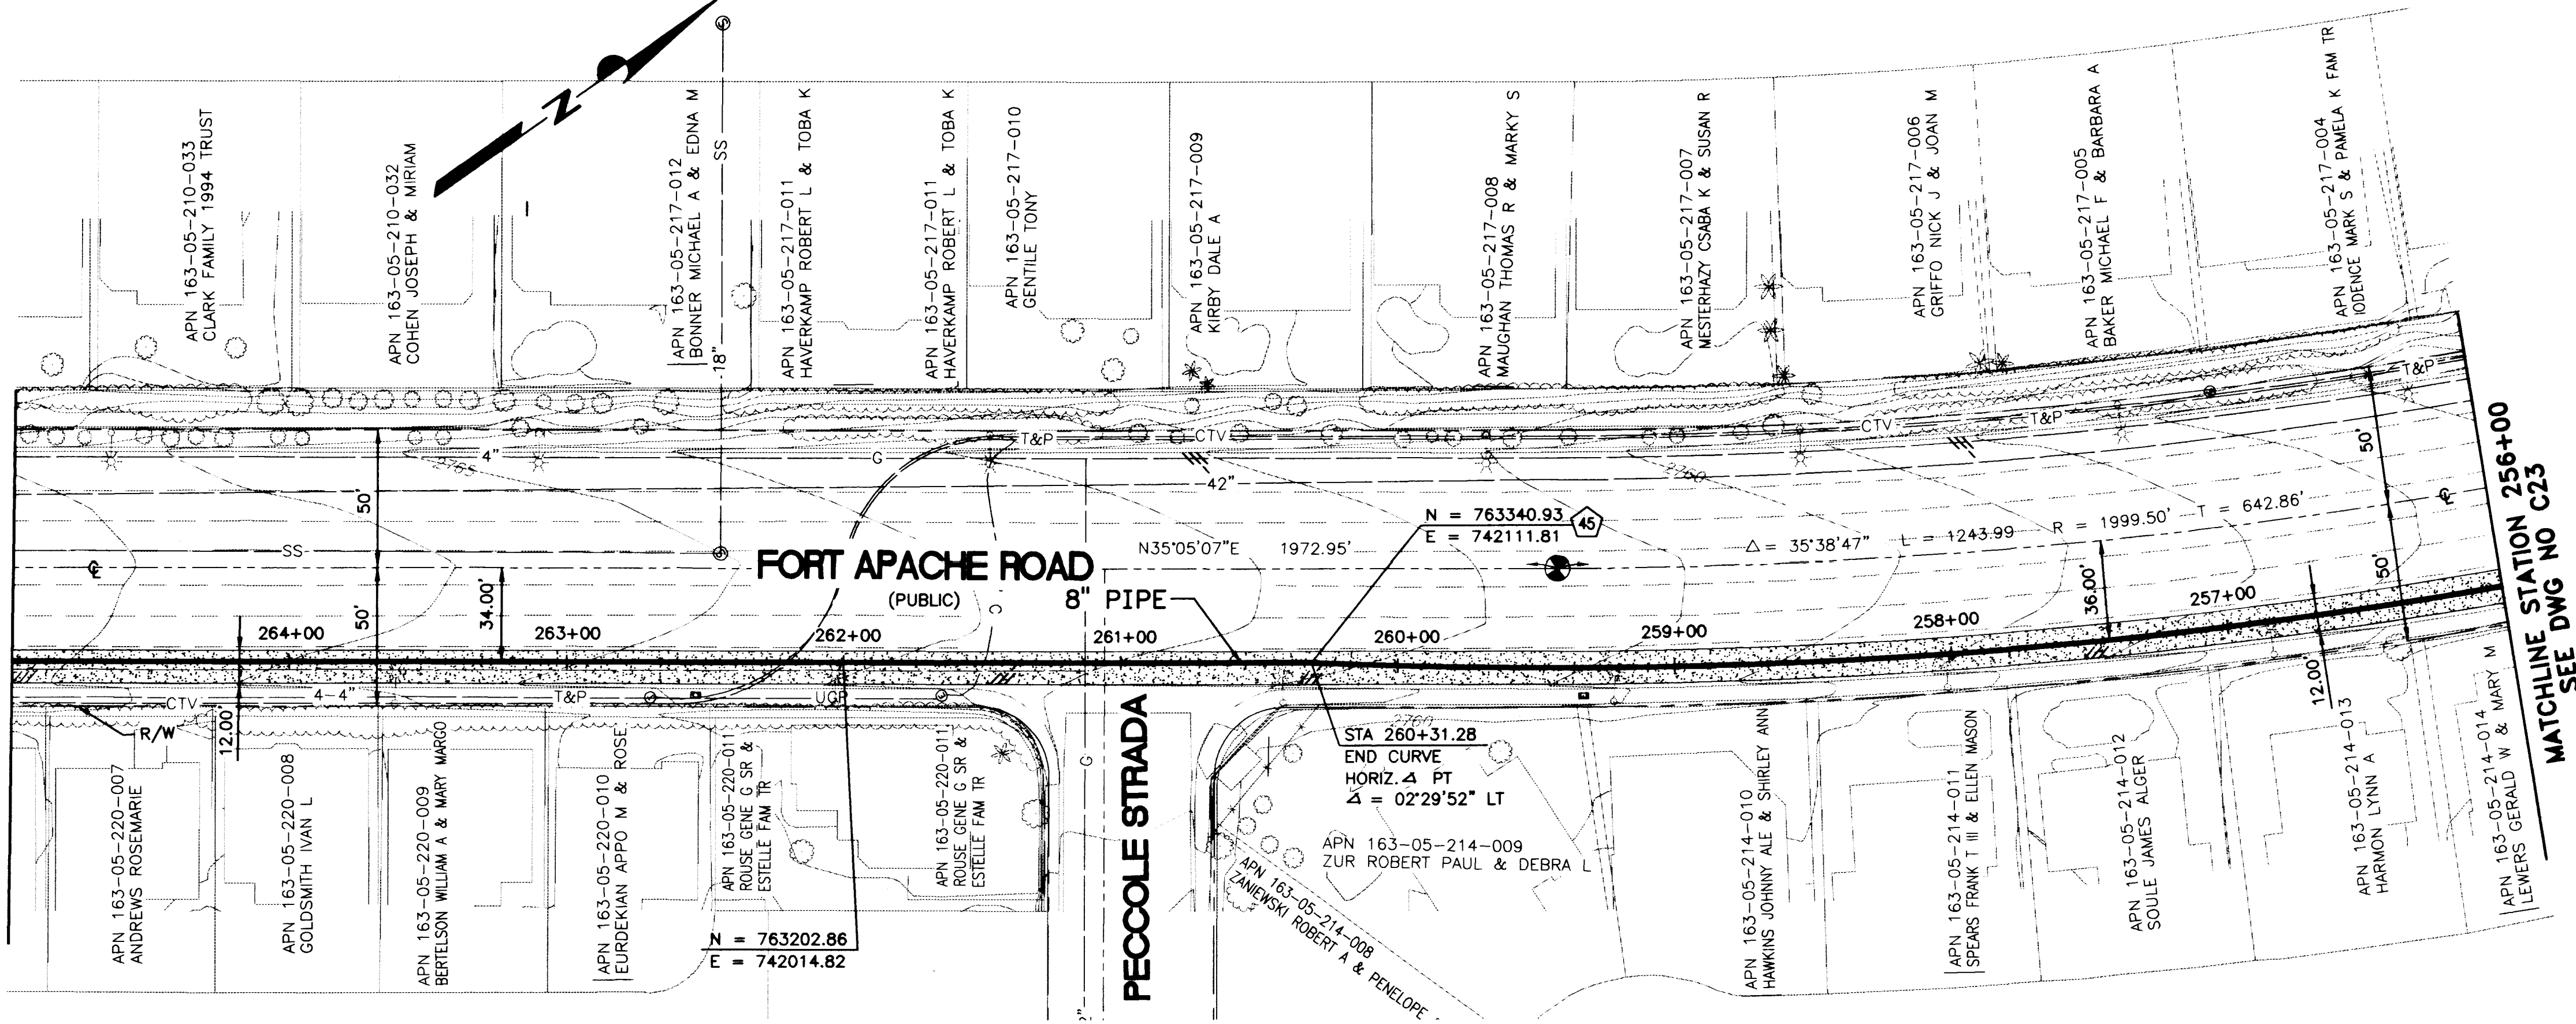

MATCHLINE STATION 256+00
SEE DWG NO C23

Call
before you
Dig
1-800-227-2600

CONTRACT NUMBER
894

DRAWING NUMBER C24
SHEET 32 OF 51

RECYCLED WATER DISTRIBUTION SYSTEM - RAMPART BLVD PIPELINE
RECYCLED PIPELINE - PLAN AND PROFILE
STA 256+00 TO STA 265+00

1/19/98
5/10/98
5/14/99
12702
R.P.E. NO. DATE
R.P.E. NO. DATE
R.P.E. NO. DATE


ANDREW W. RICHARDSON
No. 08577

VERIFY SCALE
1/2" = 0' 1/2"


SCALE
HORIZ. SCALE
VERT. SCALE
1" = 40'

894C24.DWG Plot 08/12/98 16:58

LAS VEGAS VALLEY WATER DISTRICT
GREELEY AND HANSEN
ENGINEERS
4625 SOUTH POLARIS AVENUE, SUITE 210
LAS VEGAS, NEVADA 89103

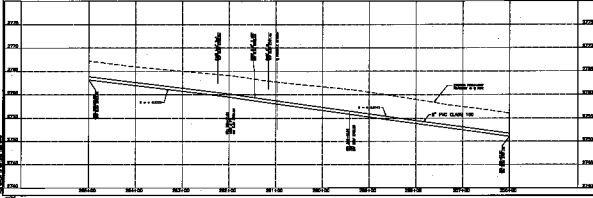

RECYCLED WYLLINE - PLAN AND PROFILE
STA 206+00 TO STA 207+00

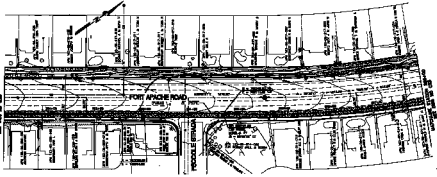

10' P.C. CLARK 100
10' P.C. CLARK 100
10' P.C. CLARK 100

84



RECYCLED WYLLINE - PLAN AND PROFILE
STA 206+00 TO STA 207+00

RECYCLED WYLLINE - PLAN AND PROFILE
STA 206+00 TO STA 207+00

RECYCLED WYLLINE - PLAN AND PROFILE
STA 206+00 TO STA 207+00

LA JOLLA VALLEY WATER DISTRICT
CRESLEY AND HARBEN
ENGINEERS
4000 SIXTH AVENUE, SUITE 200
LA JOLLA, CALIFORNIA 92037