


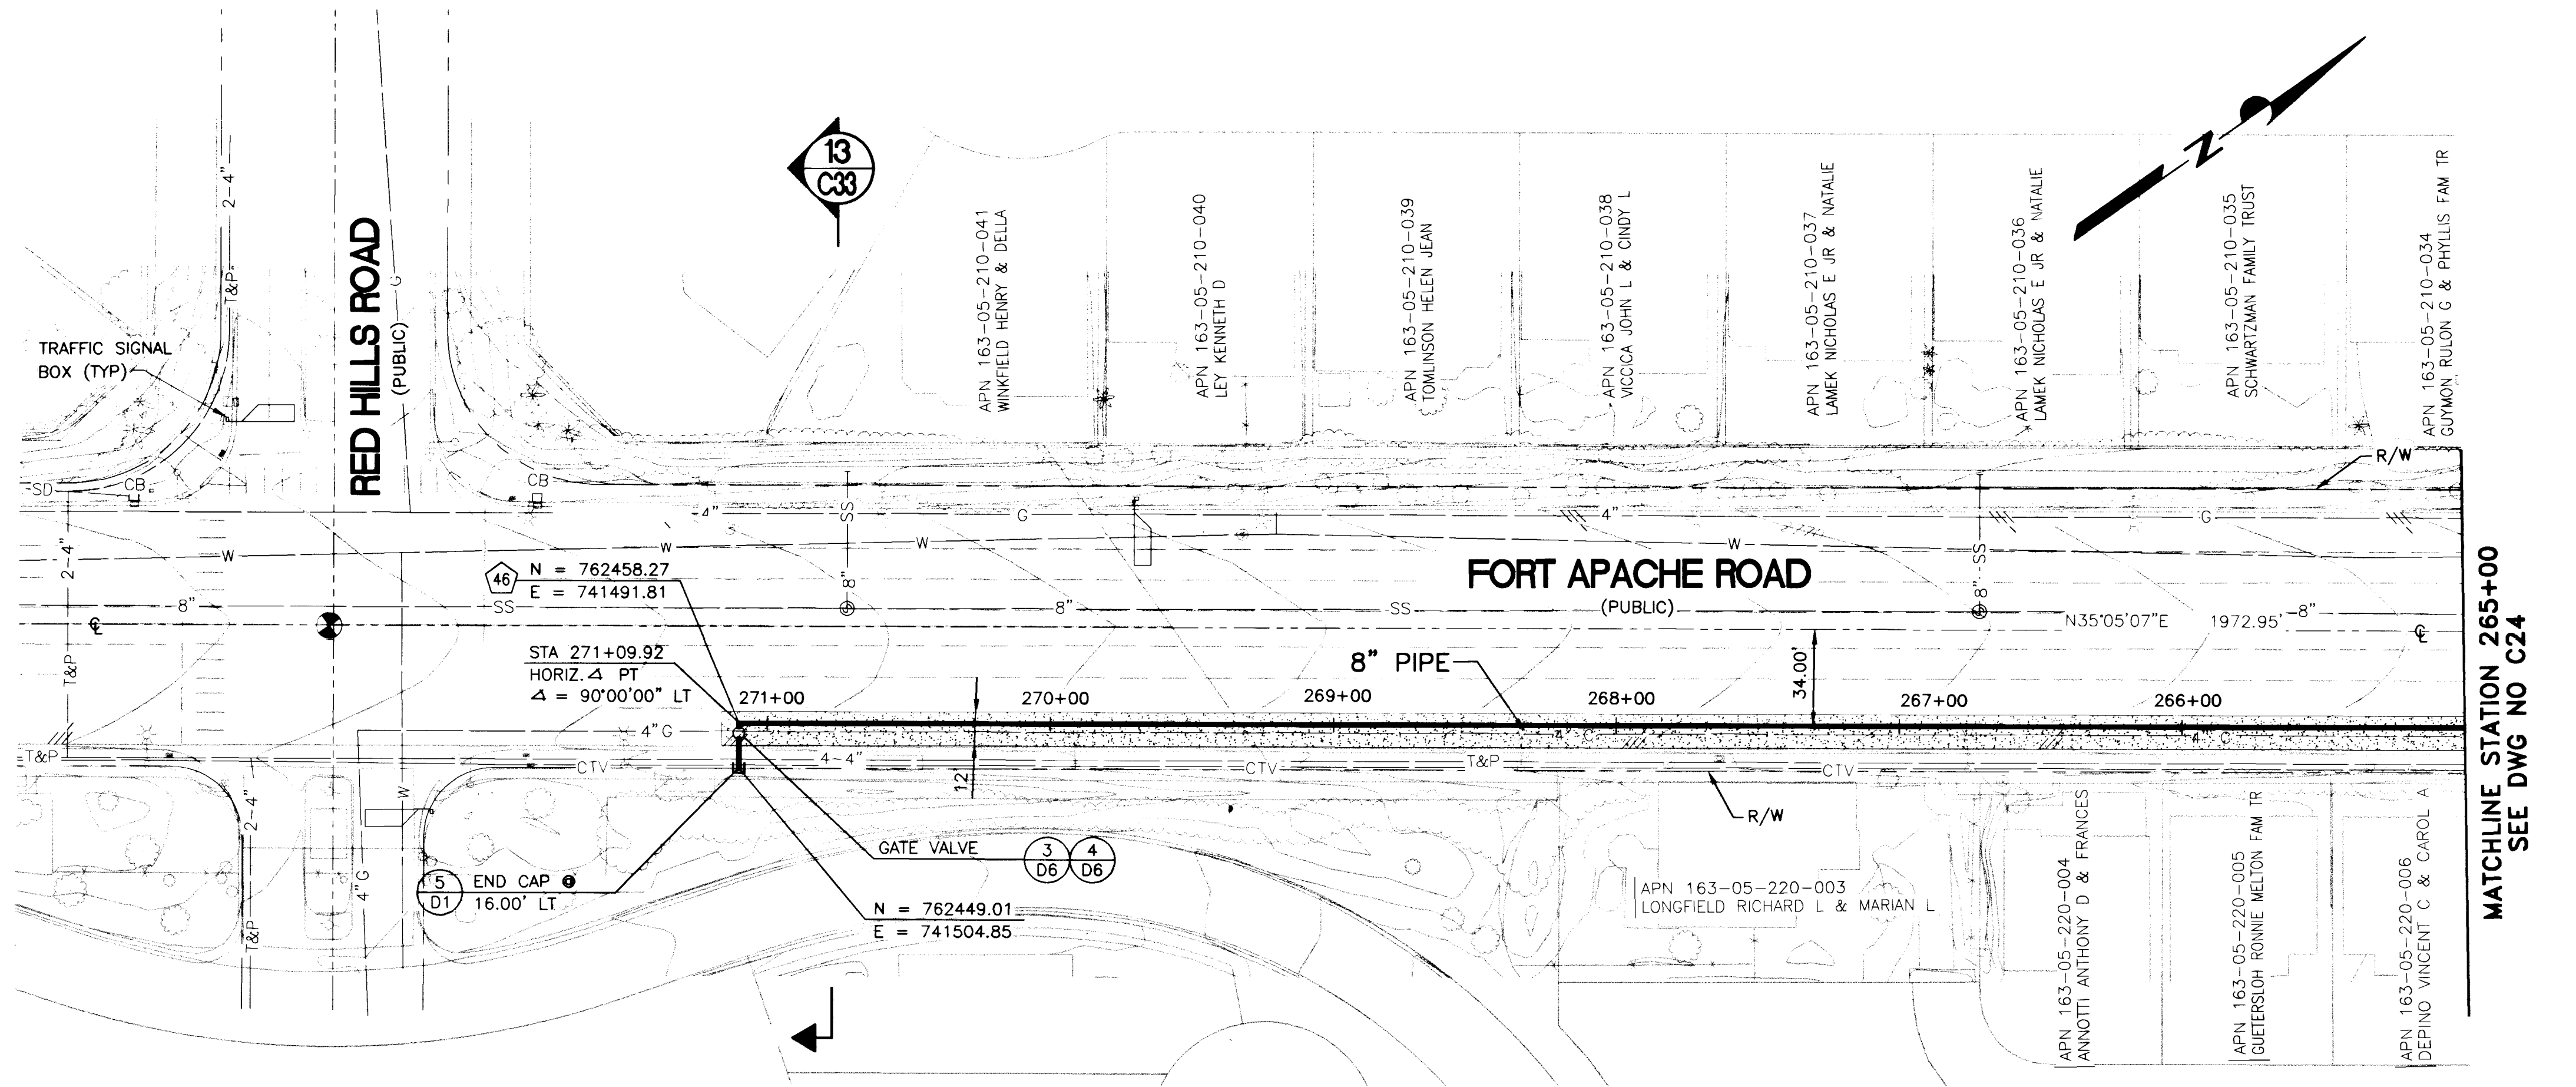


CAUTION:
EXISTING 4" PE GAS MAIN PARALLEL TO PROPOSED 8" RECYCLED WATER PIPELINE FROM PECCOLE STRADA TO RED HILLS ROAD. CONTRACTOR SHALL TAKE ALL DUE PRECAUTION TO PROTECT GAS MAIN DURING EXCAVATION. SOUTHWEST GAS INSPECTOR SHALL BE ON SITE DURING EXCAVATION. NOTIFY BOB MIDDAG, SOUTHWEST GAS ENGINEERING (365-2071) 48 HOURS IN ADVANCE TO SCHEDULE INSPECTOR.


SIGNALIZED INTERSECTIONS (TURN SIGNALS)
TO REMAIN OPERATIONAL THROUGH ALL
PHASES OF CONSTRUCTION


Avoid cutting underground
utility lines. It's costly.

**Call
before
you
Dig**

1-800-227-2600

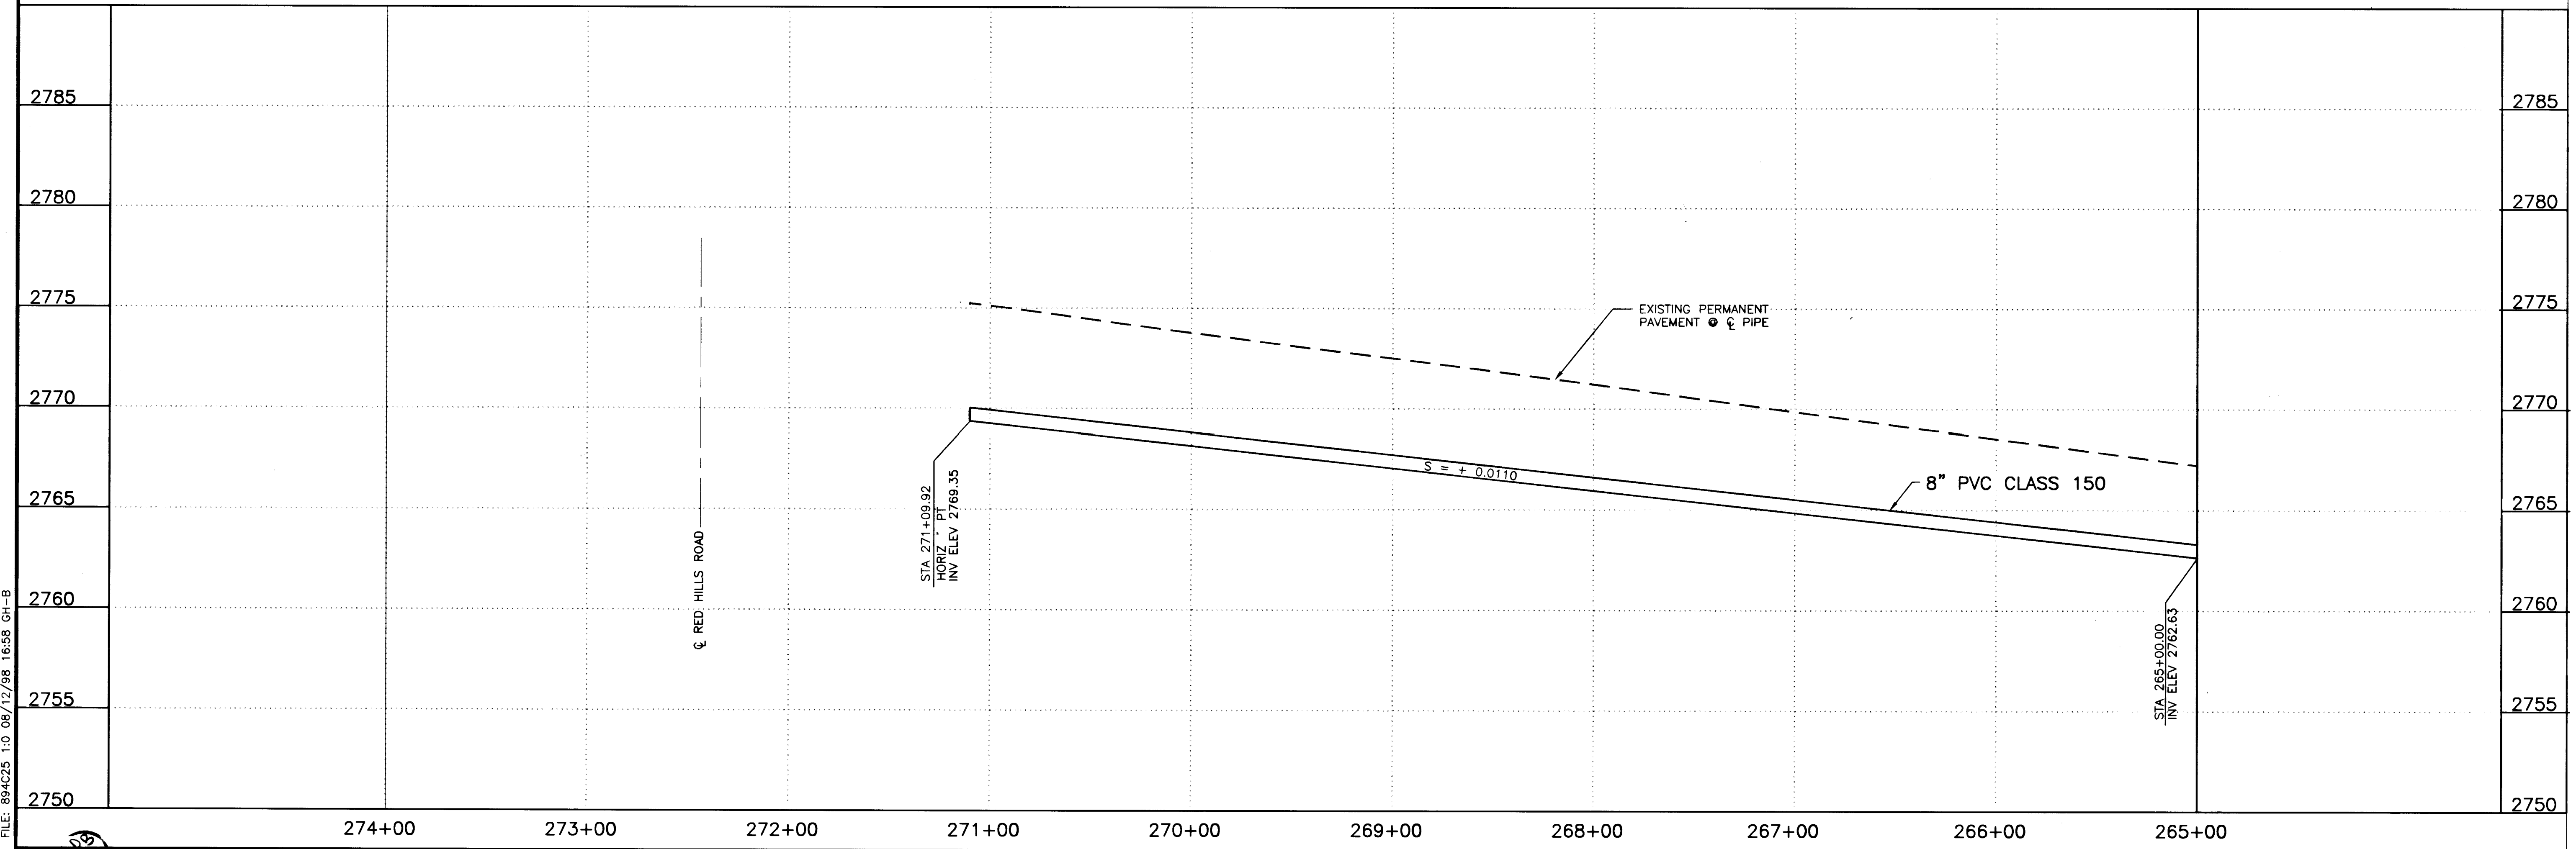

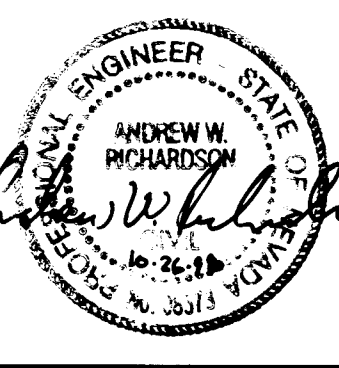
LAS VEGAS VALLEY WATER DISTRICT	
GREELEY AND HANSEN ENGINEERS 4625 SOUTH POLARIS AVENUE, SUITE 210 LAS VEGAS, NEVADA 89103	
VERIFY SCALE 1/2" = 0' 1/2"	BAR REPRESENTS ONE AND ONE-HALF INCHES ON ORIGINAL
RECYCLED WATER DISTRIBUTION SYSTEM - RAMPART BLVD PIPELINE	
RECYCLED PIPELINE - PLAN AND PROFILE STA 265+00 TO STA 271+09.92	
SCALE HORIZ. SCALE 1" = 40'	VERT. SCALE 1" = 4'
894C25.DWG	Plot 10/26/98 11:28
DRAWN BY: R. ATLEE 1/19/98	CHECKED BY: M. PETERSON 6/10/98
RECOMMENDED BY: RAM G. JANKA 12/02 R.P.E. NO. DATE	ACCEPTED BY: <i>Andrew W. Richardson</i> 10-26-98 R.P.E. NO. DATE
	
CONTRACT NUMBER 894	
DRAWING NUMBER C25 SHEET 33 OF 51	

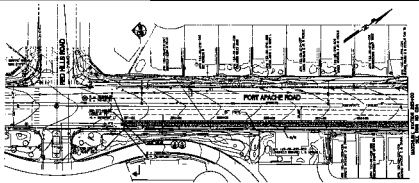

CAUTION:
 EXISTING 4" PC WAS FRAMED TO PROPOSED 8" RECYCLED WATER PIPELINE FROM PEDESTAL STRAIN
 TO RED HILLS ROAD. CONTRACTOR SHALL USE ALL DUE PRECAUTION TO PROTECT GAS MAIN DURING
 EXCAVATION. SOUTHWEST GAS INSPECTOR SHALL BE ON ANY EXCAVATION. NOTIFY WEST WYOMING
 SOUTHWEST GAS ENGINEERING (360-2671) 48 HOURS IN ADVANCE TO SCHEDULE INSPECTION.

SEPARATE INTERSECTIONS (SHOWN SEPARATELY)
 TO REMAIN OPERATIONAL THROUGH ALL
 PHASES OF CONSTRUCTION

NO STOPPING
 Cal
 before you
 D.C.
 1-800-852-8888

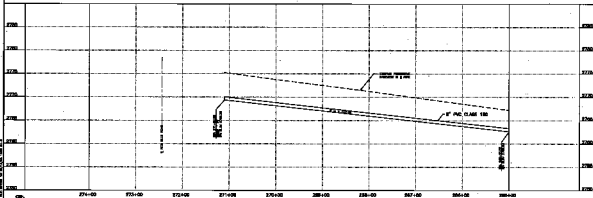

LAS VEGAS VALLEY WATER DISTRICT
 ORRISLEY AND HAMMEN
 ENGINEERS
 4440 SOUTH POLARIS AVENUE, SUITE 200
 LAS VEGAS, NEVADA 89121

VERTICAL SCALE
 1" = 4' V
 1" = 40' H

RECYCLED WATER PIPELINE SYSTEM - SOUTHWEST GAS PROFILE
 RECYCLED WATER PIPELINE - PLAN AND PROFILE
 STA 268+00 TO STA 271+00.32

894

1-800-852-8888