



FILE: 894C28 1:0 08/12/98 16:50 CH-B

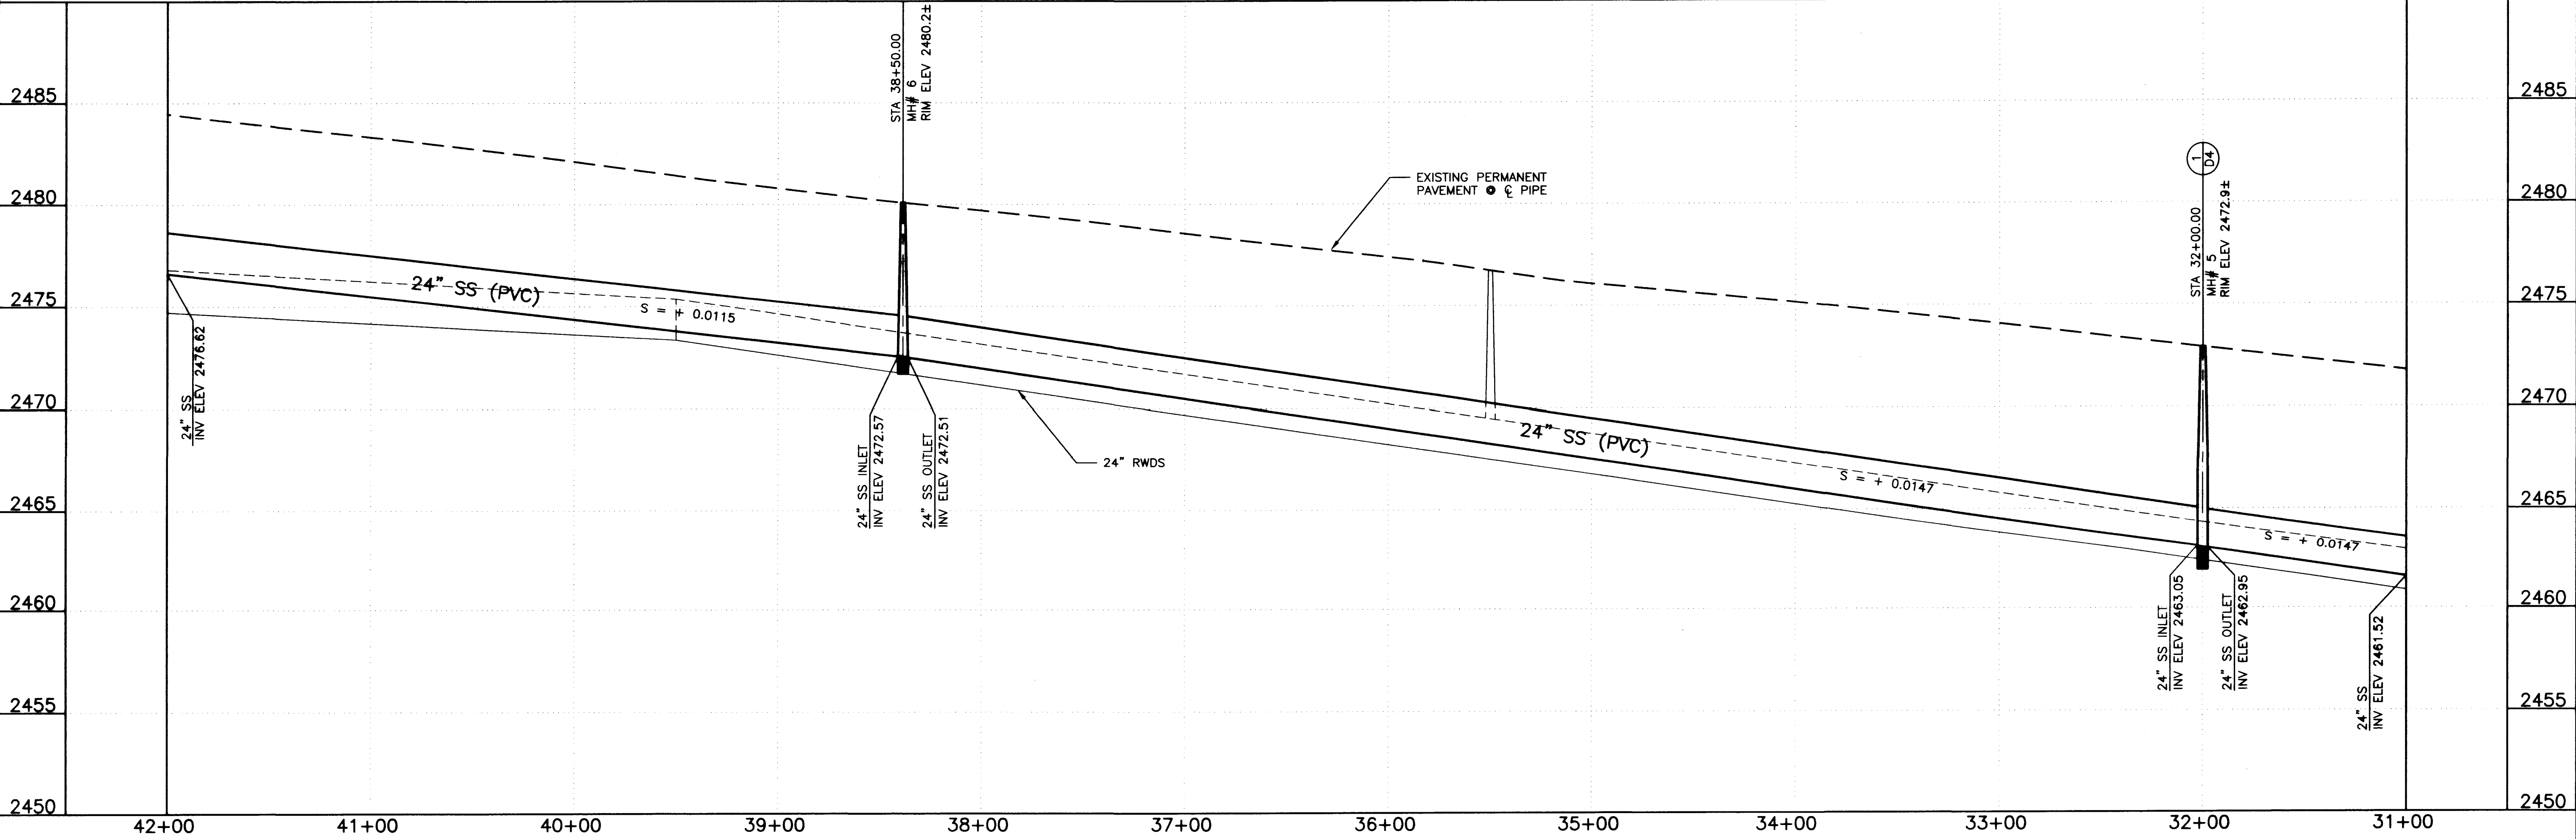

Call
before you
Dig
1-800-227-2600

MATCHLINE STATION 42+00
SEE DWG NO C29

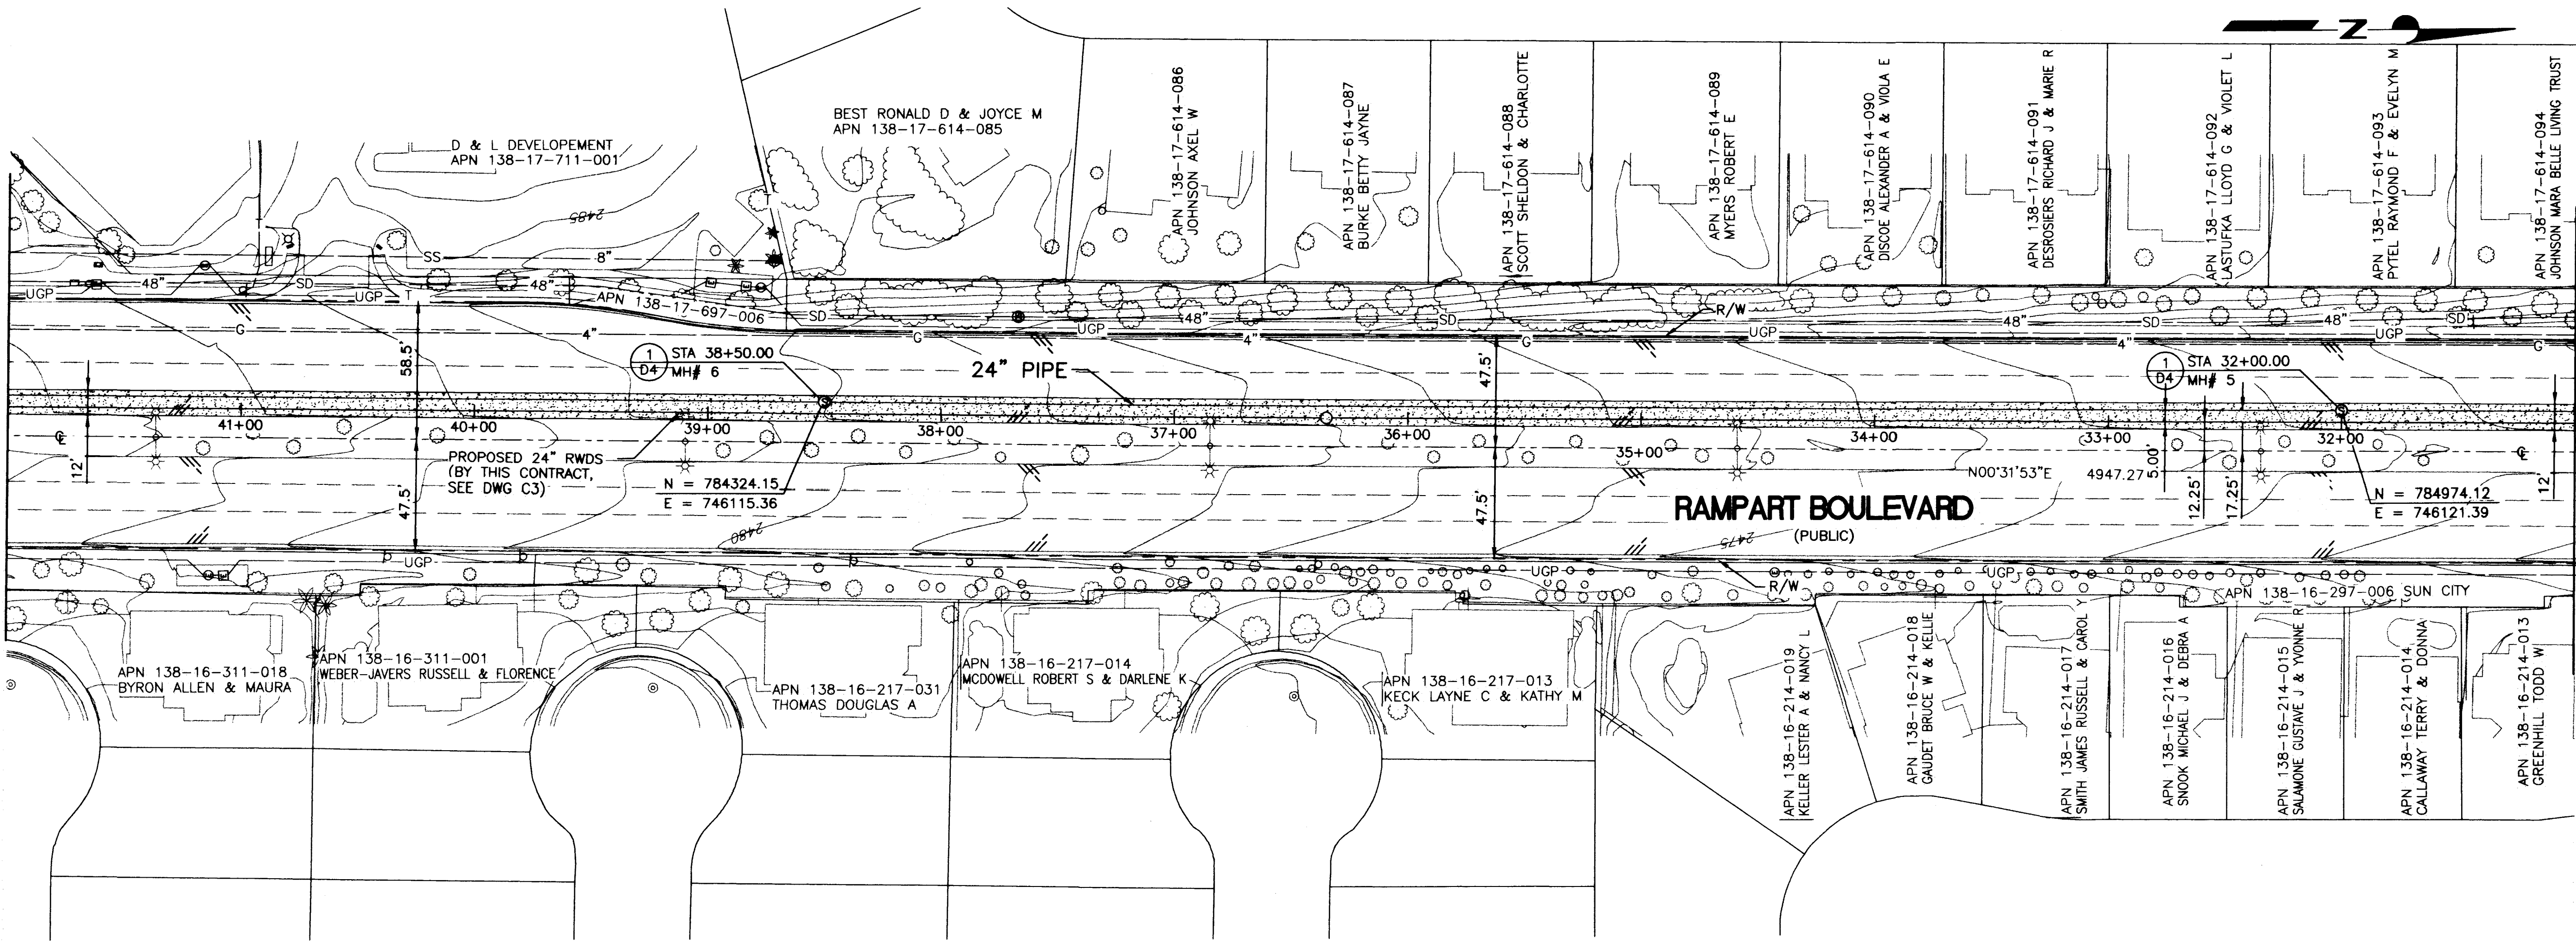


MATCHLINE STATION 31+00
SEE DWG NO C27

CONTRACT NUMBER	894
DRAWING NUMBER	C28
SHEET	36 OF 51
DATE	6/22/98
DESIGNED BY	ANDREW W. RICHARDSON
CHECKED BY	M. PETERSON
RECOMMENDED BY	RAM G. JANCA
DATE	12/02
R.P.E. NO.	8573
R.P.E. NO. DATE	8573 6/22/98

RECYCLED WATER DISTRIBUTION SYSTEM - RAMPART BLVD PIPELINE	INFLUENT SEWER - PLAN AND PROFILE
STA 31+00 TO STA 42+00	STA 31+00 TO STA 42+00
DATE	10/20/98
PLAT	894C28 DWG
SCALE	1" = 40'
VERT. SCALE	1" = 4'
HORIZ. SCALE	1" = 40'


VERIFY SCALE	1" = 40'
BAR REPRESENTS	ONE AND ONE-HALF INCHES ON ORIGINAL

LAS VEGAS VALLEY WATER DISTRICT	GREELEY AND HANSEN
ENGINEERS	4625 SOUTH POLARIS AVENUE, SUITE 210
	LAS VEGAS, NEVADA 89103

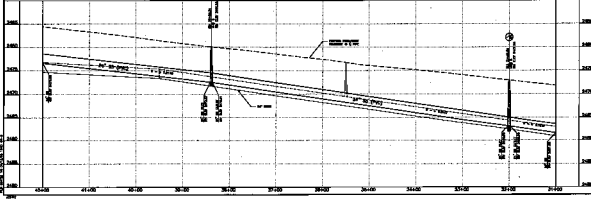

before
Cal
D
D
1-28-88

SECTION 10+00 TO 10+50

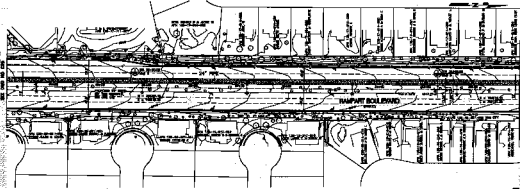

SECTION 10+50 TO 11+00

884

EXISTING SEWER DRAINAGE SYSTEM - IMPROVE AND REPAIR
 IMPROVE SEWER - PLAN AND PROFILE
 STA 31+00 TO STA 43+00
 1" = 40' HORIZ
 1" = 10' VERT

LAMAR VALLEY WATER DISTRICT
 CHANDLER AND HANSEN
 ENGINEERS
 4400 SOUTH WILLOW AVENUE, SUITE 204
 LAMAR, TEXAS 77601