



FILE: 894C29 1:0 08/12/98 17:00 GH-B

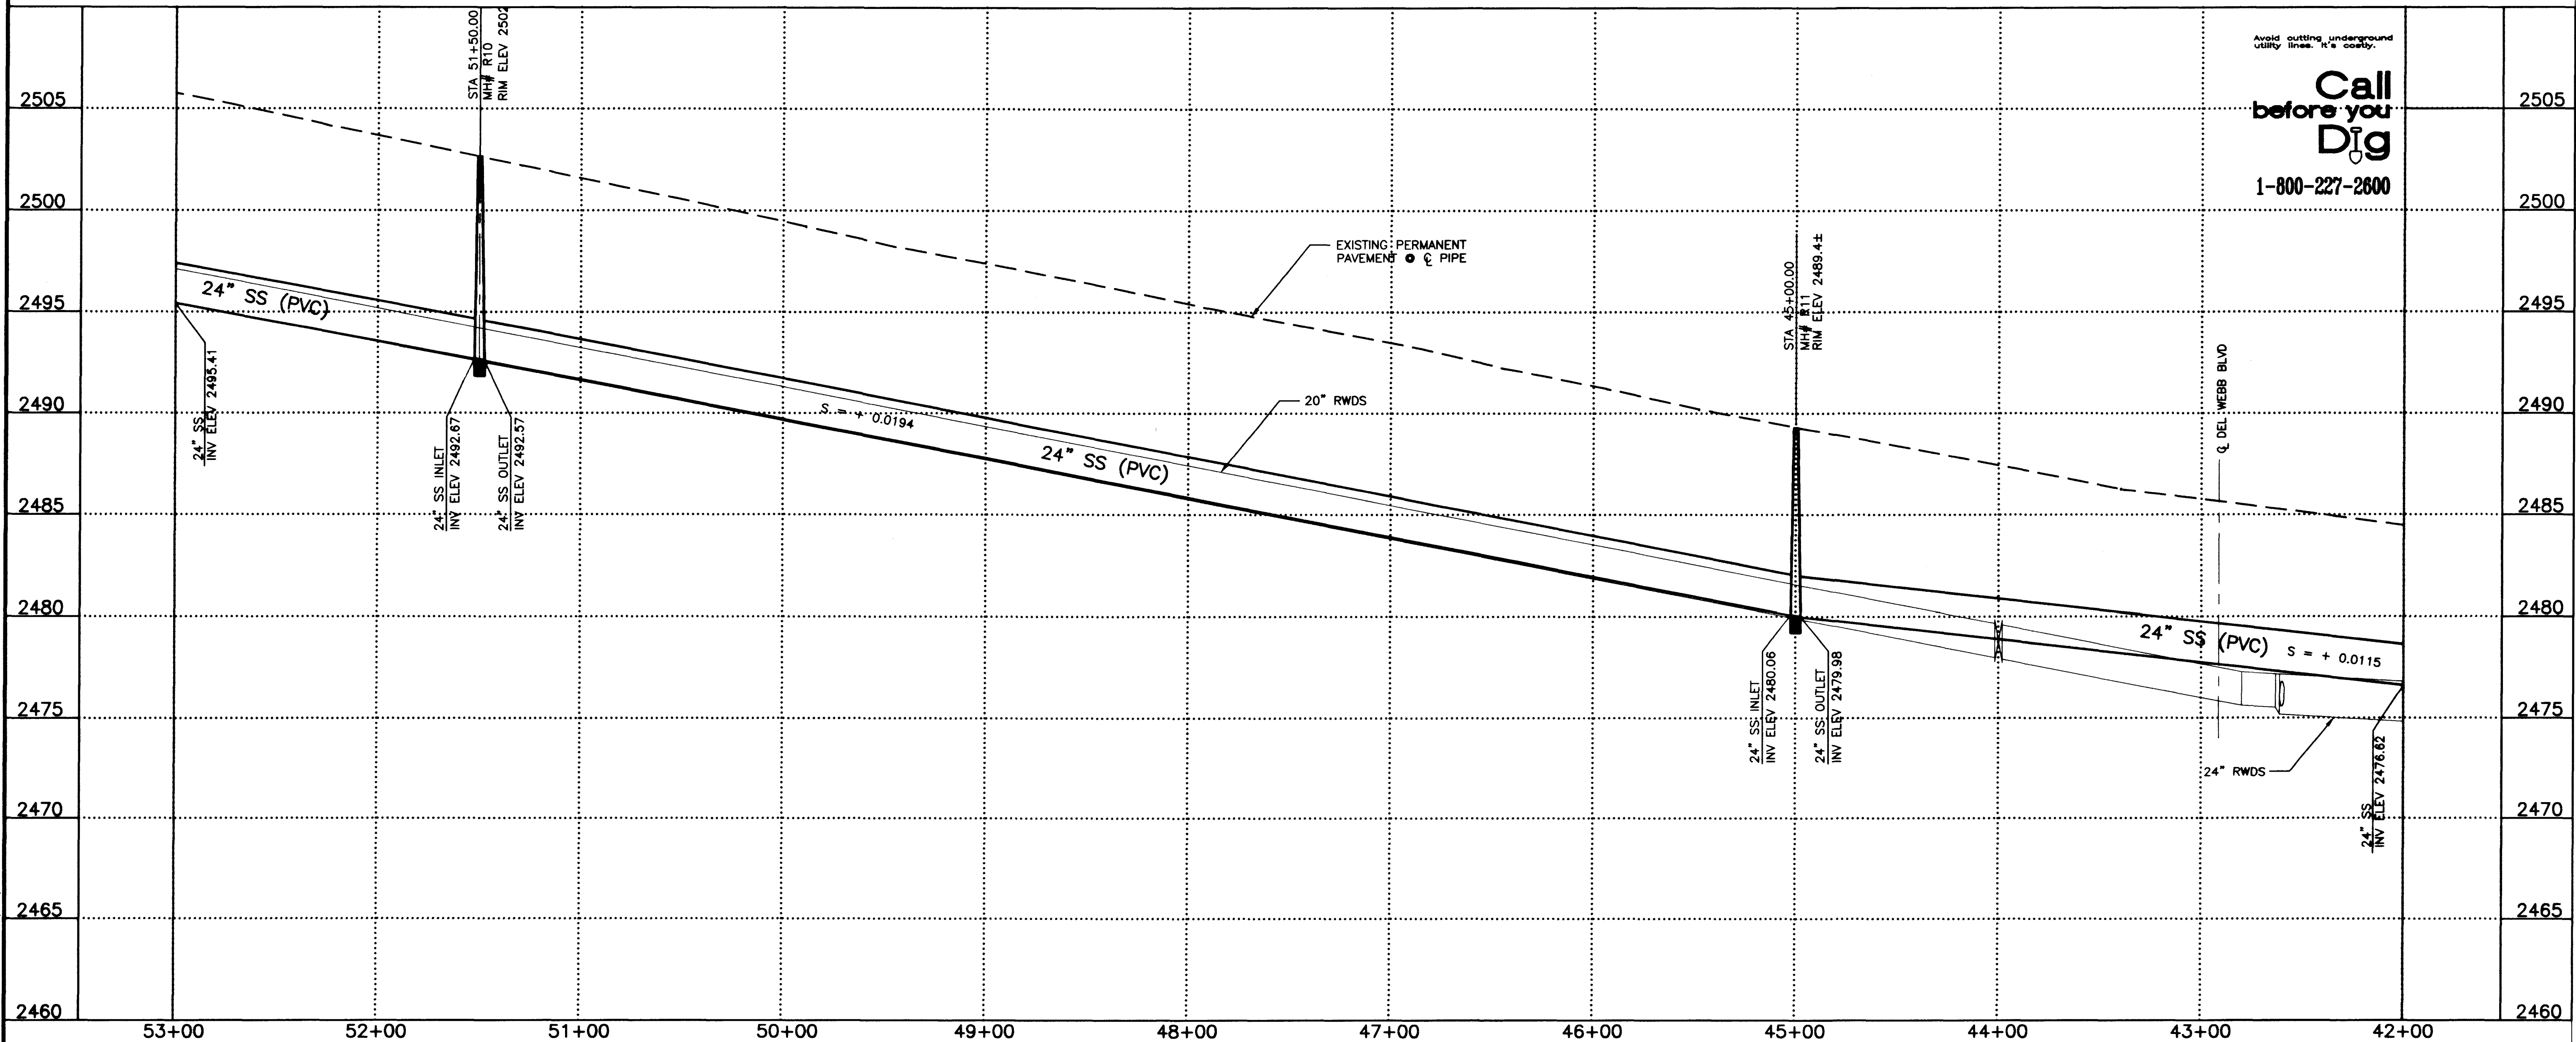


MATCHLINE STATION 53+00
SEE DWG NO C30

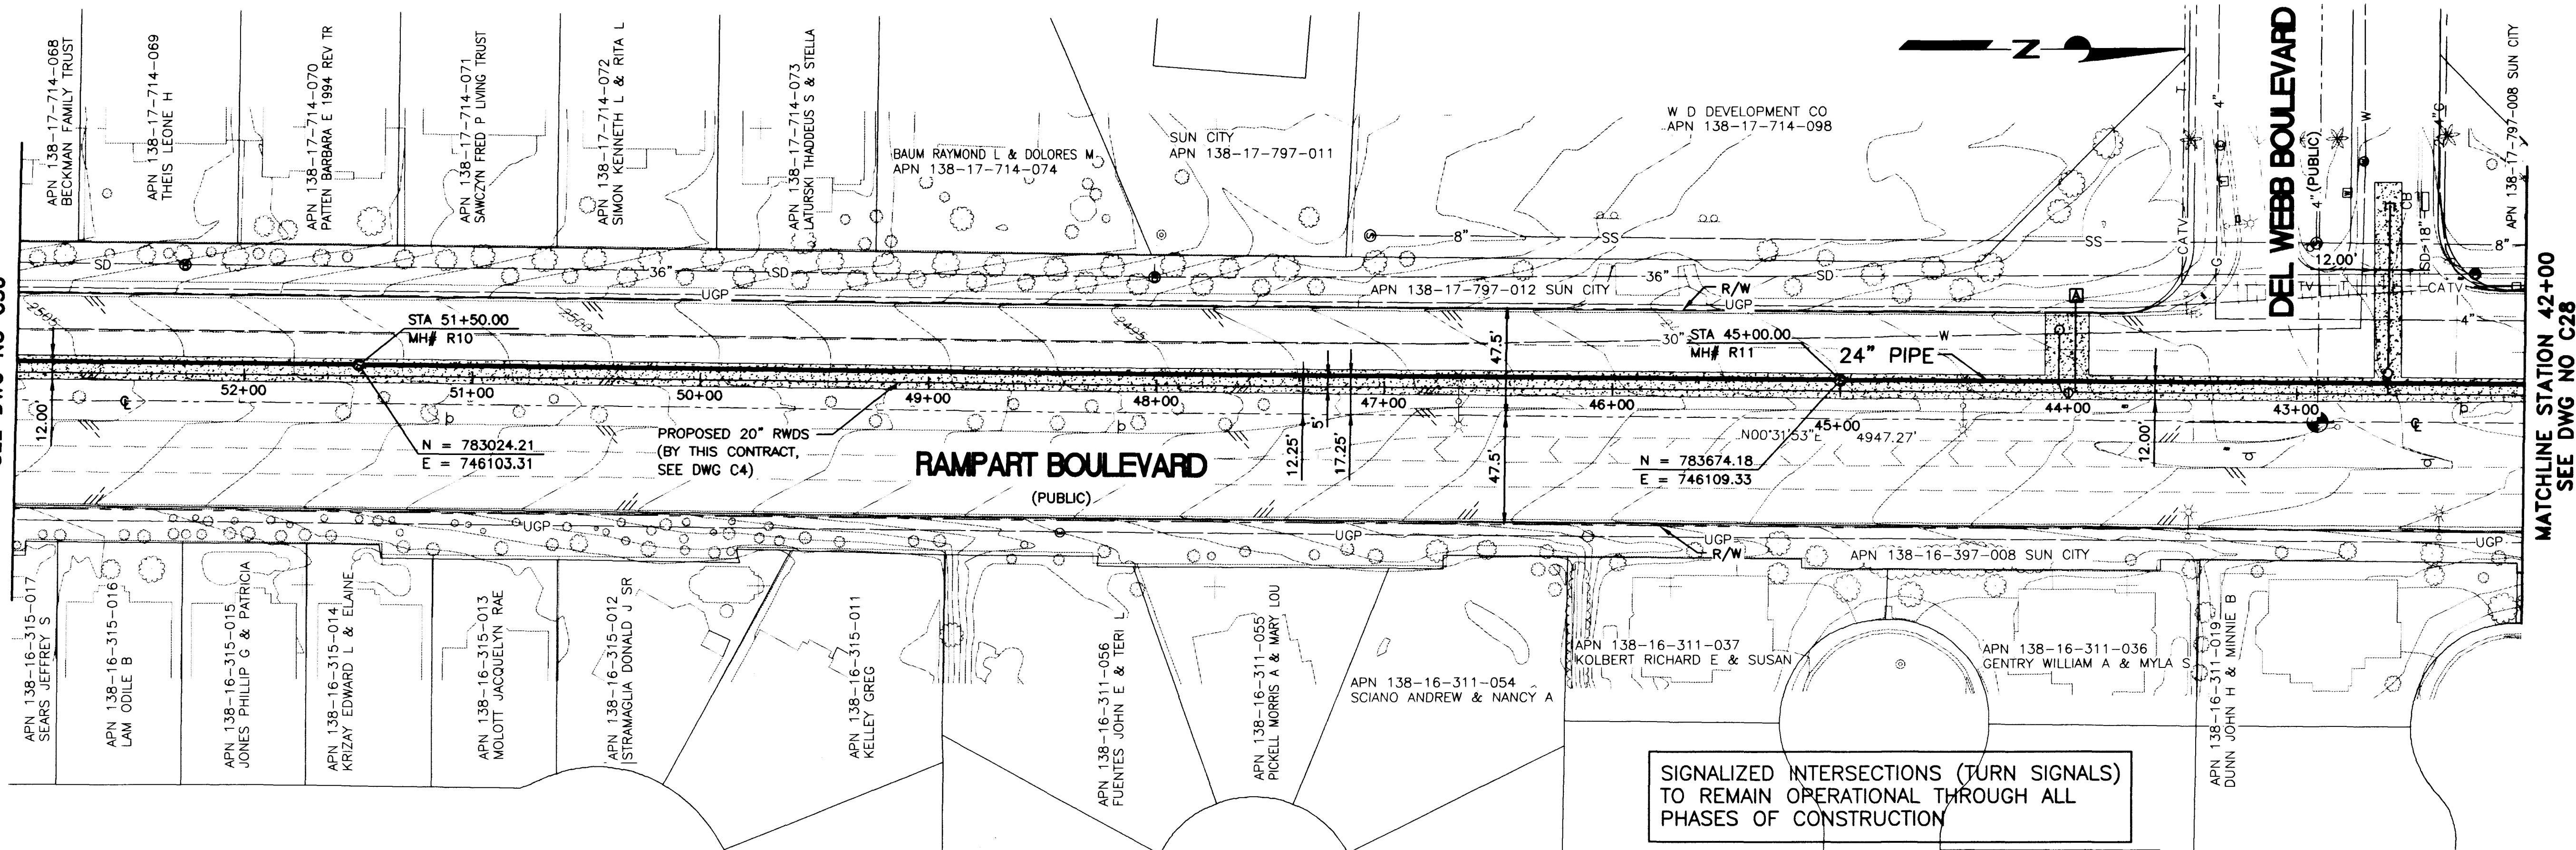


MATCHLINE STATION 42+00
SEE DWG NO C28

LAS VEGAS VALLEY WATER DISTRICT		GREELEY AND HANSEN ENGINEERS 4625 SOUTH POLARIS AVENUE, SUITE 210 LAS VEGAS, NEVADA 89103	
VERIFY SCALE 1/2" = 0' 1/2"		BAR REPRESENTS ONE AND ONE-HALF INCHES ON ORIGINAL	
RECYCLED WATER DISTRIBUTION SYSTEM - RAMPART BLVD PIPELINE		INFLUENT SEWER - PLAN AND PROFILE STA 42+00 TO STA 53+00	
DRAWN BY: R. ATLEE CHECKED BY: M. PETERSON RECOMMENDED BY: R. J. JANG ACCEPTED BY: ANDREW W. RICHARDSON		DATE: 1/19/98 DATE: 6/10/98 DATE: 8/24/98 DATE: 8/24/98	
CONTRACT NUMBER 894		DRAWING NUMBER C29 SHEET 37 OF 51	

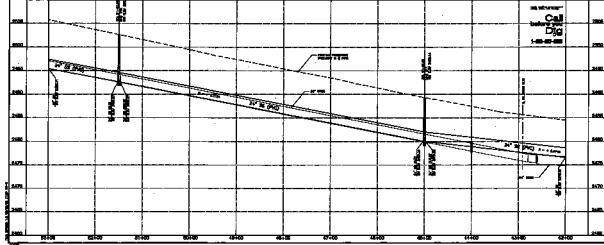

SEWERAGE SYSTEMS (SANITARY)
TO BE CONSTRUCTED, INCLUDE ALL
PHASES OF CONSTRUCTION

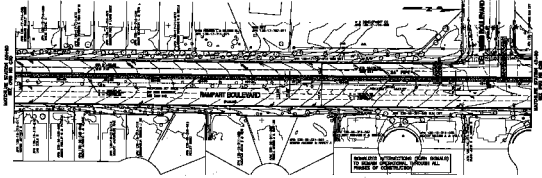

	894	PROJECT NO. 100-00-000 SHEET NO. 100-00-000	INFLUENT SEWER - PLAN AND PROFILE STA 43+00 TO STA 53+00	VERTICAL SCALE 1" = 10'	LAS VEGAS VALLEY ROAD DISTRICT ORRISLEY AND HANSEN 4000 SOUTH PLEASANT AVENUE, SUITE 210 LAS VEGAS, NEVADA 89102
	100-00-000	100-00-000	100-00-000	100-00-000	100-00-000