

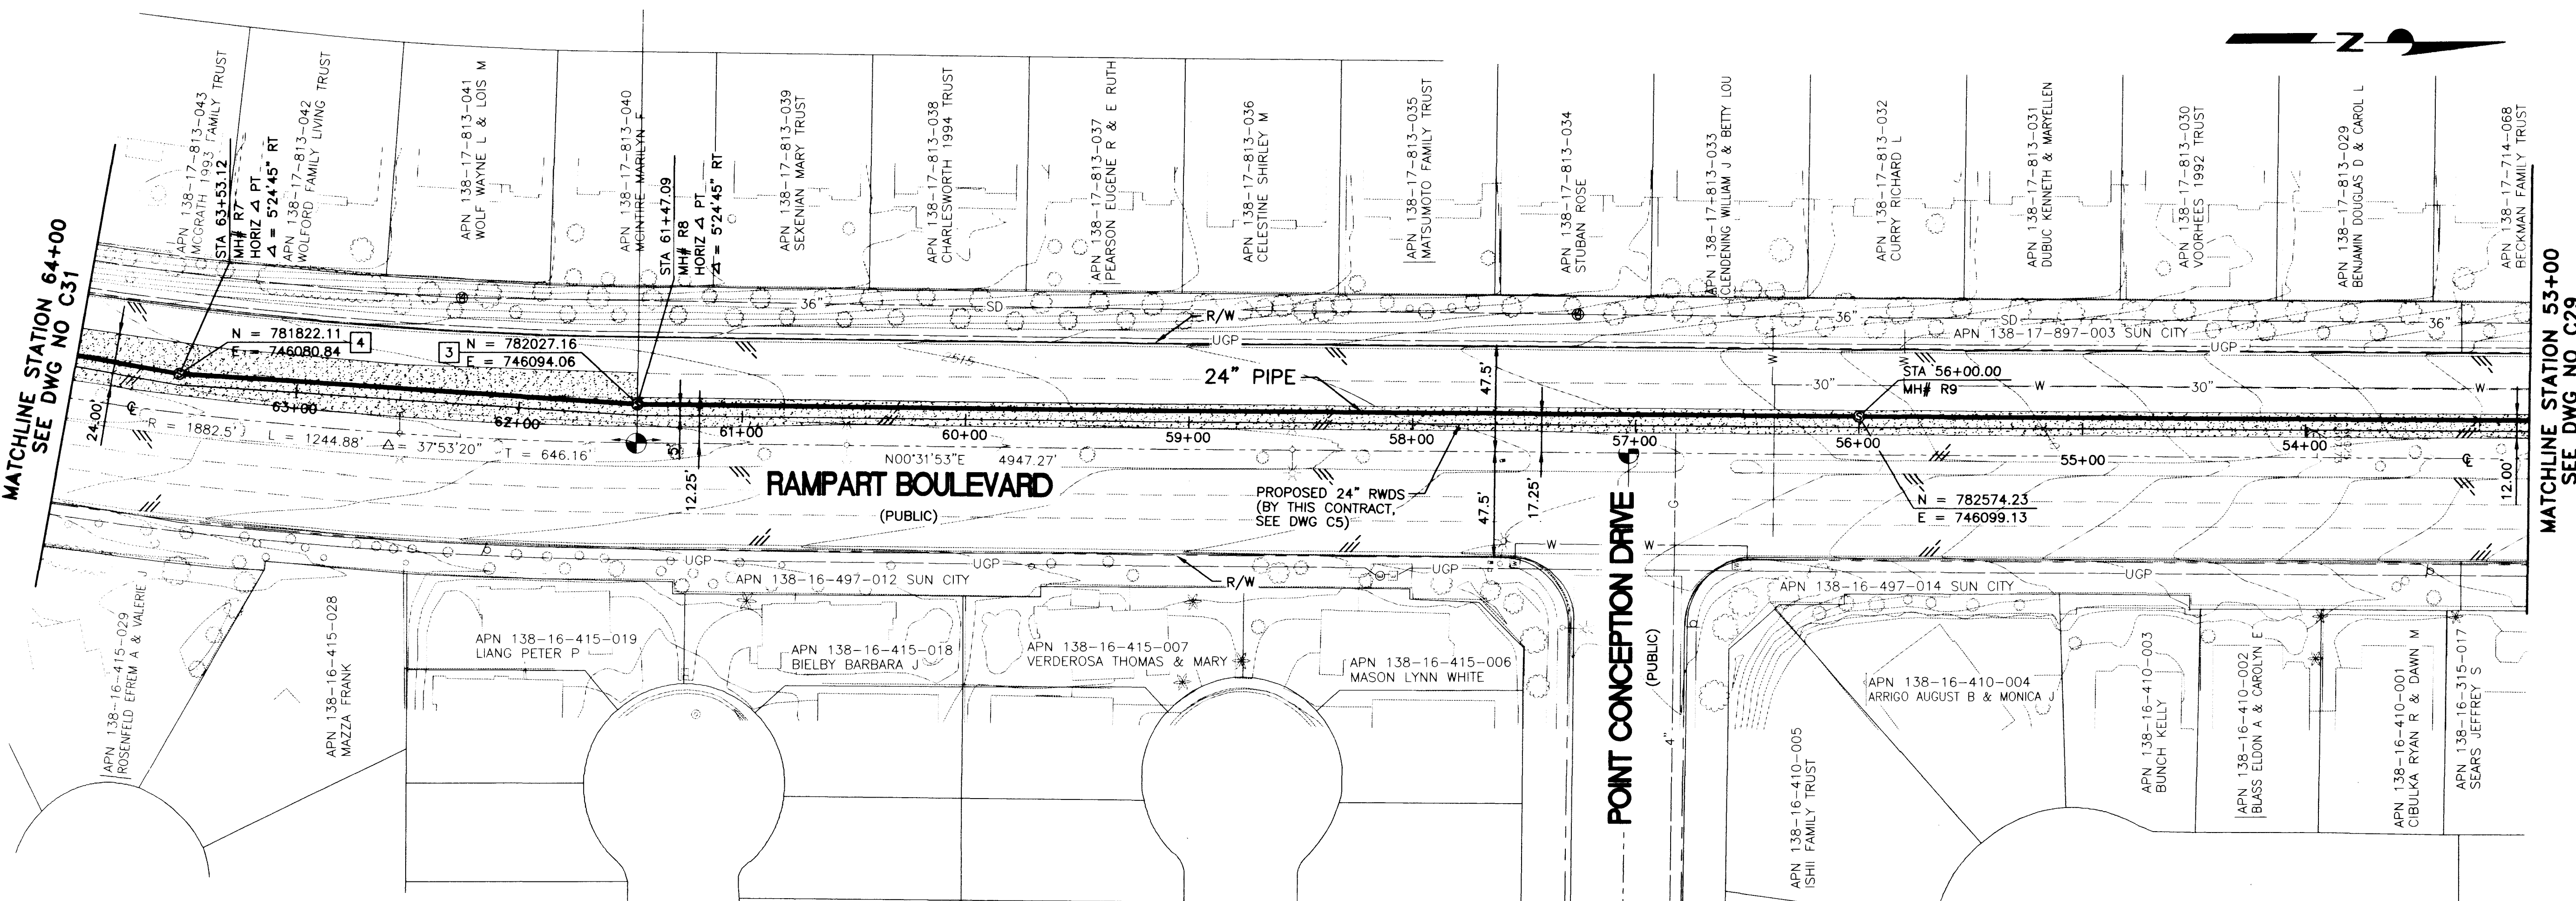
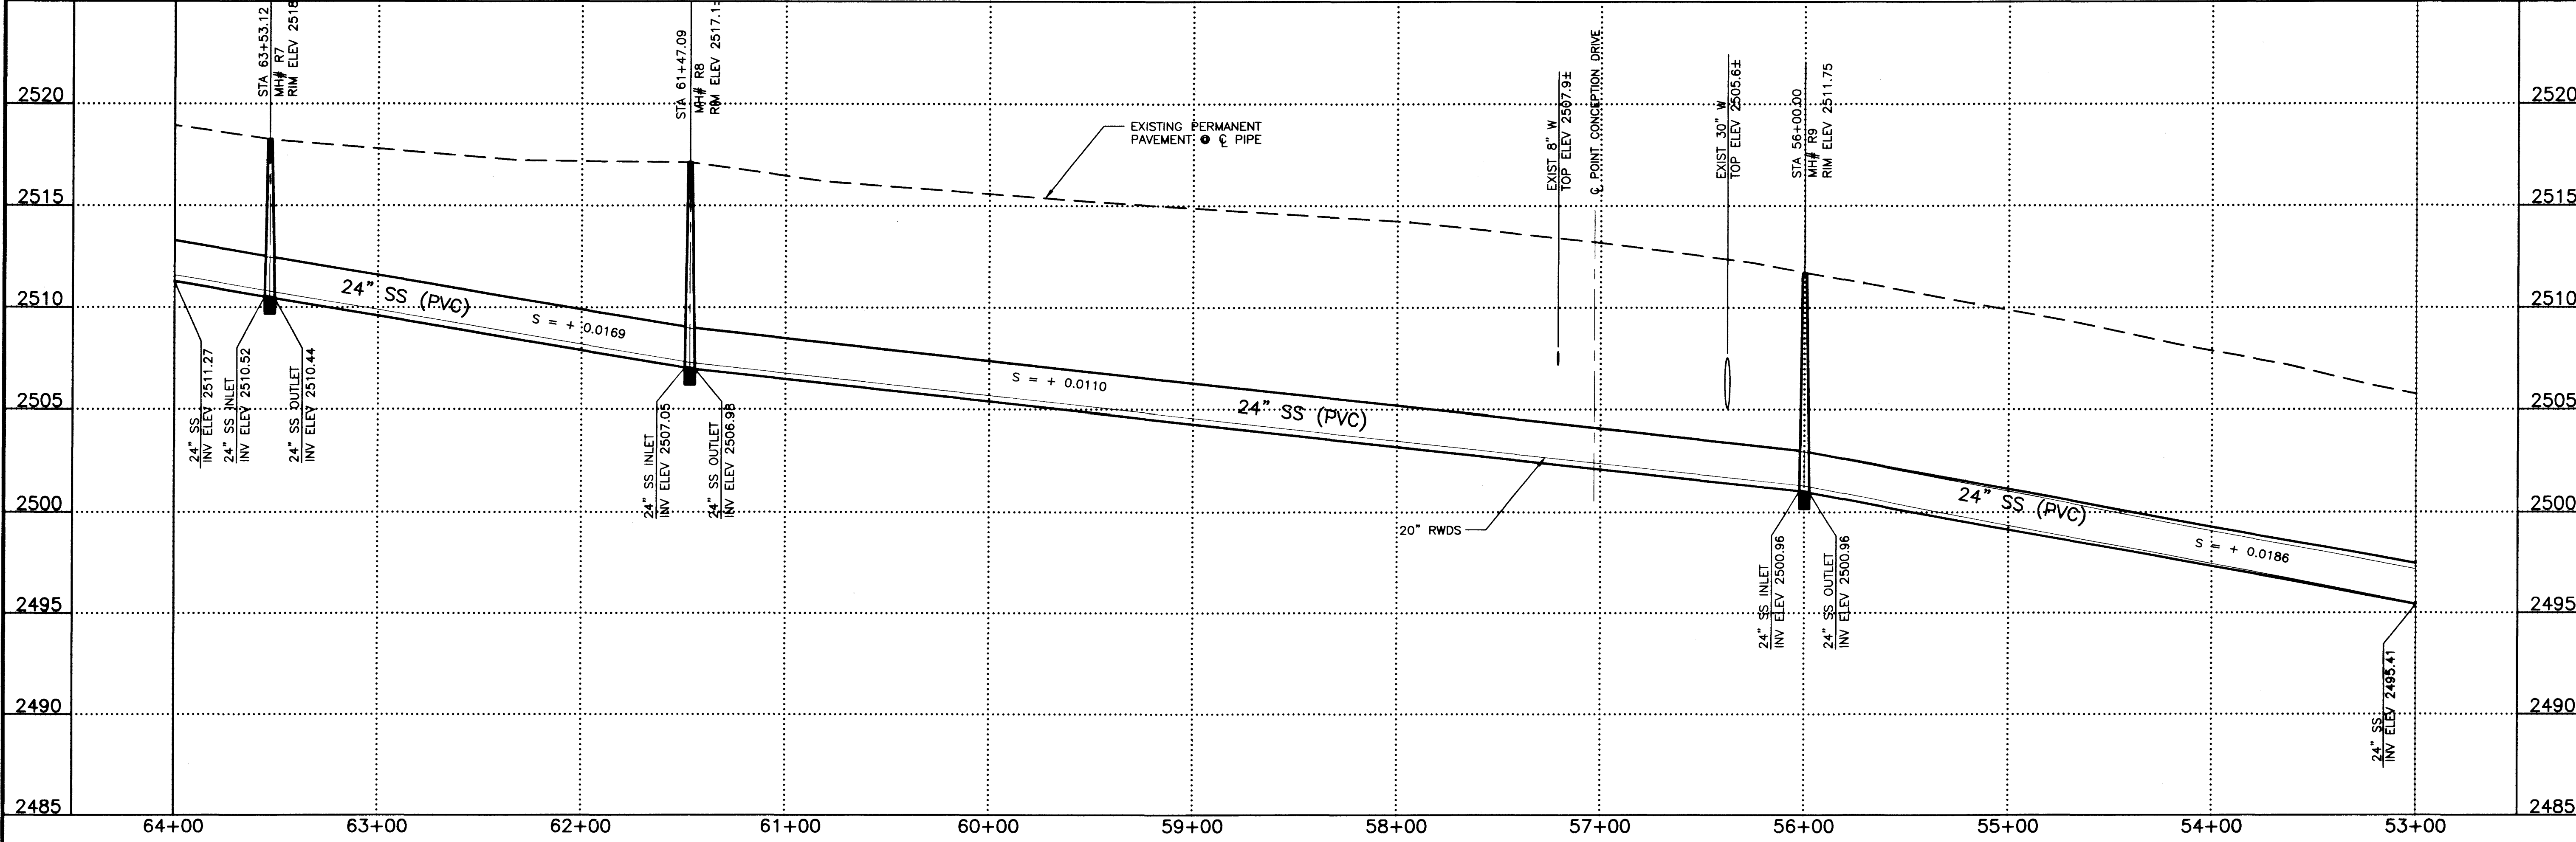


FILE: 894C30 1:0 08/12/98 17:01 GH-B

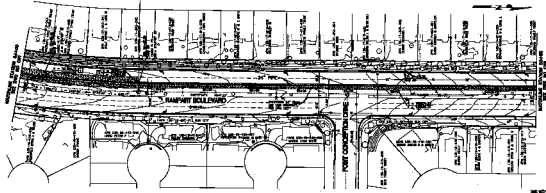

Call
before you
Dig
1-800-227-2600

RECYCLED WATER DISTRIBUTION SYSTEM - RAMPART BLVD PIPELINE		LAS VEGAS VALLEY WATER DISTRICT	
INFLUENT SEWER - PLAN AND PROFILE STA 53+00 TO STA 64+00		GREELEY AND HANSEN ENGINEERS 4625 SOUTH POLARIS AVENUE, SUITE 210 LAS VEGAS, NEVADA 89103	
DRAWN BY: 1/19/98 CHECKED BY: 6/10/98 RECOMMENDED BY: 8/4/98 RAM G. JARNA R.P.E. NO. DATE ACCEPTED BY: 8/25/98 ANDREW W. RICHARDSON R.P.E. NO. DATE		VERIFY SCALE 1/2" = 0' 1/2" BAR REPRESENTS ORIGINAL INCHES ON ORIGINAL	
CONTRACT NUMBER 894		DRAWING NUMBER C30 SHEET 38 OF 51	

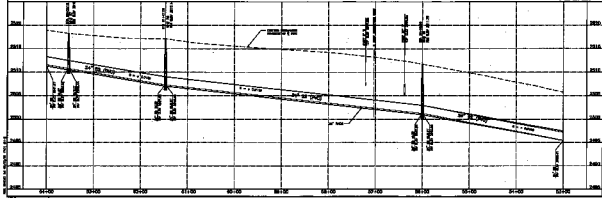

NO. 1000, JANUARY, 1954, 1-1



804

SEWER LINE CENTER LINE - 24\"/>

VERY SCALE
1\"/>

LA VILLE WALK WEST STREET
CHURCH AND HANSEN
EASTWICK
400 SOUTH POLAR AVENUE, SUITE 20
LAS VEGAS, NEVADA 89103