
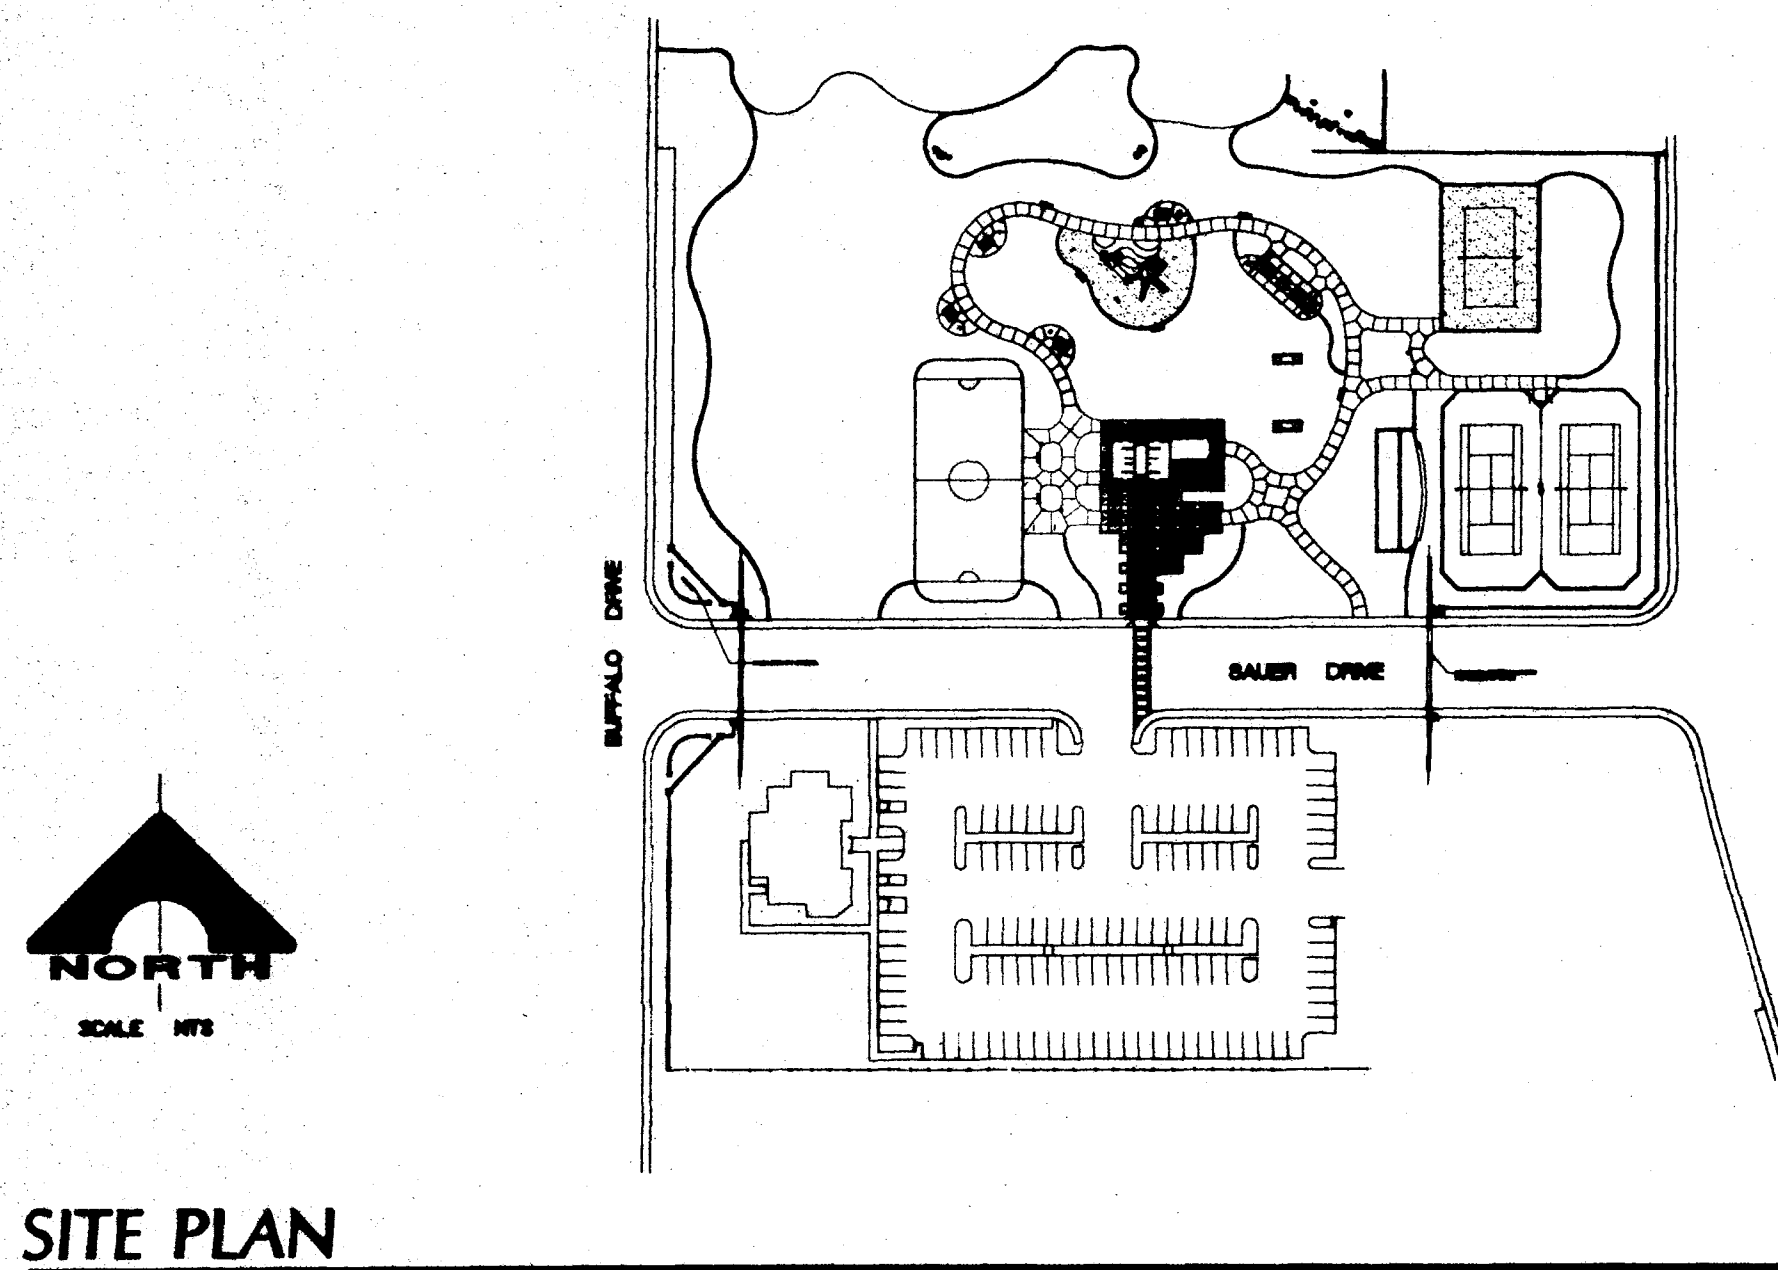


# DEPARTMENT OF PARKS & LEISURE ACTIVITIES


## *LIBRARY PARK*

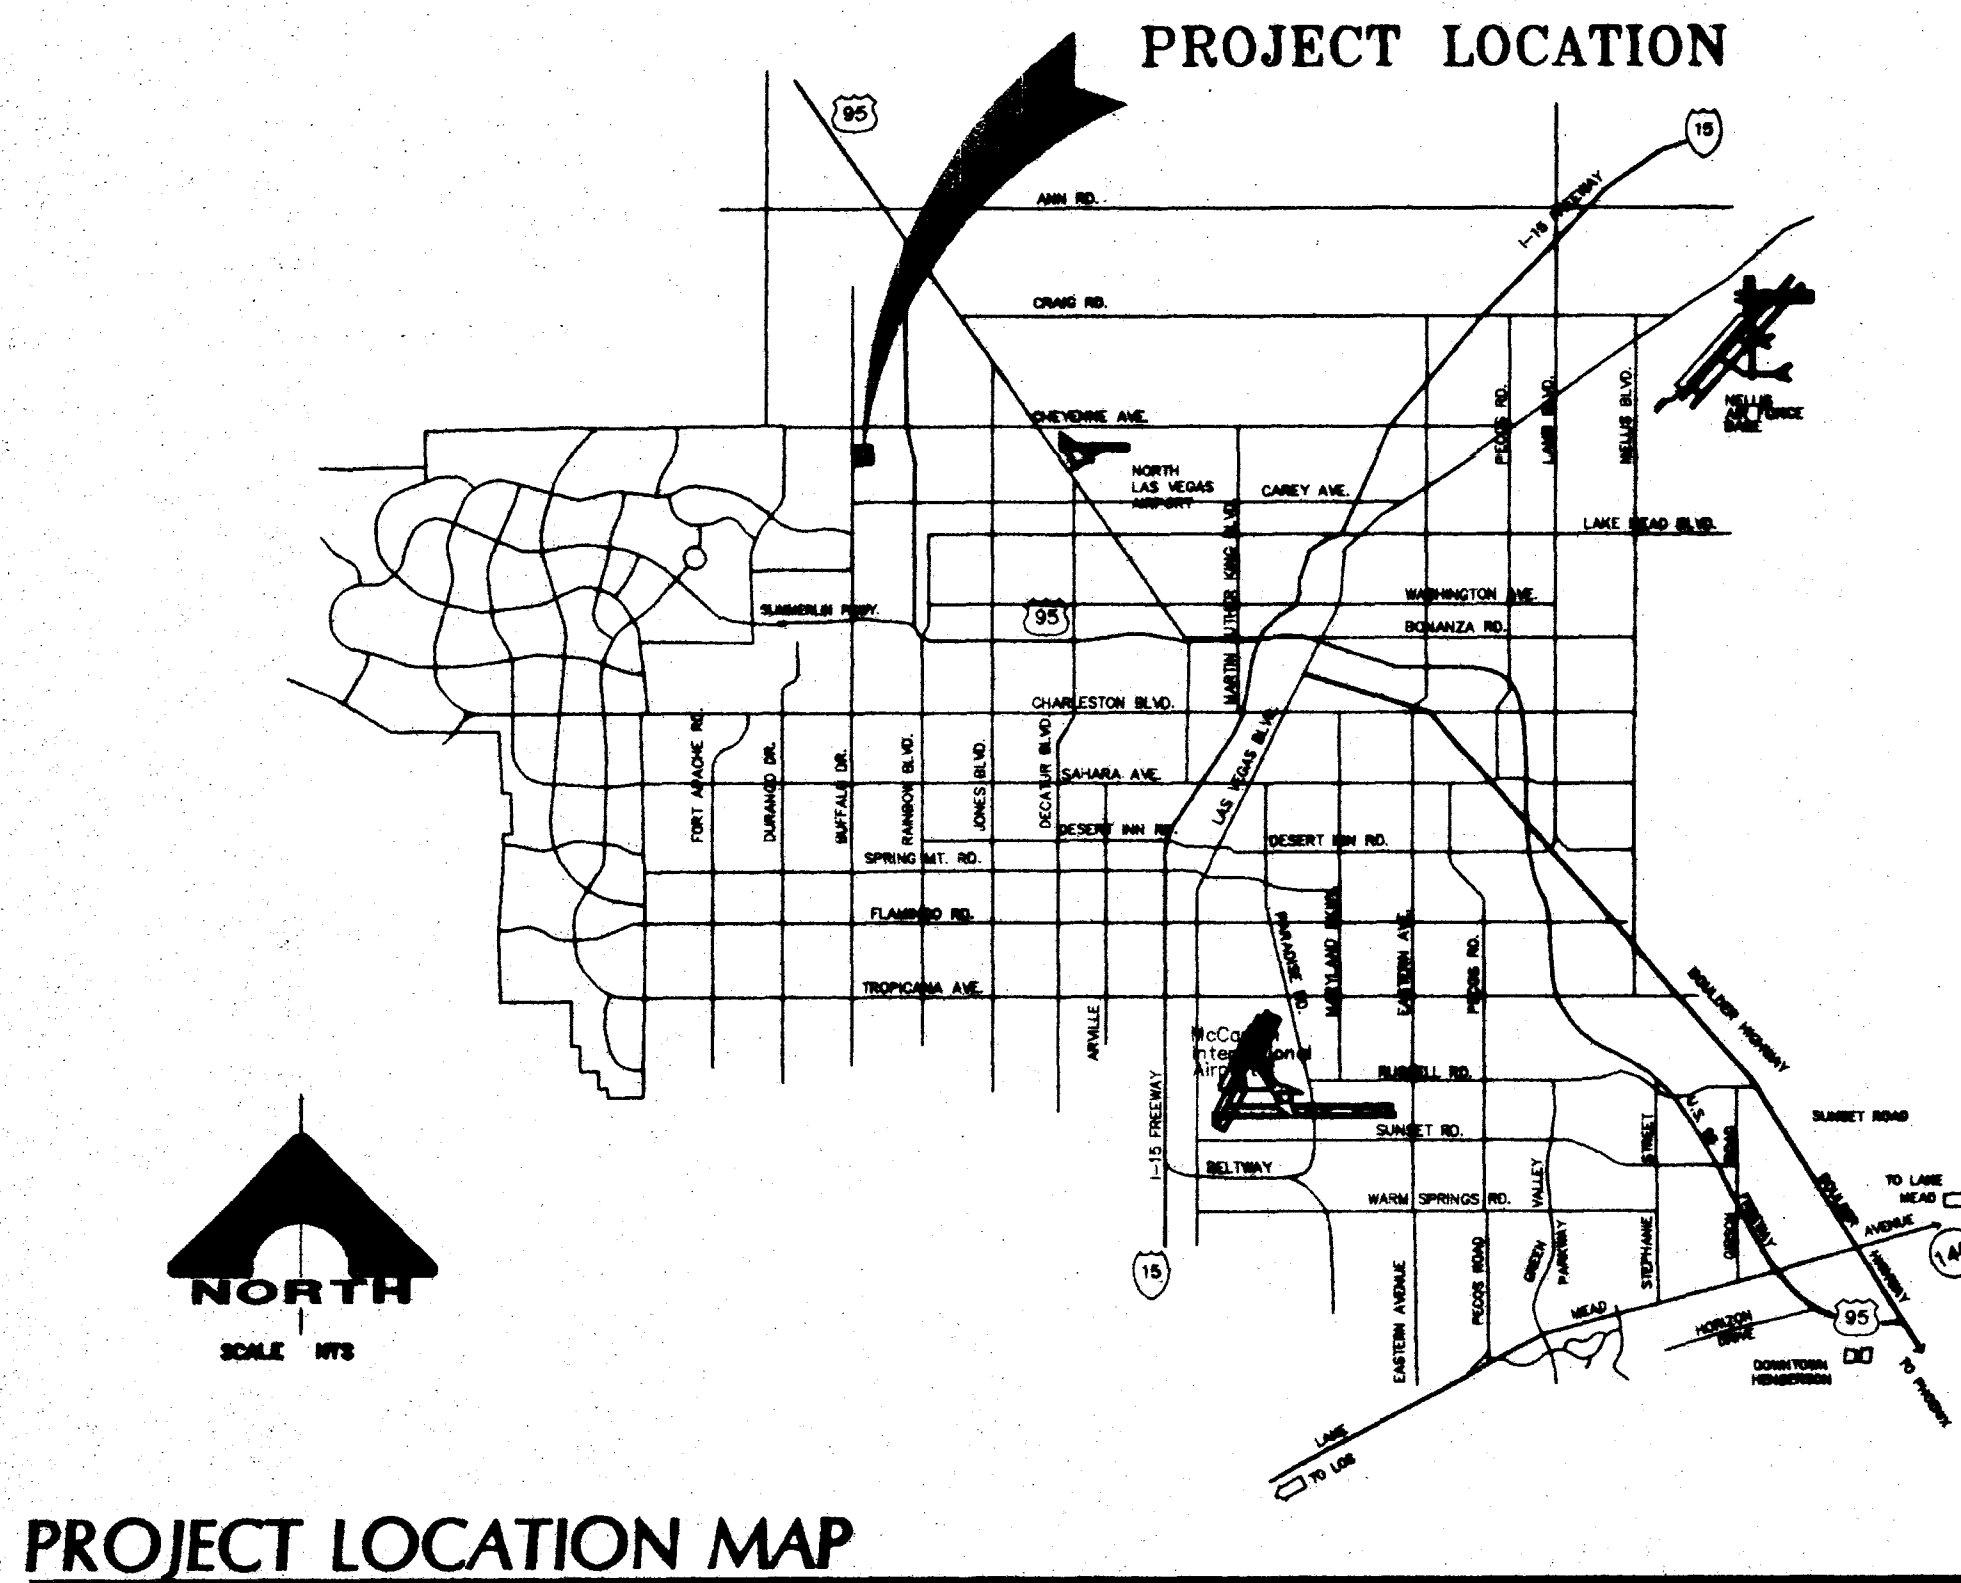

## DRAWING INDEX

- |    |      |   |                                                           |
|----|------|---|-----------------------------------------------------------|
| 1  | D1.1 | - | COVER SHEET                                               |
| 2  | D1.2 | - | DRAWING INDEX                                             |
| 3  | C1.1 | - | GENERAL NOTES                                             |
| 4  | C2.1 | - | DIMENSION PLAN                                            |
| 5  | C3.1 | - | GRADING PLAN                                              |
| 6  | C4.1 | - | UTILITY PLAN                                              |
| 7  | C5.1 | - | DETAILS                                                   |
| 8  | L1.1 | - | LANDSCAPE DEMOLITION PLAN                                 |
| 9  | L2.1 | - | LANDSCAPE EQUIPMENT SCHEDULE                              |
| 10 | L2.2 | - | LANDSCAPE LAYOUT PLAN                                     |
| 11 | L3.1 | - | LANDSCAPE PLANTING SCHEDULE                               |
| 12 | L3.2 | - | LANDSCAPE PLANTING PLAN                                   |
| 13 | L4.1 | - | LANDSCAPE IRRIGATION SCHEDULE                             |
| 14 | L4.2 | - | LANDSCAPE IRRIGATION PLAN                                 |
| 15 | L4.3 | - | IRRIGATION RETROFIT PLAN                                  |
| 16 | L4.4 | - | LANDSCAPE IRRIGATION DETAILS                              |
| 17 | L5.1 | - | LANDSCAPE CONSTRUCTION DETAILS                            |
| 18 | L5.2 | - | LANDSCAPE CONSTRUCTION DETAILS                            |
| 19 | L5.3 | - | LANDSCAPE CONSTRUCTION DETAILS                            |
| 20 | E1.1 | - | ELECTRICAL LEGEND & SCHEDULE                              |
| 21 | E2.1 | - | ELECTRICAL SITE PLAN                                      |
| 22 | E3.1 | - | ELECTRICAL DETAILS                                        |
| 23 |      | - | NEVADA POWER PLAN                                         |
| 24 |      | - | SPRINT CENTEL PLAN                                        |
| 25 | A1   | - | FLOOR PLAN                                                |
| 26 | A2   | - | EXTERIOR ELEVATIONS                                       |
| 27 | A3   | - | BUILDING SECTIONS                                         |
| 28 | A4   | - | WALL SECTIONS                                             |
| 29 | A5   | - | REFLECTED CEILING PLAN                                    |
| 30 | A6   | - | ROOF PLAN                                                 |
| 31 | A7   | - | INTERIOR ELEVATIONS, DOOR SCHEDULE, ROOM FINISH SCHEDULE. |
| 32 | A8   | - | MISCELLANEOUS DETAILS                                     |
| 33 | S1   | - | GENERAL NOTES                                             |
| 34 | S2   | - | FOUNDATION PLAN                                           |
| 35 | S3   | - | ROOF FRAMING PLAN                                         |
| 36 | S4   | - | SECTIONS & DETAILS                                        |
| 37 | S5   | - | SECTIONS & DETAILS                                        |
| 38 | S6   | - | SECTIONS & DETAILS                                        |
| 39 | M1   | - | VENTILATION FLOOR PLAN                                    |
| 40 | P1   | - | SYMBOLS, NOTES, SCHEDULES, ISOMETRIC PIPING               |
| 41 | P2   | - | SOIL, WASTE AND VENT FLOOR PLAN                           |
| 42 | P3   | - | COLD WATER LINE FLOOR PLAN                                |
| 43 | EB-1 | - | ELECTRICAL FLOOR PLAN                                     |

## CONSULTANTS

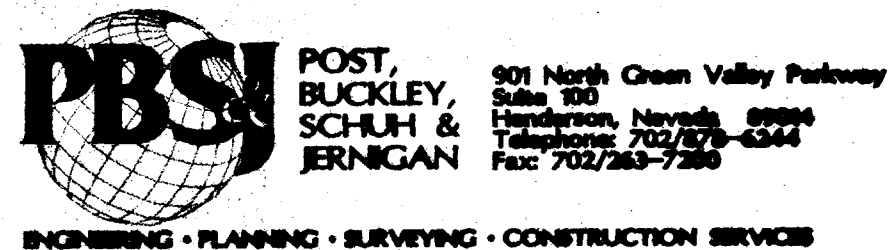

**TJ KROB CONSULTING ENGINEERS, INC.**  
1919 S. JONES BLVD. SUITE B  
LAS VEGAS, NEVADA 89102  
(702) 871-3621  
**ELECTRICAL ENGINEERING**

**Terracon**  
CONSULTANTS WESTERN, INC.  
4643 South Polaris Avenue  
Las Vegas, Nevada 89108  
Phone (702) 597-6000  
Fax (702) 597-6000


# LANDSCAPE ARCHITECT

**JWZUNINO & ASSOCIATES**  
**LANDSCAPE ARCHITECTURE - LAND PLANNING**  
 3305 W. SPRING MOUNTAIN ROAD #90 LAS VEGAS, NEVADA 89102  
 PHONE: (702) 253-9390 - FAX: 253-1016 - E-MAIL: jwzunino@bellsouth.net


|                                     |  |-------------------------------------|--|----|--|-------------------------------------------------------------------------------------|--|-----------|--|-------------------------------------------------------------------------------------|--|-----------|--|--------|--|-------------------|--|-----------|--|------|--|------------------------------------------------------------------------------------------------------------------------------------------------------------------------------------------------------------------------|--|--|--|
| DRAWING NO.                         |  | 2  |  |  |  | SCALE (H) |  | NTS                                                                                 |  | SCALE (V) |  | W.A. # |  | DESIGN BY: CAW/DH |  | REVISIONS |  | DATE |  |                                                                                                                                                                                                                        |  |  |  |
| D1.2<br>650.42                      |  | 43 |  |                                                                                     |  | FLD BK #  |  | DATE:                                                                               |  | 7/07      |  |        |  |                   |  |           |  |      |  |                                                                                                                                                                                                                        |  |  |  |
| DEPT. OF PARKS & LEISURE ACTIVITIES |  |    |  | PROJECT:                                                                            |  |           |  |  |  |           |  |        |  |                   |  |           |  |      |  | <b>WZUNINO &amp; ASSOCIATES</b><br><b>LANDSCAPE ARCHITECTURE - LAND PLANNING</b><br>3336 W. SPRING MOUNTAIN ROAD #100 LAS VEGAS, NEVADA 89102<br>PHONE: (702) 252-4000 - FAX: (702) 252-1074 - E-MAIL: jwz@wzunino.com |  |  |  |
| DRAWING INDEX                       |  |    |  | LIBRARY PARK                                                                        |  |           |  |                                                                                     |  |           |  |        |  |                   |  |           |  |      |  |                                                                                                                                                                                                                        |  |  |  |

# DEPARTMENT OF PARKS & LEISURE ACTIVITIES

## LIBRARY PARK

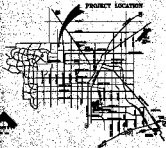

PROJECT LOCATION MAP

 

SITE PLAN

### DRAWING INDEX

|    |                                                               |
|----|---------------------------------------------------------------|
| 1  | D1.1 - COVER SHEET                                            |
| 2  | D1.2 - DRAWING INDEX                                          |
| 3  | C1.1 - GENERAL NOTES                                          |
| 4  | C2.1 - DIMENSION PLAN                                         |
| 5  | C3.1 - GRADING PLAN                                           |
| 6  | C4.1 - UTILITY PLAN                                           |
| 7  | C5.1 - DETAILS                                                |
| 8  | L1.1 - LANDSCAPE DEMOLITION PLAN                              |
| 9  | L2.1 - LANDSCAPE EQUIPMENT SCHEDULE                           |
| 10 | L2.2 - LANDSCAPE LAYOUT PLAN                                  |
| 11 | L3.1 - LANDSCAPE PLANTING SCHEDULE                            |
| 12 | L3.2 - LANDSCAPE PLANTING PLAN                                |
| 13 | L4.1 - LANDSCAPE IRRIGATION SCHEDULE                          |
| 14 | L4.2 - LANDSCAPE IRRIGATION PLAN                              |
| 15 | L4.3 - IRRIGATION RETROFIT PLAN                               |
| 16 | L4.4 - LANDSCAPE IRRIGATION DETAILS                           |
| 17 | L5.1 - LANDSCAPE CONSTRUCTION DETAILS                         |
| 18 | L5.2 - LANDSCAPE CONSTRUCTION DETAILS                         |
| 19 | L5.3 - LANDSCAPE CONSTRUCTION DETAILS                         |
| 20 | E1.1 - ELECTRICAL LEGEND & SCHEDULE                           |
| 21 | E2.1 - ELECTRICAL SITE PLAN                                   |
| 22 | E3.1 - ELECTRICAL DETAILS                                     |
| 23 | NEVADA POWER PLAN                                             |
| 24 | SPRINT CENTEL PLAN                                            |
| 25 | A1 - FLOOR PLAN                                               |
| 26 | A2 - EXTERIOR ELEVATIONS                                      |
| 27 | A3 - BUILDING SECTIONS                                        |
| 28 | A4 - WALL SECTIONS                                            |
| 29 | A5 - REFLECTED CEILING PLAN                                   |
| 30 | A6 - ROOF PLAN                                                |
| 31 | A7 - INTERIOR ELEVATIONS, DOOR SCHEDULE, ROOM FINISH SCHEDULE |
| 32 | MISCELLANEOUS DETAILS                                         |
| 33 | S1 - GENERAL NOTES                                            |
| 34 | S2 - FOUNDATION PLAN                                          |
| 35 | S3 - ROOF FRAMING PLAN                                        |
| 36 | S4 - SECTIONS & DETAILS                                       |
| 37 | S5 - SECTIONS & DETAILS                                       |
| 38 | S6 - SECTIONS & DETAILS                                       |
| 39 | M1 - VENTILATION FLOOR PLAN                                   |
| 40 | P1 - SYMBOLS, NOTES, SCHEDULES, ISOMETRIC PIPING              |
| 41 | S7 - HOT WATER AND VENT FLOOR PLAN                            |
| 42 | S8 - COLD WATER AND VENT FLOOR PLAN                           |
| 43 | S9 - ELECTRICAL FLOOR PLAN                                    |

### CONSULTANTS



### LANDSCAPE ARCHITECT

