



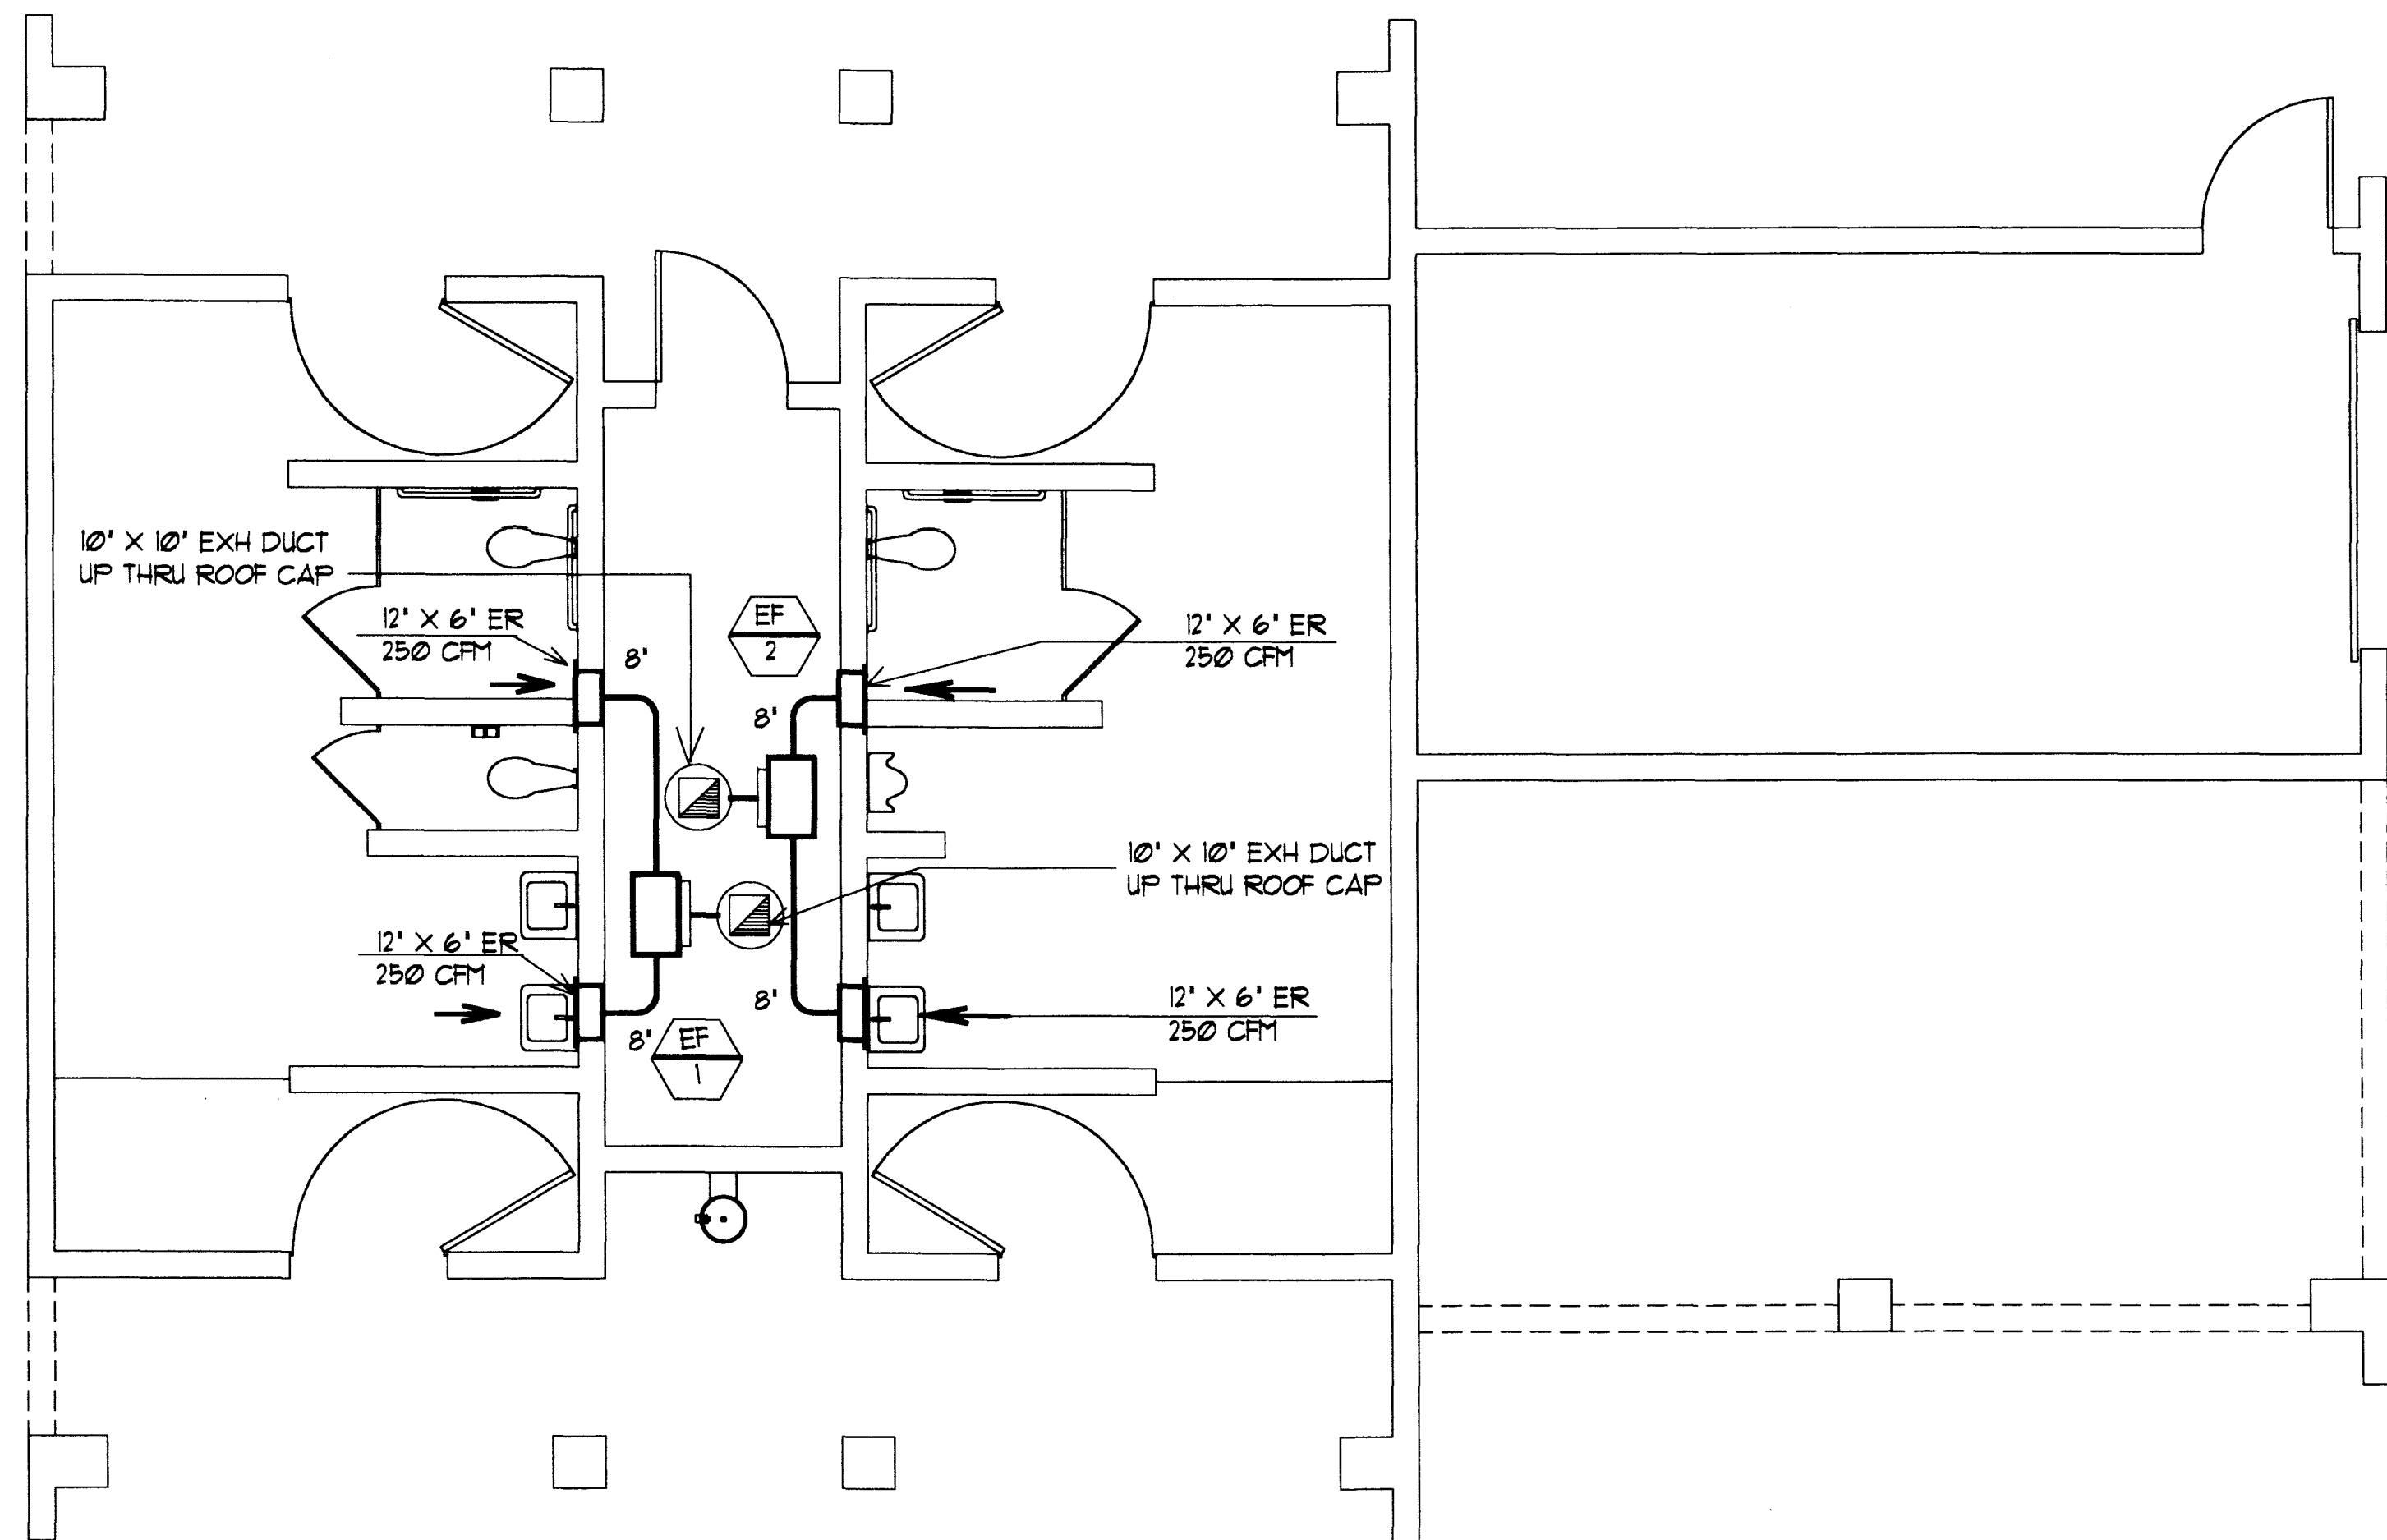

SYMBOL LIST

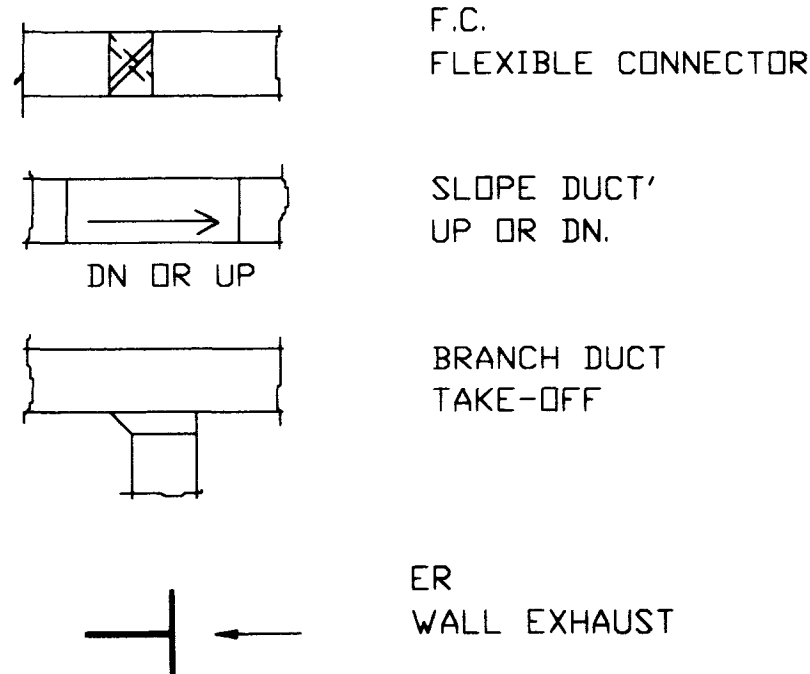

- GENERAL NOTES:
1. ALL WORK SHALL BE IN ACCORDANCE WITH 1994 UBC, UMC, UPC & NFPA, 1993 NEC AND 1992 MEC. ALL LATEST RULES, REGULATION AND ORDINANCES OF THE CITY OF LAS VEGAS AND STATE OF NEVADA.
 2. MECHANICAL CONTRACTOR SHALL BE RESPONSIBLE FOR ALL PERMITS AND FEES RELATED TO HIS TRADE.
 3. ALL NEW DUCTWORK WILL BE CONSTRUCTED AND SUPPORTED UNDER LATEST EDITION OF SMACNA AND 1994 UMC.
 4. ALL DUCT SHALL BE INSTALLED TO CLEAR LIGHTS AND BUILDING STRUCTURES.
 5. SUBMIT SIX COPIES OF SHOP DRAWINGS AND SUBMITTALS FOR REVIEW AND APPROVAL BEFORE ORDERING MATERIALS.
 6. COORDINATE WITH THE ELECTRICIAN FOR POWER CONNECTION .
 7. PROVIDE THE OWNER (3) THREE COPIES OF SERVICE AND MAINTENANCE MANUAL..

AIR OUTLETS SCHEDULE

TYPE	DESCRPTIONS	MFR / MODEL NO.
ER	EXHAUST REGISTER, BAR GRILLE W/ 1/2" SPACING HEAVY DUTY STEEL CONSTRUCTION & FRAME H	KRUEGER NO. 1815 RHD45 OR EQUAL.

FAN SCHEDULE

NO.	MFR/MODEL NO	TYPE	CFM	TSP	WATTS	RPM	V-PH-HZ	WT.	SERVICE	LOCATION
EF-1	DAYTON 2D073	CEILING	500	0.25	280	1050	115-1-60	48	WOMEN	CEILING
EF-2	DAYTON 2D073	CEILING	500	0.25	280	1050	115-1-60	48	MEN	CEILING

- NOTES:
1. ALL EXHAUST FANS SHALL BE COMPLETE WITH ROOF CAP, FLASHING, EXHAUST DUCT.
 2. EF-1, EF-2 SHALL BE CONTROLLED BY PROGRAMMABLE TIME CLOCK.

DATE:

REVISIONS:

PROJECT:

DEPARTMENT OF PUBLIC WORKS

LIBRARY PARK RESTROOM FACILITY

VENTILATION FLOOR PLAN

650.42

39

43

DRAWN BY: HL

DESIGN BY: AC

DATE: 1/91

ARCHITECTURAL SERVICES

CITY OF LAS VEGAS

PROJECT:

LIBRARY PARK RESTROOM FACILITY

VENTILATION FLOOR PLAN

650.42

39

43

