


APPROVED REDUCED PRESSURE PRINCIPLE ASSEMBLY(S) SHALL BE INSTALLED PER THE
UDACS PLATE NO. 11A OR 11B. NO WATER SHALL BE TAKEN FROM A SERVICE
REQUIRING BACKFLOW PREVENTION UNTIL THE REDUCED PRESSURE PRINCIPLE ASSEMBLY
HAS BEEN SUCCESSFULLY TESTED BY THE LVVWD.

ANY BLOCK WALL OR OTHER FENCE MATERIAL SHALL BE DESIGNED AND CONSTRUCTED AROUND THE OUTSIDE OF THE EASEMENT(S) TO ALLOW THE DISTRICT DIRECT ACCESS FROM THE ADJACENT RIGHT OF WAY.

THIS PROPERTY MAY HAVE STATIC WATER PRESSURE IN EXCESS OF 80psi. THE UNIFORM PLUMBING CODE REQUIRES THAT INDIVIDUAL ON-SITE (PRIVATE) PRESSURE REDUCING VALVES BE INSTALLED WHENEVER THE PRESSURE EXCEEDS 80psi. PRV'S ARE THE DEVELOPERS RESPONSIBILITY AND WILL NOT BE INSPECTED OR INCLUDED IN THE ACCEPTANCE OF LVWD FACILITIES.

THE DOUBLE CHECK DETECTOR ASSEMBLIES SHALL BE INSTALLED IN ACCORDANCE WITH THE UDACS PLATE 20B.

ANY BLOCK WALL OR OTHER FENCE MATERIAL SHALL BE DESIGNED AND CONSTRUCTED AROUND THE OUTSIDE OF THE EASEMENT(S) SO AS TO ALLOW THE DISTRICT DIRECT ACCESS FROM THE ADJACANT RIGHT-OF-WAY.

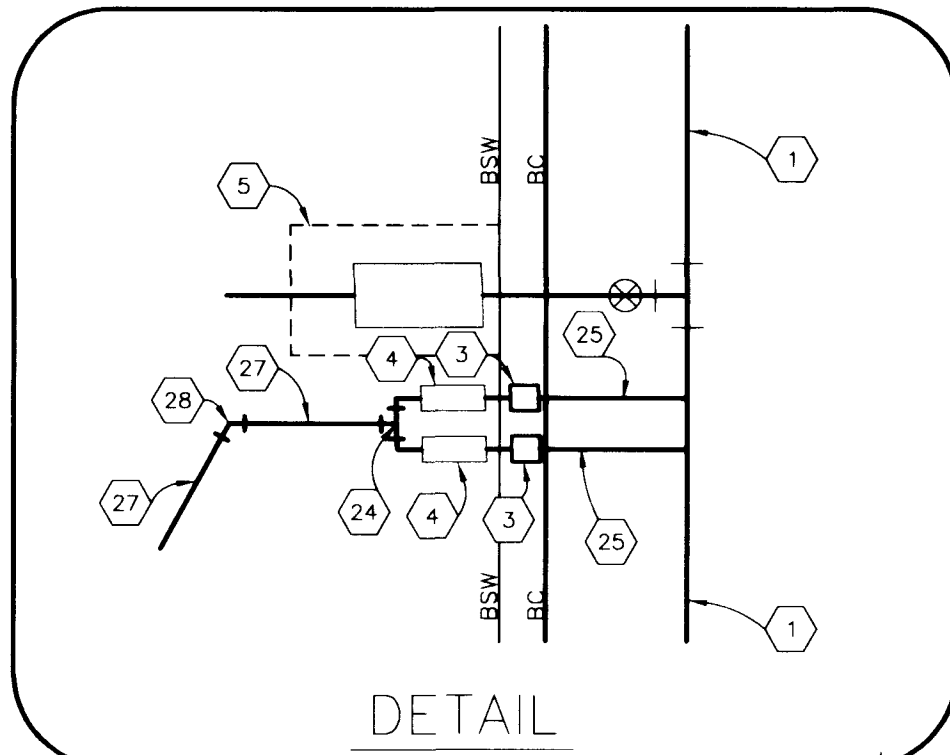


1	INSTALL 10" PVC WATER PIPE	13	INSTALL 8" x 6" TEE	25	INSTALL 2" COPPER TYPE "K" WATERLINE	37	INSTALL 12"x 10" REDUCER
2	INSTALL 2- 2" SERVICE SADDLES	14	INSTALL 6" GATE VALVE	27	INSTALL 4" PVC WATERLINE	38	INSTALL 12" x 12" x 12" TEE
3	INSTALL 2" WATER METER PER LVVWD STANDARDS	15	INSTALL 6" PVC WATER PIPE	28	INSTALL 4" 45' ELBOW	39	INSTALL 12" PVC WATERLINE
4	INSTALL 2" RPPA PER LVVWD STANDARDS	16	INSTALL FIRE HYDRANT ASSEMBLY PER U.D.A.C.S. PLATE 7	29	INSTALL 8" PVC SDR35 SANITARY SEWER	40	JOIN EXIST. 12" PVC WATER LINE
5	10' x 20' LVVWD EASEMENT	17	INSTALL 8" GATE VALVE	30	INSTALL 48" SANITARY SEWER MANHOLE	41	INSTALL 12" x 12" x 8" TEE
6	6' x 6' LVVWD EASEMENT	18	TERMINATE WATERLINE 5' FROM BLDG. SEE PLUMBING PLAN FOR CONTINUATION	31	INSTALL 8" x 6" WYE	42	INSTALL 10" DCDA
7	INSTALL 6" TEE	19	INSTALL 6" 22" ELBOW D.I. FITTING	32	INSTALL 6" SANITARY SEWER	43	INSTALL 8"x6" TAPPING TEE & VALVE
8	INSTALL 6" x 4" TEE	20	INSTALL 8" 22" ELBOW D.I. FITTING	33	INSTALL 6" CLEANOUT PER DETAIL 1 SHEET 21		
9	INSTALL 10" GATE VALVE	21	INSTALL 8" TEE	34	INSTALL 6" WYE		
10	INSTALL 10" x 8" REDUCER	22	INSTALL 2" BLOW OFF	35	INSTALL 10" x 10" TEE		
11	INSTALL 8" 45' ELBOW	24	INSTALL 4" x 2" x 2" TEE	36	INSTALL 12" GATE VALVE		
12	INSTALL 8" PVC WATER PIPE			37	PEST INDICATOR VALVE W/TAMPER SWITCH		

STREETLIGHT NOTE:


SEE "CONSTRUCTION NOTES" ON SHEETS C1.10, C1.11 AND C1.13 FOR STREETLIGHT CONSTRUCTION INFORMATION

GENERAL NOTE: ALL UTILITY LINES SHALL BE BACKFILLED AND COMPACTED PER
CLARK COUNTY PUBLIC WORKS STANDARD DRAWING NOS. 405 & 406.

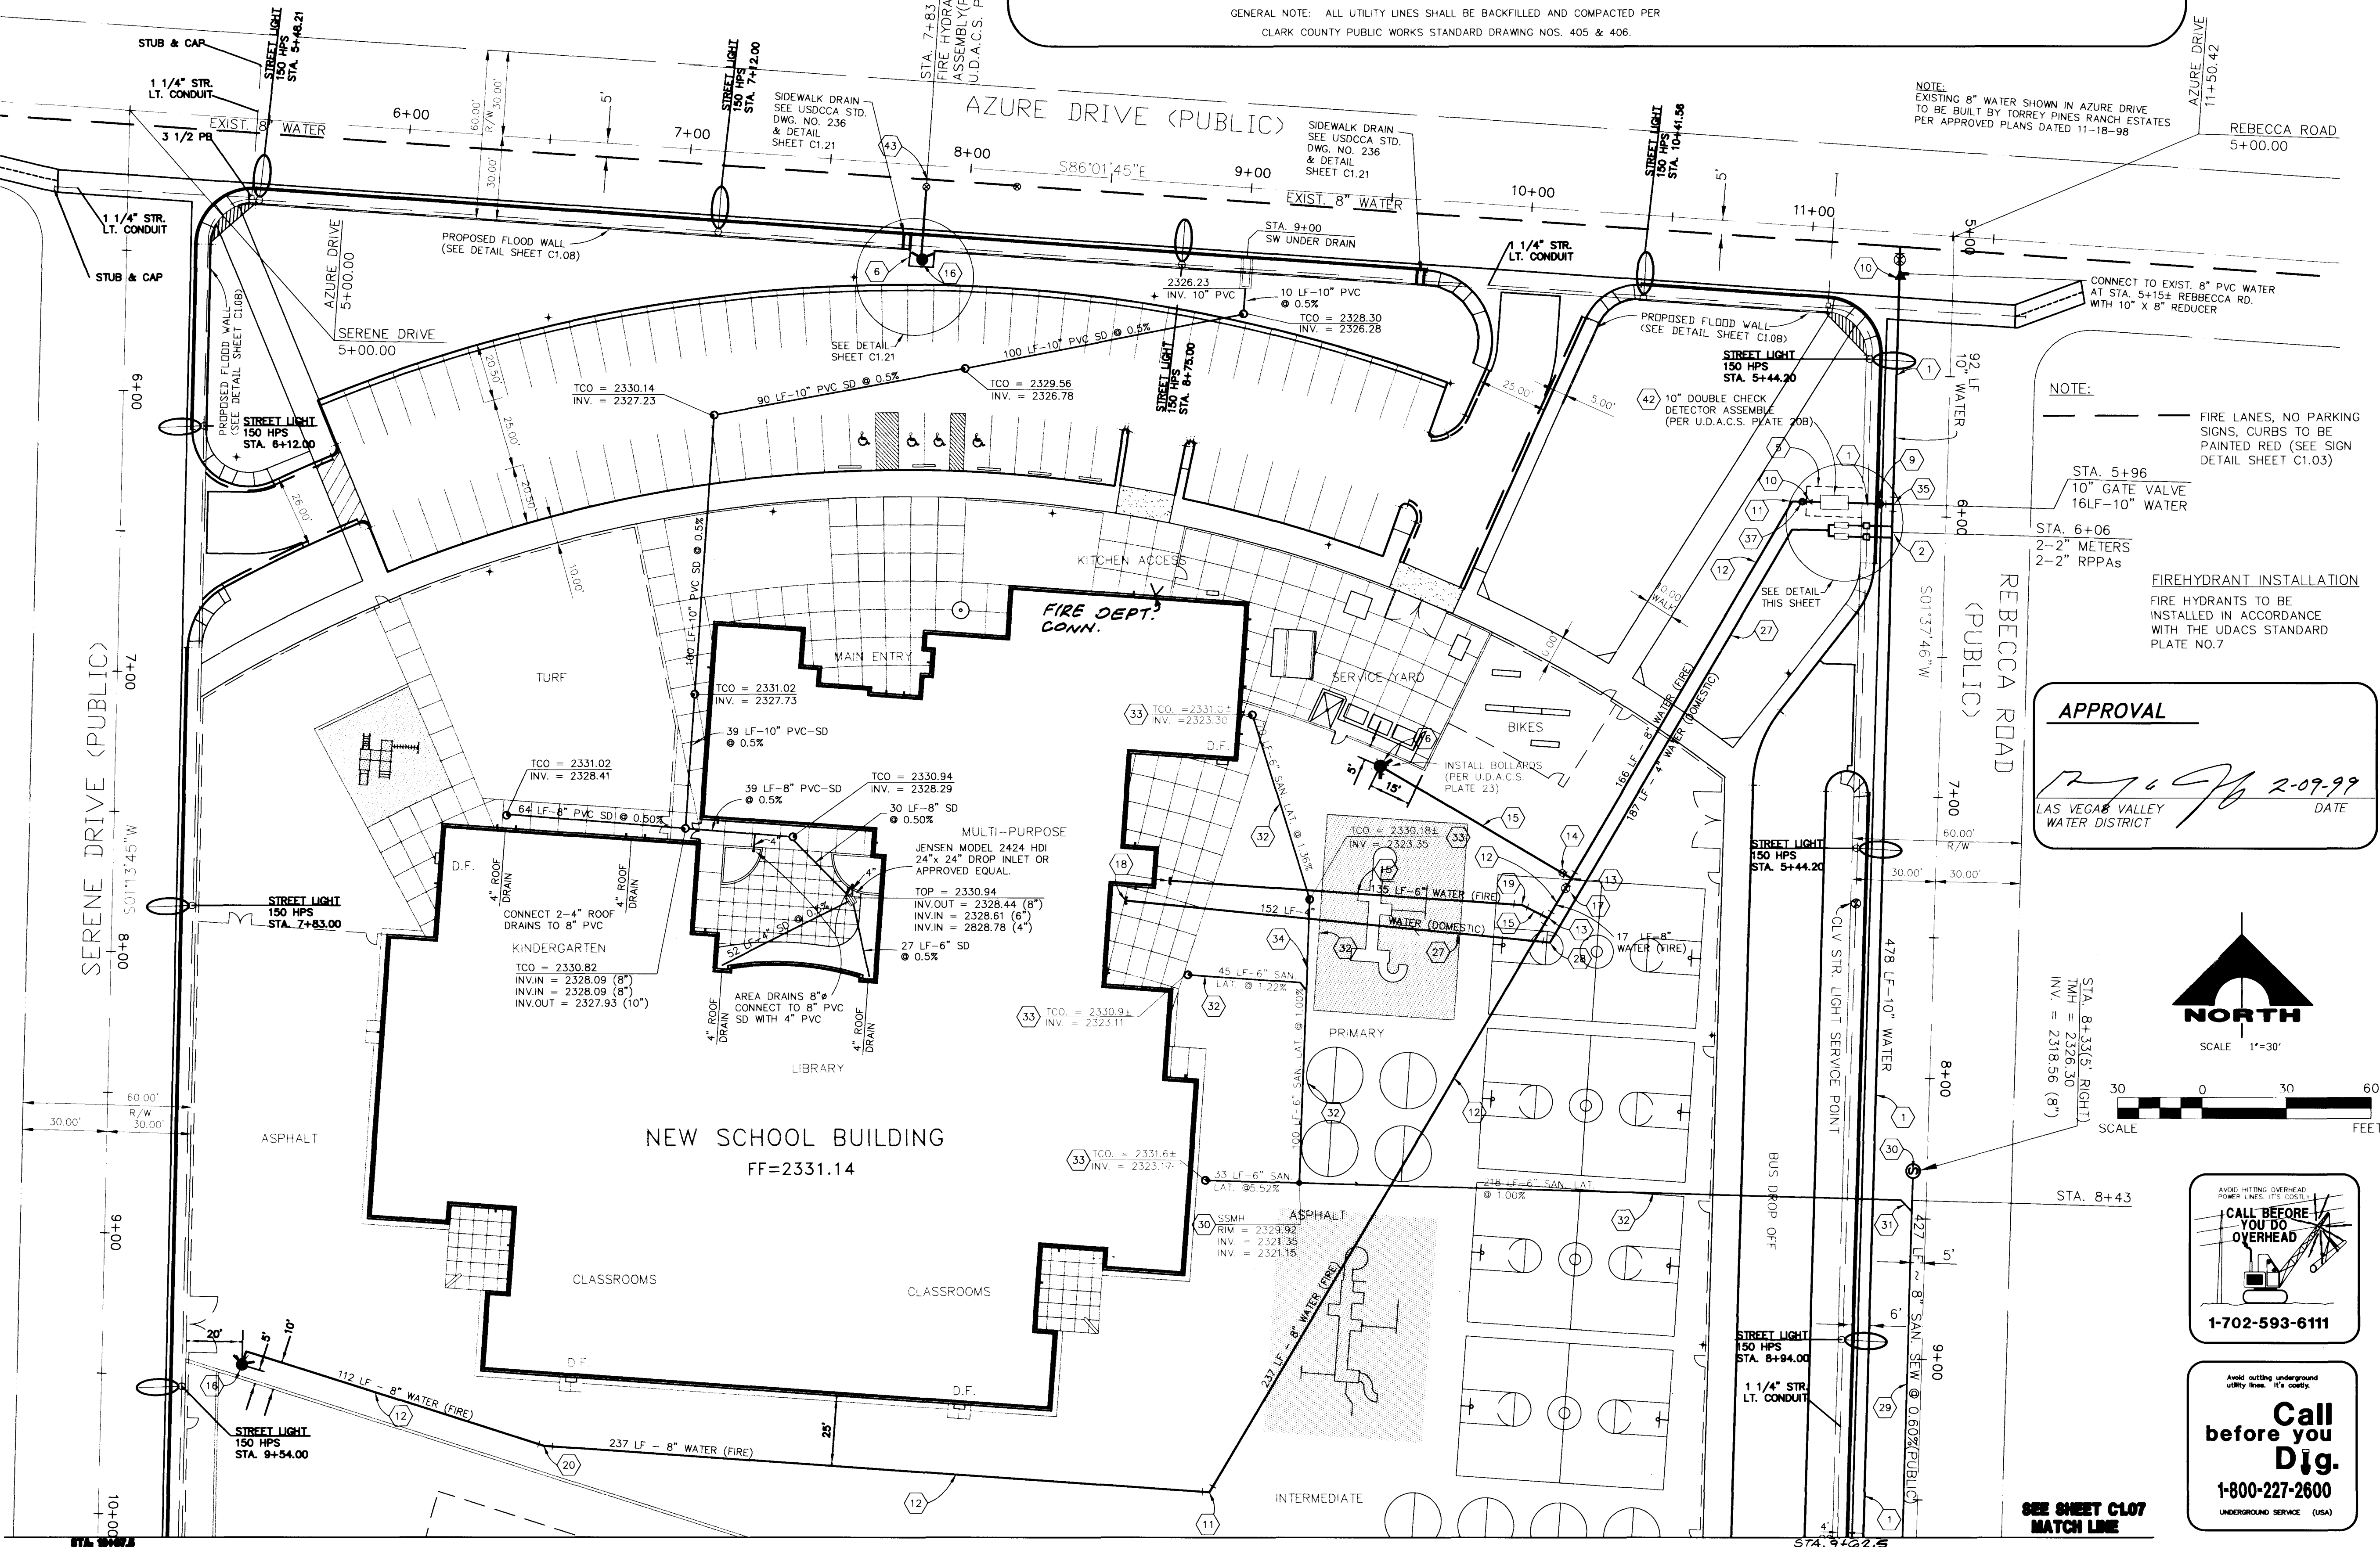[illegible]

DO NOT SCALE DRAWINGS

All designs, arrangements and plans indicated or presented by this drawing, as instruments of service, are owned by and the property of the ARCHITECTS. To reproduce or disclose any part of the drawings or designs other than the original architect is a violation of NRS 623. The plans and/or specifications shall be restricted to the original site for which they were prepared and publication or reproduction is limited to such use. Reproduction, publication or resale for any other purpose or use in particular is prohibited. None of such designs, arrangements or plans shall be used by or disclosed to any person, firm, agency, or corporation without the written permission of the ARCHITECTS. Any contact with third parties on these plans and specifications shall constitute prima facie evidence of acceptance of these restrictions.

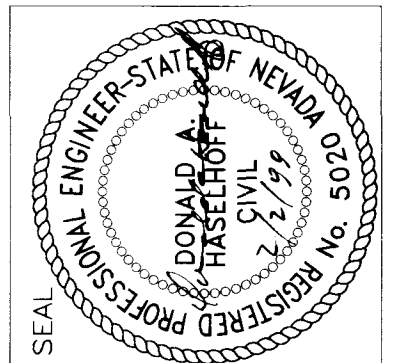

CSO PROJECT NO.	
CSO REVIEW	
APPROVED BY	
DATE	
DATE	
WRAN BY	KIM SIMPSON
CHECKED BY	BOB HERMAN
SUBMITAL	
PROJECT NO.	97224


— FIRE LANES, NO PARKING
SIGNS, CURBS TO BE
PAINTED RED (SEE SIGN
DETAIL SHEET C1.03)

FIREHYDRANT INSTALLATION
FIRE HYDRANTS TO BE
INSTALLED IN ACCORDANCE
WITH THE UDACS STANDARD
PLATE NO.7

12676 2-09-99
LAS VEGAS VALLEY WATER DISTRICT DATE



SCALE 1"=30'

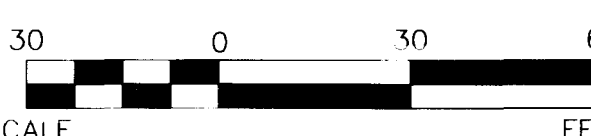

1-702-593-6111



**Call
before you
Dig.
1-800-227-2600**

IMA ARCHITECTURE STUDIOS

2992 SOUTH MARYLAND PARKWAY
[REDACTED] 20333

CLARK COUNTY SCHOOL DISTRICT
CONSTRUCTION MANAGEMENT

LAS VEGAS, NEVADA 89121

JOSEPH M. NEAL ELEMENTARY SCHOOL

SITE UTILITY PLAN I


SHEET NO.

C1.06
OF 22
715-106

[illegible]

- [illegible]

Copyright © 2005 by John Wiley & Sons, Inc.

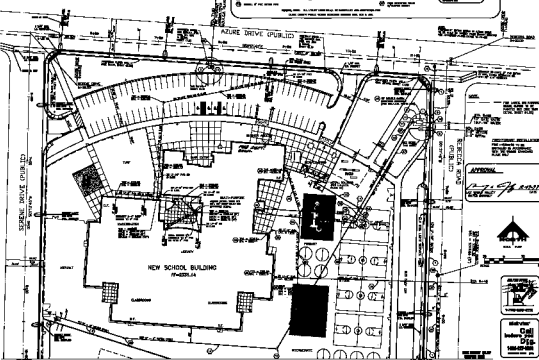[illegible][illegible]

	SCHOOL DISTRICT	
	100 WEST, KANSAS CITY	
	CITY SCHOOL	

CLARK COUNTY 8 CHO
 COMPLETELY REFINISHED
 4000 SQ. FT.
 JOSEPH M. NEAL ELEMENTARY
 (WATER UTILITY PLAN)

DRAWING NO. **C106**
 6 OF 22
 21E-104

CLARK COUNTY SCHOOL DISTRICT

JOSEPH M. NEAL ELEMENTARY SCHOOL

SITE UTILITY PLAN I

CLOS
6 OF 21
TIME=004