


APPROVED REDUCED PRESSURE PRINCIPLE ASSEMBLY(S) SHALL BE INSTALLED PER THE UDACS PLATE NO. 11A OR 11B. NO WATER SHALL BE TAKEN FROM A SERVICE REQUIRING BACKFLOW PREVENTION UNTIL THE REDUCED PRESSURE PRINCIPLE ASSEMBLY HAS BEEN SUCCESSFULLY TESTED BY THE LVVMD.

ANY BLOCK WALL OR OTHER FENCE MATERIAL SHALL BE DESIGNED AND CONSTRUCTED AROUND THE OUTSIDE OF THE EASEMENT(S) TO ALLOW THE DISTRICT DIRECT ACCESS FROM THE ADJACANT RIGHT OF WAY.

THIS PROPERTY MAY HAVE STATIC WATER PRESSURE IN EXCESS OF 80psi. THE UNIFORM PLUMBING CODE REQUIRES THAT INDIVIDUAL ON-SITE (PRIVATE) PRESSURE REDUCING VALVES BE INSTALLED WHENEVER THE PRESSURE EXCEEDS 80psi. PRVS ARE THE DEVELOPERS RESPONSIBILITY AND WILL NOT BE INSPECTED OR INCLUDED IN THE ACCEPTANCE OF LVWD FACILITIES.

THE DOUBLE CHECK DETECTOR ASSEMBLIES SHALL BE INSTALLED IN ACCORDANCE WITH THE UDACS PLATE 20B.

ANY BLOCK WALL OR OTHER FENCE MATERIAL SHALL BE DESIGNED AND CONSTRUCTED AROUND THE OUTSIDE OF THE EASEMENT(S) SO AS TO ALLOW THE DISTRICT DIRECT ACCESS FROM THE ADJACENT RIGHT-OF-WAY.

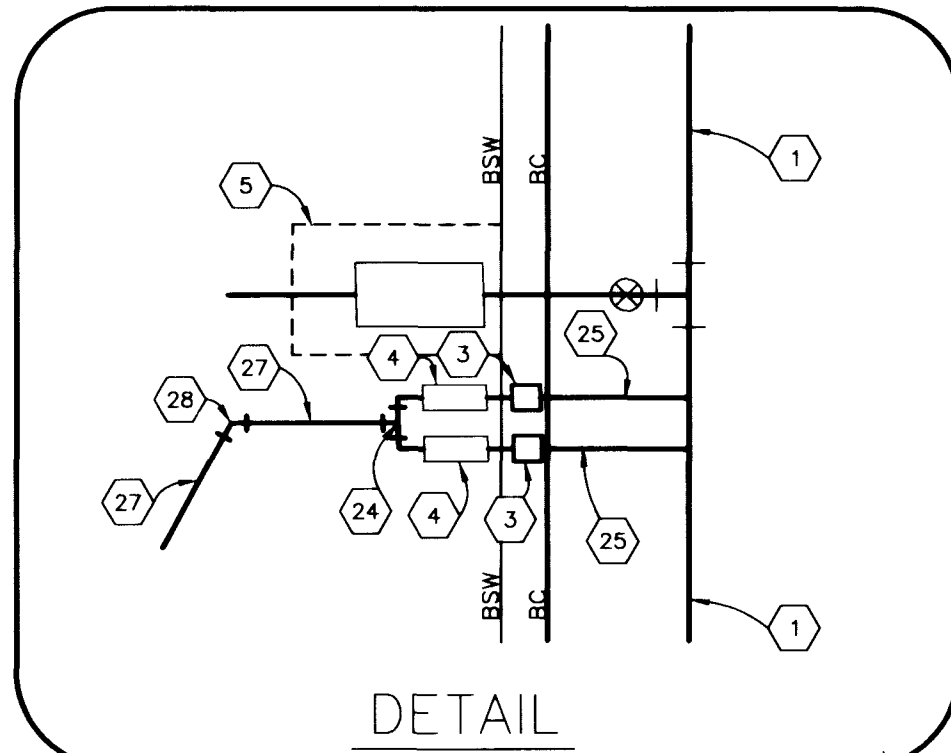

1. INSTALL 10" PVC WATER PIPE
2. INSTALL 2— 2" SERVICE SADDLES
3. INSTALL 2" WATER METER PER LVVWD STANDARDS
4. INSTALL 2" RPPA PER LVVWD STANDARDS
5. 10' x 20' LVVWD EASEMENT
6. 6' x 6' LVVWD EASEMENT
7. INSTALL 6" TEE
8. INSTALL 6" x 4" TEE
9. INSTALL 10" GATE VALVE
10. INSTALL 10" x 8" REDUCER
11. INSTALL 8" 45° ELBOW
12. INSTALL 8" PVC WATER PIPE


- 13 INSTALL 8" x 6" TEE
- 14 INSTALL 6" GATE VALVE
- 15 INSTALL 6" PVC WATER PIPE
- 16 INSTALL FIRE HYDRANT ASSEMBLY
PER U.D.A.C.S. PLATE 7
- 17 INSTALL 8" GATE VALVE
- 18 TERMINATE WATERLINE 5' FROM BLDG.
SEE PLUMBING PLAN FOR CONTINUATION
- 19 INSTALL 6" 221' ELBOW D.I. FITTING
- 20 INSTALL 8" 221' ELBOW D.I. FITTING
- 21 INSTALL 8" TEE
- 22 INSTALL 2" BLOW OFF
- 24 INSTALL 4" x 2" x 2" TEE

- | | |
|----|--|
| 25 | INSTALL 2" COPPER TYPE "K" WATERLINE |
| 27 | INSTALL 4" PVC WATERLINE |
| 28 | INSTALL 4" 45° ELBOW |
| 29 | INSTALL 8" PVC SDR35 SANITARY SEWER |
| 30 | INSTALL 48" SANITARY SEWER MANHOLE |
| 31 | INSTALL 8" x 6" WYE |
| 32 | INSTALL 6" SANITARY SEWER |
| 33 | INSTALL 6" CLEANOUT PER DETAIL 1
SHEET 21 |
| 34 | INSTALL 6" WYE |
| 35 | INSTALL 10" x 10" TEE |
| 36 | INSTALL 12" GATE VALVE |
| 37 | PEST INDICATOR VALVE
W/TAMPER SWITCH |

- 37 INSTALL 12"x 10" REDUCER
- 38 INSTALL 12" x 12" x 12" TEE
- 39 INSTALL 12" PVC WATERLINE
- 40 JOIN EXIST. 12" PVC WATER LINE
- 41 INSTALL 12" x 12" x 8" TEE
- 42 INSTALL 10" DCDA
- 43 INSTALL 8"x6" TAPPING
TEE & VALVE


SEE "CONSTRUCTION NOTES" ON
SHEETS C1.10, C1.11 AND C1.13
FOR STREETLIGHT CONSTRUCTION
INFORMATION

GENERAL NOTE: ALL UTILITY LINES SHALL BE BACKFILLED AND COMPACTED PER
CLARK COUNTY PUBLIC WORKS STANDARD DRAWING NOS. 405 & 406.

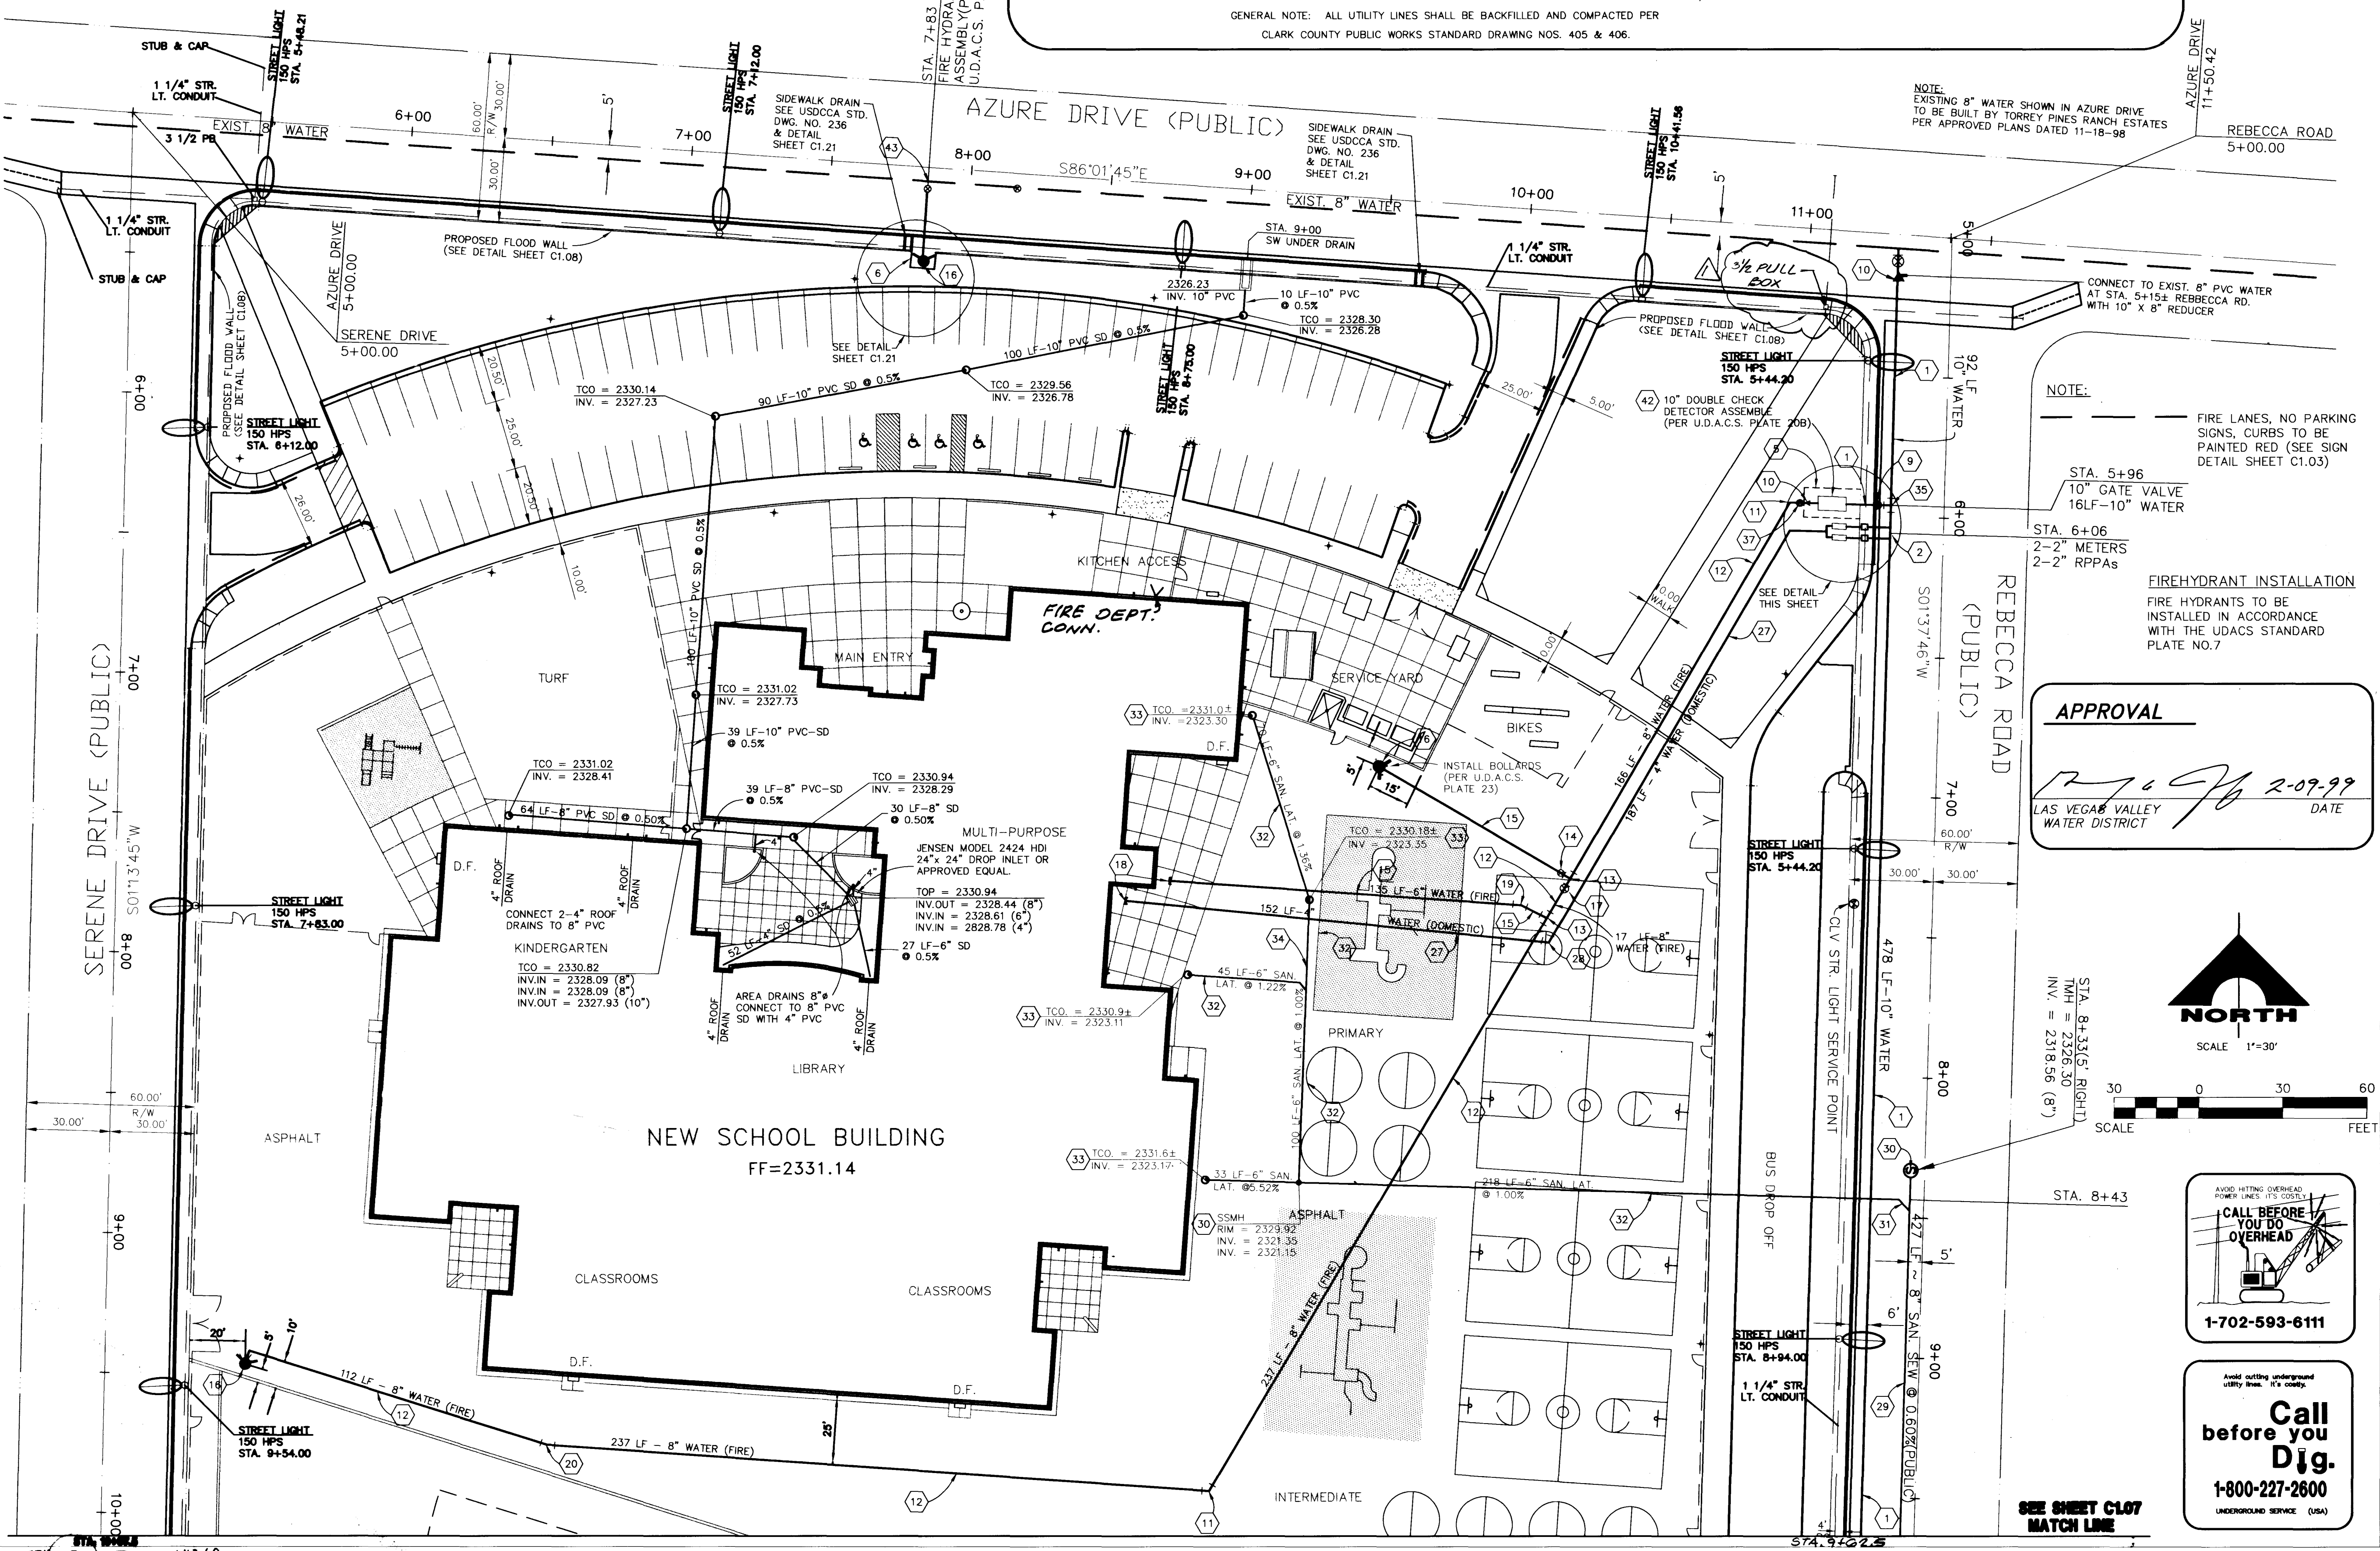[illegible]

DO NOT SCALE DRAWINGS

All designs, arrangements and plans indicated or presented by this drawing, as instruments of service, are owned by and the property of the ARCHITECTS. To alter these documents for any project by anyone other than the ARCHITECTS is strictly prohibited under NR 52. The plans and/or specifications shall be restricted to the original site for which they were prepared and publication thereof is expressly limited to such use. Reproduction, in whole or in part, without the written permission of the ARCHITECTS is prohibited. None of such designs, arrangements or plans shall be used by or disclosed to any person, firm, agency, or corporation without the written permission of the ARCHITECTS. The ARCHITECTS shall retain the right to alter these designs, arrangements or plans and specifications shall constitute prima facie evidence of acceptance of these restrictions.

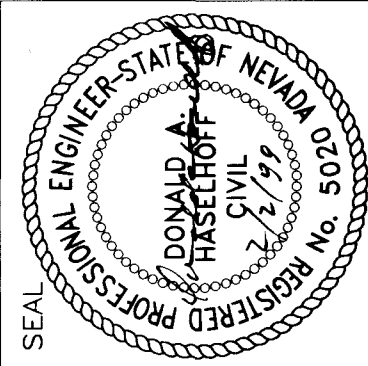

0350 PROJECT NO.	
0350 REVIEW	
APPROVED BY	
DATE	
DATE	
FORNOWN BY	
KIM SIMPSON	
DESIGNED BY	
BOB HERMAN	
SUBMITTAL	
AVE PROJECT NO.	
97224	

CLARK COUNTY SCHOOL DISTRICT


LAS VEGAS, NEVADA 89121

JOSEPH M. NEAL ELEMENTARY SCHOOL

SITE UTILITY PLAN I



JUMA ARCHITECTURE STUDIOS

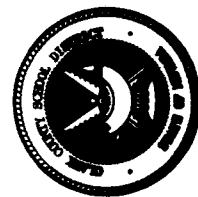

SHEET NO.

C1.06

6 OF 22
715-106

715-106

