


SUNSET HILLS PHASE II

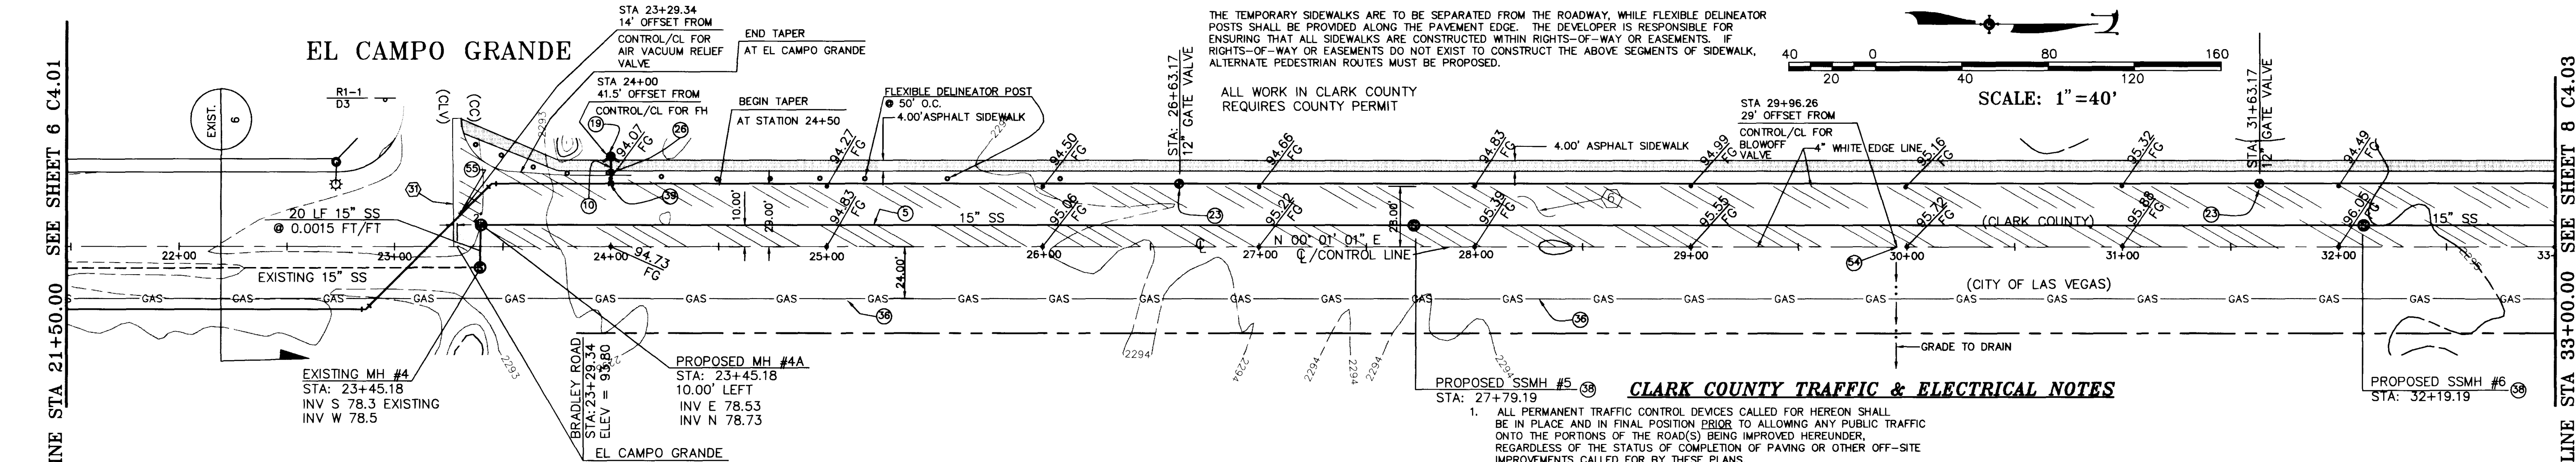

BRADLEY ROAD

SCALE = 1" = 40' HORIZONTAL
SCALE = 1" = 4' VERTICAL

CLARK COUNTY TRAFFIC & ELECTRICAL NOTES

- ALL PERMANENT TRAFFIC CONTROL DEVICES CALLED FOR HEREON SHALL BE IN PLACE AND IN FINAL POSITION PRIOR TO ALLOWING ANY PUBLIC TRAFFIC ONTO THE PORTIONS OF THE ROAD(S) BEING IMPROVED HEREUNDER. REGARDLESS OF THE STATUS OF COMPLETION OF PAVING OR OTHER OFF-SITE IMPROVEMENTS CALLED FOR BY THESE PLANS.
- BEFORE ANY WORK IS STARTED IN THE RIGHT-OF-WAY, THE CONTRACTOR SHALL INSTALL ALL ADVANCE WARNING SIGNS FOR THE CONSTRUCTION ZONE. THE CONTRACTOR SHALL INSTALL TEMPORARY GROUND MOUNTED STOP SIGNS AT ALL NEW STREET ENCROACHMENTS INTO EXISTING COUNTY STREETS IMMEDIATELY AFTER FIRST GRADING WORK IS ACCOMPLISHED, AND SHALL MAINTAIN SAID SIGNS UNTIL PERMANENT SIGNS ARE INSTALLED.
- ALL CONSTRUCTION SIGNING, BARRICADING AND PAVEMENT MARKINGS SHALL CONFORM TO THE NEVADA WORK ZONE TRAFFIC CONTROL HANDBOOK - 1986 AND TO THE MANUAL ON UNIFORM TRAFFIC CONTROL DEVICES, CURRENT EDITION.
- IF THE IMPROVEMENTS NECESSITATE THE OBLITERATION, TEMPORARY OBSTRUCTION, TEMPORARY REMOVAL, OR RELOCATION OF ANY EXISTING TRAFFIC PAVEMENT MARKING, SUCH PAVEMENT MARKING SHALL BE RESTORED OR REPLACED WITH LIKE MATERIALS TO THE SATISFACTION OF THE COUNTY TRAFFIC MANAGER.
- THE DEVELOPER SHALL BE RESPONSIBLE TO PROVIDE AND INSTALL ALL PERMANENT SIGNS SHOWN ON THE PLANS. STREET NAME SIGNS SHALL CONFORM IN THEIR ENTIRETY TO CLARK COUNTY STANDARDS. ALL OTHER SIGNS SHALL BE STANDARD SIZE UNLESS OTHERWISE SPECIFIED ON THE PLANS. ALL SIGN POSTS SHALL BE INSTALLED IN ACCORDANCE WITH CLARK COUNTY STANDARDS. ALL SIGNS SHALL USE TYPE III SHEETING.
- IF A PROPOSED STREET LIGHT STANDARD IS FIELD LOCATED TO WITHIN FIVE (5) FEET OF ANY SIGN SHOWN HEREON TO BE MOUNTED ON A SIGN POST, THEN CHANGE SIGN MOUNTING TO ONE ON THE STREETLIGHT STANDARD.
- PRIOR TO CONSTRUCTION, THE STREET SIGN CONTRACTOR SHALL OBTAIN STREET NAMES AND BLOCK NUMBERING FROM THE CURRENT PLANNING DIVISION OF THE DEPARTMENT OF COMPREHENSIVE PLANNING.
- ALL TRAFFIC SIGNAL POLE ASSEMBLIES, STEEL PEDESTALS FOR CABINETS, AND STREET LIGHT POLES SHALL BE GALVANIZED PER ASTM A.123.
- ALL STREET LIGHTING INSTALLATIONS EXCEPT AS NOTED ON THE STREET LIGHTING PLANS SHALL CONFORM TO THE IMPROVEMENT STANDARDS DEPARTMENT OF PUBLIC WORKS, CLARK COUNTY, NEVADA, AND THE UNIFORM STANDARD SPECIFICATIONS FOR PUBLIC WORKS CONSTRUCTION, OFF-SITE IMPROVEMENTS, CLARK COUNTY AREA, NEVADA, LATEST EDITION OF EACH.
- THE FOLLOWING CLARK COUNTY UNDERGROUND UTILITIES MAY BE LOCATED IN YOUR PROJECT AREA: STREET LIGHTING, TRAFFIC SIGNALS, LAS VEGAS AREA COMPUTER TRAFFIC SYSTEM (LVACTS) INTERCONNECT CABLE. YOU MUST CONTACT CLARK COUNTY TRAFFIC MANAGEMENT DIVISION, OPERATIONS UNIT AT 455-7511 FOR LOCATIONS AT LEAST 48 HOURS PRIOR TO WORKING IN THE AREA. CLARK COUNTY IS NOT A MEMBER OF CALL BEFORE YOU DIG (UNDERGROUND SERVICE ALERT), AND A CALL TO THAT ORGANIZATION DOES NOT RELIEVE YOU OF LIABILITY FOR CLARK COUNTY FACILITIES.
- LVACTS INTERCONNECT CABLE POLICY IS IN EFFECT. INTERCONNECT CABLE MUST BE MAINTAINED AT ALL TIMES. DEVELOPER/CONTRACTOR SHALL PROVIDE TEMPORARY OVERHEAD INTERCONNECT CABLE, WHILE PERMANENT CABLE IS BEING RELOCATED. TEMPORARY AERIAL INSTALLATION MUST BE ACCEPTABLE TO THE COUNTY TRAFFIC MANAGER AND TO LVACTS. ANY DAMAGE TO THIS CABLE IS DEEMED AN EMERGENCY BY LVACTS. CITY OF LAS VEGAS, CLARK COUNTY AND NDOT AND MUST BE REPAIRED IMMEDIATELY TO LVACTS' ACCEPTANCE. \$2500 PER DAY DAMAGES MAY BE ASSESSED AFTER 24 HOURS HAS ELAPSED FROM TIME OF BREAK OR DAMAGE.
- ALL NEW OR REPLACEMENT TRAFFIC SIGNAL LOOPS SHALL BE INSTALLED USING CABLE-IN-DUCT WIRING, SHALL HAVE INDEPENDENT LEAD-IN WIRES FOR EACH LOOP FROM THE CONTROLLER TO THE PULL-BOX, AND EACH LEAD-IN SHALL BE INDIVIDUALLY TAGGED.
- TRAFFIC SIGNAL PEDESTRIAN HEADS SHALL BE THE INCANDESCENT TYPE.
- ELECTRICAL POWER SERVICE POINT LOCATION(S) FOR STREET LIGHTING AND TRAFFIC SIGNALS MUST BE INDICATED ON THE PLANS. IF CONNECTING TO AN EXISTING CIRCUIT, INDICATE LOCATION OF EXISTING SERVICE POINT FOR EACH CIRCUIT.
- WHEN STREET LIGHTS ARE TO BE CONNECTED TO AN EXISTING CIRCUIT, THE ENGINEER MUST CERTIFY THAT THE EXISTING CIRCUIT IS CAPABLE OF HANDLING THE ADDITIONAL CIRCUIT LOAD.
- CLARK COUNTY RESERVES THE RIGHT TO REJECT STREET LIGHT AND TRAFFIC SIGNAL POLES AND ASSEMBLIES WHICH HAVE A "STRIPED" APPEARANCE.
- PRIOR TO BEGINNING OF CONSTRUCTION, MODIFICATION, OR RELOCATION OF ANY TRAFFIC SIGNAL SYSTEM, WRITTEN NOTICE SHALL BE SUBMITTED TO THE CLARK COUNTY TRAFFIC MANAGEMENT DIVISION OF THE DATE THAT WORK WILL BEGIN.
- THREE (3) NORMAL WORKING DAYS PRIOR TO TURN-ON OR COMPLETION OF MODIFICATION(S) TO A TRAFFIC SIGNAL SYSTEM, WRITTEN NOTICE SHALL BE SUBMITTED TO THE CLARK COUNTY TRAFFIC MANAGEMENT DIVISION THAT WORK IS BEING COMPLETED AND THE PROPOSED DATE OF COMPLETION.
- THIS SET OF PLANS ARE CERTIFIED TO CONFORM TO THE REQUIREMENTS OF THE TRAFFIC STUDY ACCEPTANCE LETTER, NO TRAFFIC STUDY REQUIRED.

Margaret C. Brake
BY: MARGARET C. BRAKE DATE 9-9-96


CONSTRUCTION NOTES

- CONSTRUCT BRADLEY ROAD STA: 23+29.34 TO STA: 36+63.17 PER DETAIL OF BRADLEY ROAD THIS SHEET
- SAWCUT LINE

UTILITY NOTE

UTILITY LOCATIONS SHOWN HEREON ARE APPROXIMATE ONLY. IT SHALL BE THE CONTRACTOR'S RESPONSIBILITY TO DETERMINE THE EXACT HORIZONTAL AND VERTICAL LOCATION OF ALL EXISTING UNDERGROUND UTILITIES PRIOR TO COMMENCING CONSTRUCTION. NO REPRESENTATION IS MADE THAT ALL EXISTING UTILITIES ARE SHOWN HEREON. THE ENGINEER ASSUMES NO RESPONSIBILITY FOR UTILITIES NOT SHOWN OR UTILITIES NOT SHOWN IN THEIR PROPER LOCATION.


Avoid cutting underground utility lines. It's costly.
Call before you Dig
1-800-227-2600
UNDERGROUND SERVICE (USA)

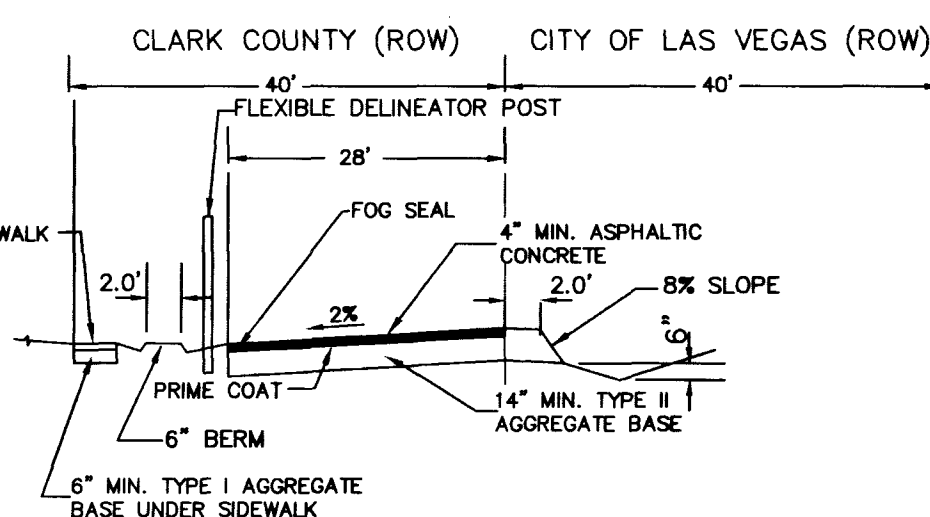

TYPICAL DETAIL OF BRADLEY ROAD
BETWEEN STATIONS 23+29.34 AND 36+58.99
(CLARK COUNTY JURISDICTION)
N.T.S.


UTILITY NOTES:

- INSTALL 15" SANITARY SEWER LINE
- INSTALL 6" WATER MAIN AWWA C-900 CLASS 150
- INSTALL FIRE HYDRANT PER UDACS PLATE NO 7
- INSTALL 12" WATER MAIN AWWA C-900 CLASS 150
- INSTALL 12" GATE VALVE
- INSTALL 6" GATE VALVE
- 4" STEEL GAS LINE INSTALLED BY SW GAS
- INSTALL 48" SANITARY SEWER MANHOLE PER DCS STD DWG SD-1
- INSTALL 12" X 6" CAST IRON TEE W/THRUST BLOCK
- INSTALL 12" CAST IRON TEE W/THRUST BLOCK
- INSTALL 2" BLOWOFF VALVE PER UDACS PLATE 4
- INSTALL 2" AIR VACUUM RELIEF VALVE PER UDACS PLATE 37B

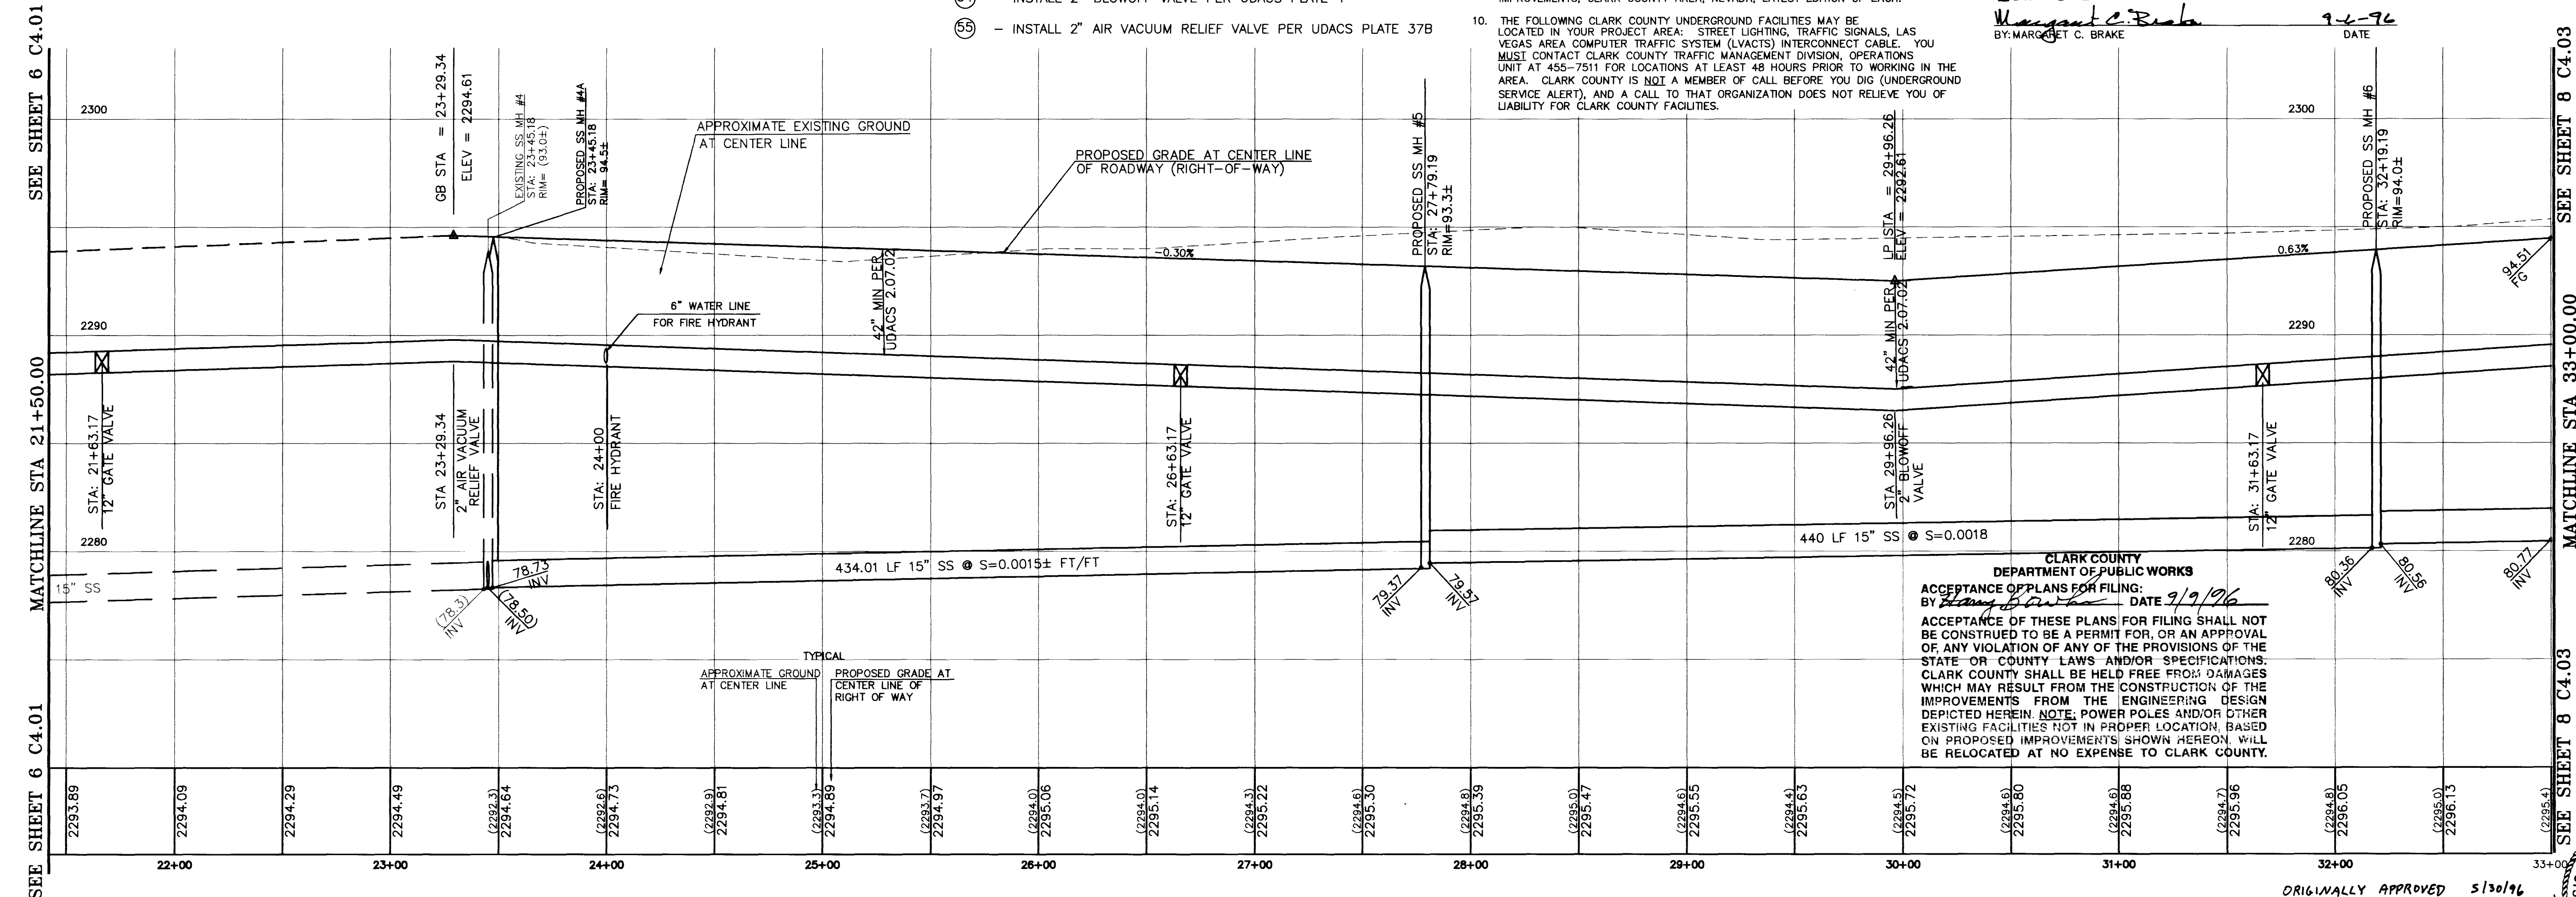

CLARK COUNTY
DEPARTMENT OF PUBLIC WORKS
ACCEPTANCE OF PLANS FOR FILING:
BY: Margaret C. Brake DATE 9/9/96
ACCEPTANCE OF THESE PLANS FOR FILING SHALL NOT BE CONSTRUED TO BE A PERMIT FOR, OR AN APPROVAL OF ANY VIOLATION OF ANY OF THE PROVISIONS OF THE STATE OR COUNTY LAWS AND/OR SPECIFICATIONS. CLARK COUNTY SHALL BE HELD FREE FROM DAMAGES WHICH MAY RESULT FROM THE CONSTRUCTION OF THE IMPROVEMENTS FROM THE ENGINEERING DESIGN DEPICTED HEREIN. NOTE: POWER POLES AND/OR OTHER EXISTING FACILITIES NOT IN PROPER LOCATION, BASED ON PROPOSED IMPROVEMENTS SHOWN HEREON, WILL BE RELOCATED AT NO EXPENSE TO CLARK COUNTY.

ORIGINALLY APPROVED 5/30/96
J. V. V. D. DATE 9/6/96

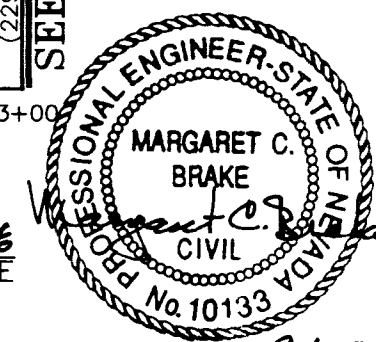

DESIGNED BY: R.D.C.		DRAWN BY: C.S.S.		CHECKED BY: M.C.B.	
APR. 15, 1996		APR. 15, 1996		APR. 15, 1996	
LIED MIDDLE SCHOOL		CCSD# 0844		PLAN AND PROFILE BRADLEY ROAD	
LAS VEGAS		CLARK COUNTY		CLARK COUNTY	
SHEET 7		OF 23		JOB NO. 71074	
SCALE 1" = 40'		VERT. 1" = 4'		P.L. 10133	

SUNNY HILLS PHASE II



CONSTRUCTION NOTES
 1. ALL CONSTRUCTION SHALL BE IN ACCORDANCE WITH THE CITY OF LOS ANGELES, CALIFORNIA, STANDARD SPECIFICATIONS FOR HIGHWAYS AND STREETS, LATEST EDITION.
 2. ALL CONSTRUCTION SHALL BE IN ACCORDANCE WITH THE CITY OF LOS ANGELES, CALIFORNIA, STANDARD SPECIFICATIONS FOR UTILITIES, LATEST EDITION.

UTILITY NOTE




BRANLEY ROAD

WIDE - 7'-0" SIDEWALK
 ROAD - 7'-0" SIDEWALK

BRANLEY ROAD

1. GRADE OF BRANLEY ROAD TO BE
2. GRADE OF BRANLEY ROAD TO BE
3. GRADE OF BRANLEY ROAD TO BE
100. GRADE OF BRANLEY ROAD TO BE

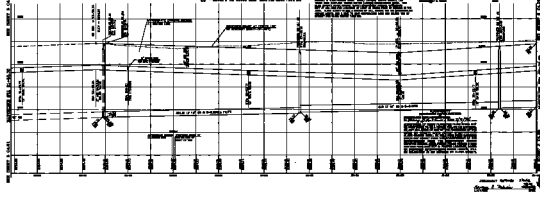

SUMMARY
 PROJECT: SUNNY HILLS PHASE II
 DRAWN BY: [Name]
 CHECKED BY: [Name]
 DATE: [Date]

REVISIONS
 NO. DESCRIPTION
 1. [Description]
 2. [Description]
 3. [Description]

APPROVED
 [Signature]
 [Title]
 [Date]

APPROVED
 [Signature]
 [Title]
 [Date]

APPROVED
 [Signature]
 [Title]
 [Date]