



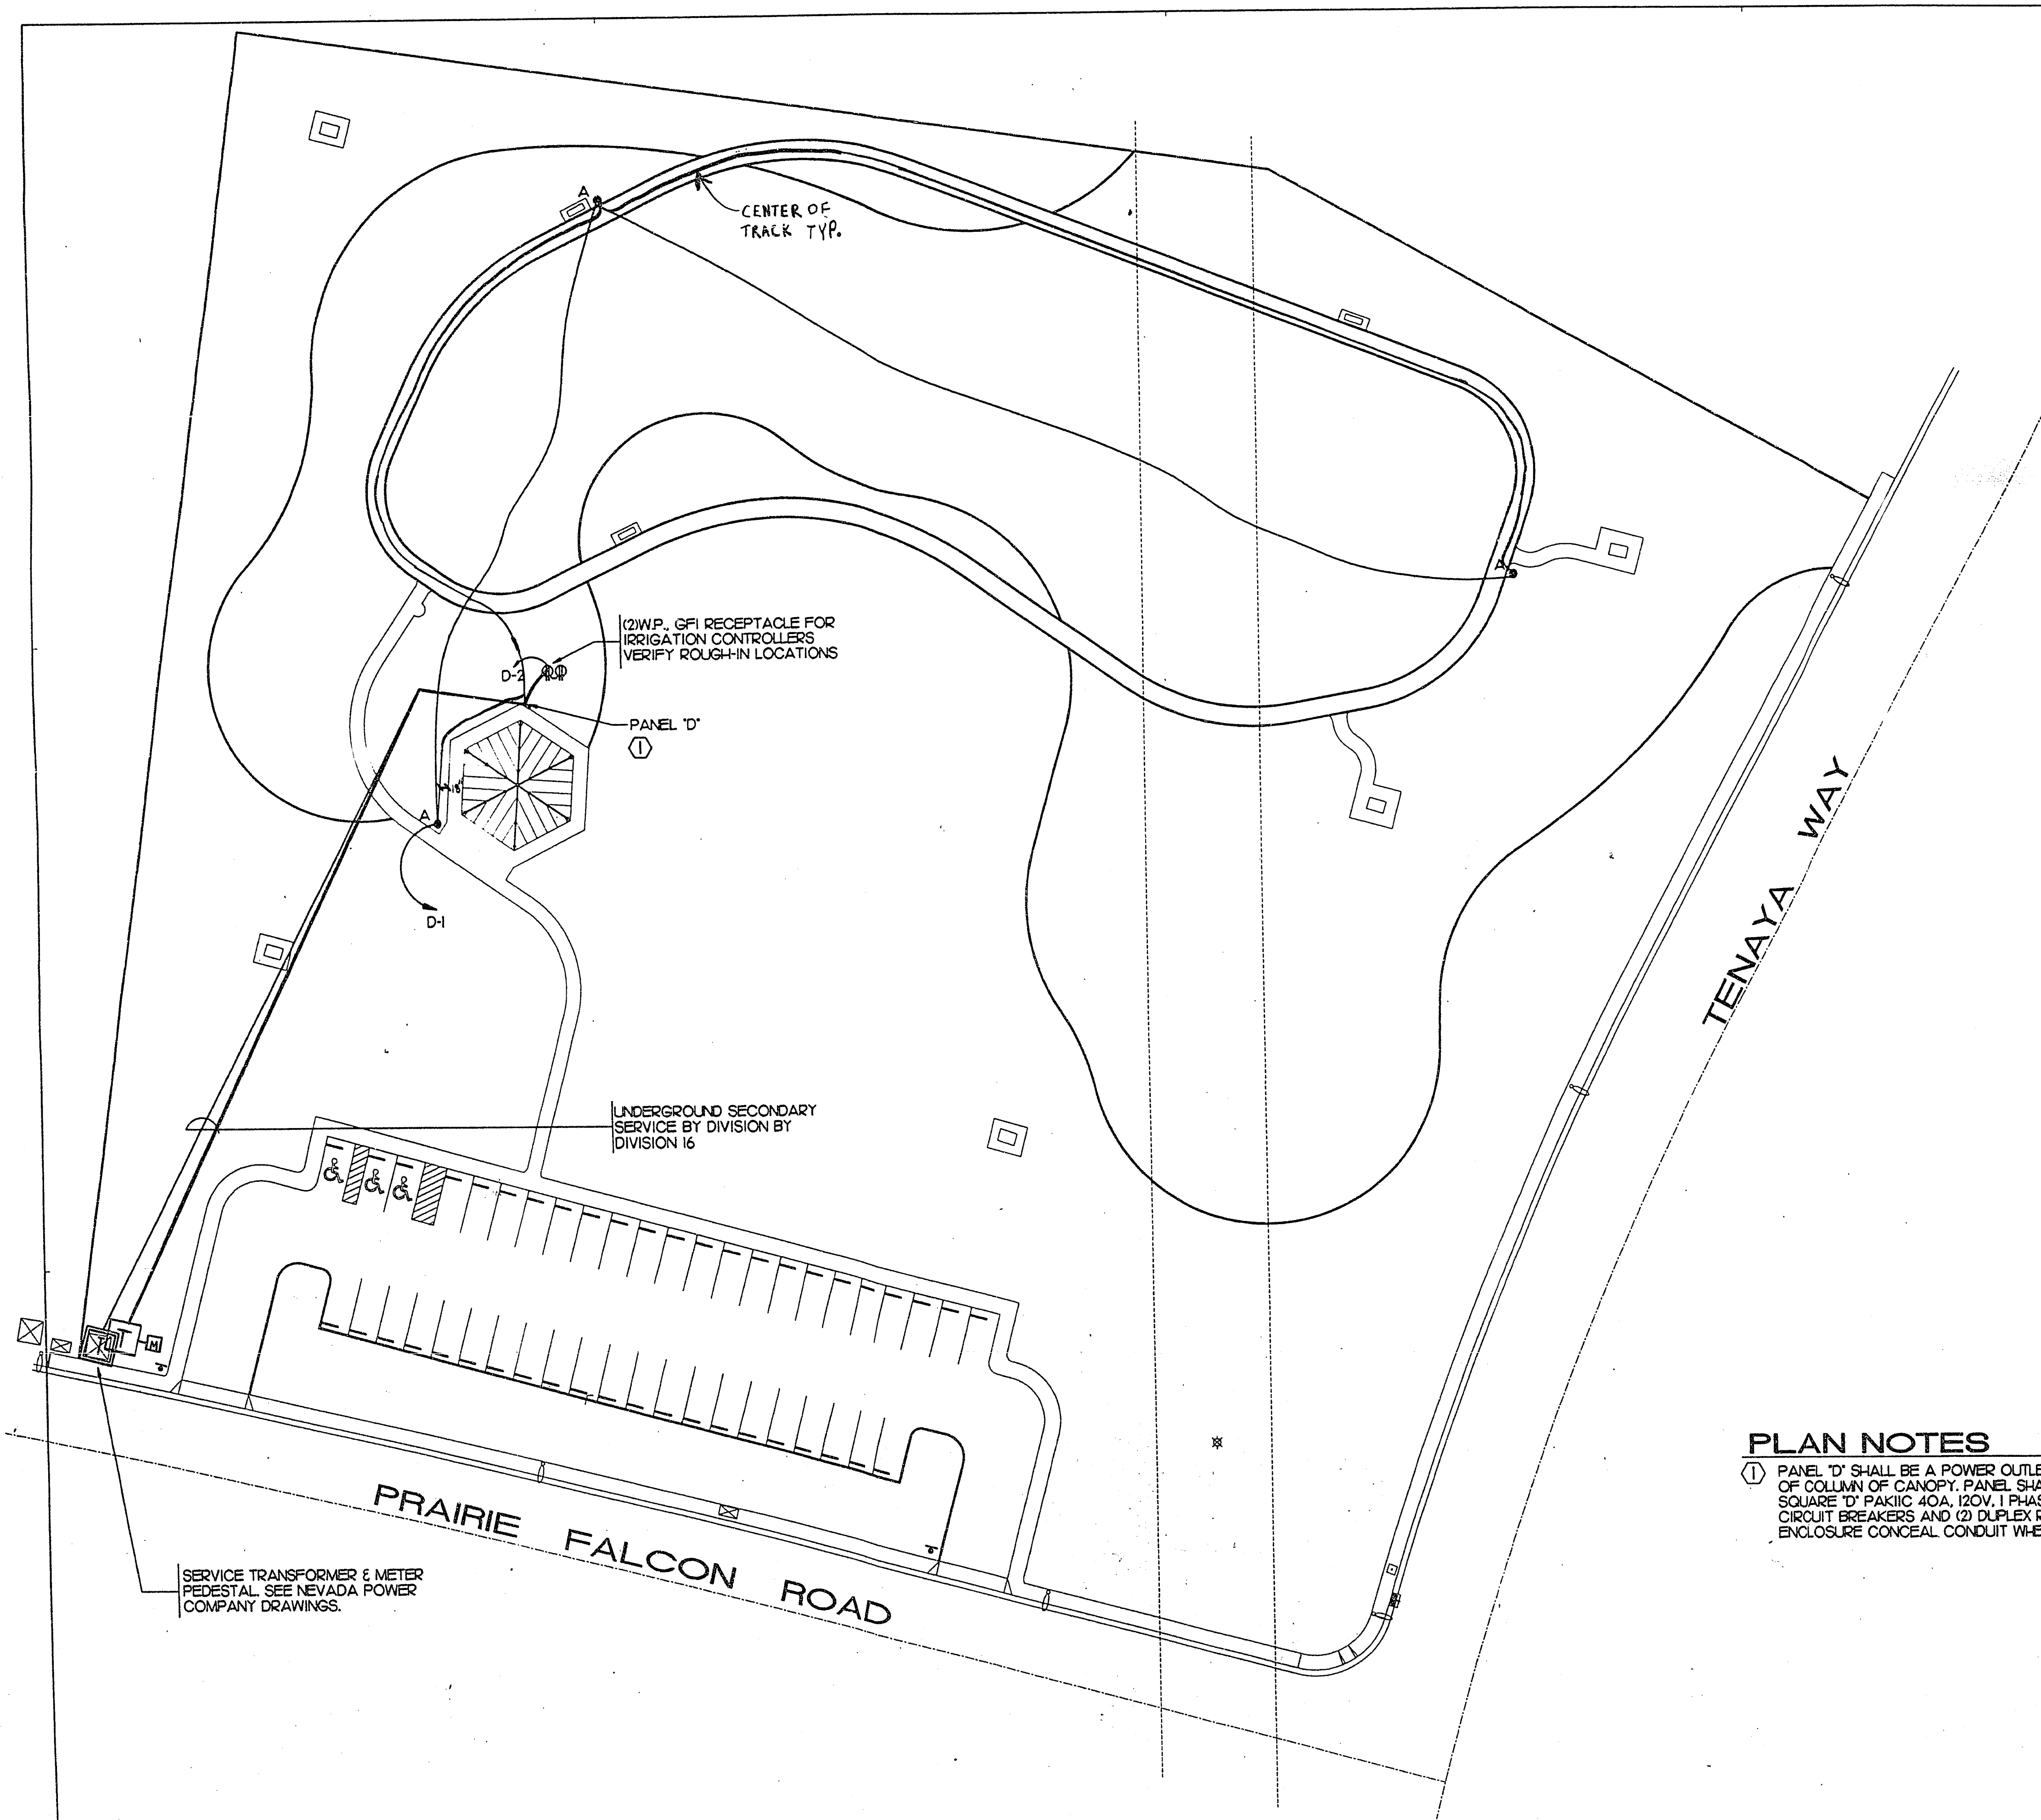

ELECTRICAL SITE PLAN WEST SIDE

SCALE: 1" = 30'

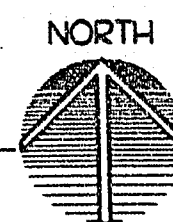

PLAN NOTES

- ① PANEL 'D' SHALL BE A POWER OUTLET PANEL ON BACK SIDE OF COLUMN OF CANOPY. PANEL SHALL BE SQUARE 'D' PAKIIC 40A, 120V, 1 PHASE WITH (2) 20A/1P CIRCUIT BREAKERS AND (2) DUPLEX RECEPTACLES, NEMA 3R ENCLOSURE CONCEAL CONDUIT WHEREVER POSSIBLE.

REVISIONS			
REV	DESCRIPTION	DATE	BY
© DOMINGO CAMBEIRO CORPORATION 1994			

DO NOT SCALE DRAWINGS


All designs, arrangements and plans indicated or presented by this drawing, as instruments of service, are owned by and the property of DOMINGO CAMBEIRO CORPORATION. The plans and/or specifications shall be restricted to the original site for which they were prepared and publication therefore is expressly limited to such use. Reproduction, publication or reuse by any method in whole or in part is prohibited. None of such designs, arrangements or plans shall be used by or disclosed to any person, firm, agency, or corporation without the written permission of DOMINGO CAMBEIRO CORPORATION. Visual contact with these plans and specifications shall constitute prima facie evidence of acceptance of these restrictions.

SEAL

DRAWN BY
JOEL E.
CHECKED BY
R.G.K.
ISSUED DATE
FEBRUARY 1994

ELECTRICAL
SITE PLAN
WEST SIDE

PROJECT
LAS VEGAS TECHNOLOGY
CENTER
OPEN SPACES AND ENTRY FEATURES, PHASE II AND III

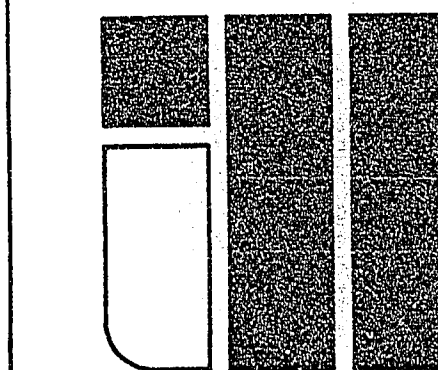

Domingo Cambeiro Corporation

ARCHITECTURE • ENGINEERING • PLANNING • INTERIORS
LAS VEGAS, NEVADA 89121-3805 (702) 732-0084
3555 PECOS-MCLEOD IC.

SHEET NO.

E2.02

JOB NO. 530-V1J
FILE NO. P:\3027\3027E22 10/01/93 15:37

"AS-BUILT"

20-63