


SECTION
NOT TO SCALE

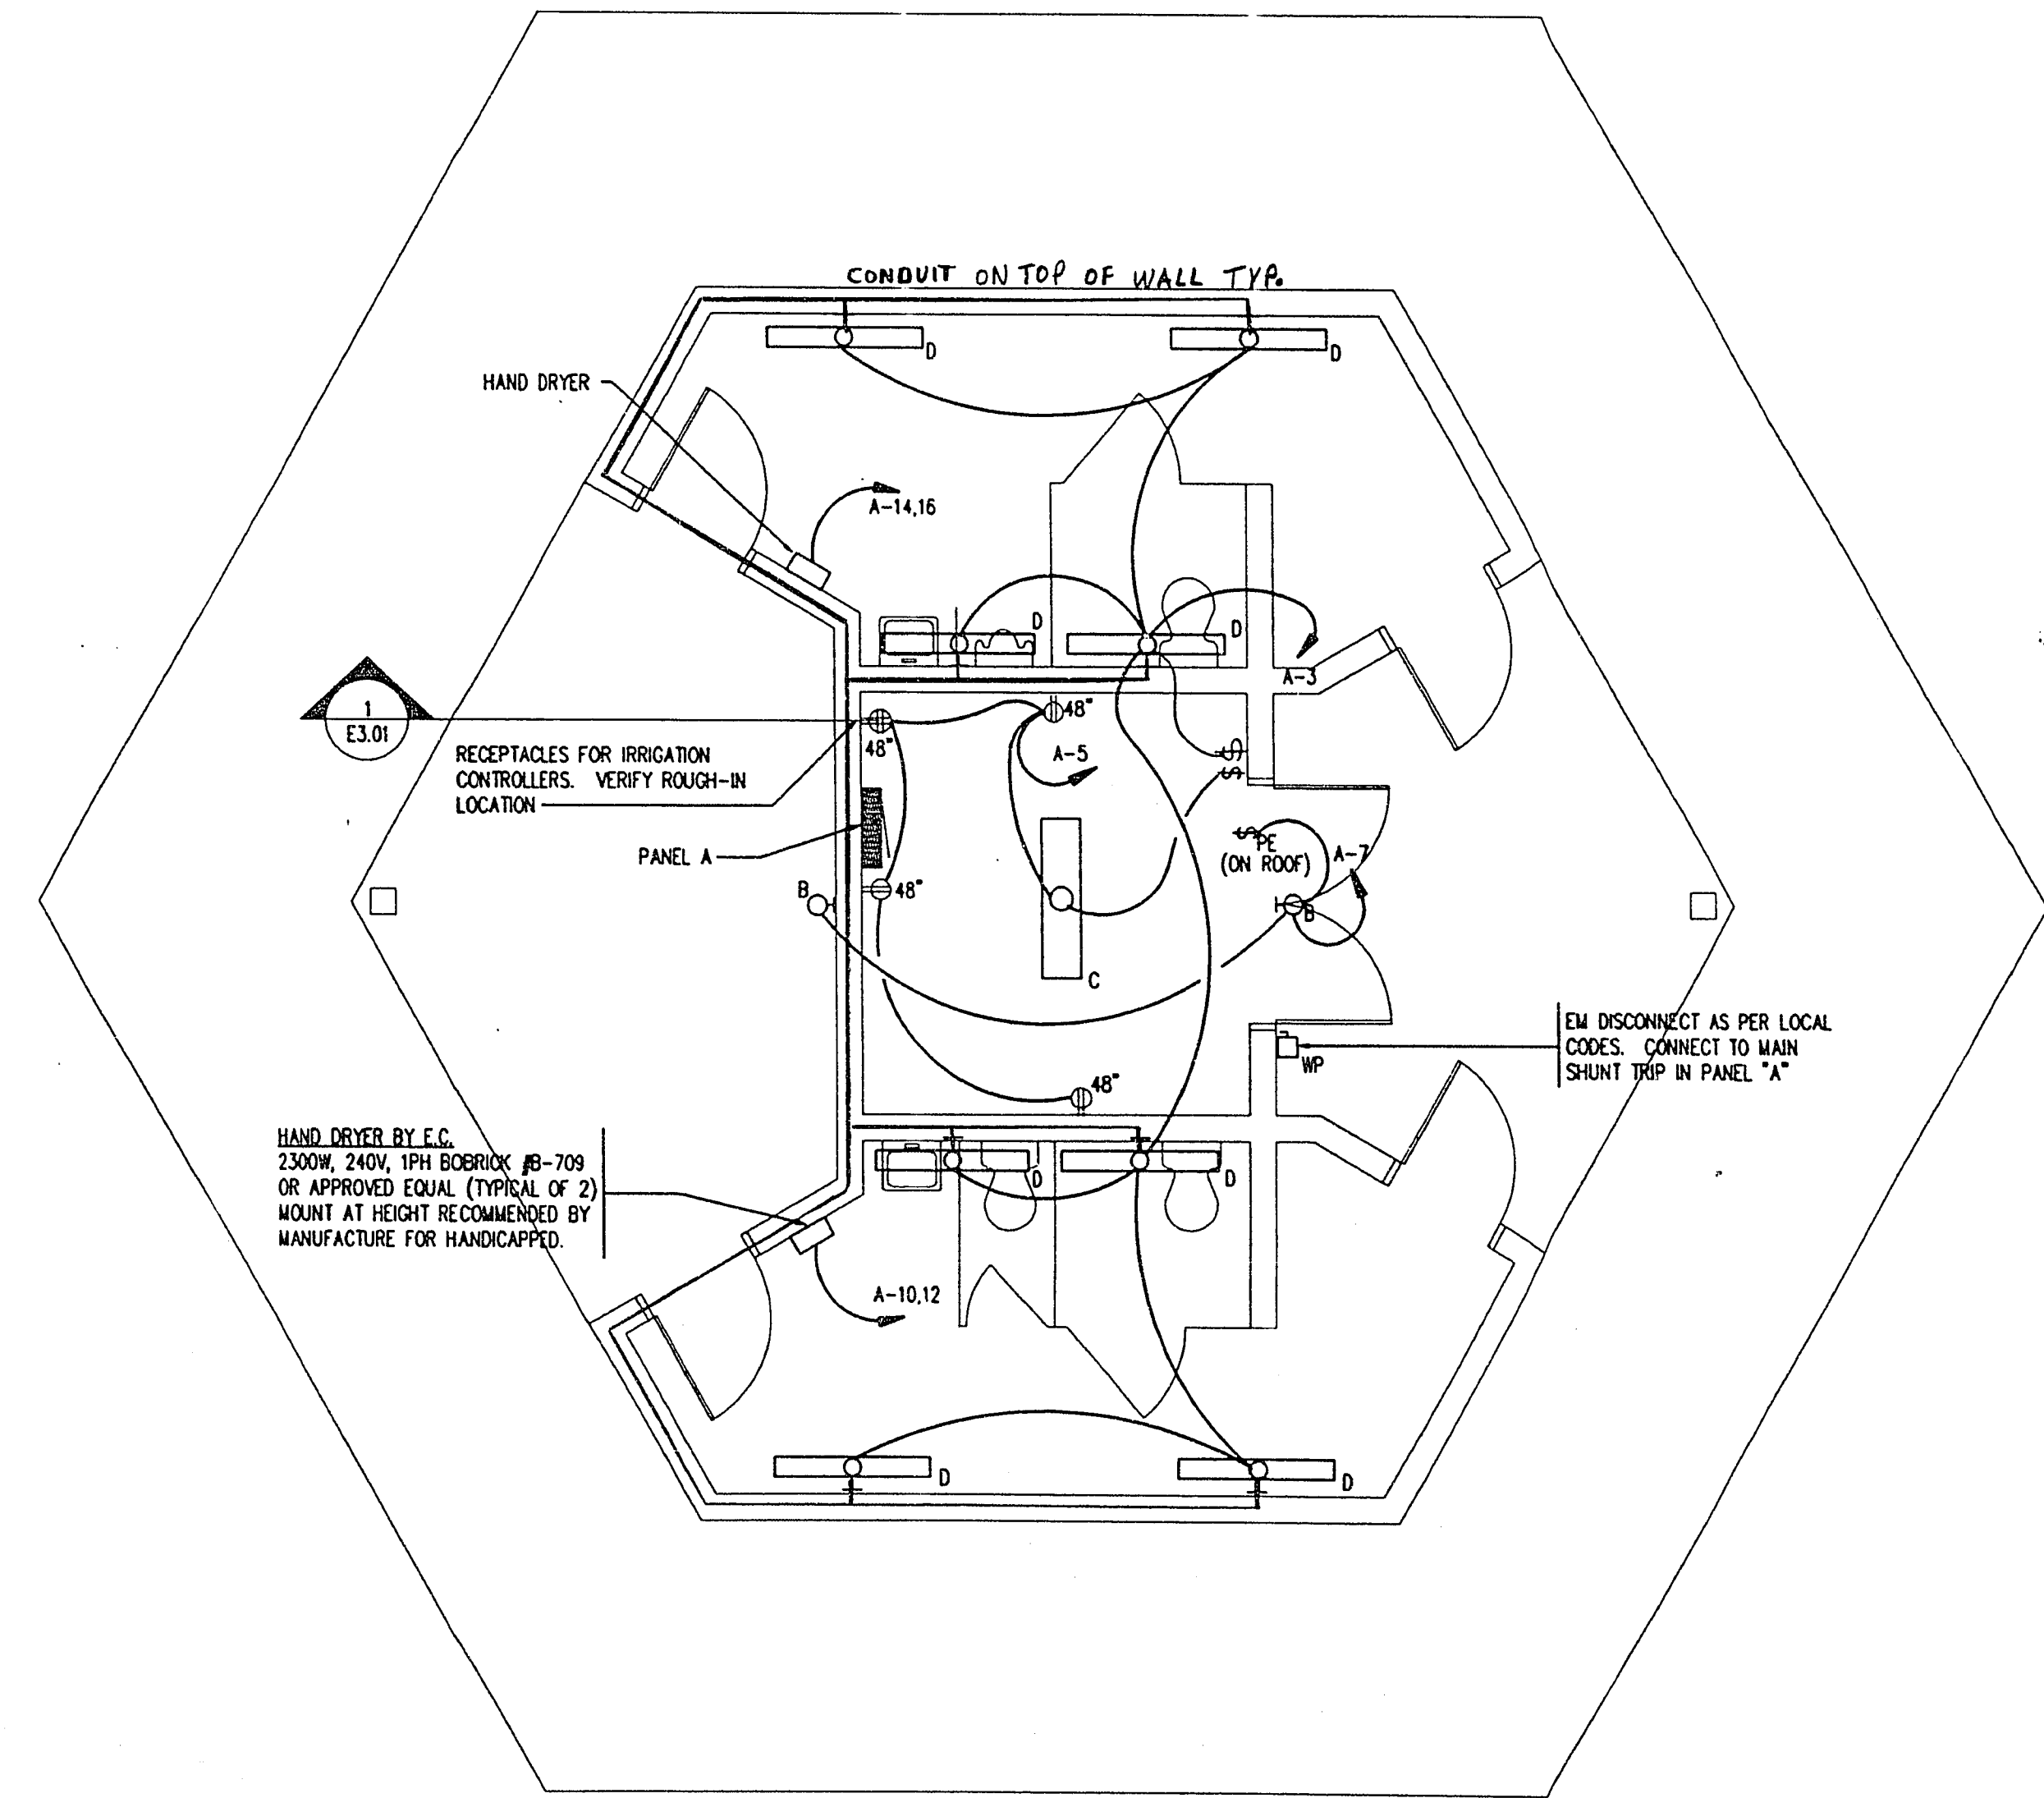

RESTROOM ELECTRICAL PLAN
SCALE: 1/4" = 1'-0"

REVISIONS			
REV	DESCRIPTION	DATE	BY

© DOMINGO CAMBEIRO CORPORATION 1994

DO NOT SCALE DRAWINGS

All designs, arrangements and plans indicated or presented by this drawing, as instruments of service, are owned by and the property of DOMINGO CAMBEIRO CORPORATION. The plans and/or specifications shall be restricted to the original site for which they were prepared and publication therefore is expressly limited to such use. Reproduction, publication or re-use by any method in whole or in part, is prohibited. None of such designs, arrangements or plans shall be used by or disclosed to any person, firm, agency, or corporation without the written permission of DOMINGO CAMBEIRO CORPORATION. Visual contact with these plans and specifications shall constitute prima facie evidence of acceptance of these restrictions.

SEAL
DRAWN BY
JOEL E.
CHECKED BY
R.G.K.
ISSUED DATE
FEBRUARY 1994

RESTROOM ELECTRICAL PLAN

PROJECT
LAS VEGAS TECHNOLOGY CENTER
OPEN SPACES AND ENTRY FEATURES, PHASE II AND III

Domingo Cambeiro Corporation
ARCHITECTURE • ENGINEERING • PLANNING • INTERIORS
3555 PECOS—MCLEOD IC. LAS VEGAS, NEVADA 89121—3805 (702) 732—0084

SHEET NO.	E3.01
JOB NO.	530-VUJ
FILE NO.	P:103027/03027231 10/01/93 15.31

"AS-BUILT"