


Avoid cutting underground utility lines. It's costly.
Call before you Dig
1-800-227-2600

Avoid cutting underground utility lines. It's costly.
Call before you Overhead
1-702-593-6111

SEWER CONSTRUCTION NOTES

1. INSTALL 8" PVC SANITARY SEWER LINE
2. INSTALL 48" SANITARY SEWER MANHOLE PER DESIGN AND CONSTRUCTION STANDARDS FOR WASTEWATER COLLECTION SYSTEMS PLATE SD-1
3. INSTALL 8" CAP



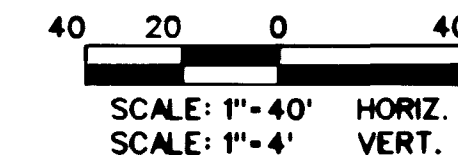


BASIS OF BEARING

NORTH 00°15'13" EAST, BEING THE BEARING OF THE EAST LINE OF THE NORTHEAST QUARTER (NE 1/4) OF THE NORTHEAST QUARTER (NE 1/4) OF THE NORTHEAST QUARTER (NE 1/4) OF SECTION 8, TOWNSHIP 19, SOUTH, RANGE 60, EAST, M.D.M. CLARK COUNTY, NEVADA AS SHOWN ON THE MAP IN FILE 87 OF SURVEYS, PAGE 83, OFFICIAL RECORDS OF CLARK COUNTY, NEVADA.

BENCHMARK

C.L.V. BENCHMARK: L.V.90-BHES
BLM BRASS CAP AT THE INTERSECTION OF DURANGO DRIVE AND IRON MOUNTAIN ROAD
NAVD 1988 ELEV 771.9689 METERS (2532.70 FEET)

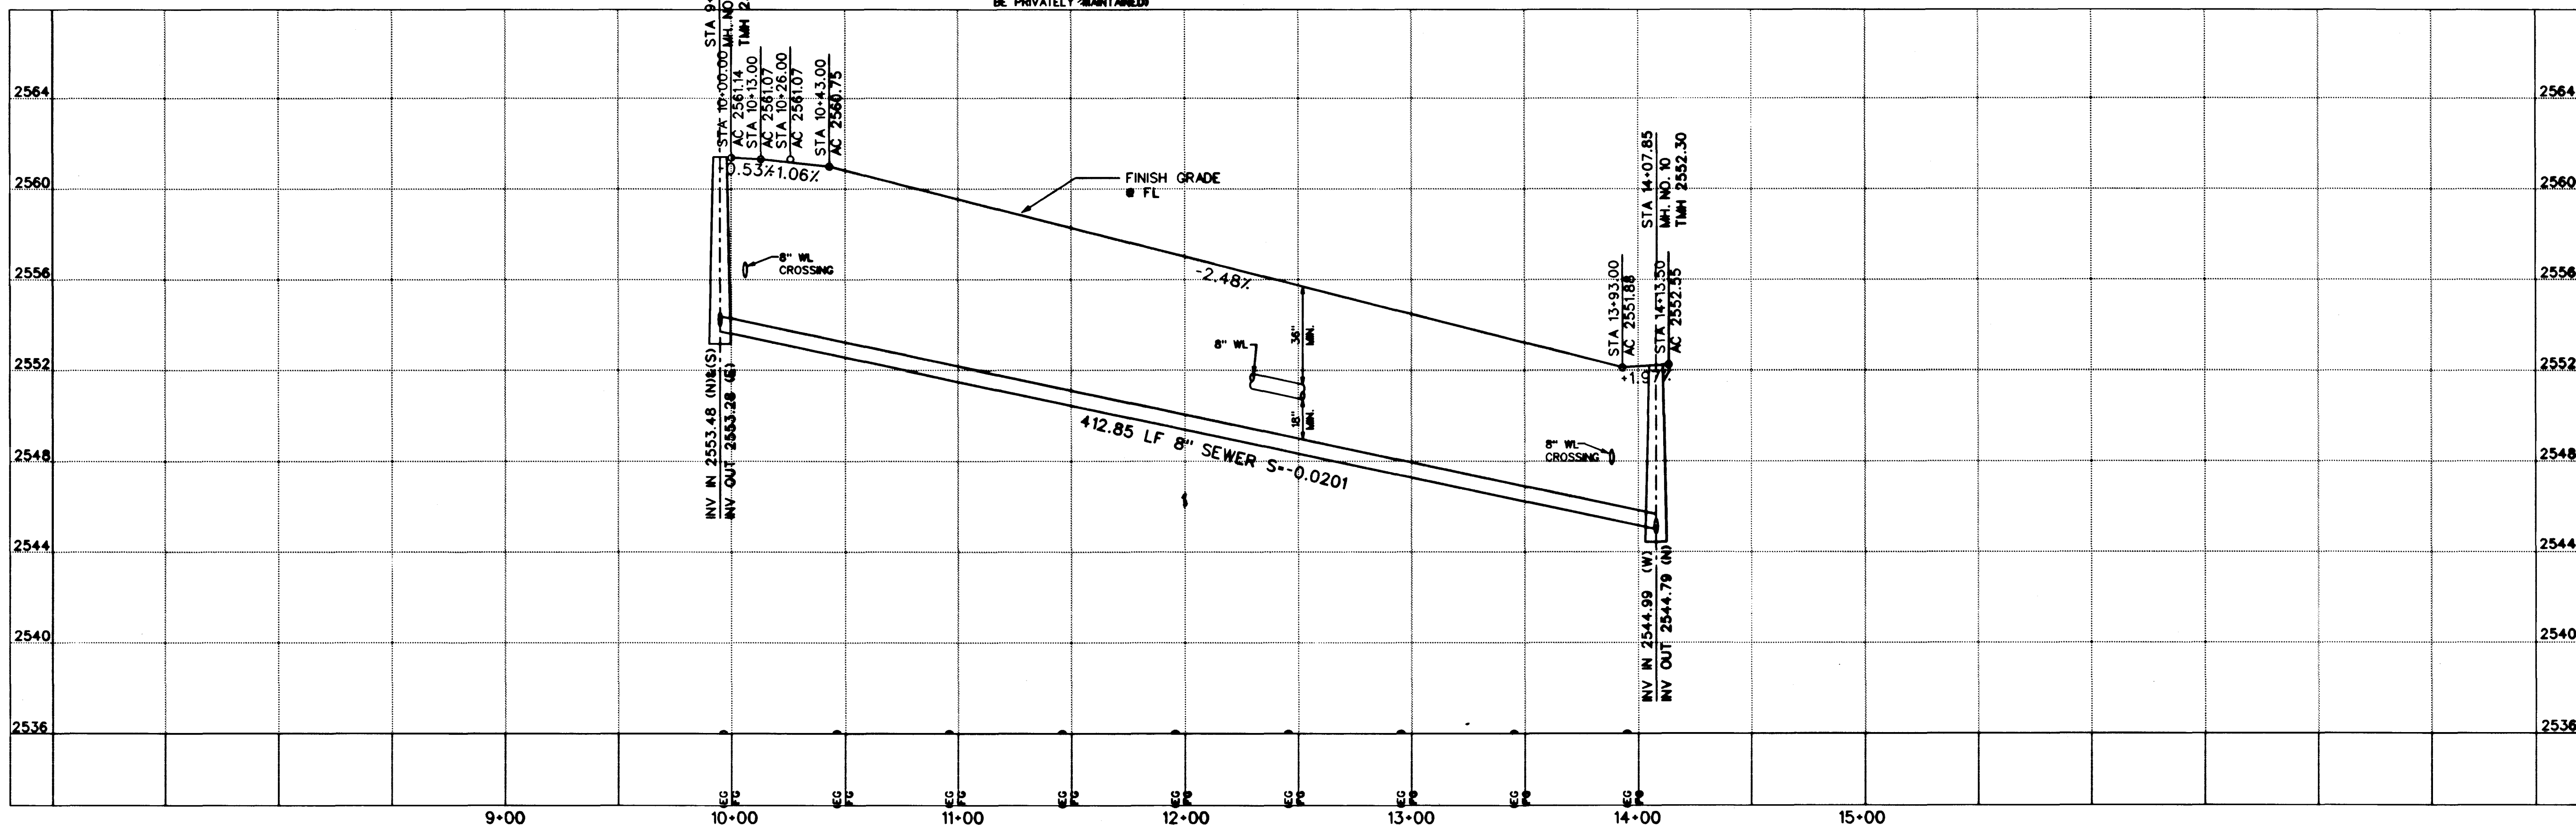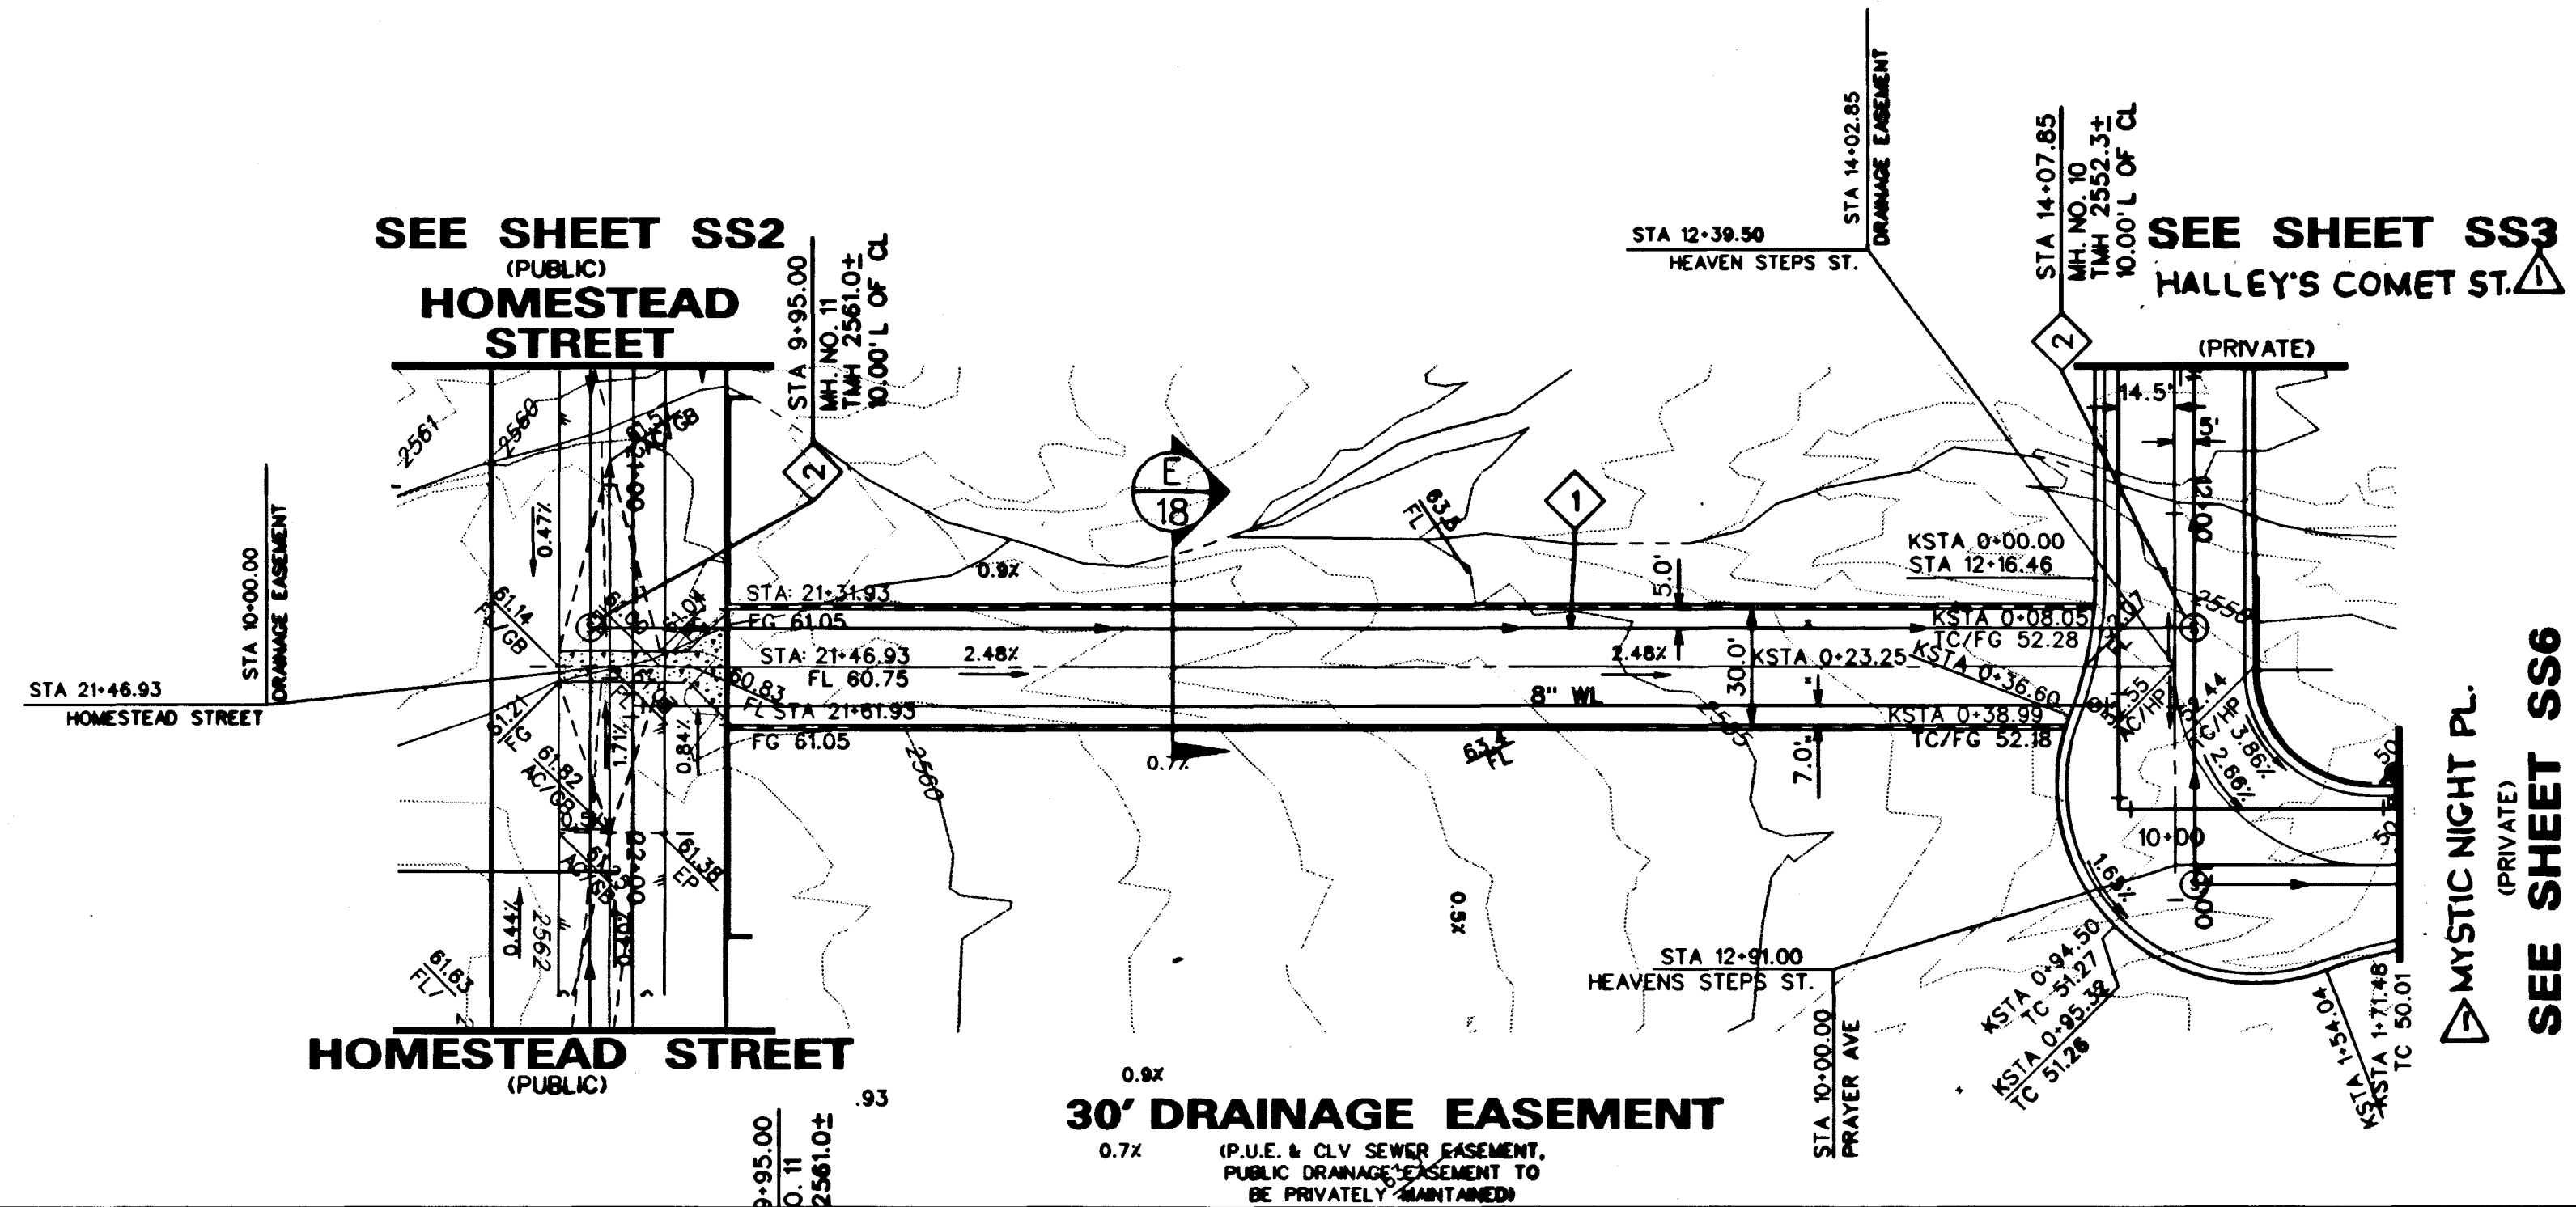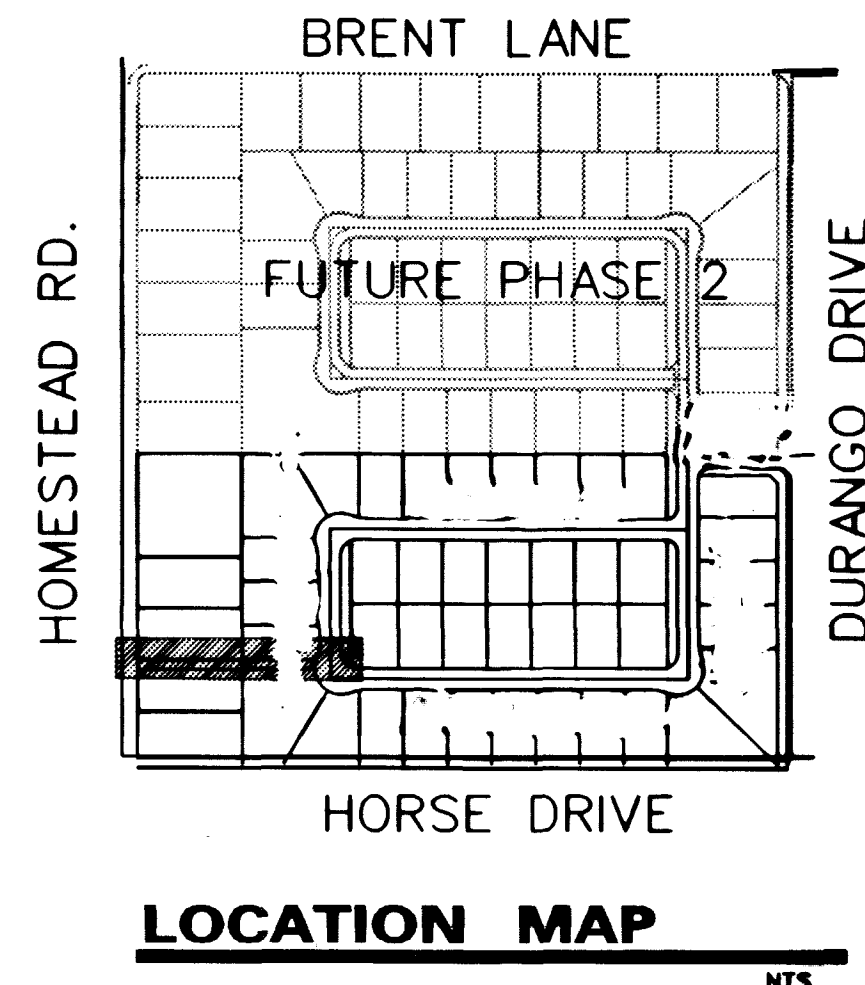


RICHMOND AMERICAN HOMES OF NEVADA INC.
7280 WEST PEAK STE. 22
LAS VEGAS, NV 89108
(702) 240-8600

PLAN AND PROFILE
DRAINAGE EASEMENT
STA 10+05 TO 12+29.50

MYSTIC VALLEY
PHASE I

DRAWN BY: G. HOWELL, W. KIM 11/4/98
DESIGNED BY: E. SERRANO, M. BELEN 11/4/98
CHECKED BY: J. W. LELAND 4/26/99
PROJECT NO: 98-9031-03
SCALE: 1"=40' HORIZ.
1"=4' VERT.

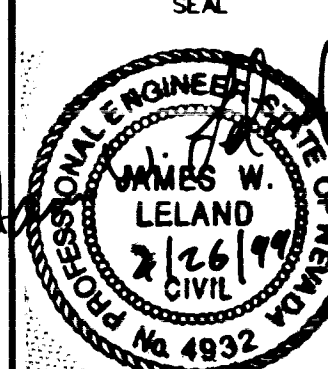

SHEET
SS7
17 OF 18 SHEETS
DRAWING NO.
1074-4599-1

Call before
you Dig
1-800-227-2400

Call before
you Overhead
1-702-383-5277

HEAVY CONSTRUCTION NOTED

- * SERIAL OF THE SUBJECT'S BIRTH OR
 * SERIAL OF THE SUBJECT'S SOCIAL SECURITY
 * SERIAL OF THE SUBJECT'S MARITAL STATUS



BASIS OF DRAWING

While neither field nor weathers are the only cause of the observed trends in the US, the observed trends in the US are not the only cause of the observed trends in the US.

ENTRANCE EXAMINER

1. The first step is to identify the problem or question that needs to be answered. This involves understanding the context and the specific requirements of the task.

