


Avoid cutting underground utility lines. It's costly.
Call before you Dig
1-800-227-2600

Avoid cutting underground utility lines. It's costly.
Call before you Overhead
1-702-593-6111

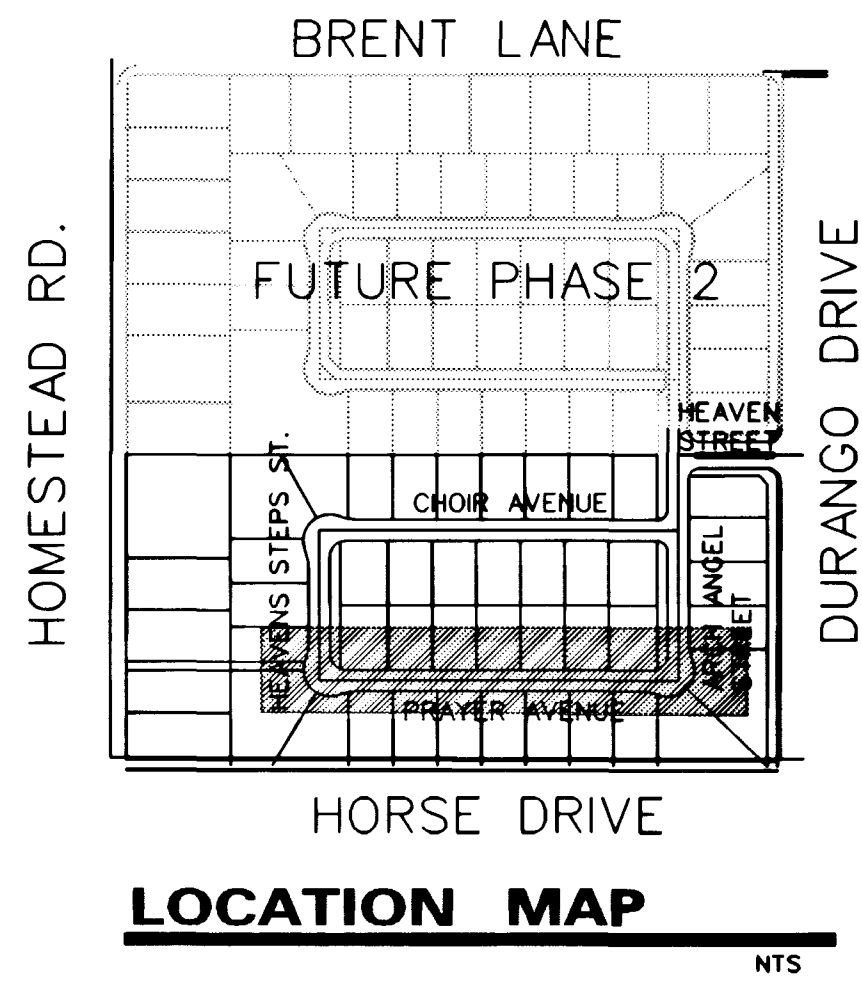

SEWER CONSTRUCTION NOTES

1. INSTALL 8" PVC SANITARY SEWER LINE
2. INSTALL 48" SANITARY SEWER MANHOLE PER DESIGN AND CONSTRUCTION STANDARDS FOR WASTEWATER COLLECTION SYSTEMS PLATE SD-1
3. INSTALL 8" CAP

40 20 0 40



SCALE: 1"=40' HORIZ.
SCALE: 1"=4' VERT.

BASIS OF BEARING

NORTH 00°15'13" EAST, BEING THE BEARING OF THE EAST LINE OF THE NORTHEAST QUARTER (NE 1/4) OF THE NORTHEAST QUARTER (NE 1/4) OF THE NORTHEAST QUARTER (NE 1/4) OF SECTION 8, TOWNSHIP 19 SOUTH, RANGE 60 EAST, M.D.M. CLARK COUNTY, NEVADA AS SHOWN ON THE MAP IN FILE 87 OF SURVEYS, PAGE 83, OFFICIAL RECORDS OF CLARK COUNTY, NEVADA.

BENCHMARK

C.L.V. BENCHMARK: 1LV90-BNES
BLM BRASS CAP AT THE INTERSECTION OF DURANGO DRIVE AND IRON MOUNTAIN ROAD
NAVD 1988 ELEV 771.9689 METERS (2532.70 FEET)

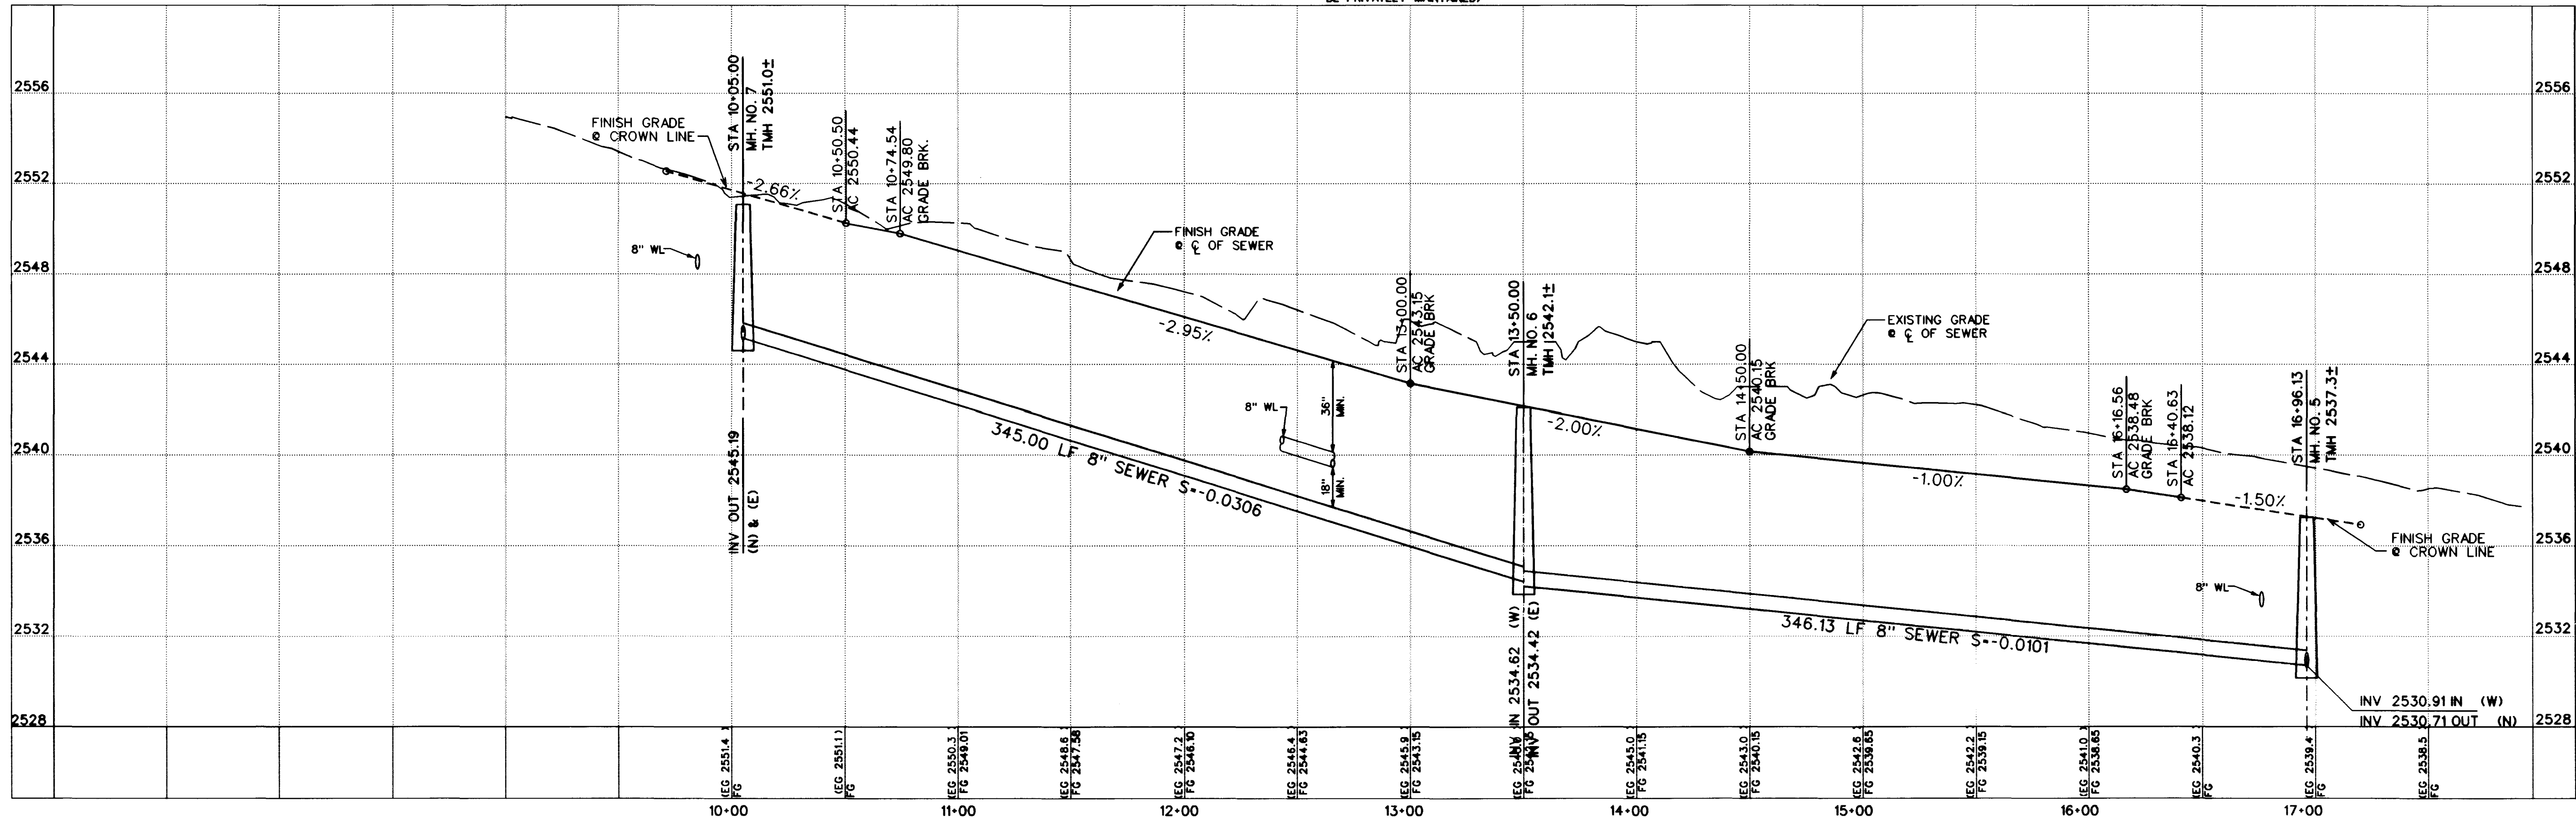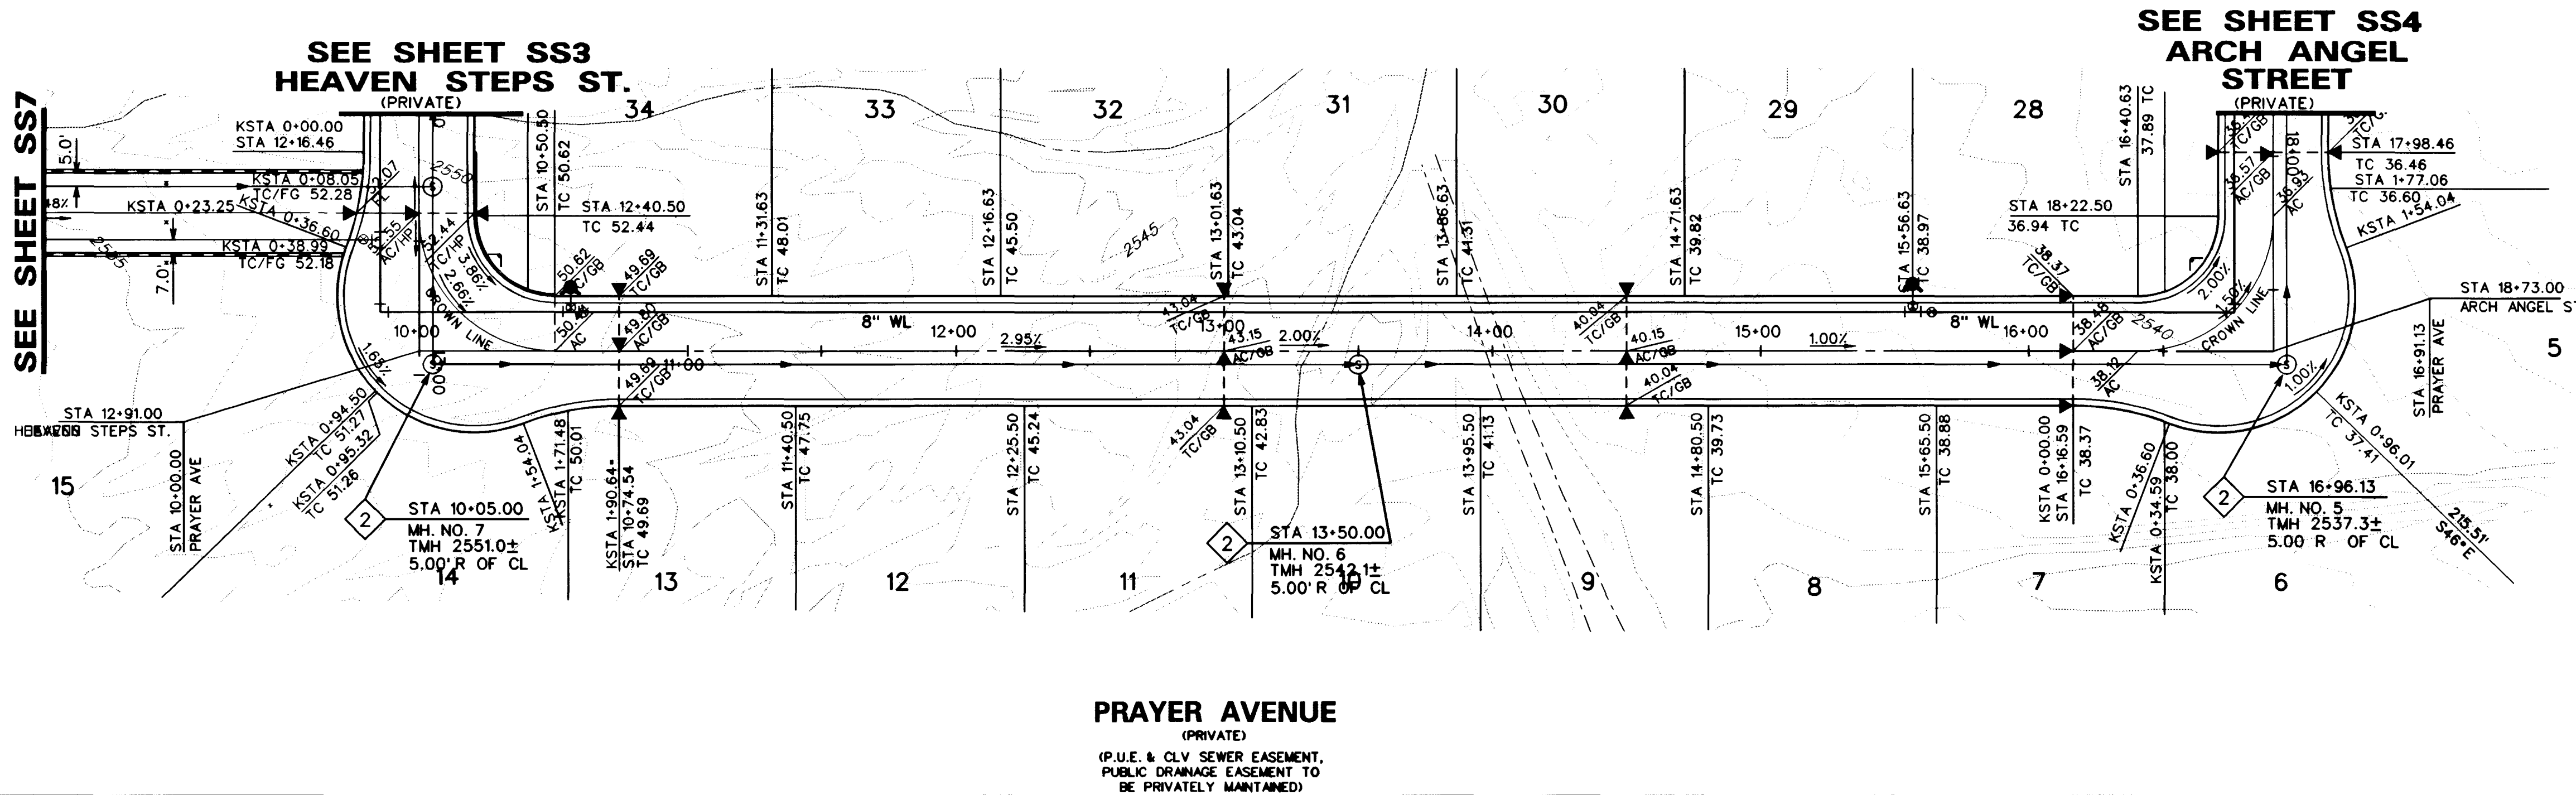

SHEET
PLAN AND PROFILE
PRAYER AVENUE
STA 10+05 TO 16+96.13

TITLE
MYSTIC VALLEY
PHASE I

DRAWN BY:
G. HOWELL, W. KIM

DESIGNED BY:
E. SERRANO, M. BELEN

CHECKED BY:
J. W. LELAND


PROJECT NO:
98-9031-03

DATE:
11/4/98

DATE:
11/4/98


DATE:
4/26/99

SCALE: 1"=40' HORIZ.
1"=4' VERT.

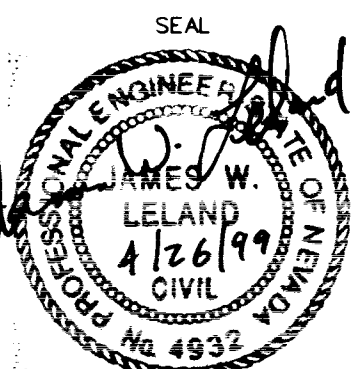

SHEET
SS6
16 OF 18 SHEETS
DRAWING NO.
1074-4599-1

RICHMOND AMERICAN HOMES OF NEVADA
INC.
7250 WEST PEAK, STE. 212
LAS VEGAS, NV 89128
(702) 240-8400

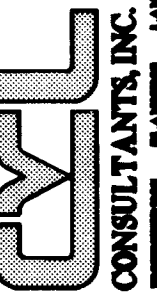

6280 S. Valley View Blvd.
Suite 200
Las Vegas, NV 89118
Tel: (702) 368-3008
Fax: (702) 368-0047

