



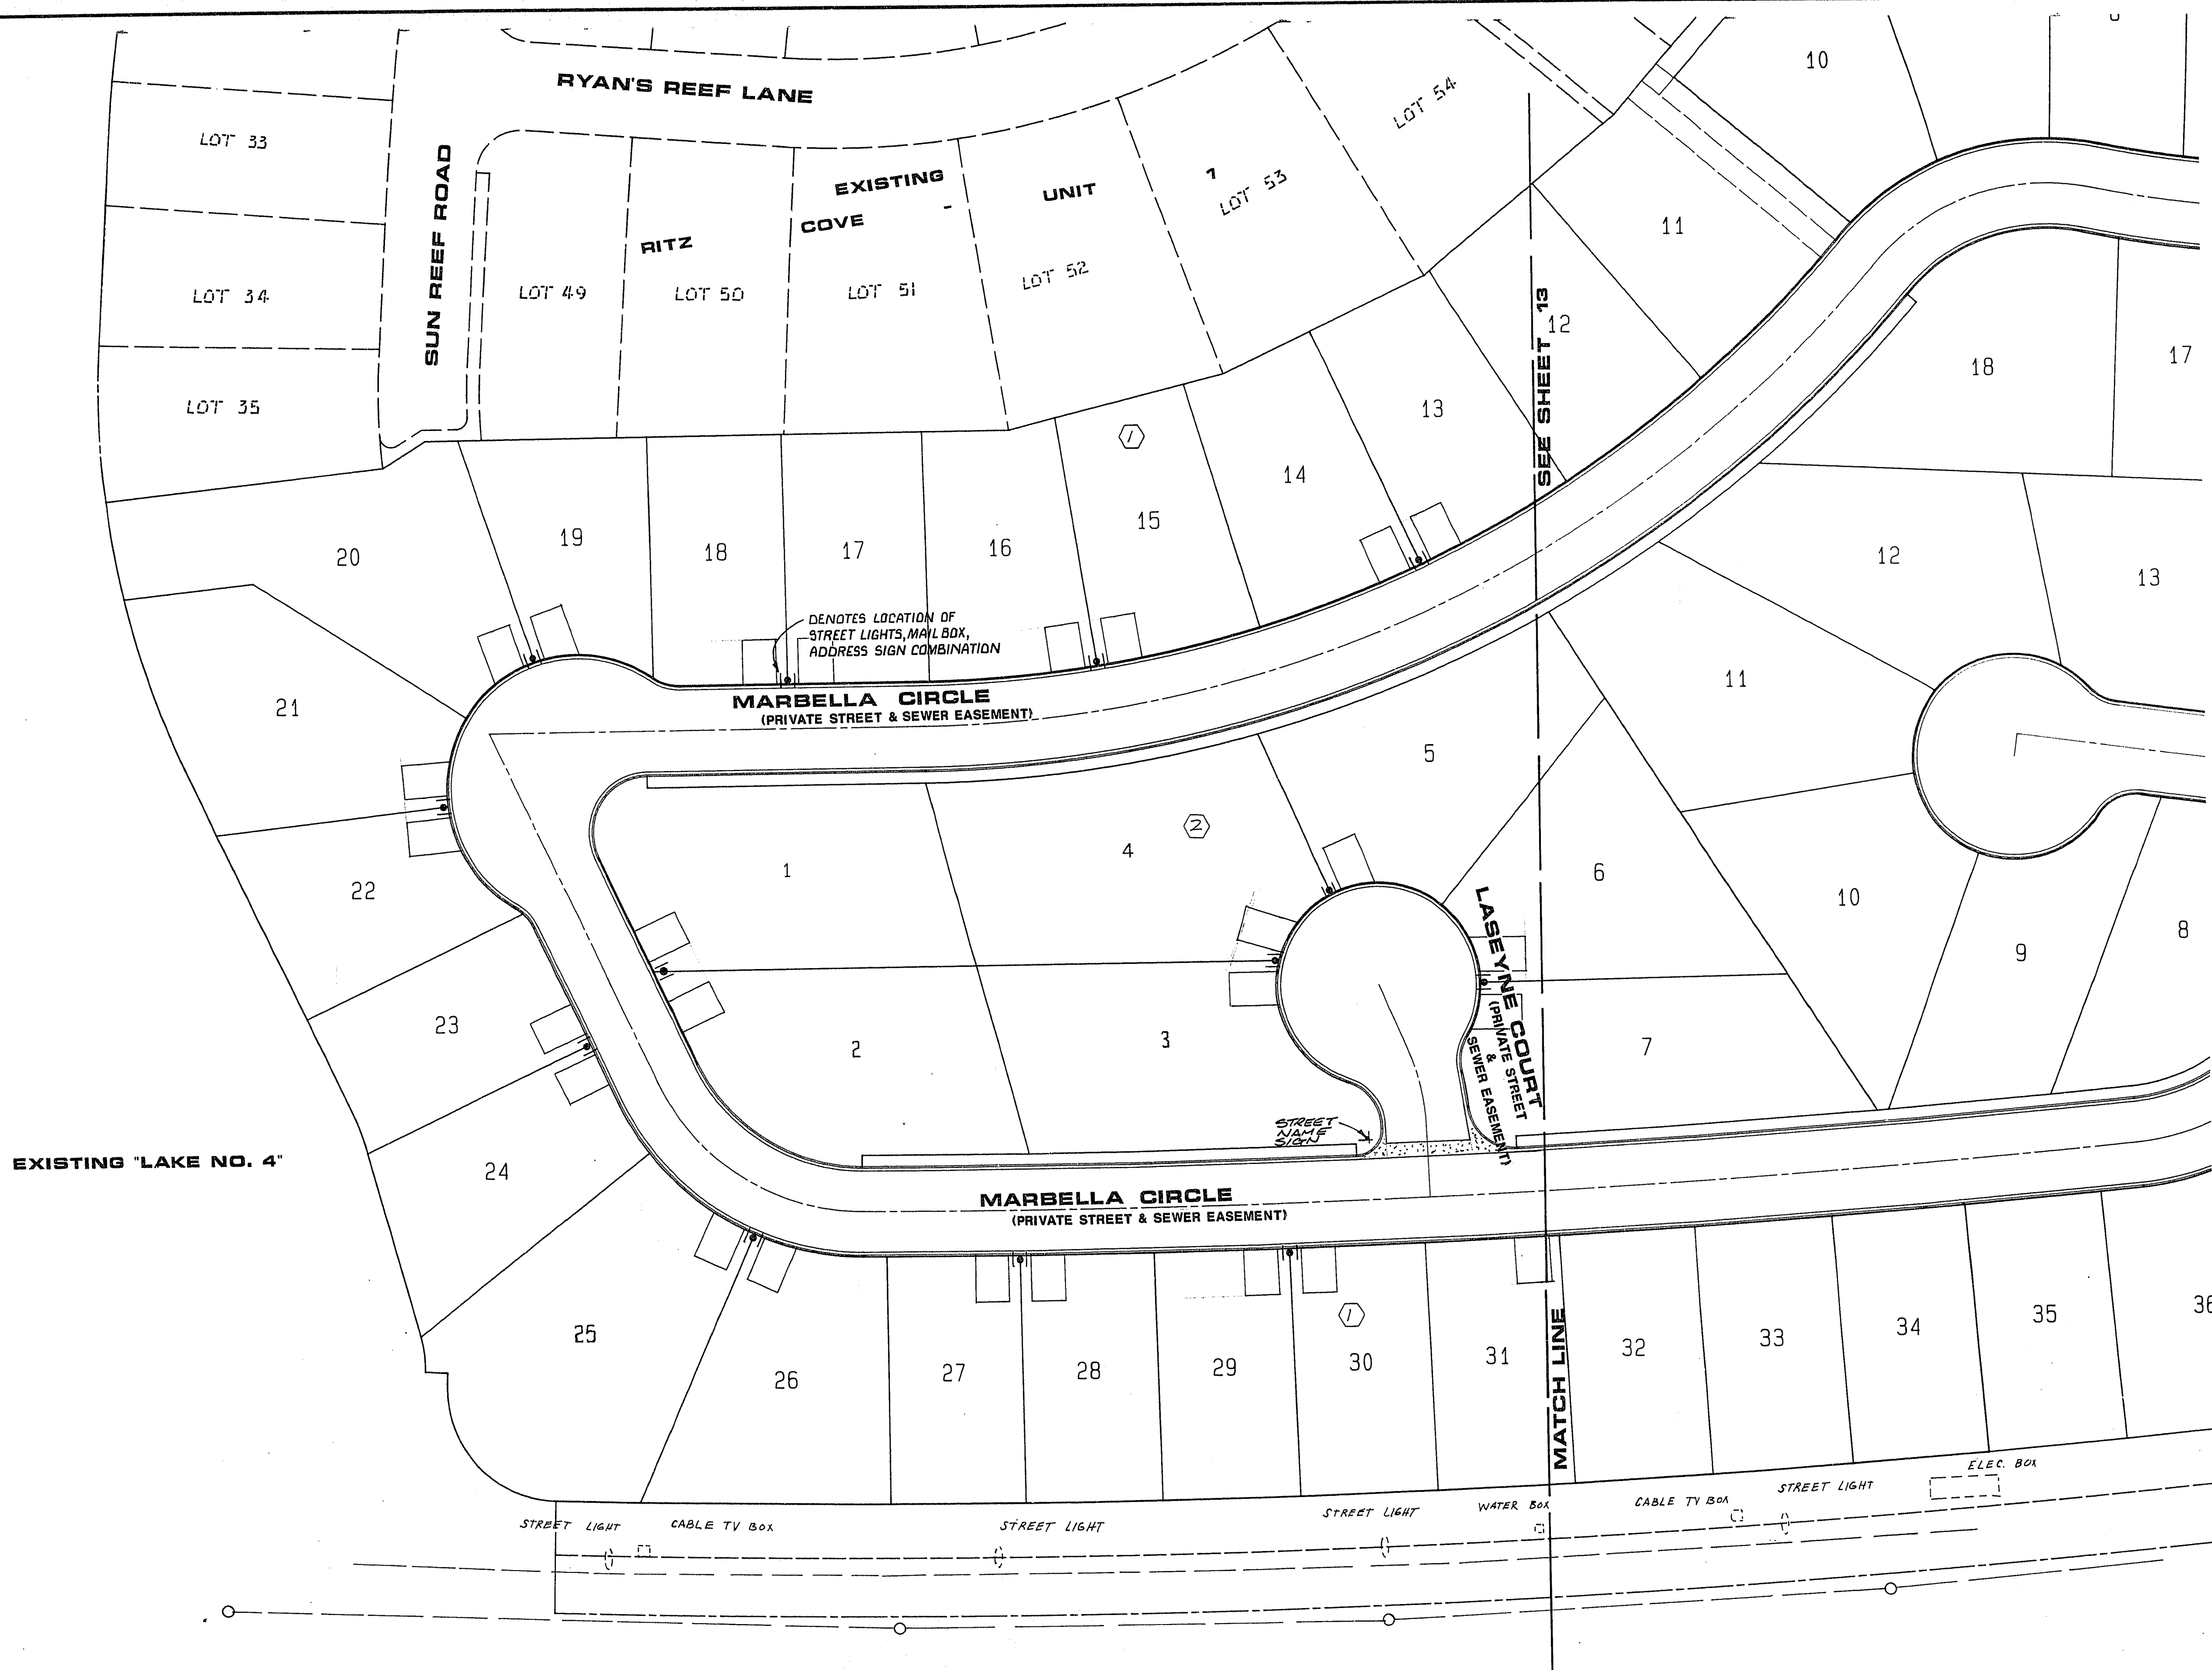

SCALE 1"=40'

Call before you Dig.
1-800-227-2600
UNDERGROUND SERVICE JUSA

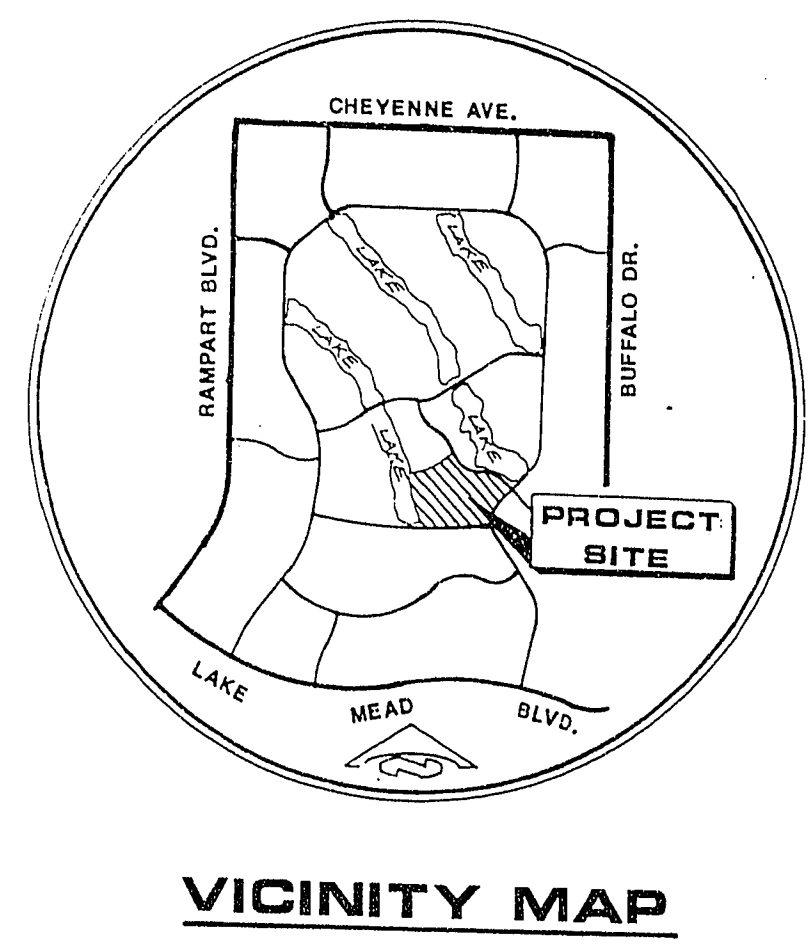

STREET LIGHT NOTE
ISLAND LIGHTING SHALL BE PER LANDSCAPING PLANS (TYP.)

BASIS OF BEARING

SOUTH 88°42'53" EAST, BEING THE BEARING OF THE NORTH LINE OF THE NORTHEAST QUARTER (NE 1/4) OF THE NORTHEAST QUARTER (NE 1/4) OF SECTION 16, TOWNSHIP 20 SOUTH, RANGE 60 EAST, M.D.M., AS SHOWN BY A MAP ON FILE IN THE OFFICE OF THE COUNTY RECORDER, CLARK COUNTY, NEVADA, AS PAGE 83 OF FILE 52 OF PARCEL MAPS.

PROJECT BENCHMARK

TOP OF CURB - WEST SIDE OF DURANGO DRIVE 250' SOUTH OF WESTCLIFF C.L.V. DATUM. ELEVATION = 2610.16

BENCHMARK

TOP OF B.L.M. BRASS CAP E 1/16, 9/16 ON CHEYENNE 1/4 MILE WEST OF BUFFALO. ELEVATION = 2386.62

NOTE:
EXISTING UTILITY LOCATIONS SHOWN HEREON ARE APPROXIMATE ONLY. IT SHALL BE THE CONTRACTOR'S RESPONSIBILITY TO DETERMINE THE EXACT VERTICAL AND HORIZONTAL LOCATION OF ALL EXISTING UNDERGROUND UTILITIES PRIOR TO COMMENCING CONSTRUCTION. NO REPRESENTATION IS MADE THAT ALL EXISTING UTILITIES ARE SHOWN HEREON. THE CONTRACTOR ASSUMES NO RESPONSIBILITY FOR UTILITIES NOT SHOWN ON UTILITIES NOT SHOWN IN THEIR PROPER LOCATION. CALL BEFORE YOU DIG. 1-800-227-2600.

REVISIONS		
NO.	DESCRIPTION/DATE	BY

Michael D. Higgins
7/19/89

SPARKS, NEVADA
LAS VEGAS, NEVADA
incorporated
SDI
ENGINEERS/PLANNERS

STREET LIGHTING PLAN
MEDITERRANEAN COVE AT DESERT SHORES
A PORTION OF THE E1/2 OF SECTION 16, T20S, R60E, MDM
LAS VEGAS

JOB NO. 2-487-071
DESIGNED GEK
DRAWN
COMP.
CHECKED
DATE FEBRUARY 1989

12
12 OF 13 SHEETS
2074-4055