


Avoid cutting underground utility lines. It's costly.
Call before you Dig
1-800-227-2600

Avoid cutting underground utility lines. It's costly.
Call before you Overhead
1-702-593-6111

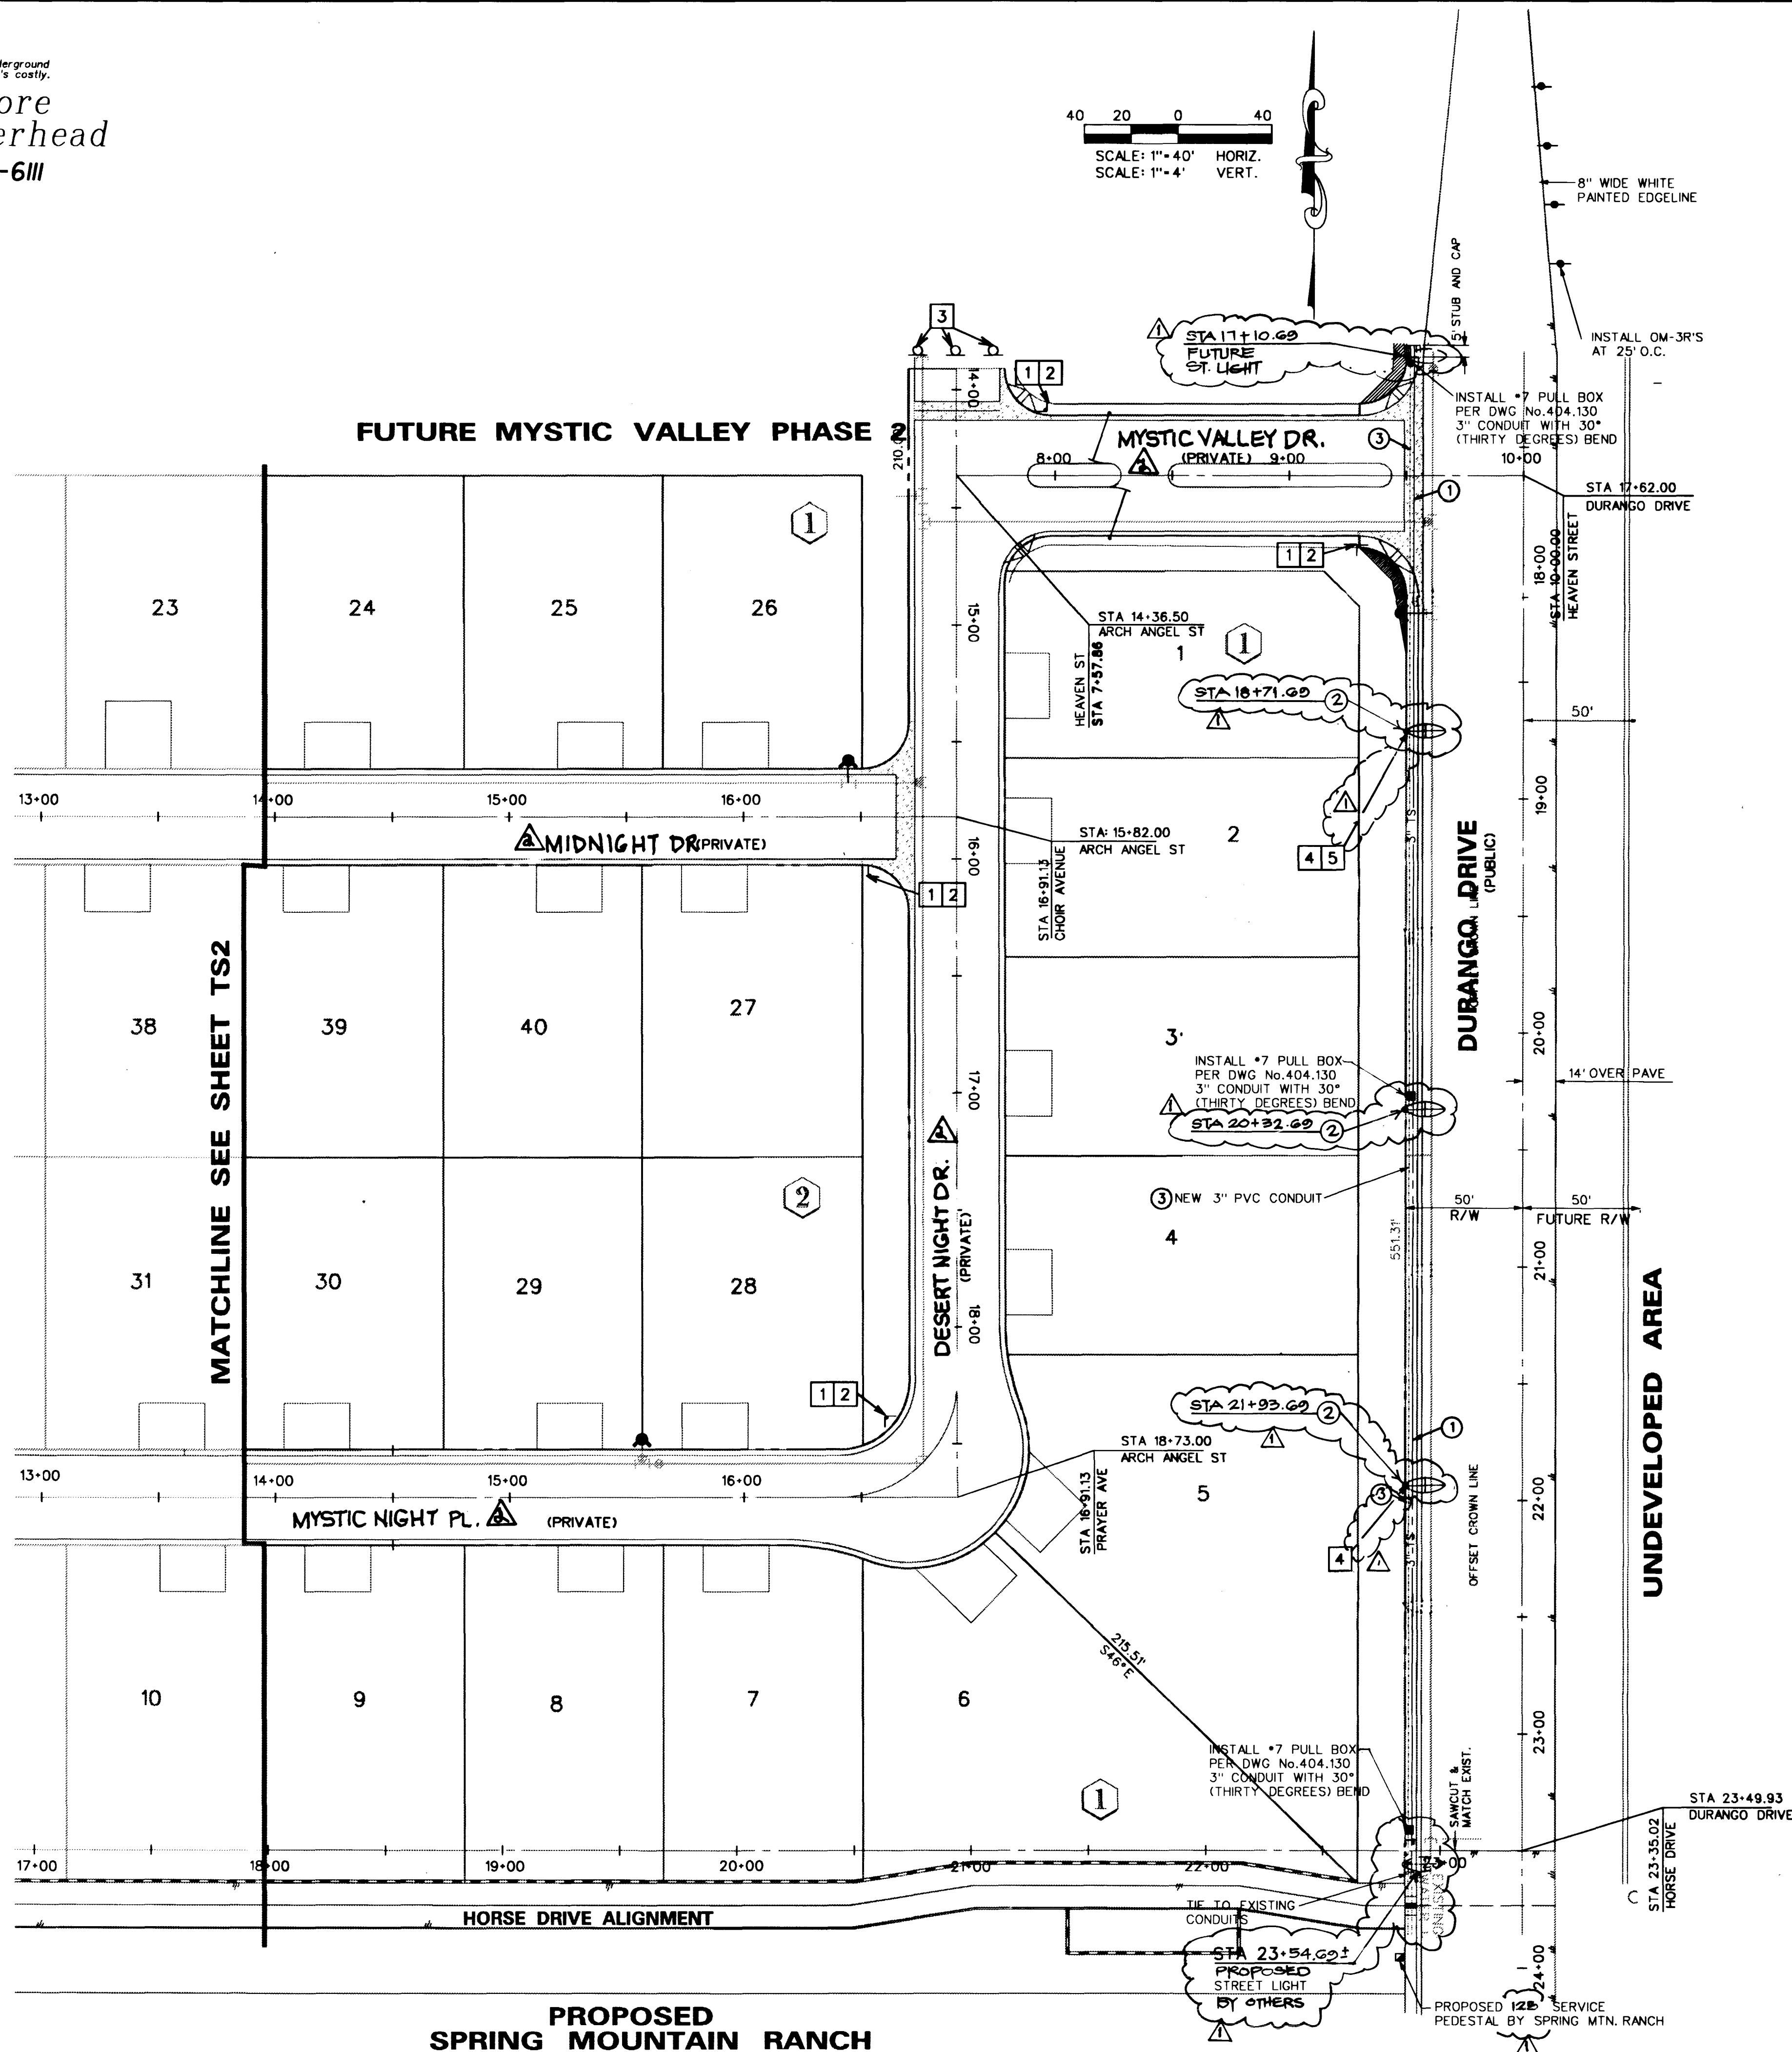


BASIS OF BEARING

NORTH 0015°13' EAST, BEING THE BEARING OF THE EAST LINE OF THE NORTHEAST QUARTER (NE 1/4) OF THE NORTHEAST QUARTER (NE 1/4) OF THE NORTHEAST QUARTER (NE 1/4) OF SECTION 8, TOWNSHIP 19 SOUTH, RANGE 60 EAST, M.D.M. CLARK COUNTY, NEVADA AS SHOWN ON THE MAP IN FILE 87, OF SURVEYS, PAGE 83, OFFICIAL RECORDS OF CLARK COUNTY, NEVADA.

BENCHMARK

C.L.V. BENCHMARK: 1LV90-BNES
BLW BRASS CAP AT THE INTERSECTION OF DURANGO DRIVE AND IRON MOUNTAIN ROAD
NAVD 1988 ELEV 771.9689 METERS (2532.70 FEET)

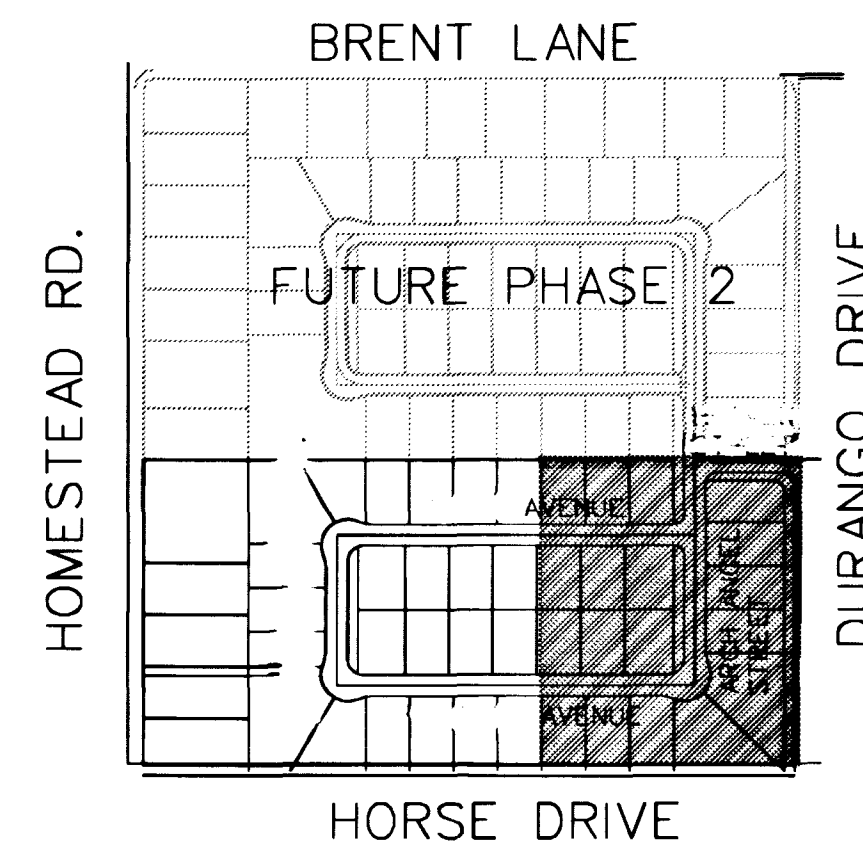

LOCATION MAP

NTS


STREETLIGHTING NOTES

1. INSTALL 2" PVC STREETLIGHT CONDUIT
2. INSTALL 250 WATT HPS LUMINAIRE
3. INSTALL 3" PVC CONDUIT WITH PULL STRINGS WITH 30° BENDS INTO #7 PULLBOXES FOR FUTURE TRAFFIC SIGNAL INTERCONNECT

STREET SIGNAGE NOTES

1. INSTALL 24" x 24" R1-1 STOP SIGN
2. INSTALL STREET NAME SIGN 6"
3. INSTALL END OF ROAD MARKERS
4. INSTALL R8-3A NO PARKING SIGN
5. INSTALL R2-1 (35 MPH) SIGN

STREET LIGHT NOTE:
ALL HAND HOLE COVERS MUST BE INSTALLED, POLE CAPS POURED, AND PULL BOX LIDS BOLTED DOWN PRIOR TO ENERGIZING CIRCUIT. ALL WIRE MUST HAVE THW INSULATION.

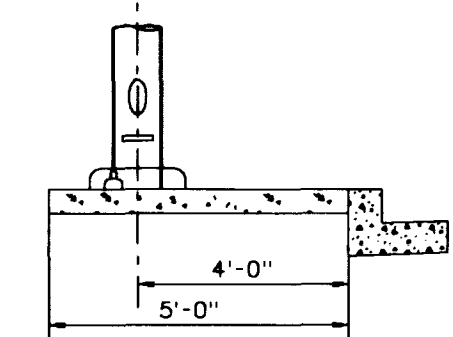


STREET LIGHT LOCATION
N.T.S. (PUBLIC STREETS)

RICHMOND AMERICAN HOMES OF NEVADA INC.
7200 WEST PEAK STE. 212
LAS VEGAS, NV 89128
(702) 400-8800


SHEET
SIGNAGE, STRIPING AND STREETLIGHTING PLAN (EAST HALF)
MYSTIC VALLEY PHASE 1

TITLE
DRAWN BY: G. HOWELL, W. KIM 11/4/98
DESIGNED BY: E. SERRANO, M. BELEN 11/4/98
CHECKED BY: M. SEEBECK
PROJECT NO: 98-9031-03
SCALE: 1"=40' HORIZ.

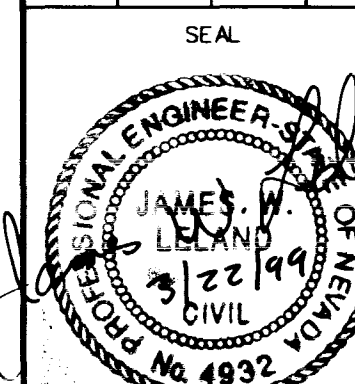

SHEET
TS1
9 OF 18 SHEETS
DRAWING NO.
207 Y-4599-1

**Call before
you Overhead**
1-800-333-0000

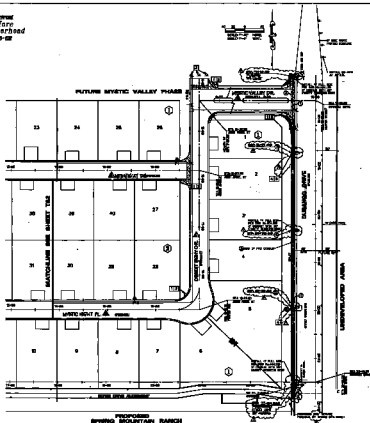

THESE COURSES WILL BE HELD IN THE AUDITORIUM OF THE UNIVERSITY OF ALABAMA. THE COST OF THE COURSES IS \$100.00. THE COURSES WILL BE HELD IN THE AUDITORIUM OF THE UNIVERSITY OF ALABAMA. THE COST OF THE COURSES IS \$100.00.

157-158



- THREE-POINTING ROUTINE**
- ① SERIAL # FIVE WHEELS/LIGHT CORNER
 - ② SERIAL SW SET ITS HANDLE
 - ③ SERIAL 7 AND 8 TO THE END OF THE RANGE

- ① WALL, 10' x 10' x 12" CONCRETE
- ② WALL, 10' x 10' x 12" CONCRETE
- ③ WALL, 10' x 10' x 12" CONCRETE
- ④ WALL, 10' x 10' x 12" CONCRETE
- ⑤ WALL, 10' x 10' x 12" CONCRETE

